


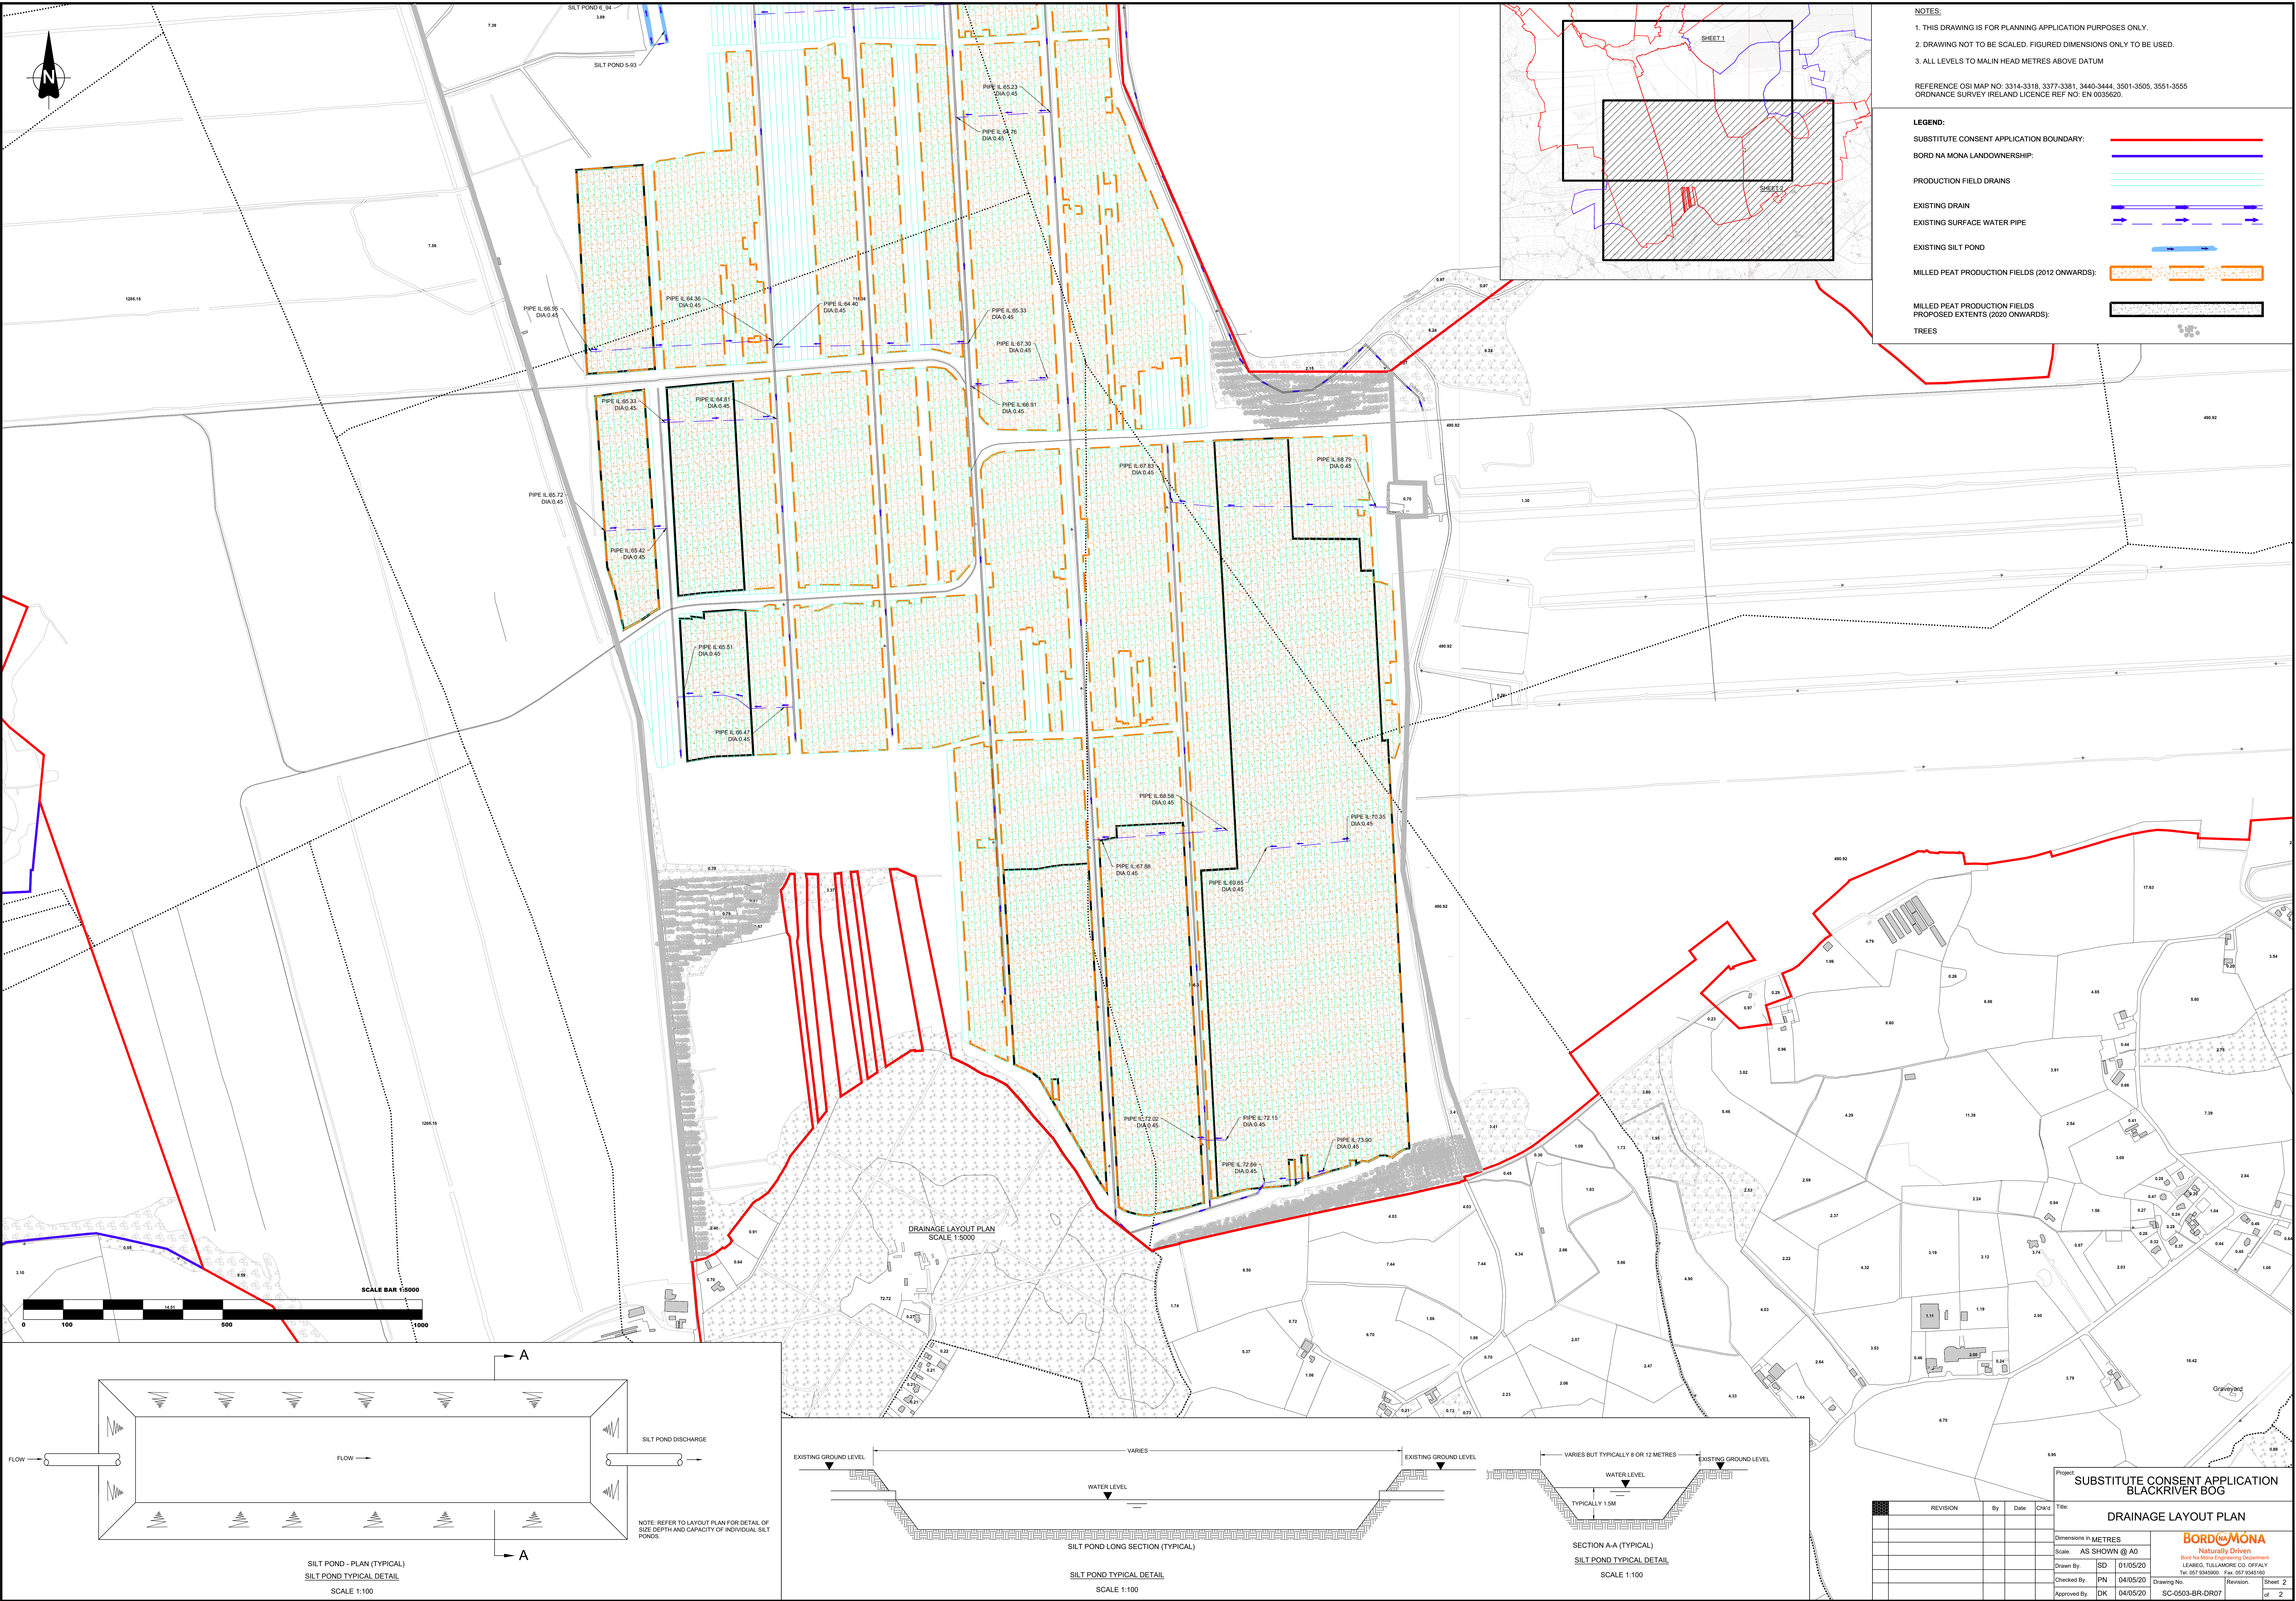

NOTES:
1. THIS DRAWING IS FOR PLANNING APPLICATION PURPOSES ONLY.
2. DRAWING NOT TO BE SCALED. FIGURED DIMENSIONS ONLY TO BE USED.
3. ALL LEVELS TO MALIN HEAD METRES ABOVE DATUM

REFERENCE OSI MAP NO: 3314-3318, 3377-3381, 3440-3444, 3501-3505, 3551-3555
ORDNANCE SURVEY IRELAND LICENCE REF NO: EN 0035620.

LEGEND:

SUBSTITUTE CONSENT APPLICATION BOUNDARY:

BORD NA MONA LANDOWNERSHIP:

PRODUCTION FIELD DRAINS:

EXISTING DRAIN:





EXISTING SURFACE WATER PIPE:

EXISTING SILT POND:

MILLED PEAT PRODUCTION FIELDS (2012 ONWARDS):

MILLED PEAT PRODUCTION FIELDS PROPOSED EXTENTS (2020 ONWARDS):

TREES:

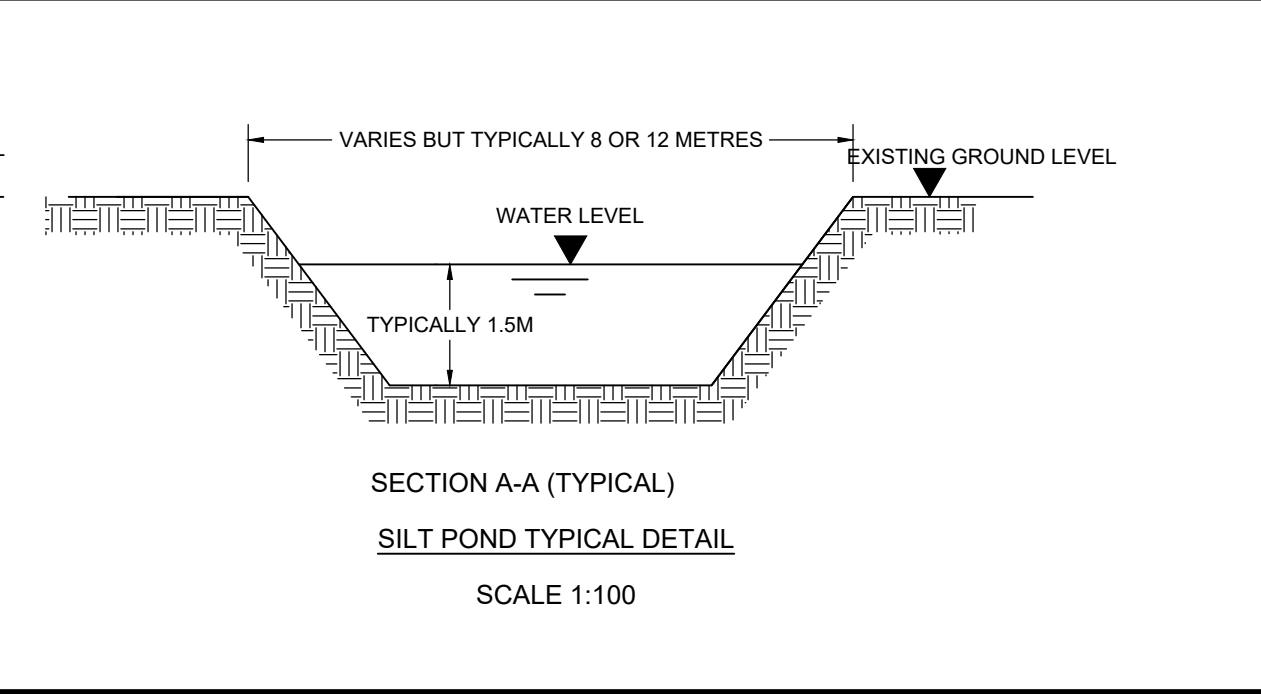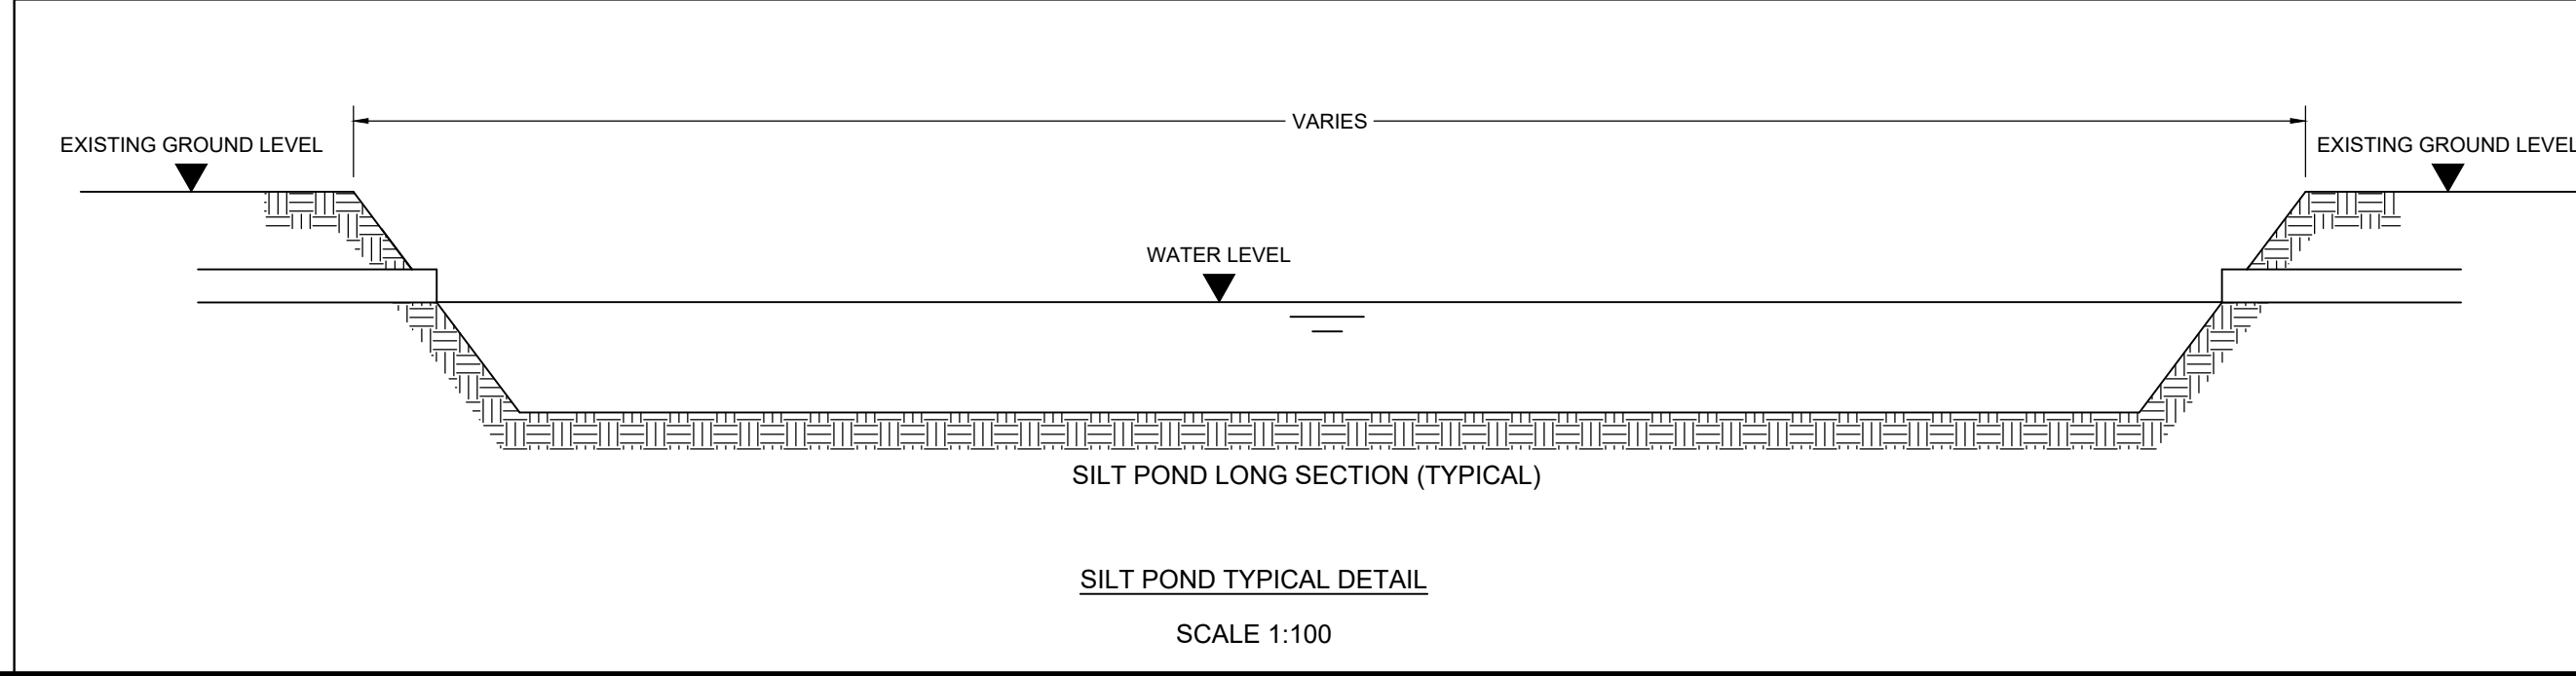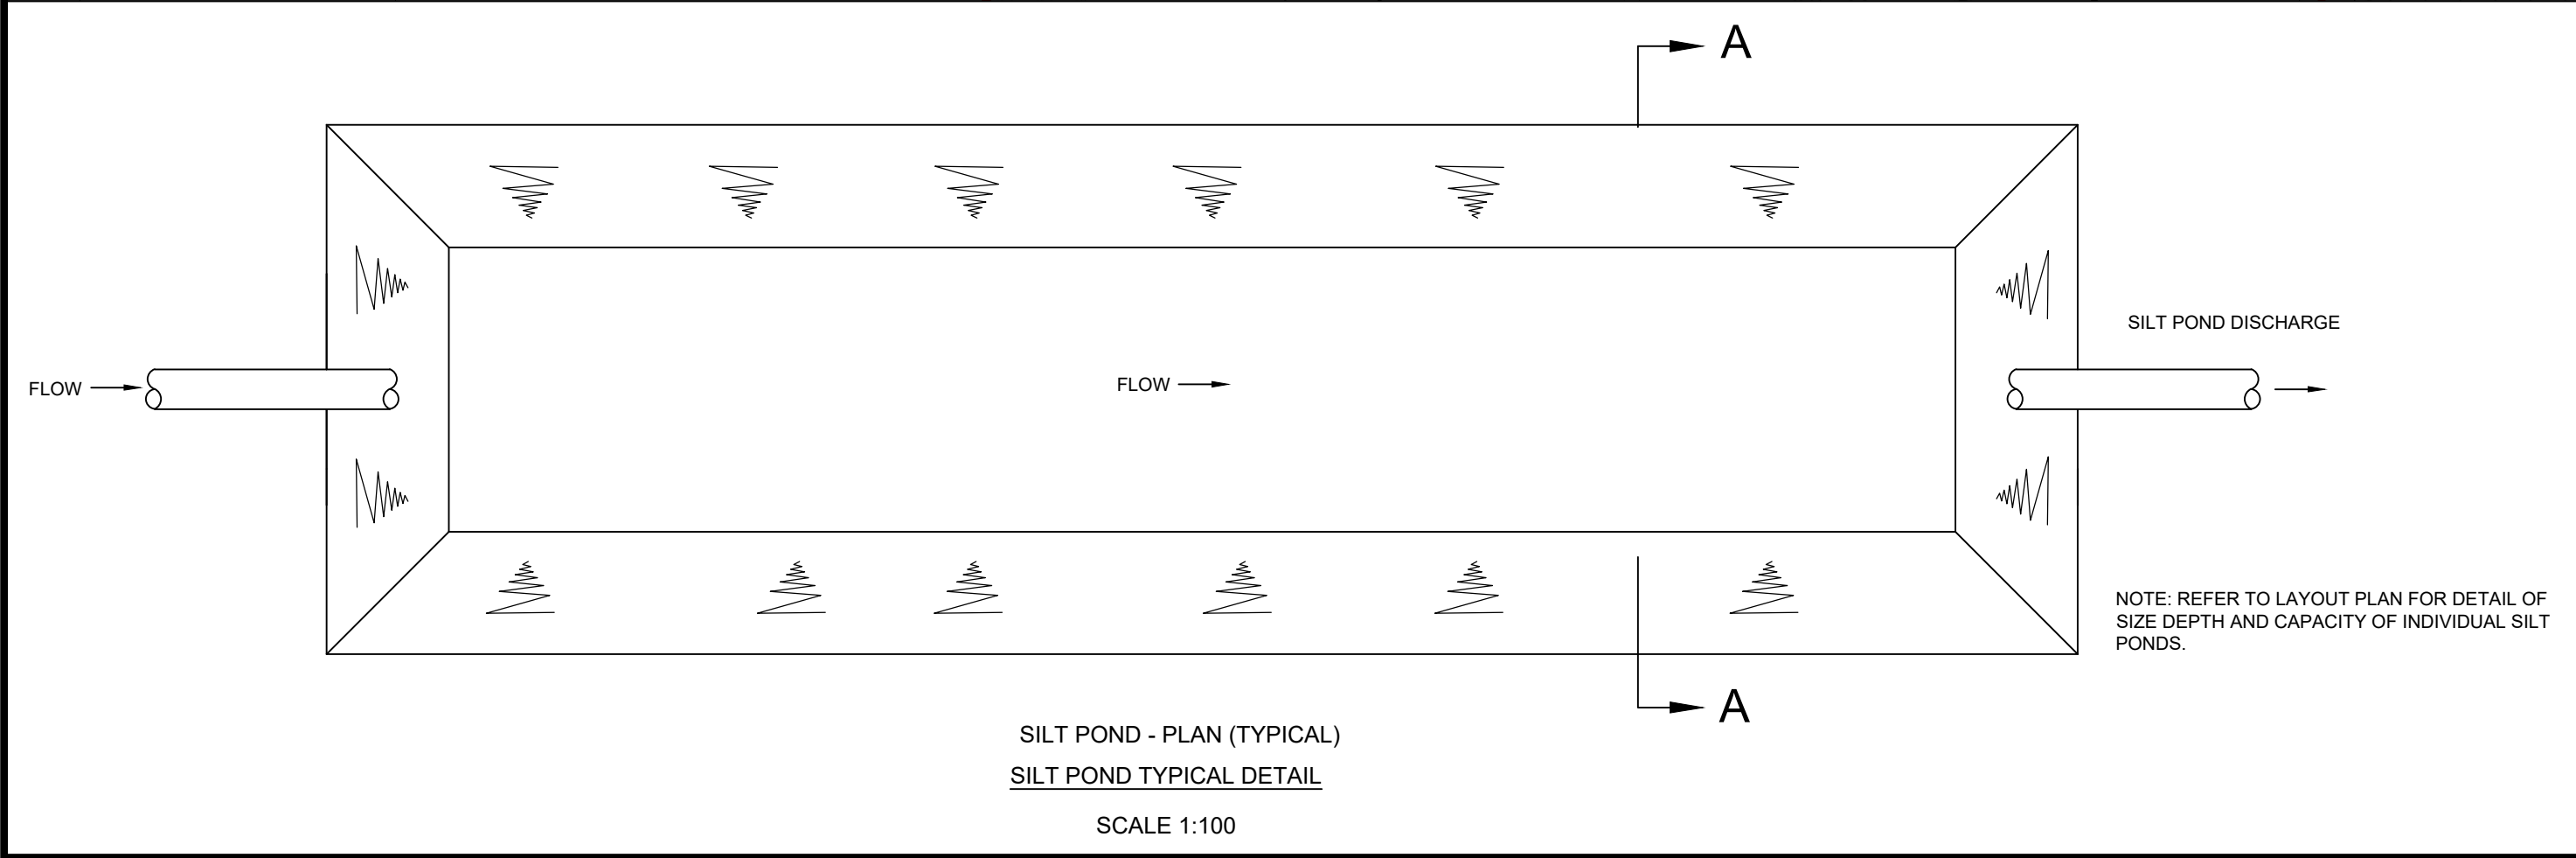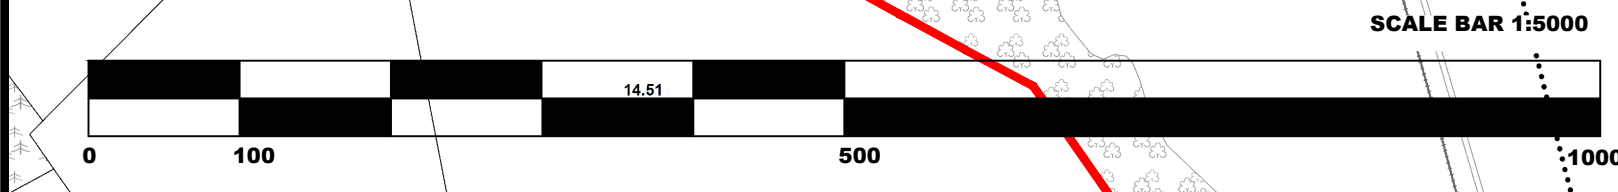

Project: **SUBSTITUTE CONSENT APPLICATION BLACKRIVER BOG**

DRAINAGE LAYOUT PLAN

REVISION	By	Date	Chk'd	Title

Dimensions in METRES
Scale: AS SHOWN @ A0

Drawn By: SD 01/05/20
Checked By: PN 04/05/20
Approved By: DK 04/05/20

BORD NA MONA
Naturally Driven
Best Na Mona Engineering Department
LEAMING, TULLAMORE CO. OFFALY
Tel: 087 9345000 Fax: 087 9345100

Revision: SC-0503-BR-DR07
Sheet: 2 of 2