


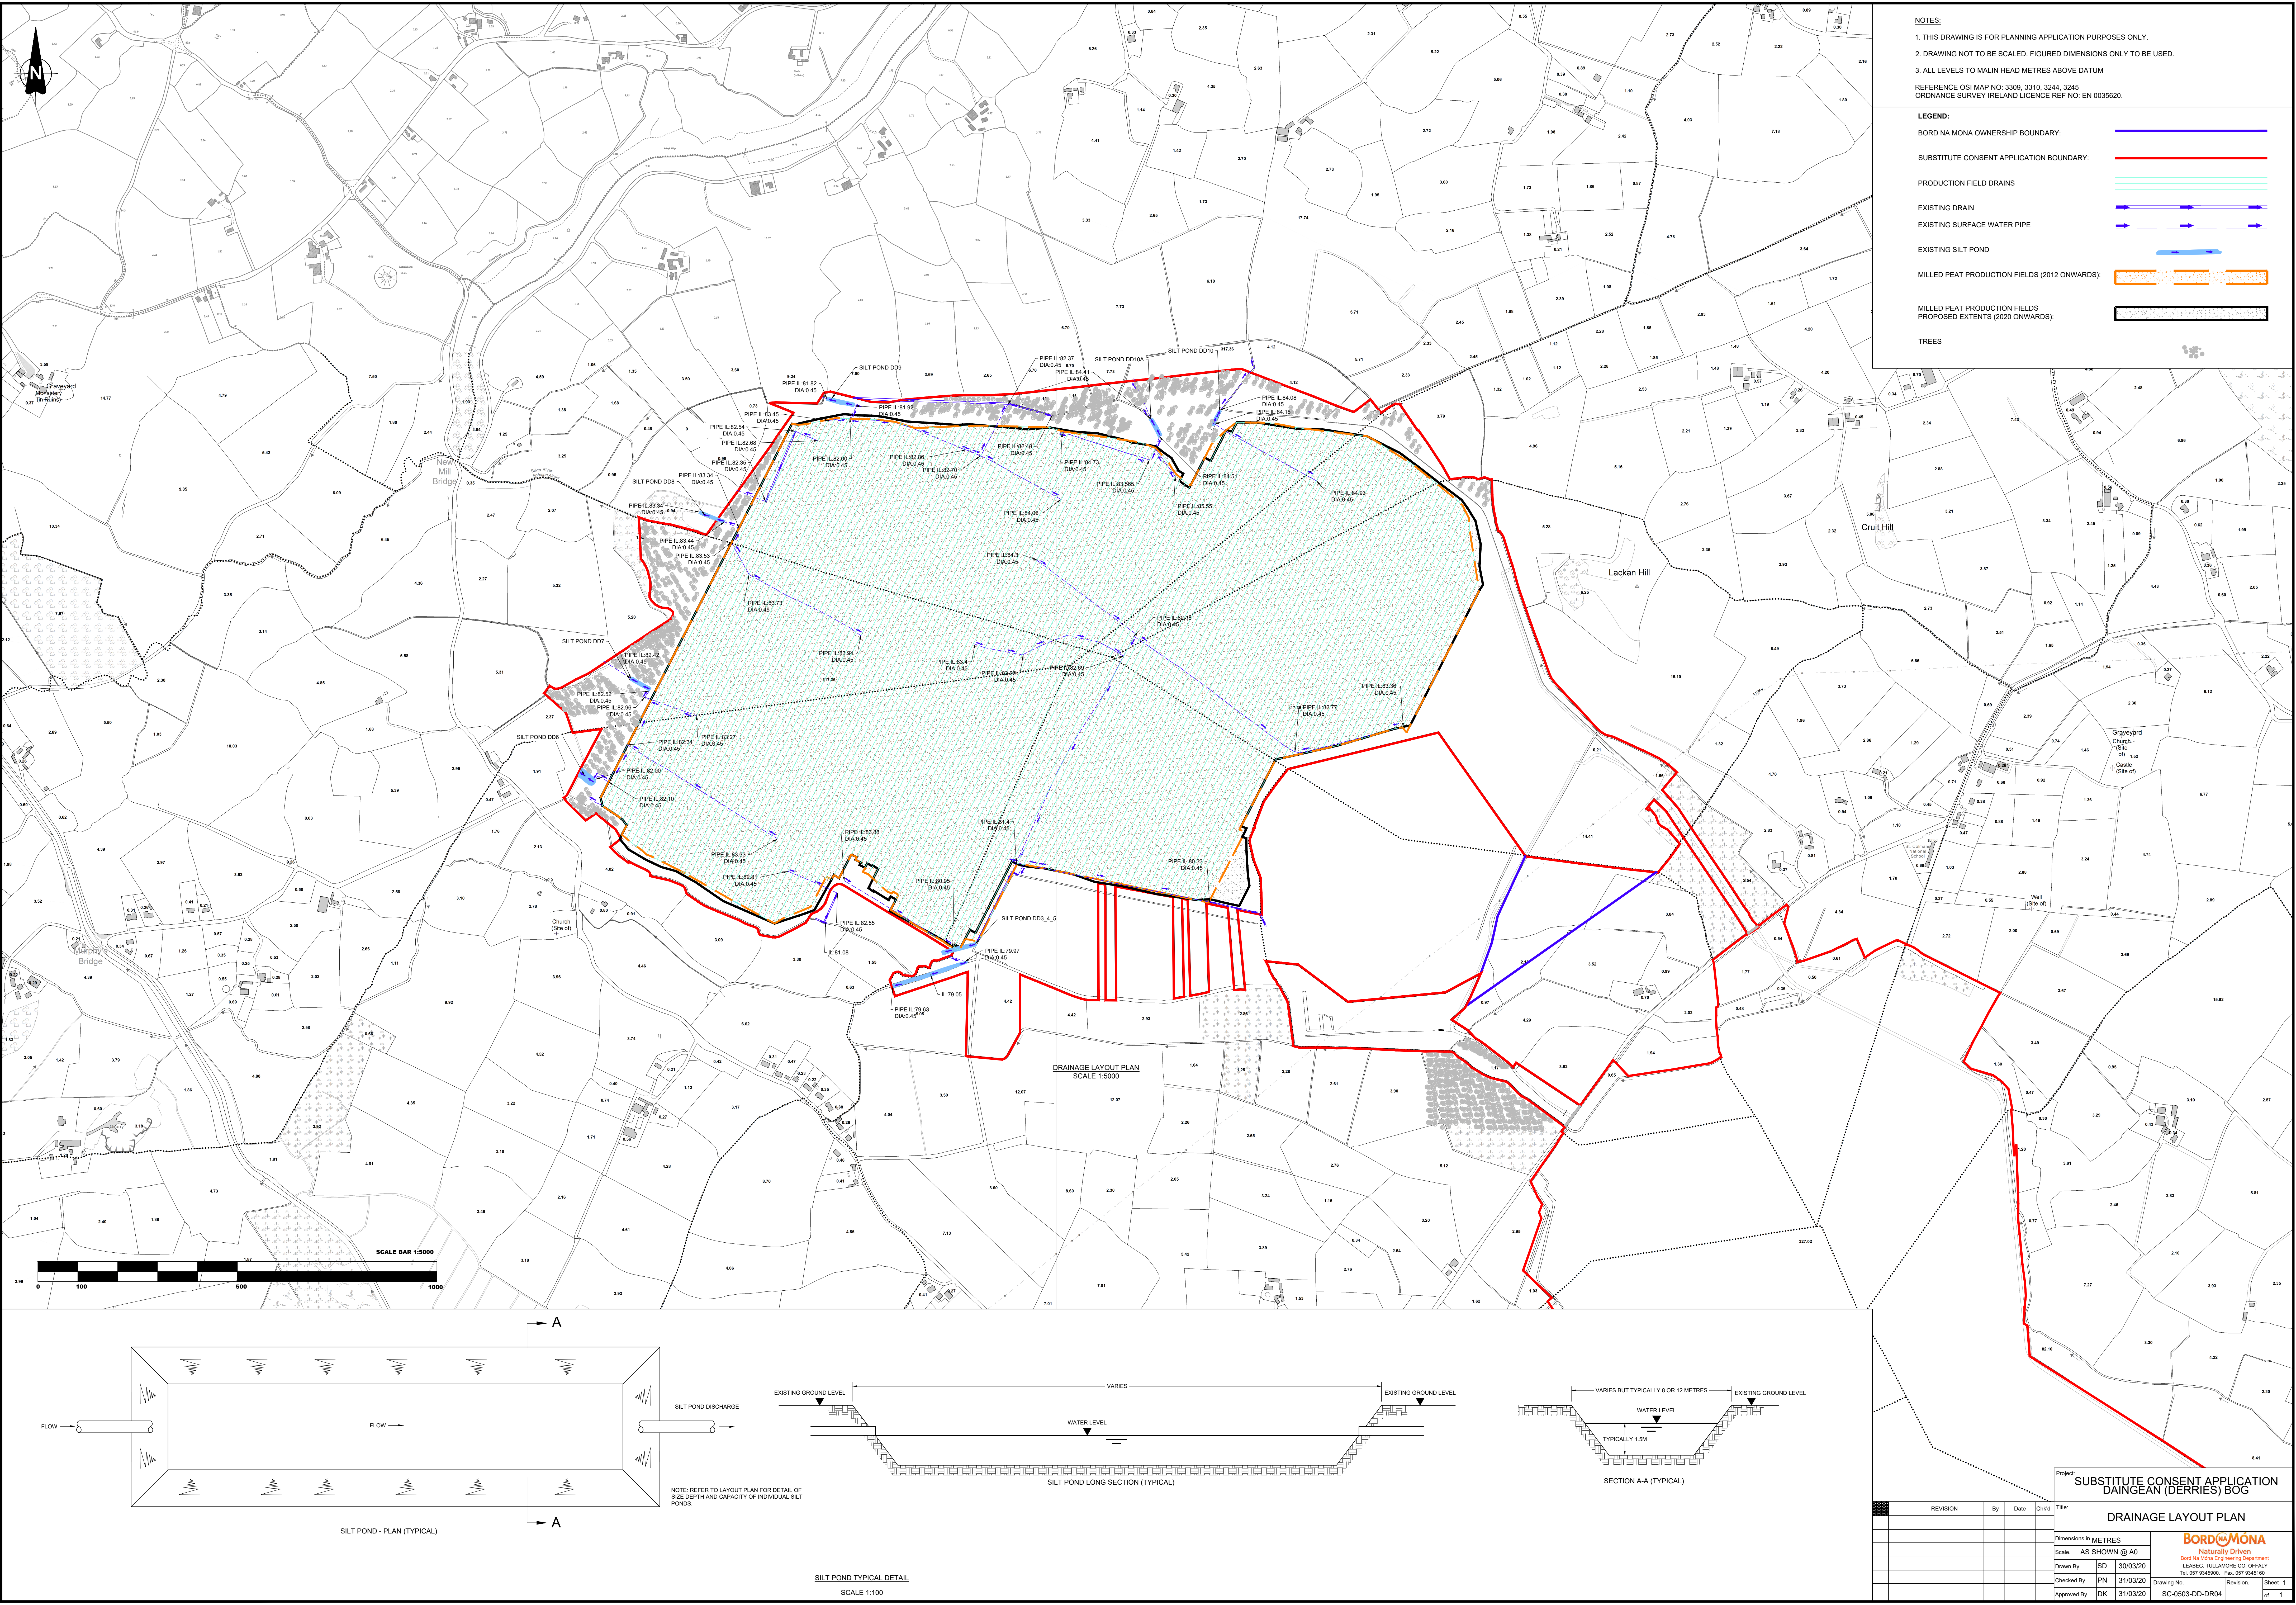

NOTES:

1. THIS DRAWING IS FOR PLANNING APPLICATION PURPOSES ONLY.

2. DRAWING NOT TO BE SCALED. FIGURED DIMENSIONS ONLY TO BE USED.

3. ALL LEVELS TO MALIN HEAD METRES ABOVE DATUM

REFERENCE OSI MAP NO. 3309, 3310, 3244, 3245

ORDNANCE SURVEY IRELAND LICENCE REF NO. EN 0035620.

LEGEND:

BORD NA MONA OWNERSHIP BOUNDARY:

SUBSTITUTE CONSENT APPLICATION BOUNDARY:

PRODUCTION FIELD DRAINS:

EXISTING DRAIN:

EXISTING SURFACE WATER PIPE:

EXISTING SILT POND:


MILLED PEAT PRODUCTION FIELDS (2012 ONWARDS):

MILLED PEAT PRODUCTION FIELDS PROPOSED EXTENTS (2020 ONWARDS):


TREES:

DRAINAGE LAYOUT PLAN


SCALE 1:5000

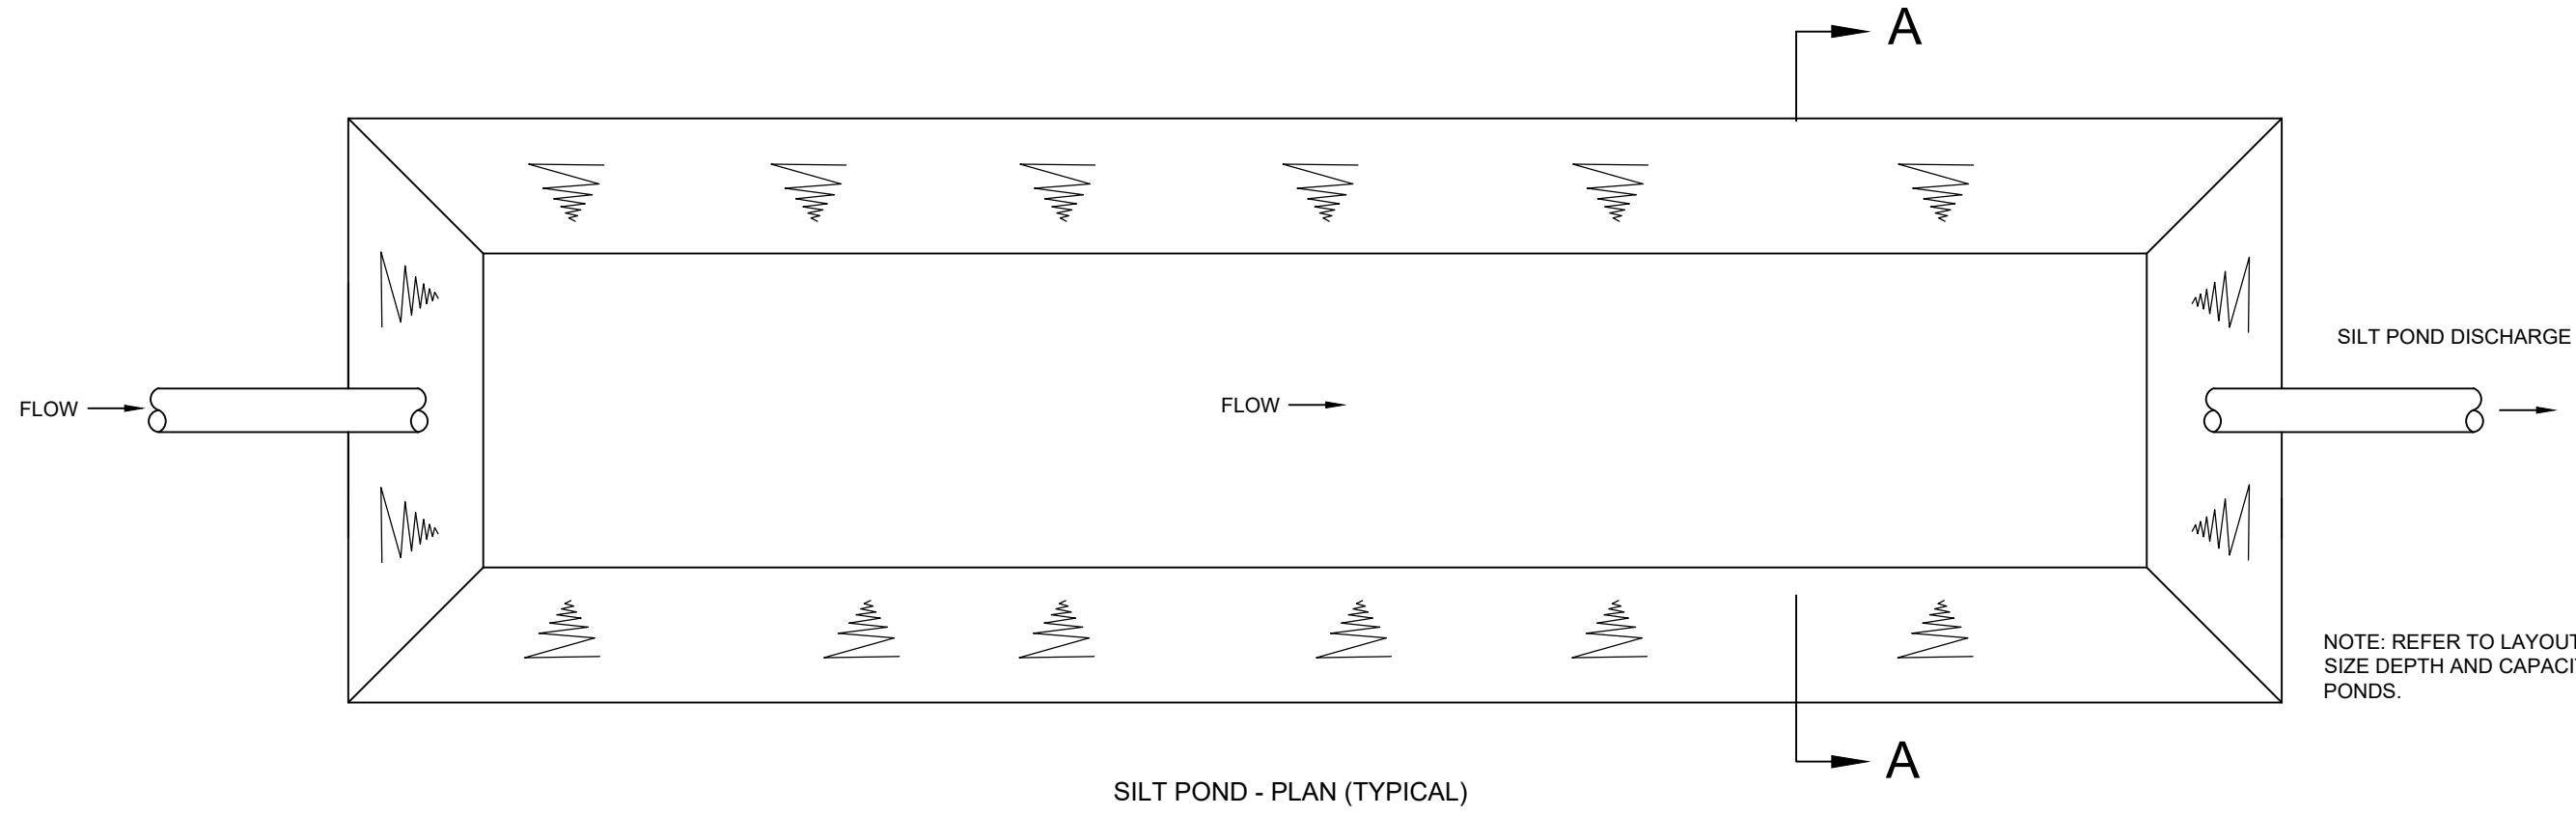

SILT POND - PLAN (TYPICAL)

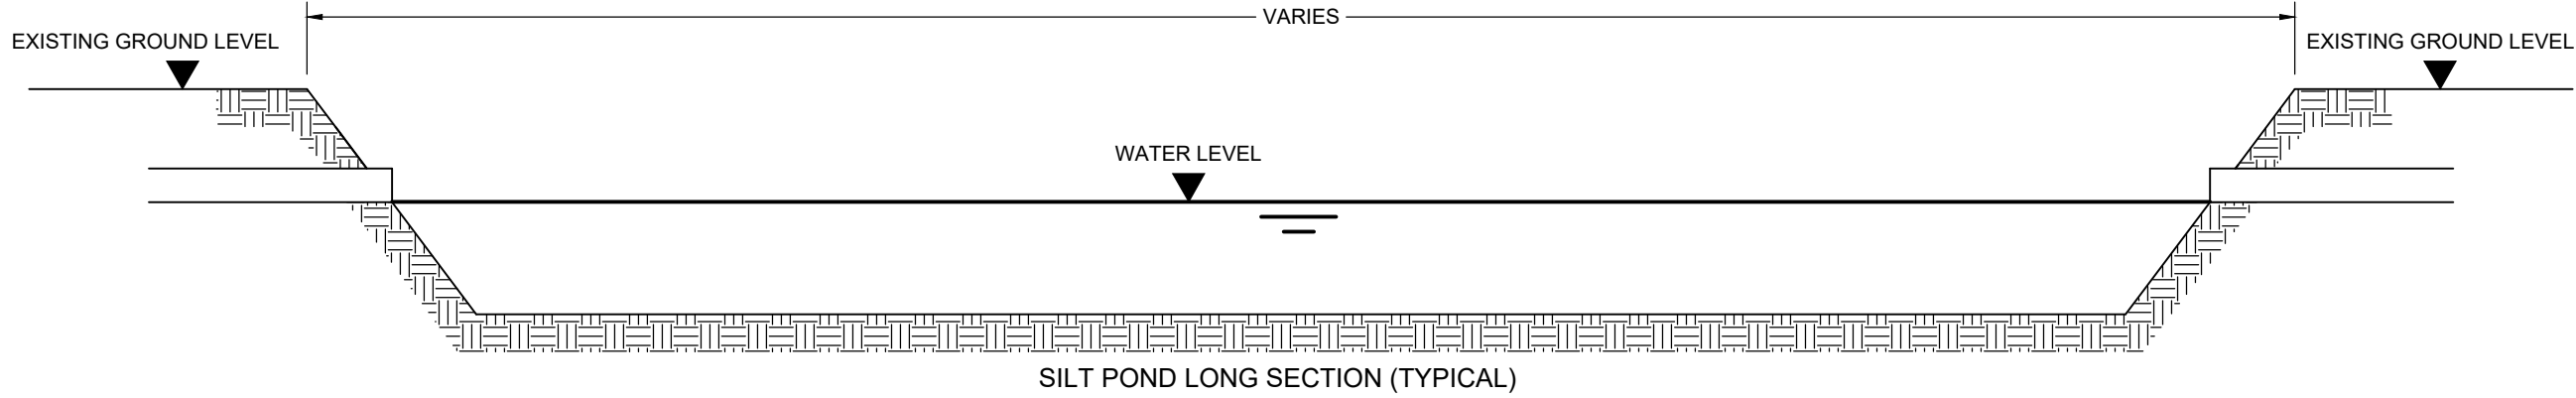

SILT POND LONG SECTION (TYPICAL)

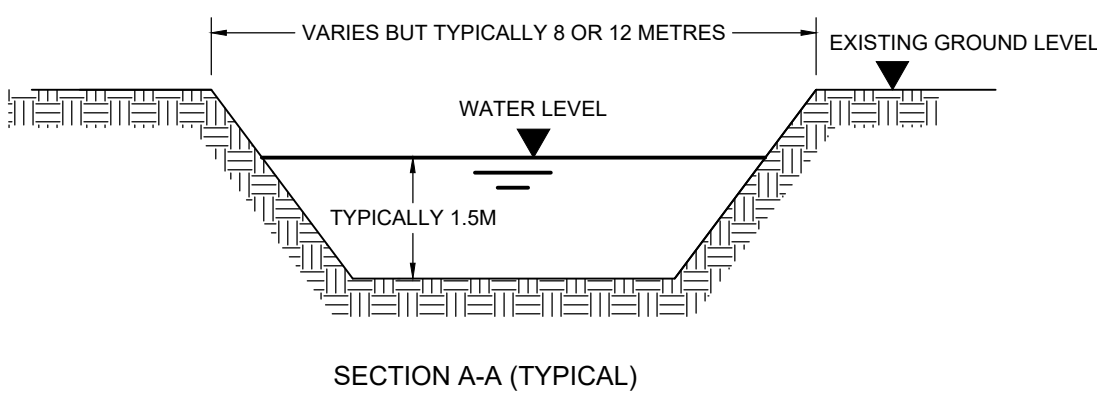

SECTION A-A (TYPICAL)

SILT POND TYPICAL DETAIL

SCALE 1:100

Project: **SUBSTITUTE CONSENT APPLICATION**
DANGEAN (DERRIS) BOG

REVISION	By	Date	Chw's	Title
				DRAINAGE LAYOUT PLAN
Dimensions in METRES				
Scale: AS SHOWN @ A0				
Drawn By: SD 30/03/20				
Checked By: PN 31/03/20				
Approved By: DK 31/03/20				
Drawing No: SC-0503-DD-DR04				
Revision: 1				
Sheet 1 of 1				

BORD NA MONA
Naturally Driven
East Na Monagh Engineering Department
LEAMING, TULLAMORE CO. OFFALY
Tel: 057 8345000 Fax: 057 8345100