


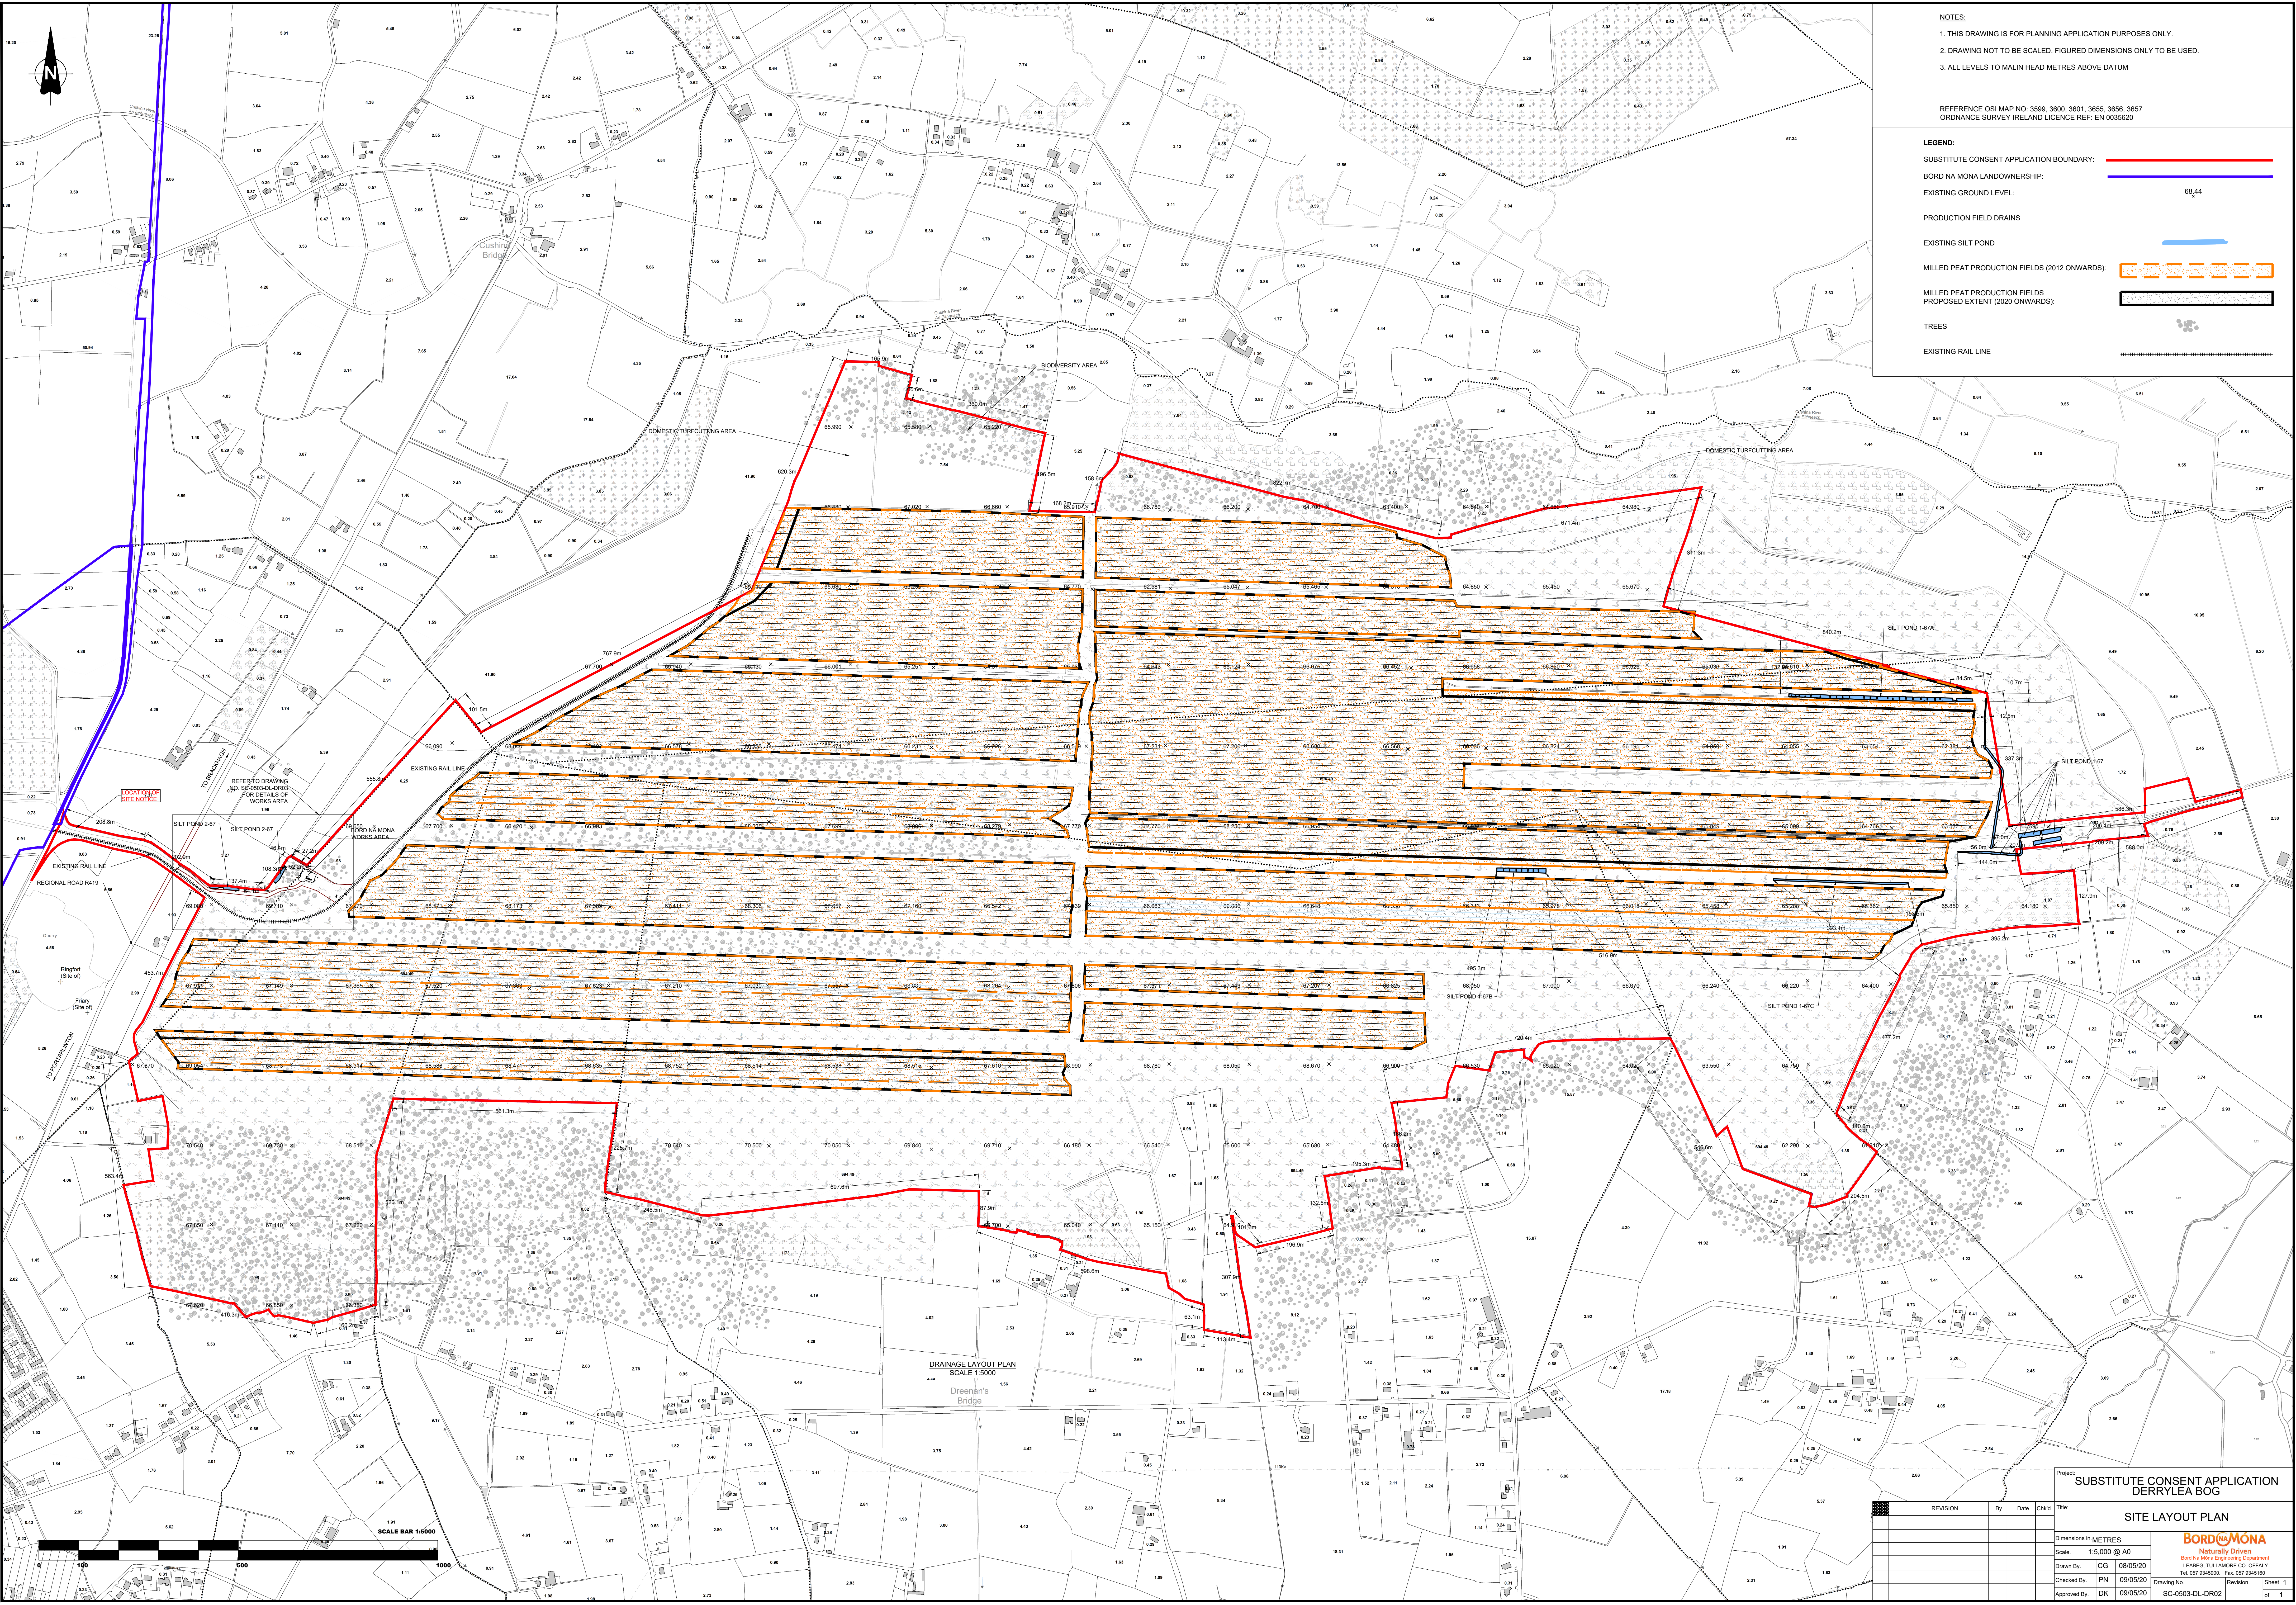

- NOTES:
1. THIS DRAWING IS FOR PLANNING APPLICATION PURPOSES ONLY.
 2. DRAWING NOT TO BE SCALED. FIGURED DIMENSIONS ONLY TO BE USED.
 3. ALL LEVELS TO MALIN HEAD METRES ABOVE DATUM

REFERENCE OSI MAP NO: 3599, 3600, 3601, 3655, 3656, 3657
ORDNANCE SURVEY IRELAND LICENCE REF: EN 003620

LEGEND:

SUBSTITUTE CONSENT APPLICATION BOUNDARY:

BORD NA MONA LANDOWNERSHIP:

EXISTING GROUND LEVEL: 68.44

PRODUCTION FIELD DRAINS:

EXISTING SILT POND:

MILLED PEAT PRODUCTION FIELDS (2012 ONWARDS):

MILLED PEAT PRODUCTION FIELDS PROPOSED EXTENT (2020 ONWARDS):

TREES:

EXISTING RAIL LINE:

DRAINAGE LAYOUT PLAN
SCALE 1:5000
Dreenan's Bridge

Project: SUBSTITUTE CONSENT APPLICATION
DERRYLEA BOG

SITE LAYOUT PLAN

REVISION	By	Date	Chkd	Titled

Dimensions in METRES	Scale: 1:5,000 @ A0
Drawn By: CG	08/05/20
Checked By: PN	09/05/20
Approved By: DK	09/05/20
SC-0503-DL-DR02	Sheet: 1 of 1

BORD NA MONA
Naturally Driven
Best in Mon Engineering Department
LEAMING: TULLAMORE CO. OFFICE
Tel: 027 9345000 Fax: 027 9345100