
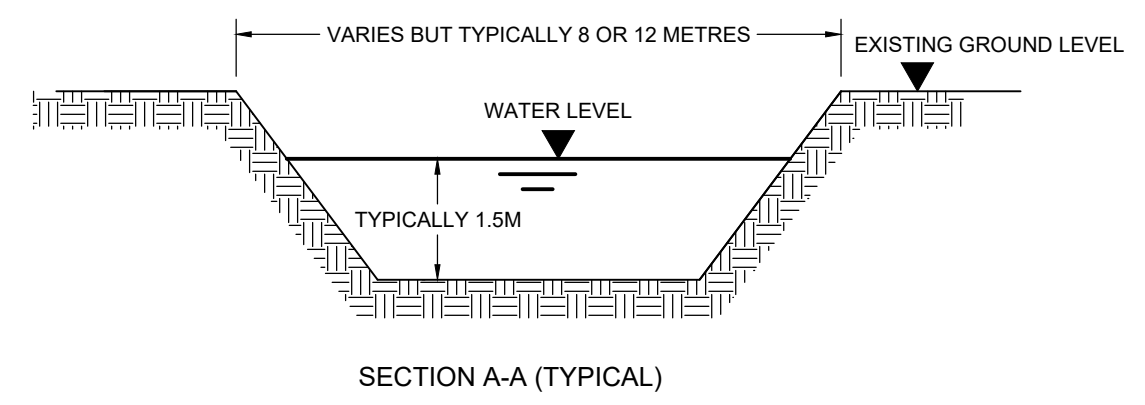
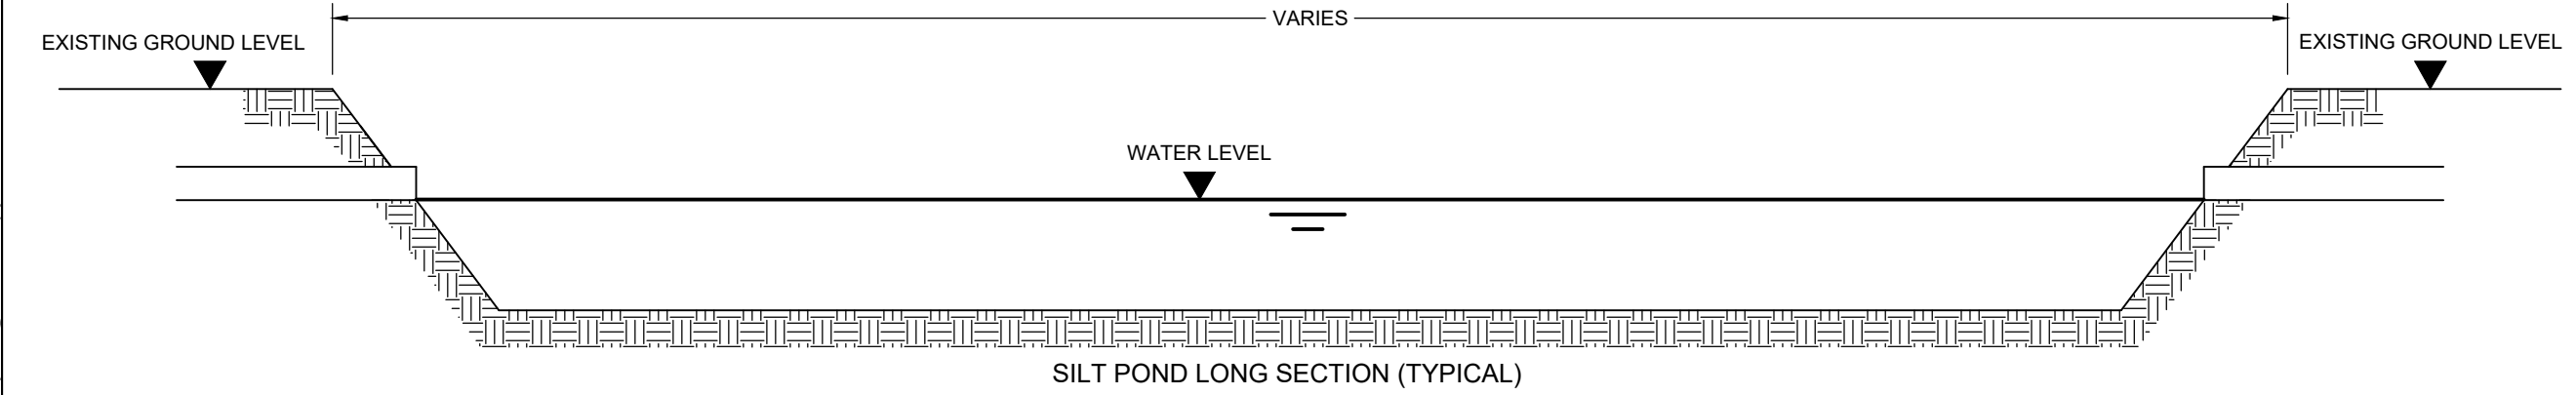


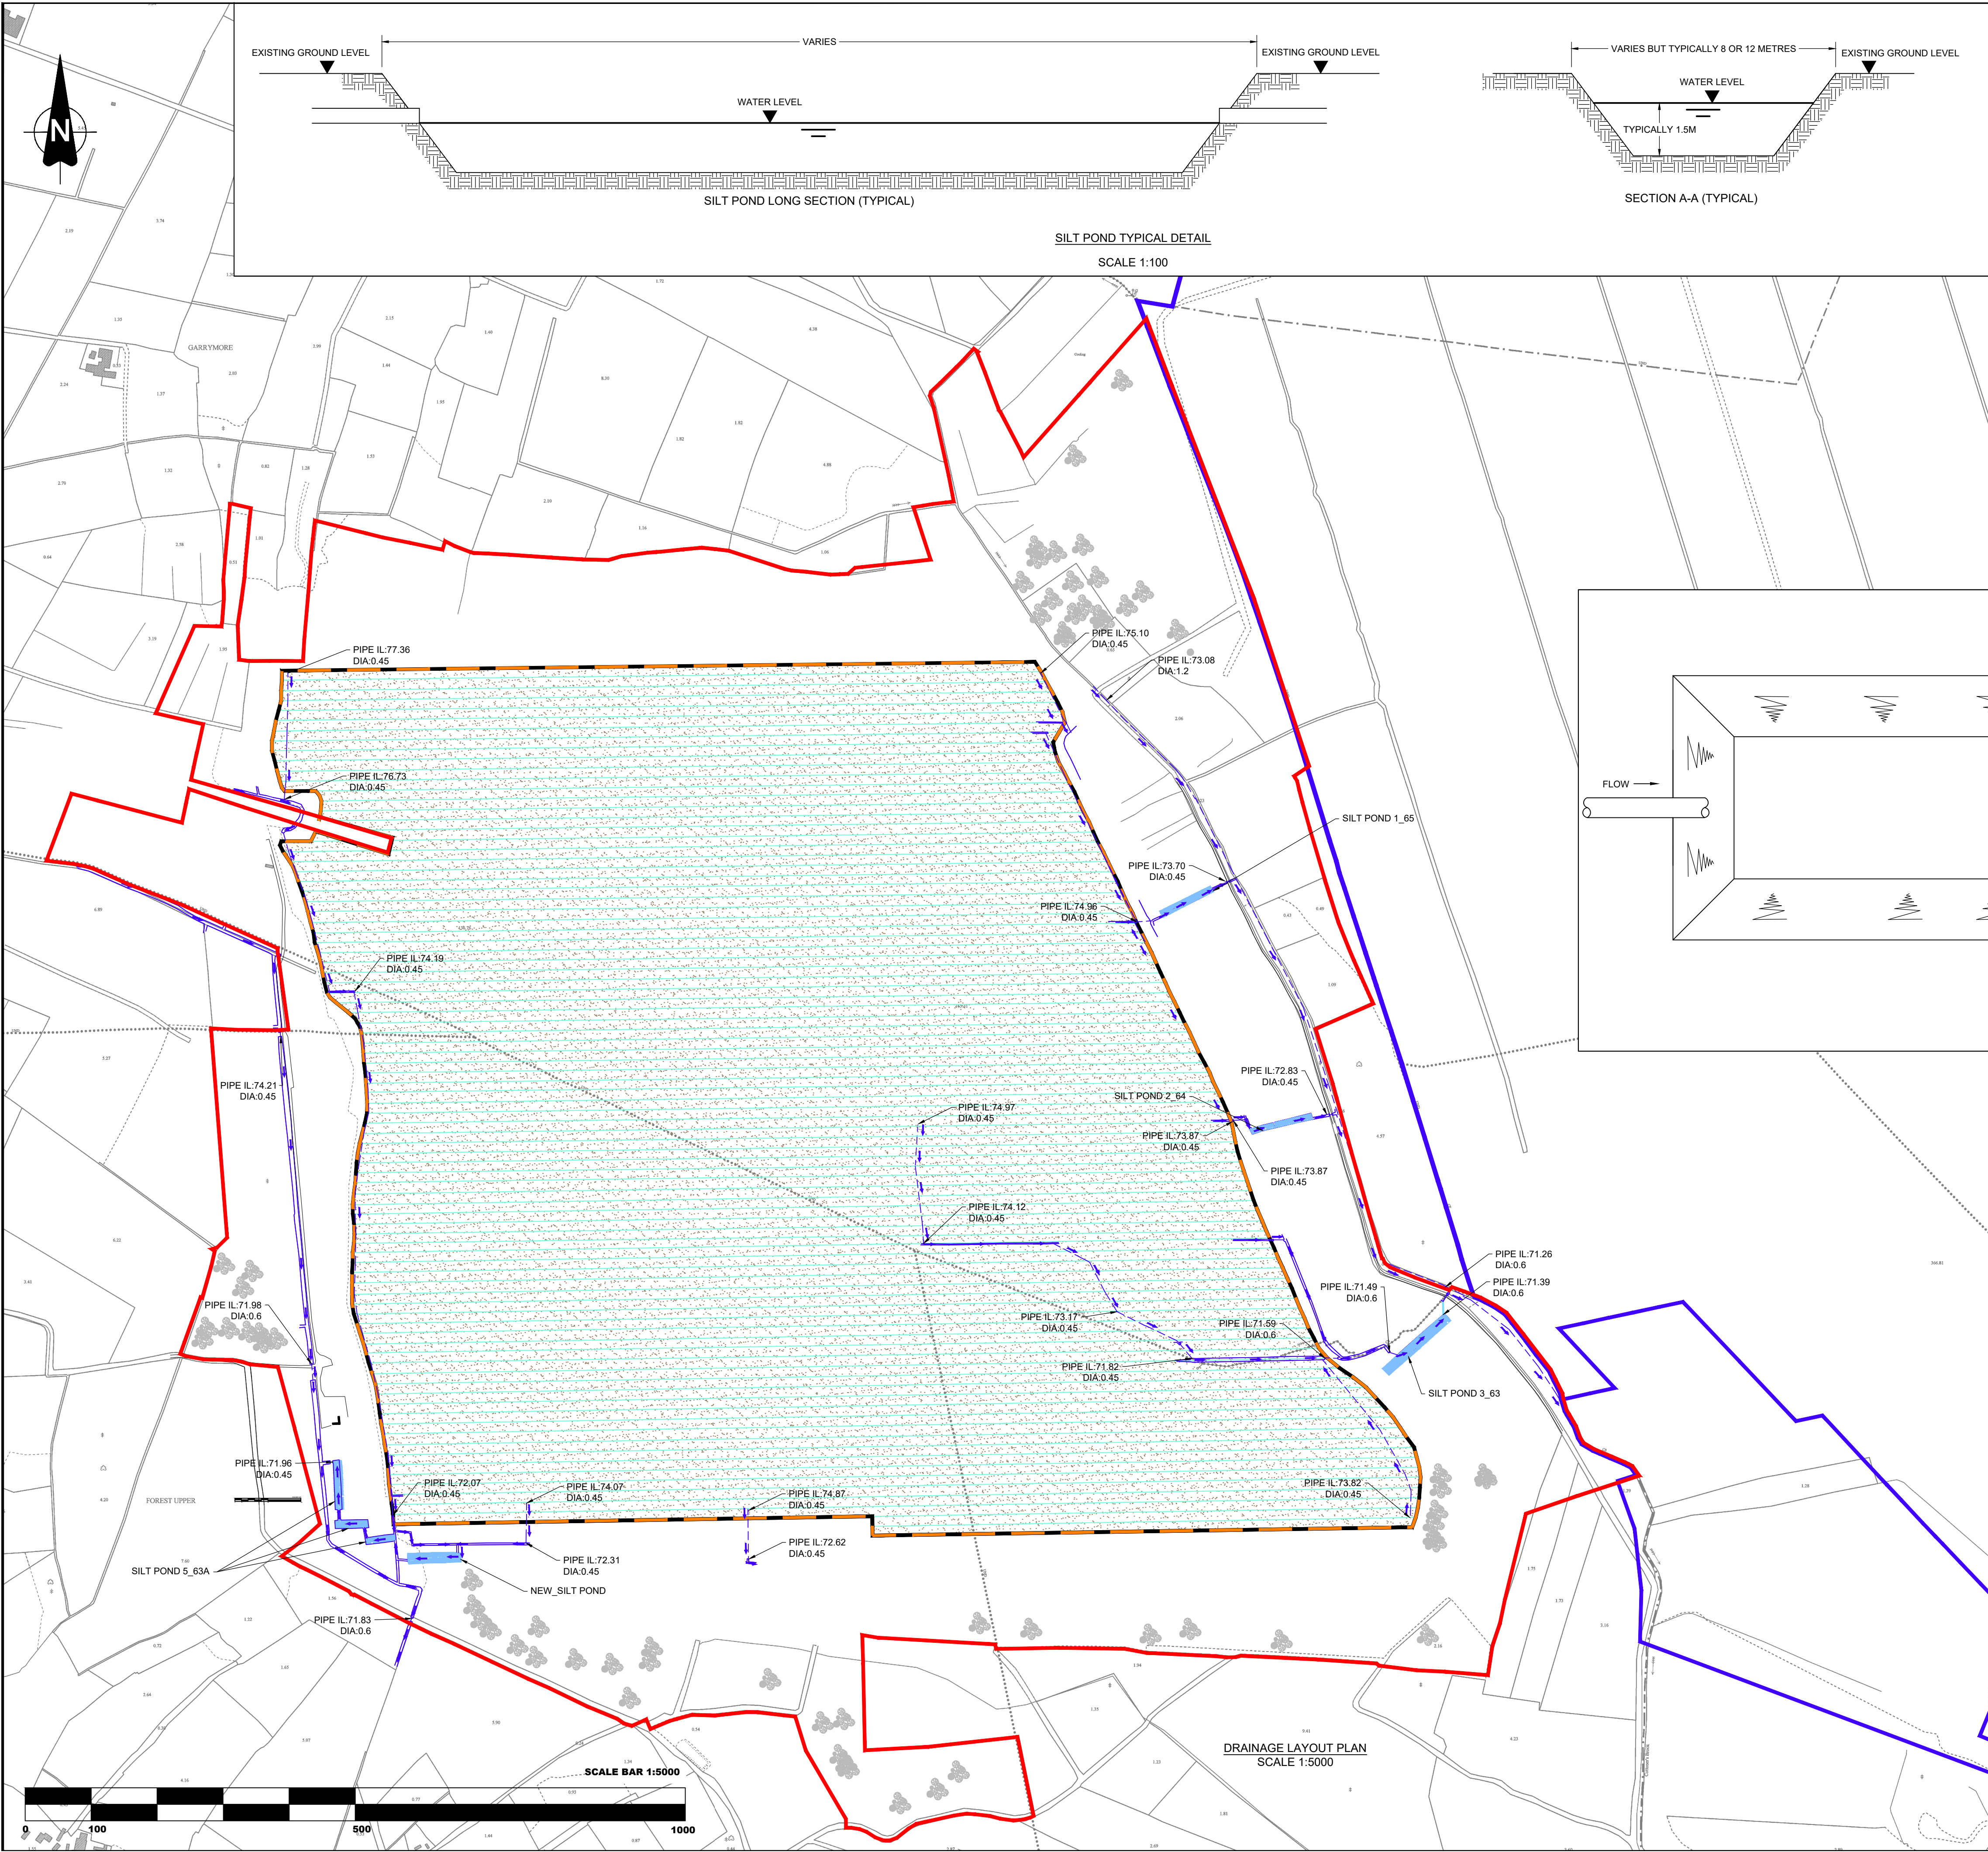

NOTES:

1. THIS DRAWING IS FOR PLANNING APPLICATION PURPOSES ONLY.
2. DRAWING NOT TO BE SCALED. FIGURED DIMENSIONS ONLY TO BE USED.
3. ALL LEVELS TO MALIN HEAD METRES ABOVE DATUM

REFERENCE OSI MAP NO: 3652, 3653
ORDNANCE SURVEY IRELAND LICENCE REF NO: EN 0035620.

LEGEND:

SUBSTITUTE CONSENT APPLICATION BOUNDARY:

BORD NA MONA LANDOWNERSHIP:

PRODUCTION FIELD DRAINS

EXISTING DRAIN


EXISTING SURFACE WATER PIPE

EXISTING SILT POND

MILLED PEAT PRODUCTION FIELDS (2012 ONWARDS):

MILLED PEAT PRODUCTION FIELDS PROPOSED EXTENTS (2020 ONWARDS):

TREES

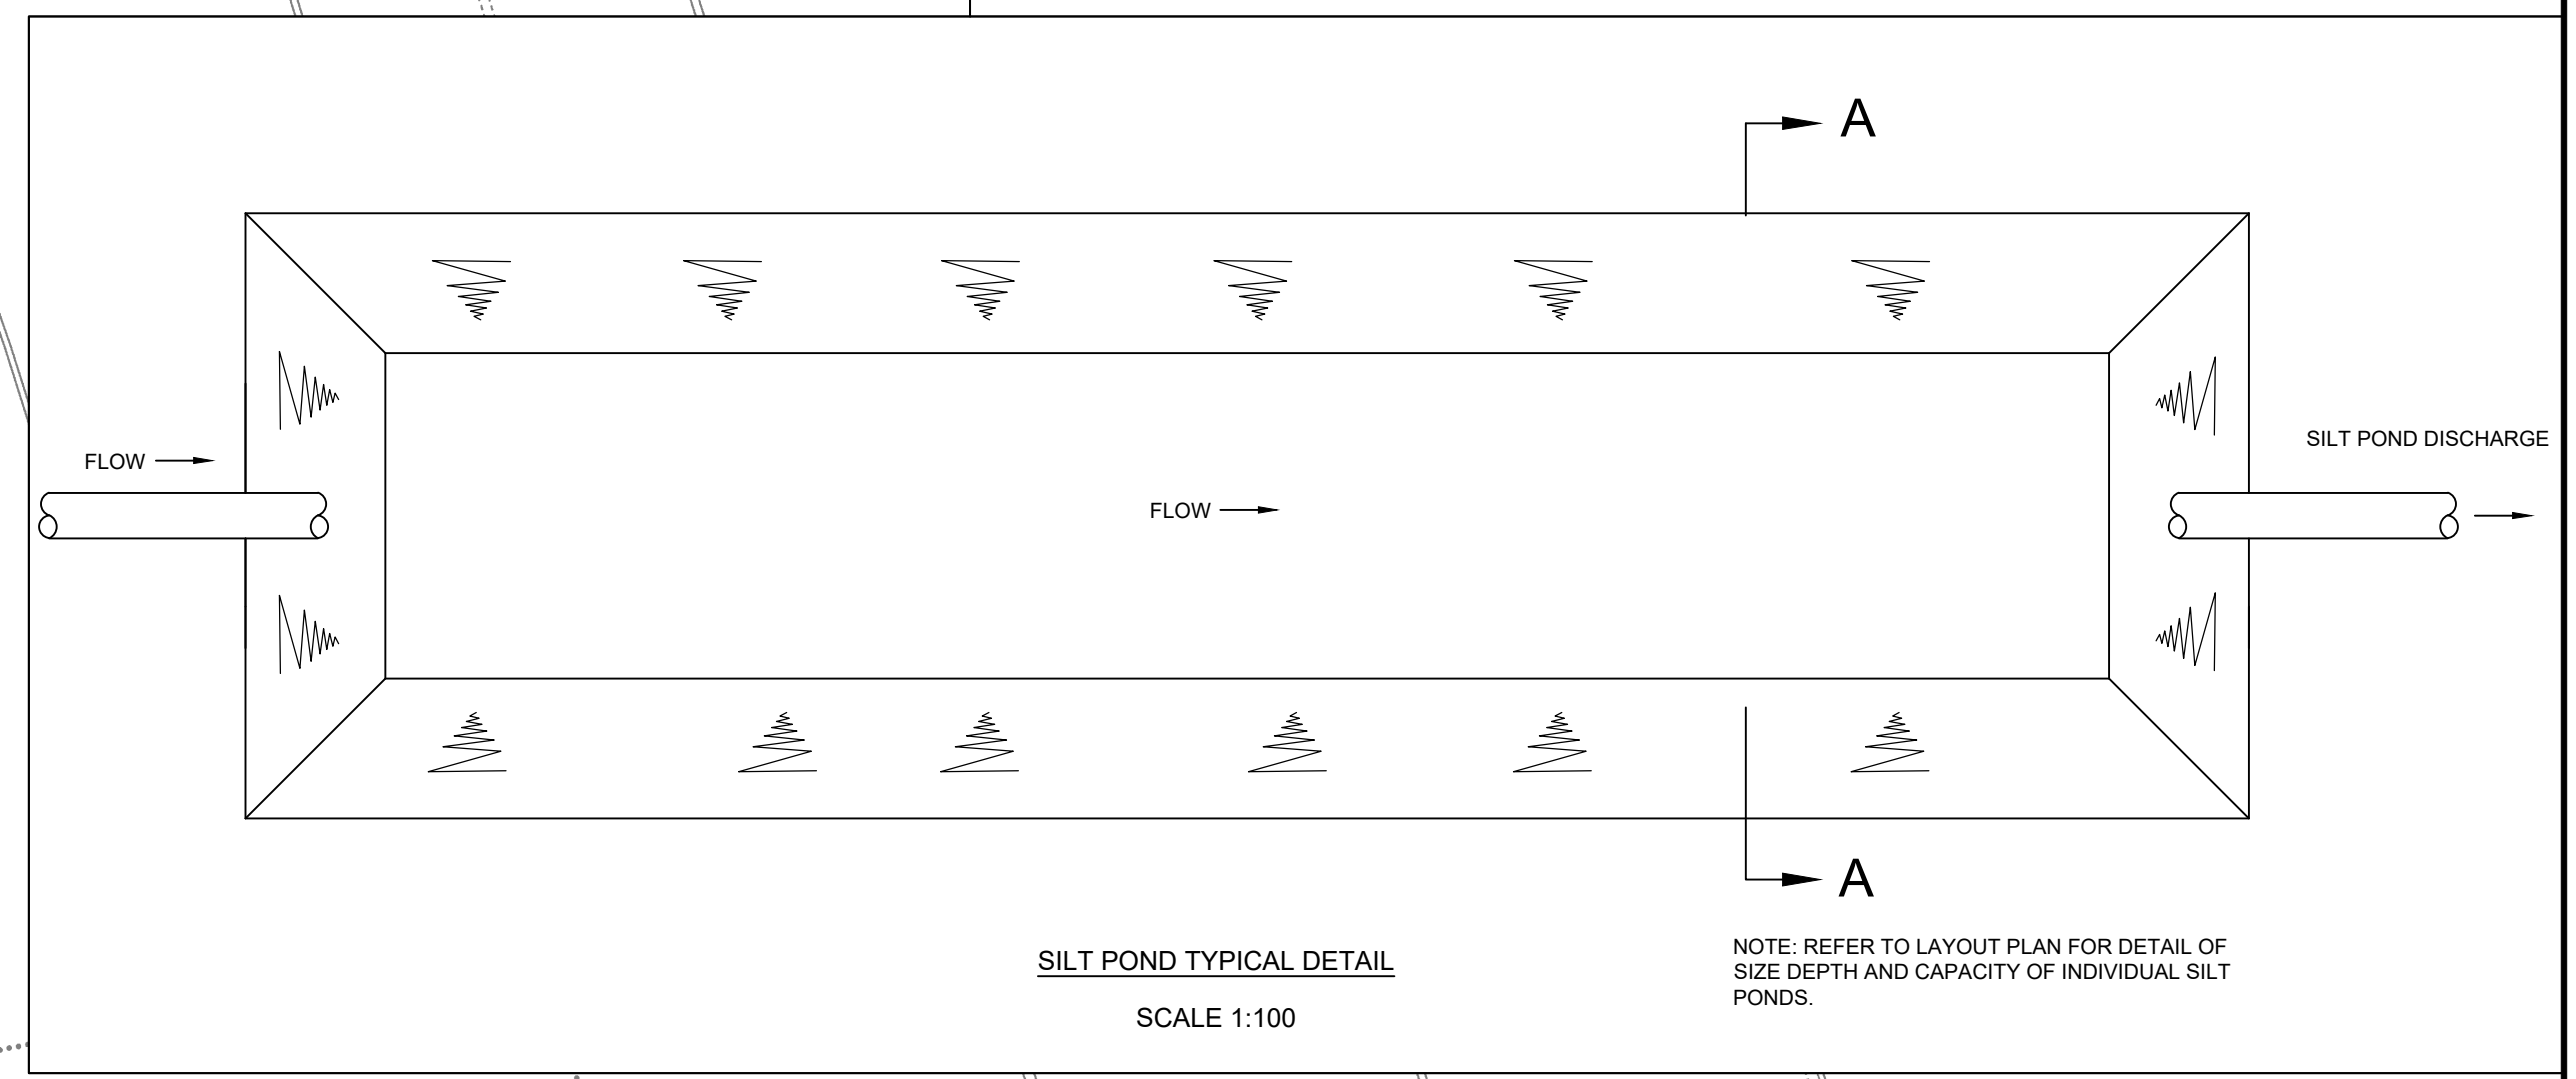

Project: SUBSTITUTE CONSENT APPLICATION GARRYMORE BOG				
Title: DRAINAGE LAYOUT PLAN				
Dimensions in: METRES				
Scale: AS SHOWN @ A1				
Drawn By.	SD	03/04/20	 Naturally Driven Bord Na M6na Engineering Department LEABEG, TULLAMORE CO. OFFALY Tel. 057 9345900. Fax. 057 9345160	
Checked By.	PN	06/04/20		
Approved By.	DK	07/04/20		
Drawing No. SC-0503-GM-DR04			Revision.	Sheet 1 of 1