


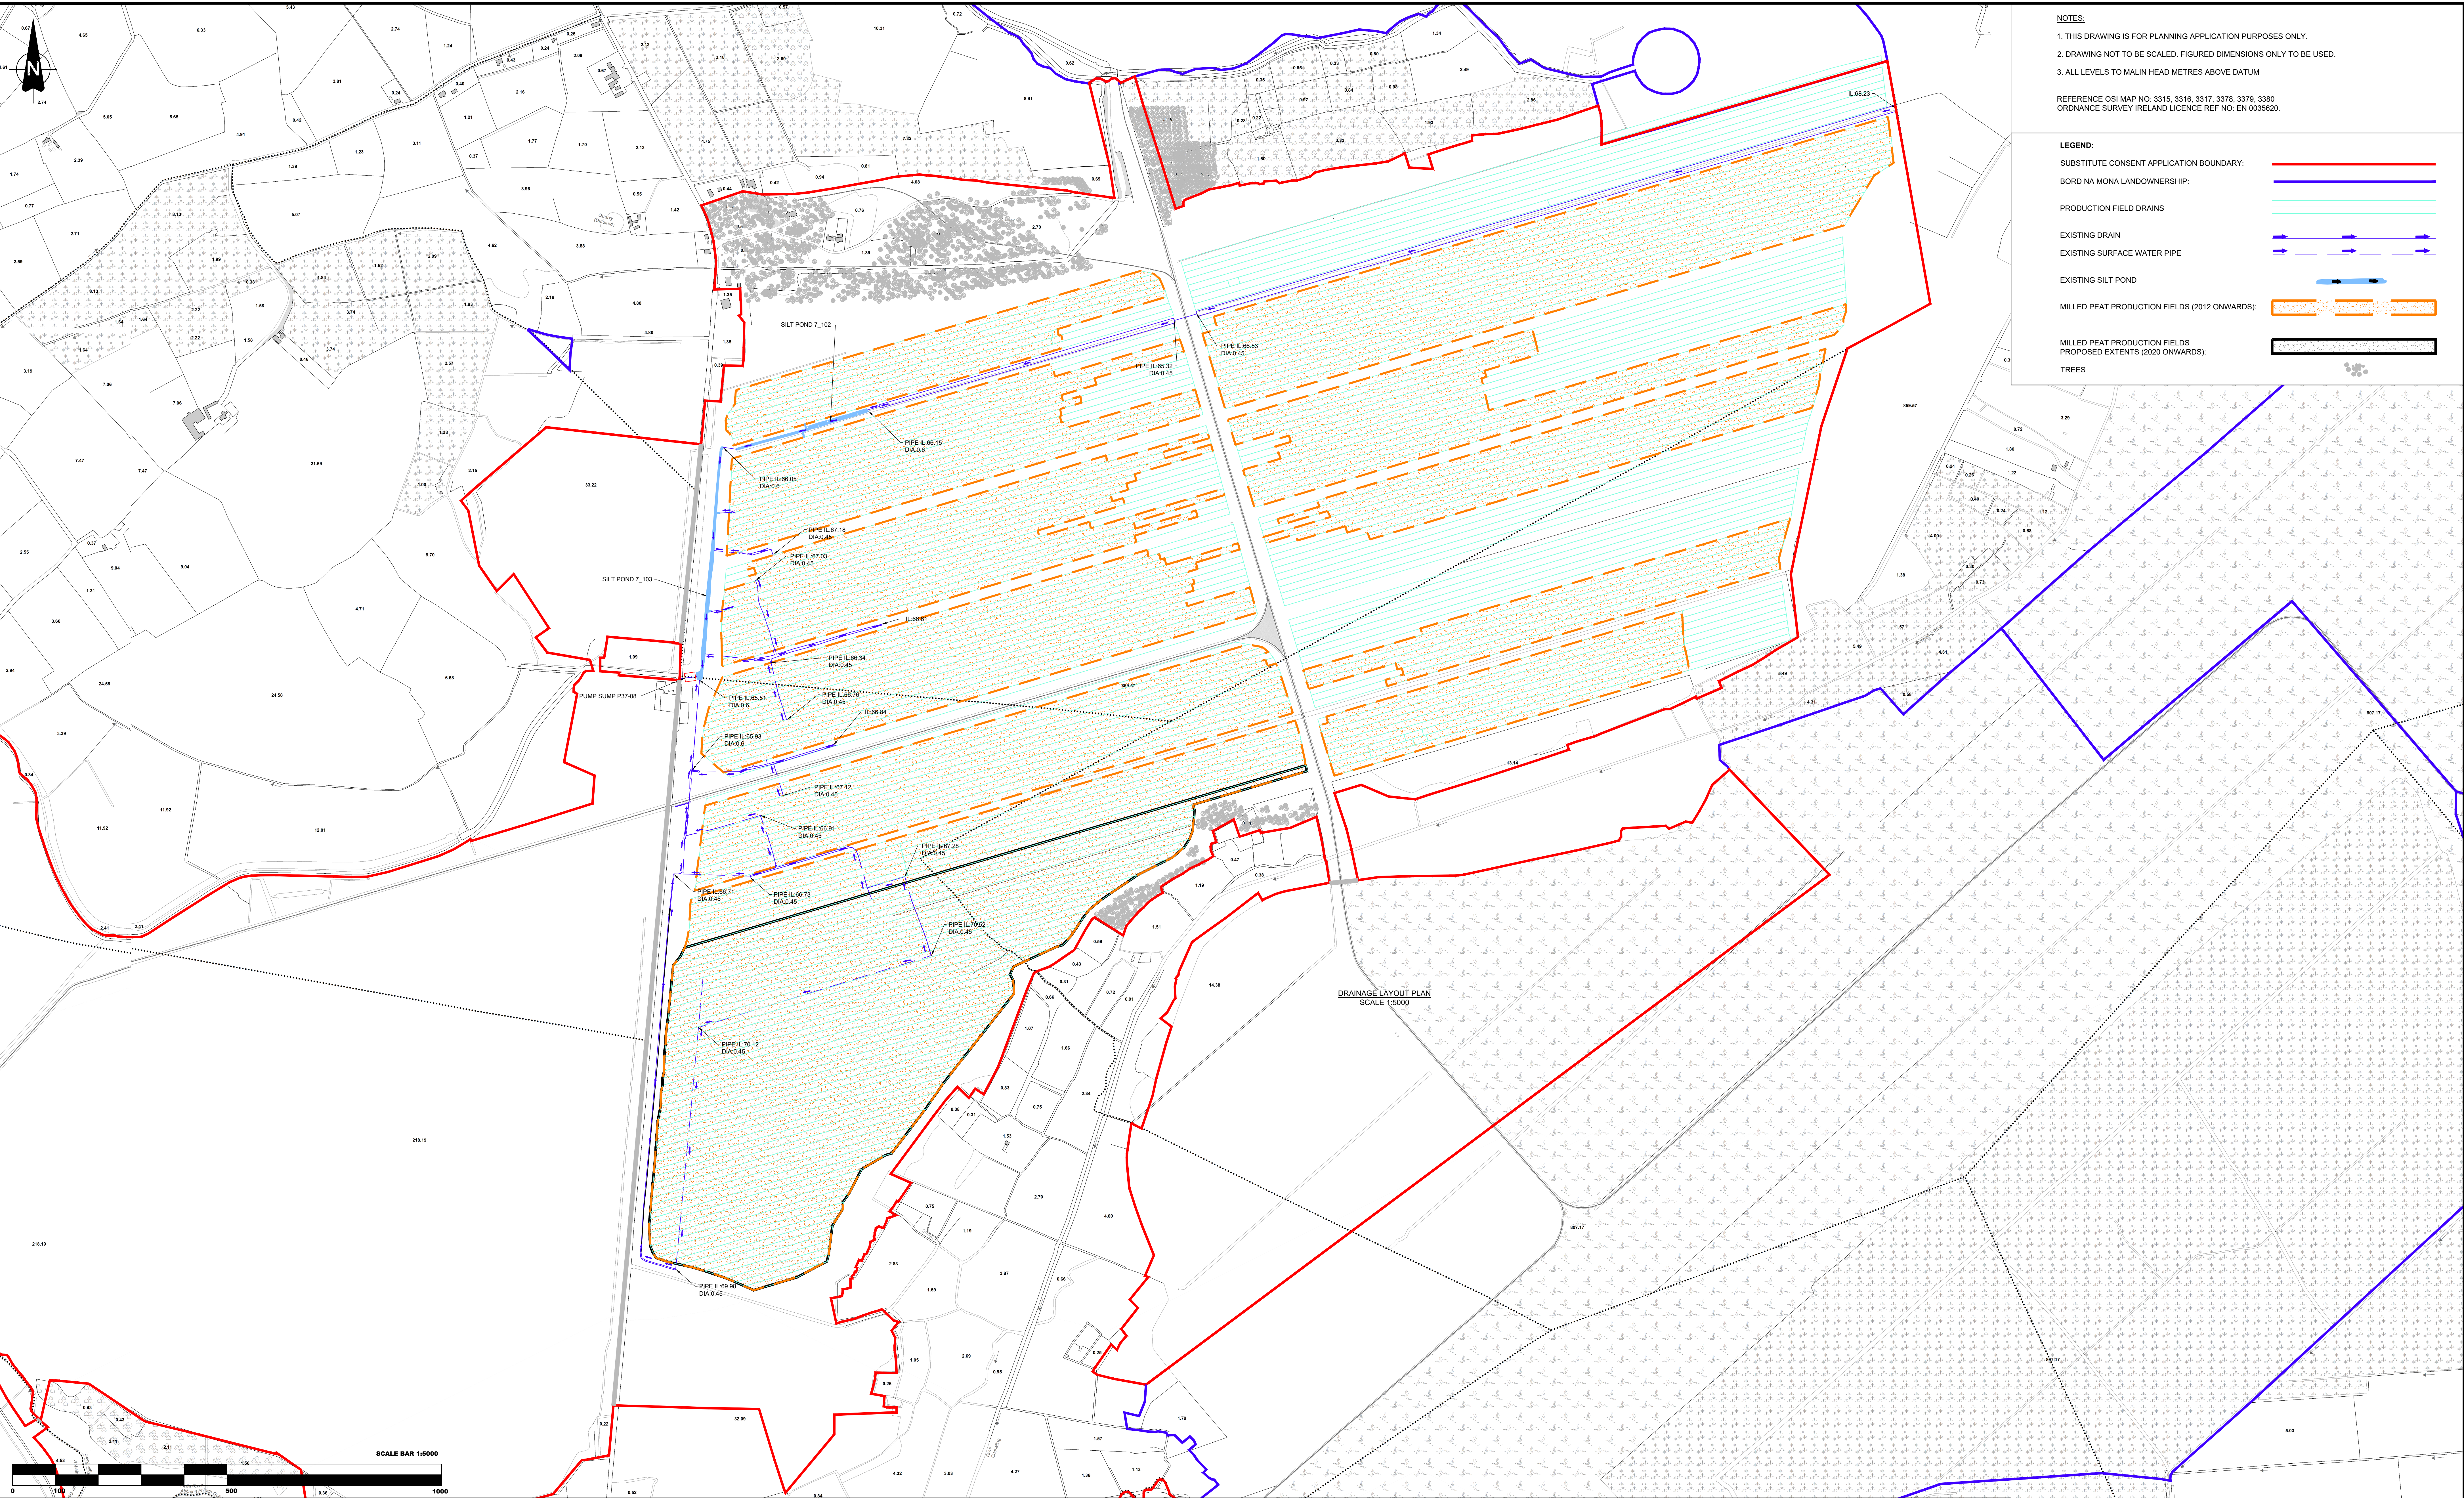

- NOTES:**
1. THIS DRAWING IS FOR PLANNING APPLICATION PURPOSES ONLY.
 2. DRAWING NOT TO BE SCALED. FIGURED DIMENSIONS ONLY TO BE USED.
 3. ALL LEVELS TO MALIN HEAD METRES ABOVE DATUM

REFERENCE OSI MAP NO: 3315, 3316, 3317, 3378, 3379, 3380
ORDNANCE SURVEY IRELAND LICENCE REF NO: EN 0035620.

LEGEND:

SUBSTITUTE CONSENT APPLICATION BOUNDARY:

BORD NA MONA LANDOWNERSHIP:

PRODUCTION FIELD DRAINS:

EXISTING DRAIN:





EXISTING SURFACE WATER PIPE:

EXISTING SILT POND:

MILLED PEAT PRODUCTION FIELDS (2012 ONWARDS):

MILLED PEAT PRODUCTION FIELDS PROPOSED EXTENTS (2020 ONWARDS):

TREES:

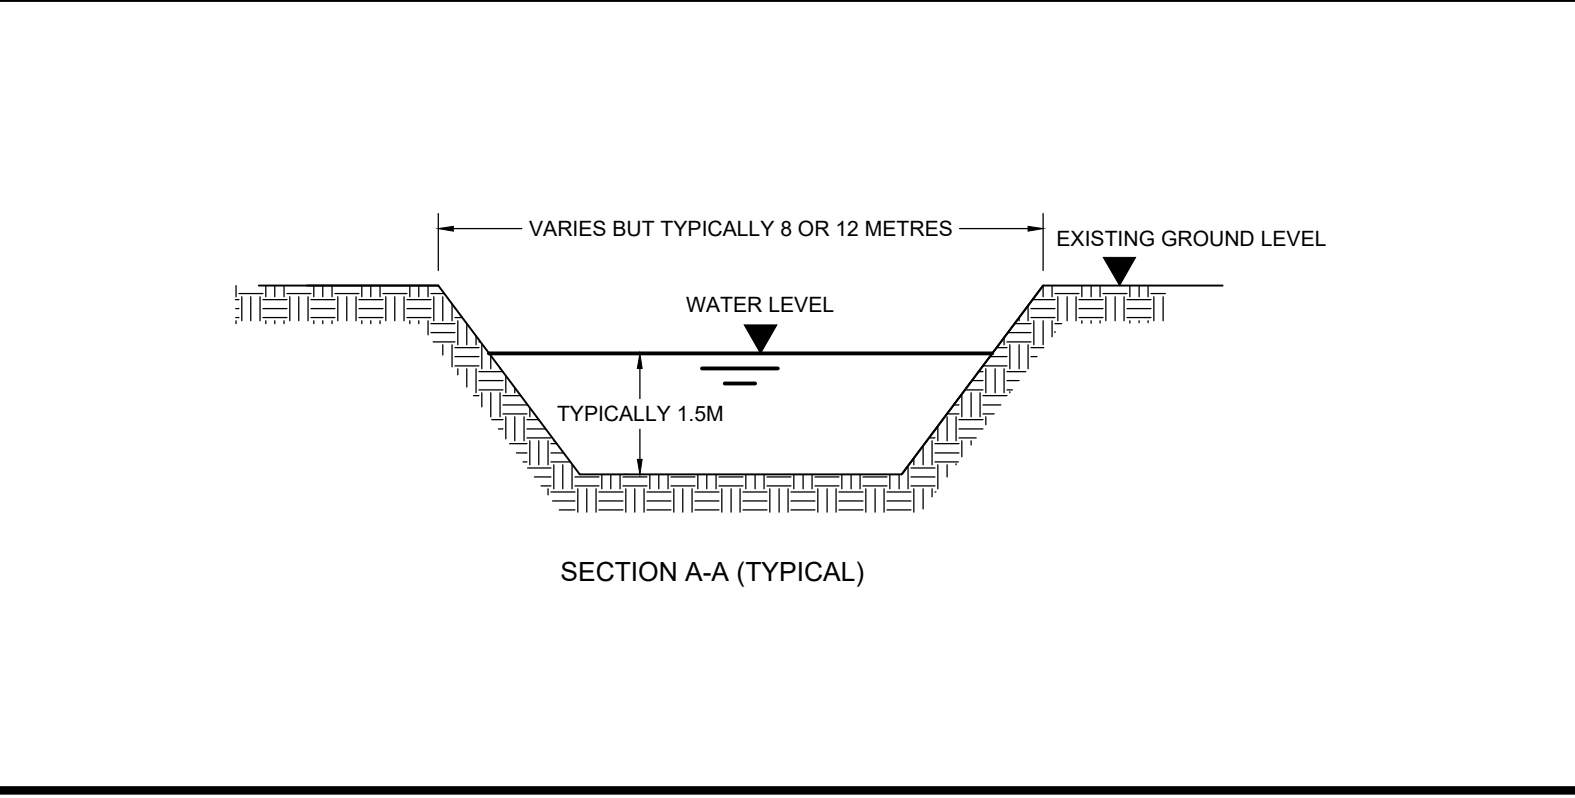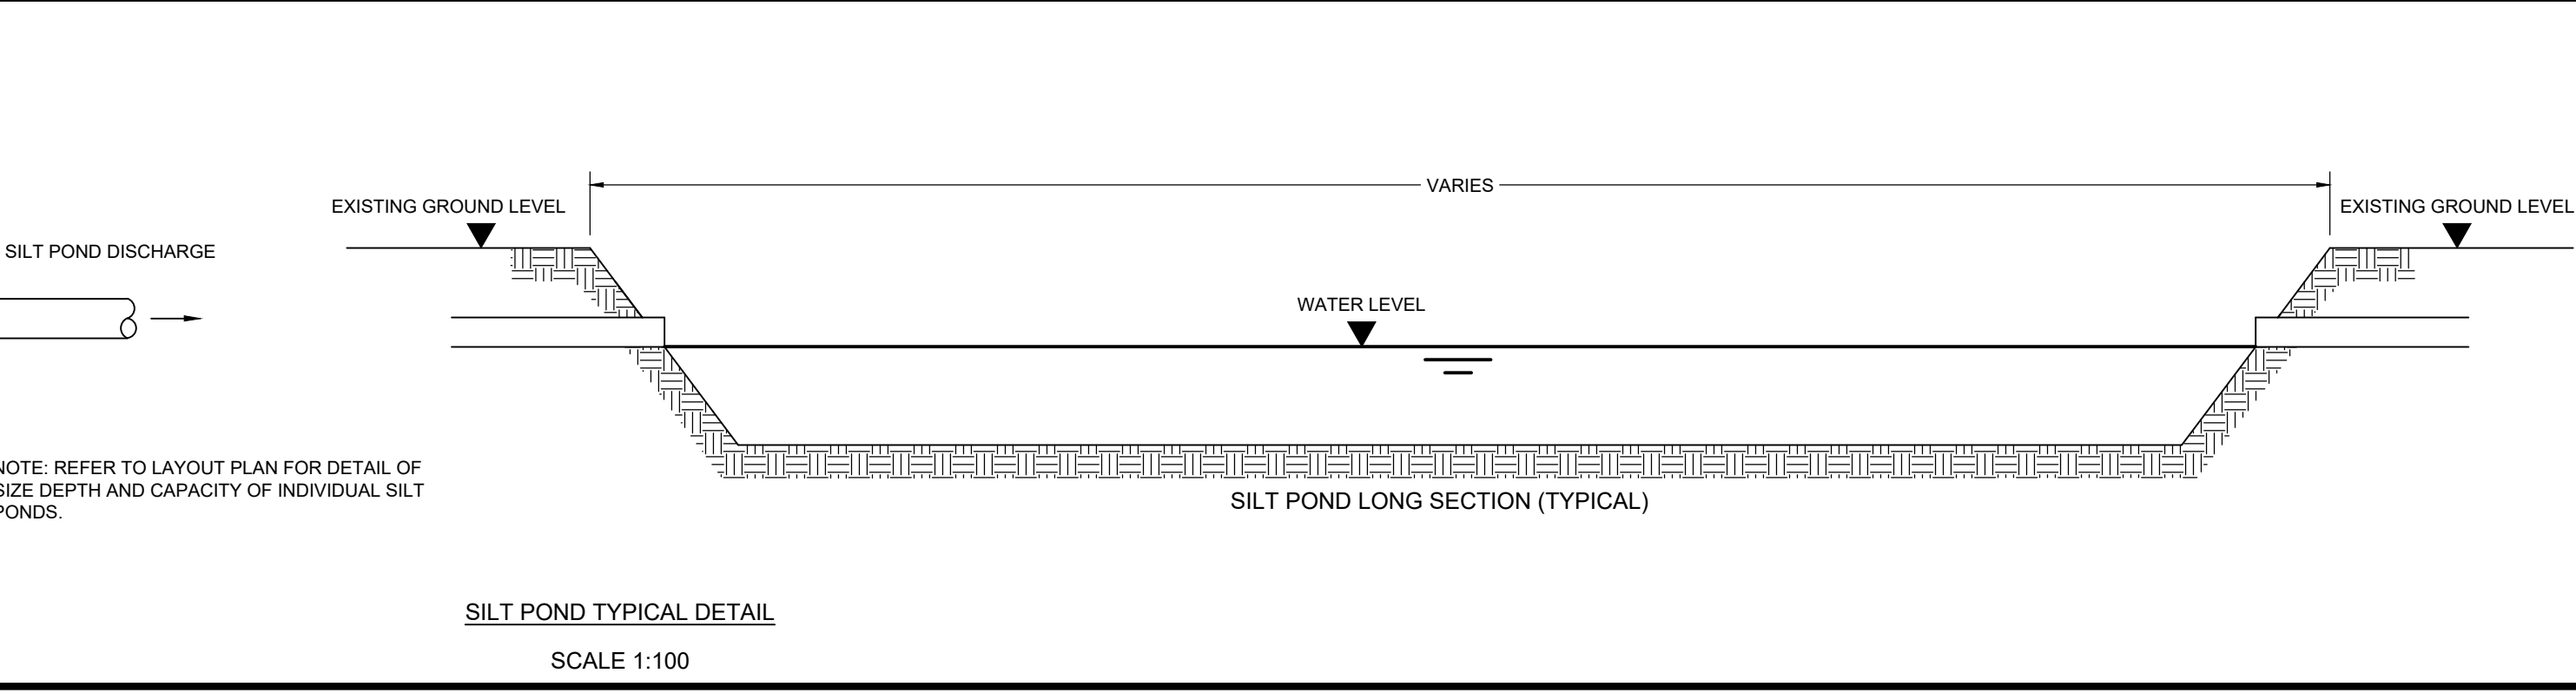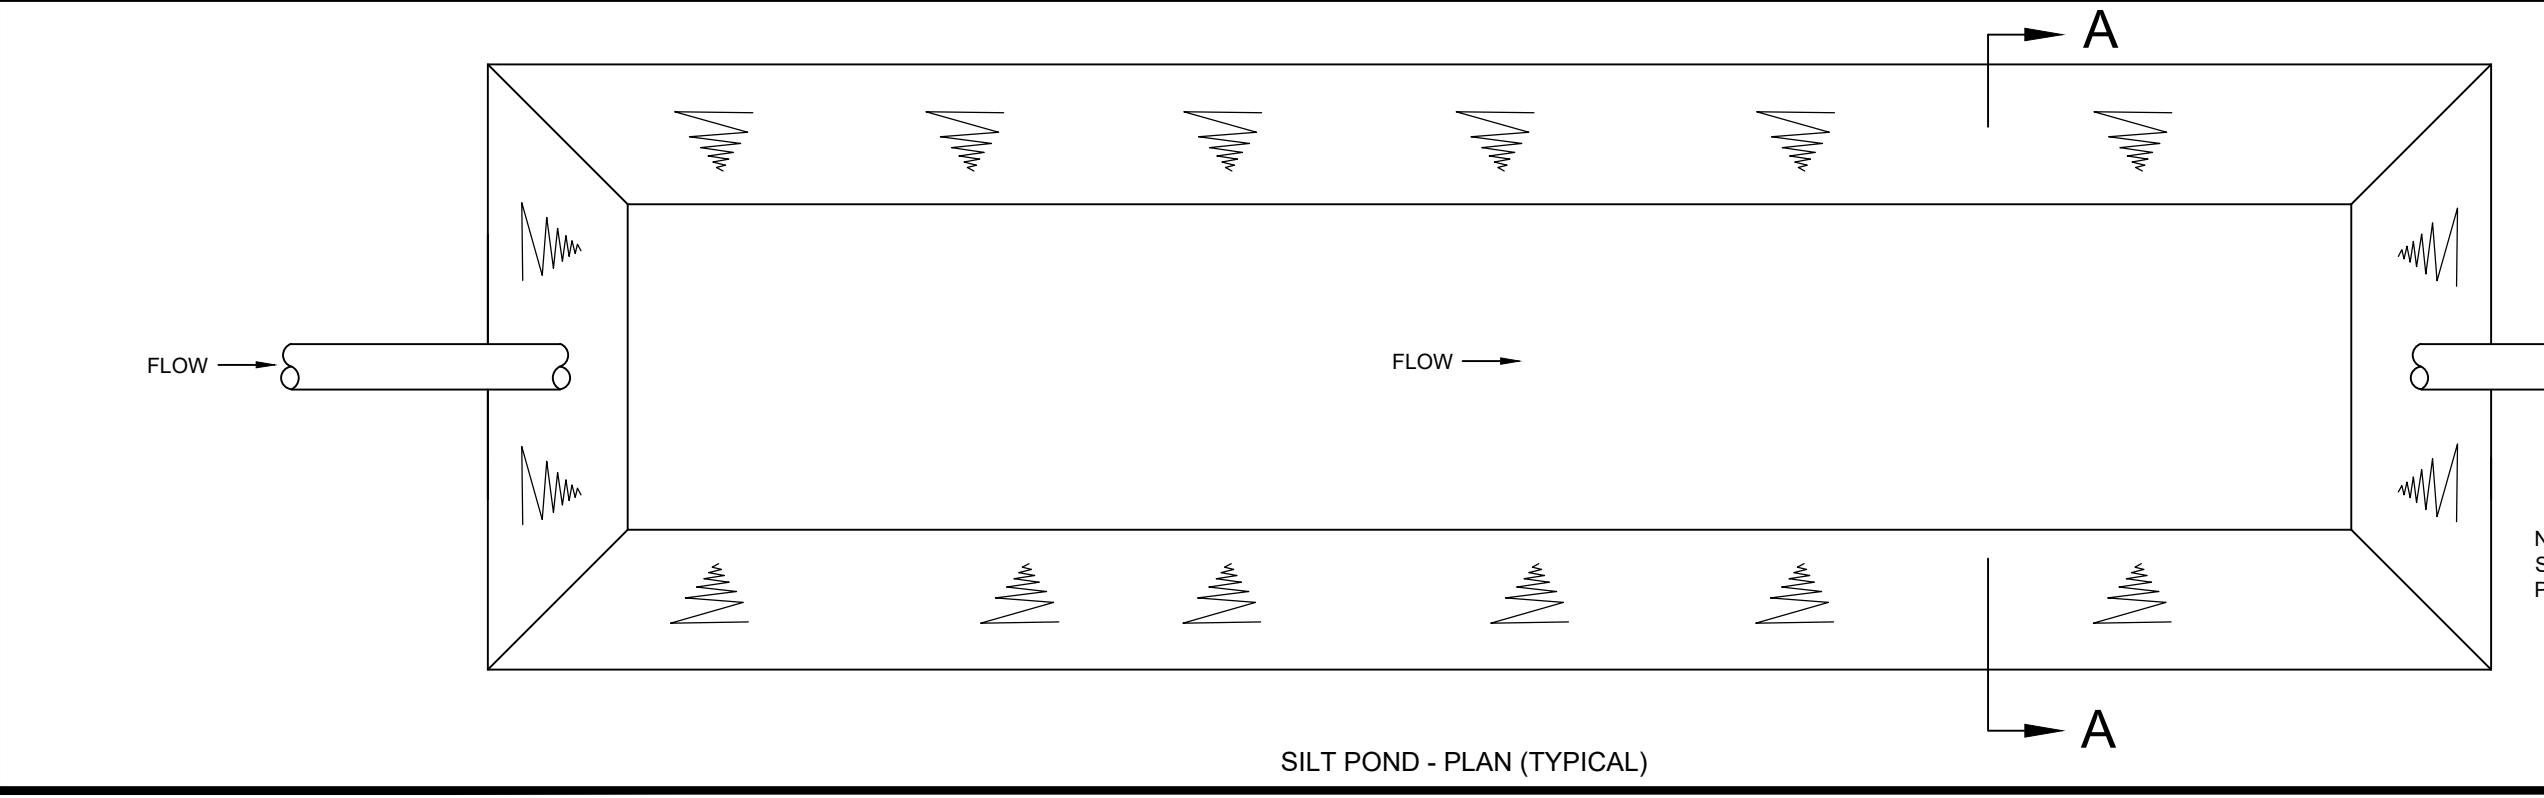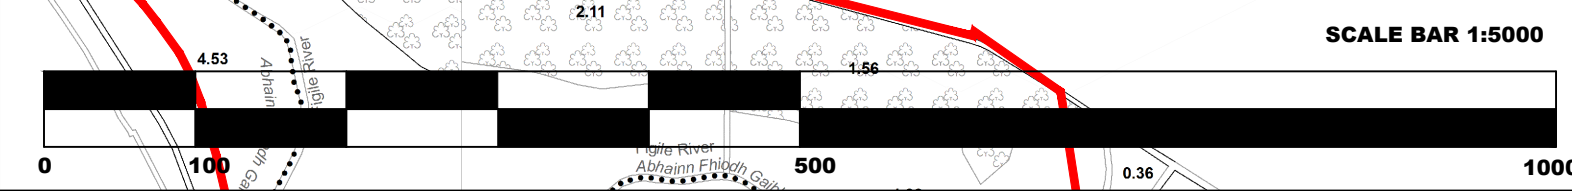

Project: SUBSTITUTE CONSENT APPLICATION GLASHABAUN NORTH BOG				
DRAINAGE LAYOUT PLAN				
REVISION	By	Date	Chk'd	Title
				Dimensions in METRES
				Scale: AS SHOWN @ A0
				Drawn By: SD 21/04/20
				Checked By: PN 22/04/20
				Approved By: DK 22/04/20
BORD NA MONA Naturally Driven East Na Mona Engineering Department LEAMING, TULLAMORE CO. OFFICIN Tel: 057 8345000 Fax: 057 8345100				Revision: Sheet 1 of 1