



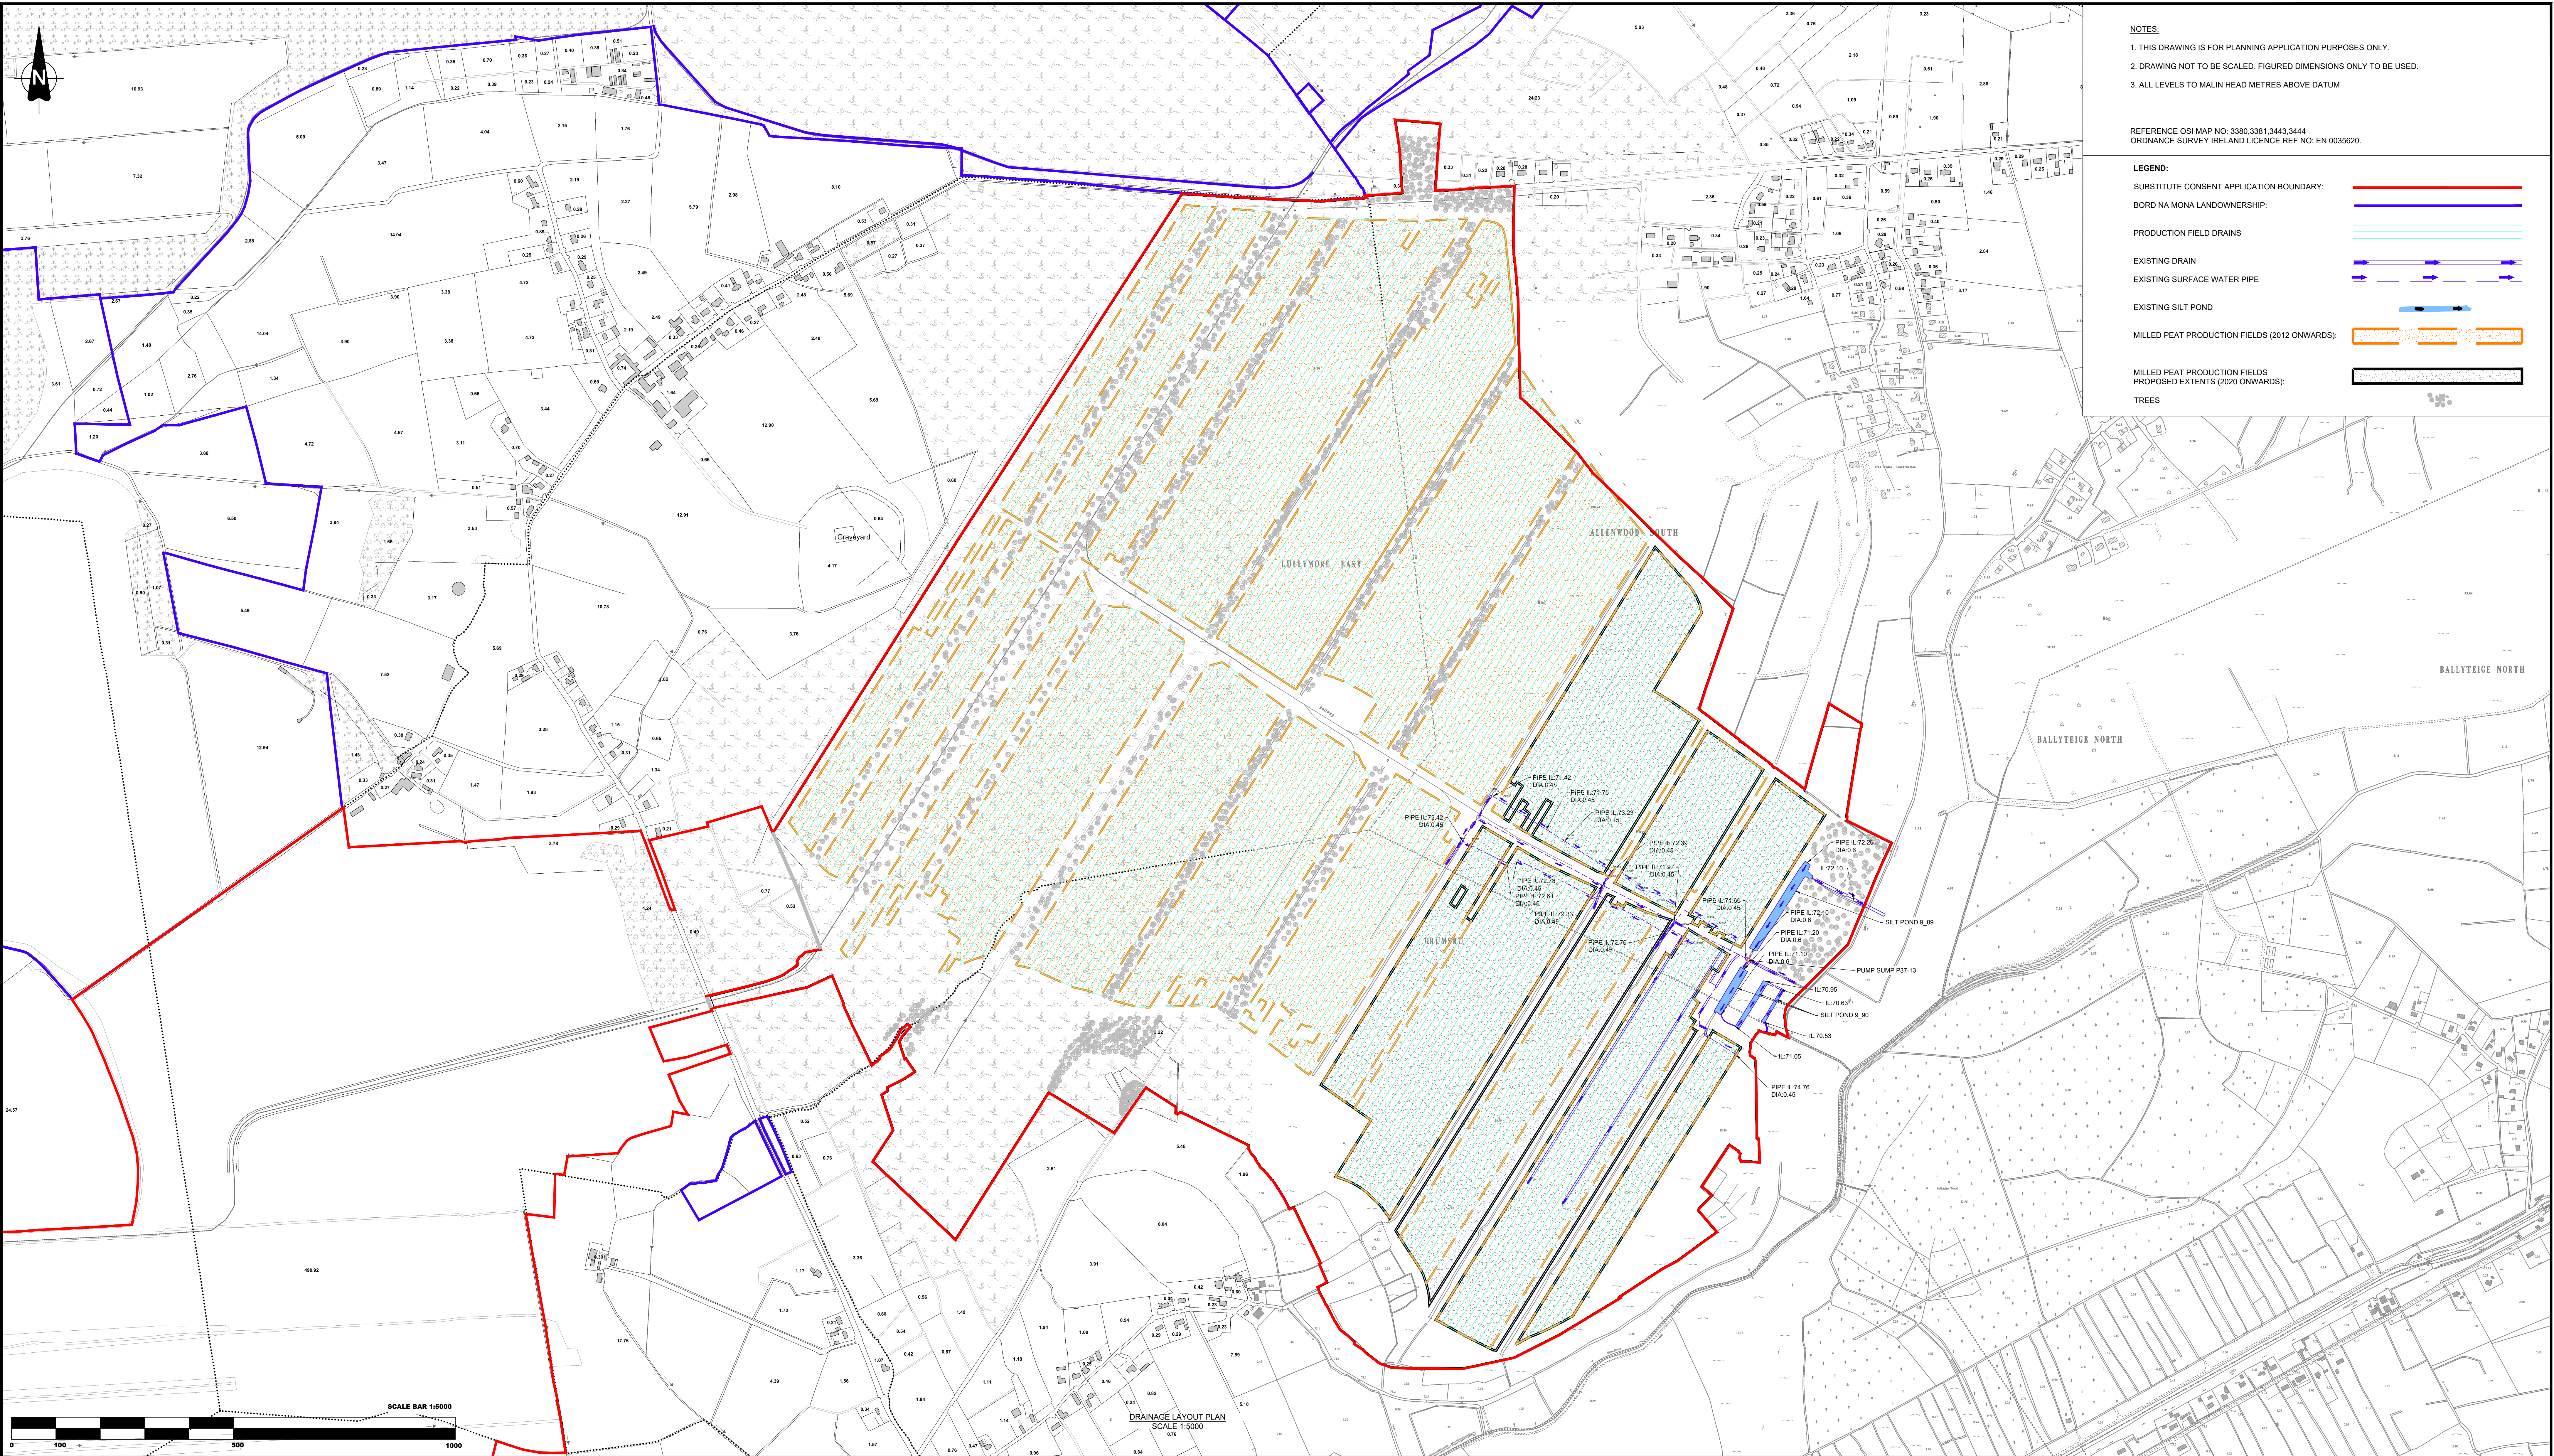

- NOTES:
1. THIS DRAWING IS FOR PLANNING APPLICATION PURPOSES ONLY.
 2. DRAWING NOT TO BE SCALED, FIGURED DIMENSIONS ONLY TO BE USED.
 3. ALL LEVELS TO MALIN HEAD METRES ABOVE DATUM

REFERENCE OSI MAP NO: 3380,3381,3443,3444
ORDNANCE SURVEY IRELAND LICENCE REF NO: EN 0035620.

- LEGEND:
- SUBSTITUTE CONSENT APPLICATION BOUNDARY:
 - BORD NA MONA LANDOWNERSHIP:
 - PRODUCTION FIELD DRAINS:
 - EXISTING DRAIN:
 - EXISTING SURFACE WATER PIPE:
 - EXISTING SILT POND:
 - MILLED PEAT PRODUCTION FIELDS (2012 ONWARDS):
 - MILLED PEAT PRODUCTION FIELDS PROPOSED EXTENTS (2020 ONWARDS):
 - TREES:

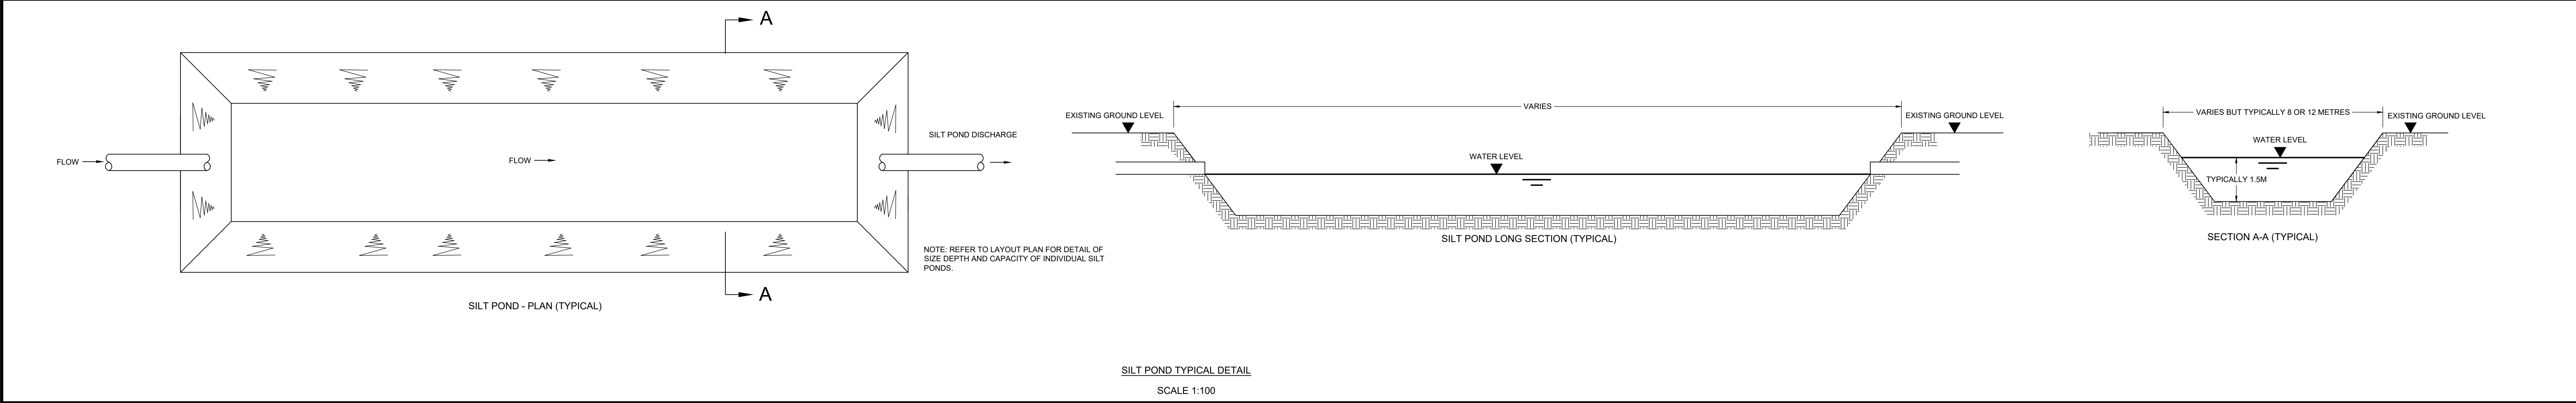

Project: SUBSTITUTE CONSENT APPLICATION LODGE BOG				
Title: DRAINAGE LAYOUT PLAN				
Dimensions in METRES				
Scale: AS SHOWN @ A0				
Drawn By: SD 20/04/20				
Checked By: PN 21/04/20				
Approved By: DK 21/04/20				
Revision: SC-0503-LG-DR04				
Sheet 1 of 1				

BORD NA MONA
Naturally Driven
Best for Monks & Engineers
LEAMING, TULLAMORE CO. OFFICIN
Tel: 057 8345000 Fax: 057 8345100