

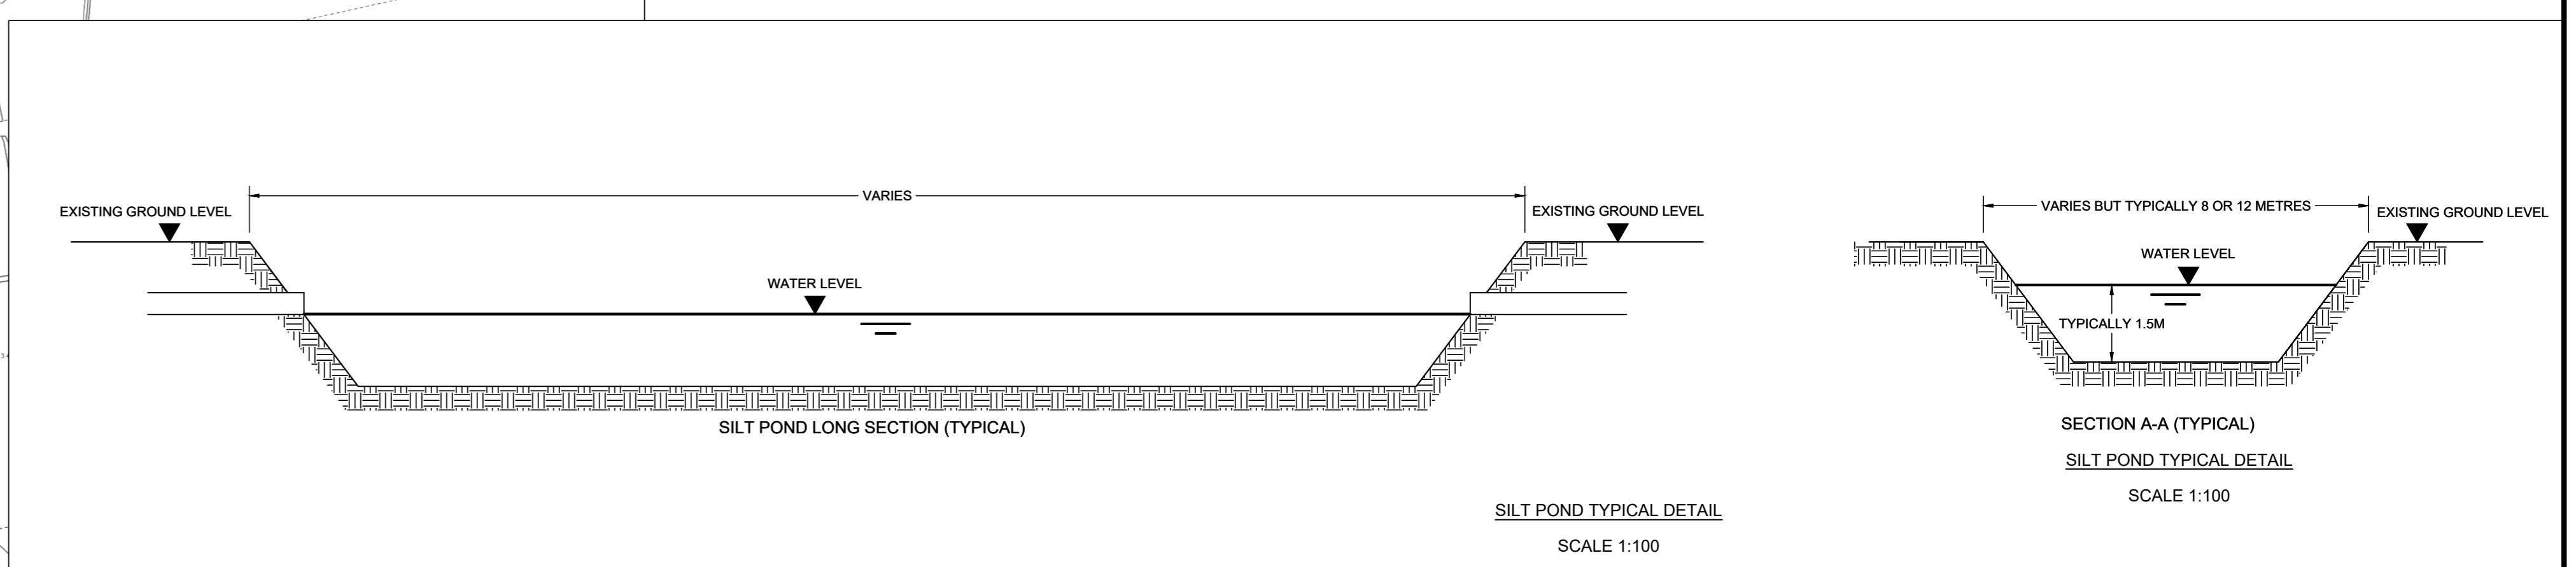
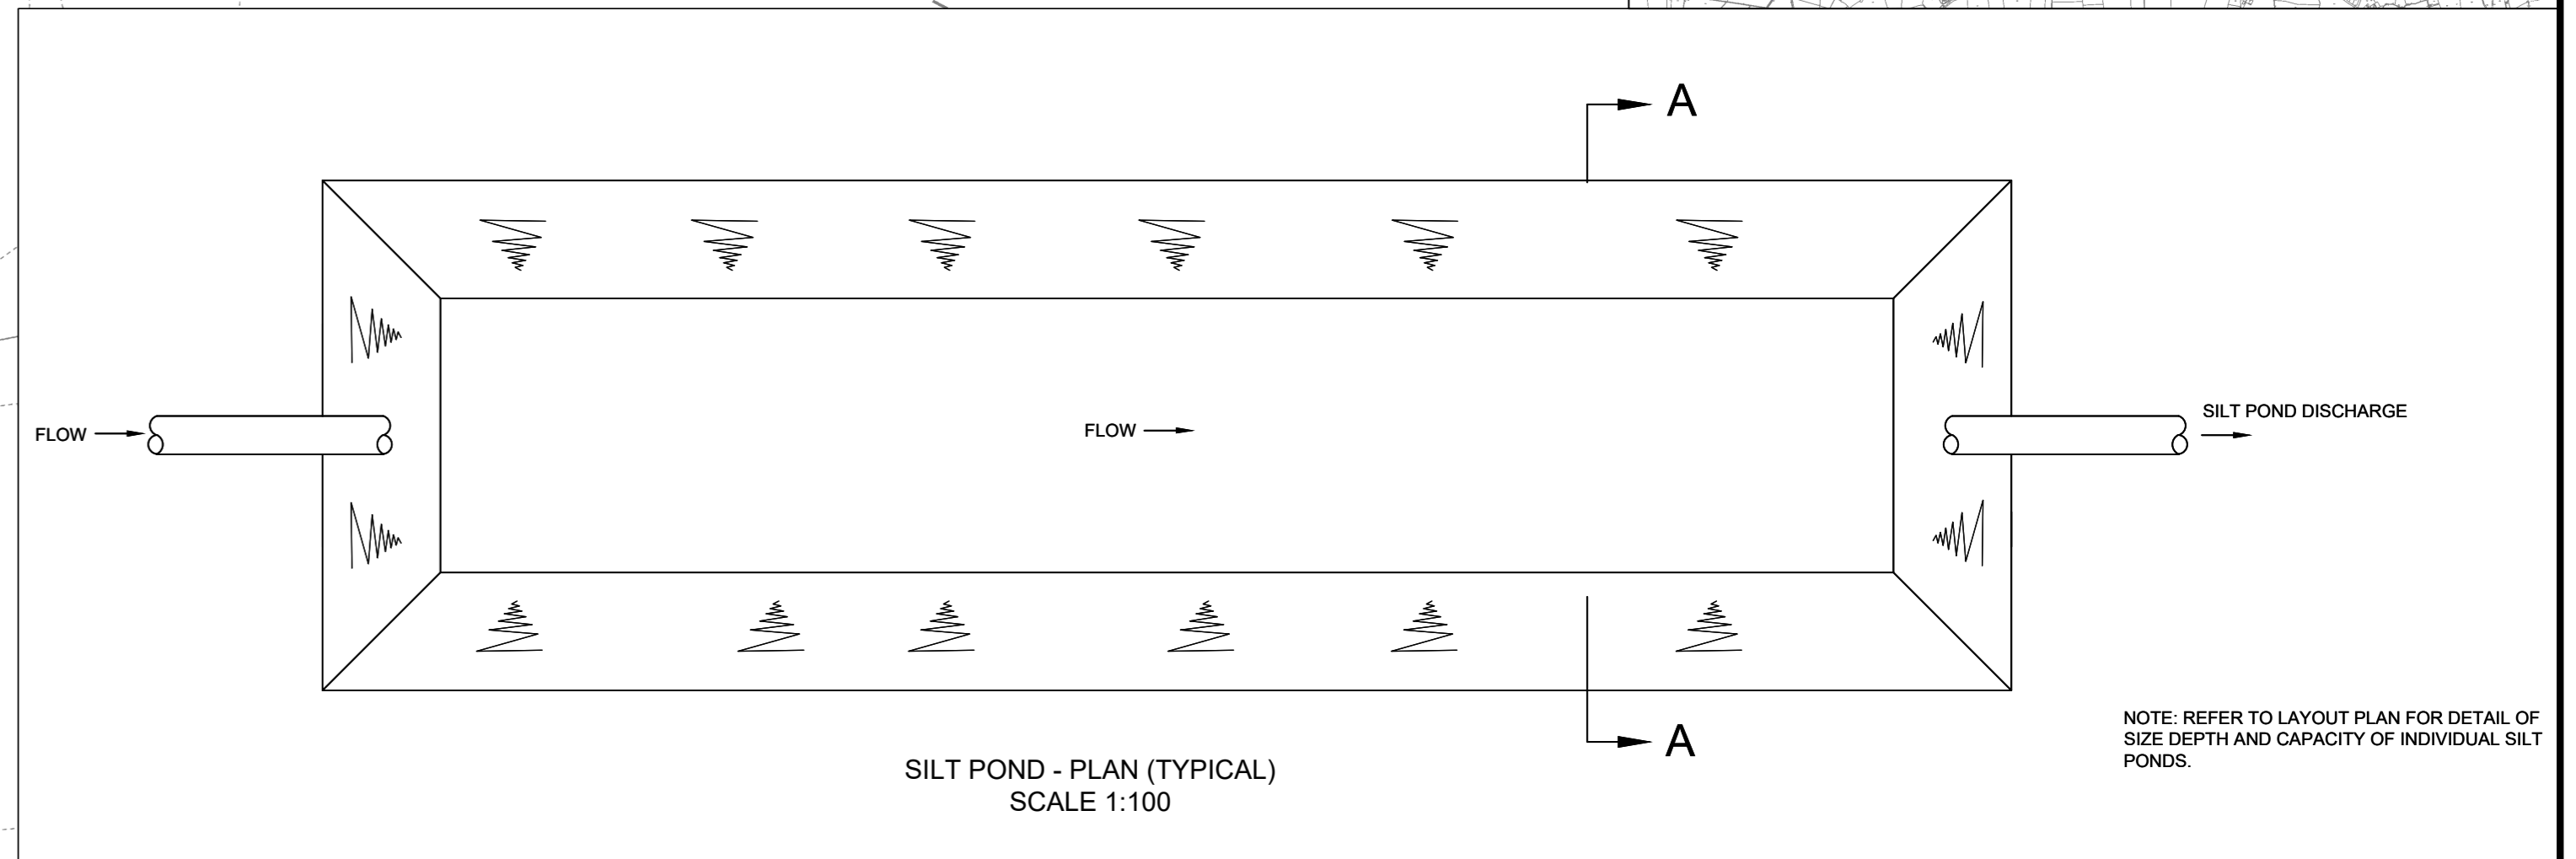


- NOTES:**
1. THIS DRAWING IS FOR PLANNING APPLICATION PURPOSES ONLY.
 2. DRAWING NOT TO BE SCALED. FIGURED DIMENSIONS ONLY TO BE USED.
 3. ALL LEVELS TO MALIN HEAD METRES ABOVE DATUM
- REFERENCE OSI MAP NO: 3488-3493, 3538-3543, 3587-3592, 3643-3648
ORDNANCE SURVEY IRELAND LICENCE REF NO: EN 0035620
- LEGEND:**
- SUBSTITUTE CONSENT APPLICATION BOUNDARY: [Red line]
 - BORD NA MONA LANDOWNERSHIP: [Blue line]
 - PRODUCTION FIELD DRAINS: [Green lines]
 - EXISTING DRAIN: [Blue dashed line]
 - EXISTING SURFACE WATER PIPE: [Blue dashed line with arrows]
 - EXISTING SILT POND: [Blue rectangle]
 - MILLED PEAT PRODUCTION FIELDS (2012 ONWARDS): [Orange hatched area]
 - MILLED PEAT PRODUCTION FIELDS PROPOSED EXTENTS (2020 ONWARDS): [Black hatched area]
 - TREES: [Grey stippled area]

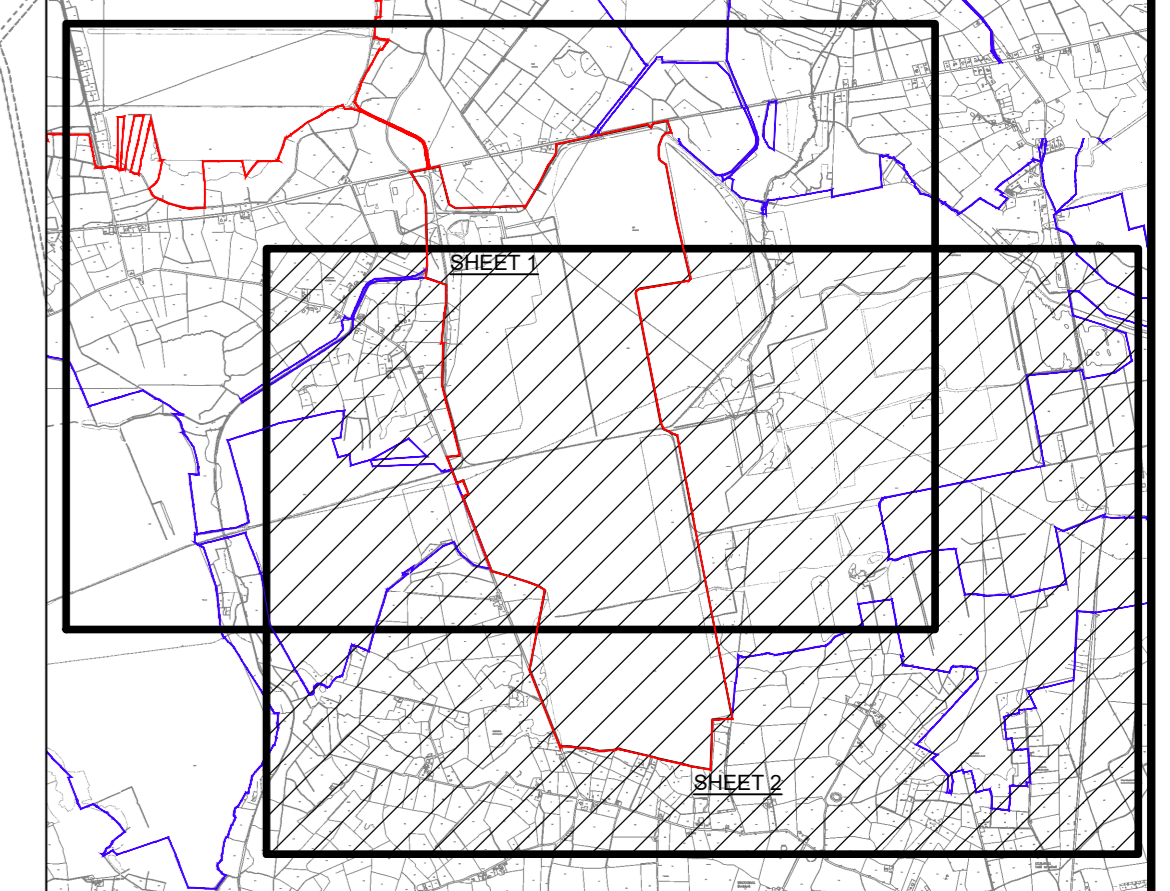

DRAINAGE LAYOUT PLAN
SCALE 1:5000

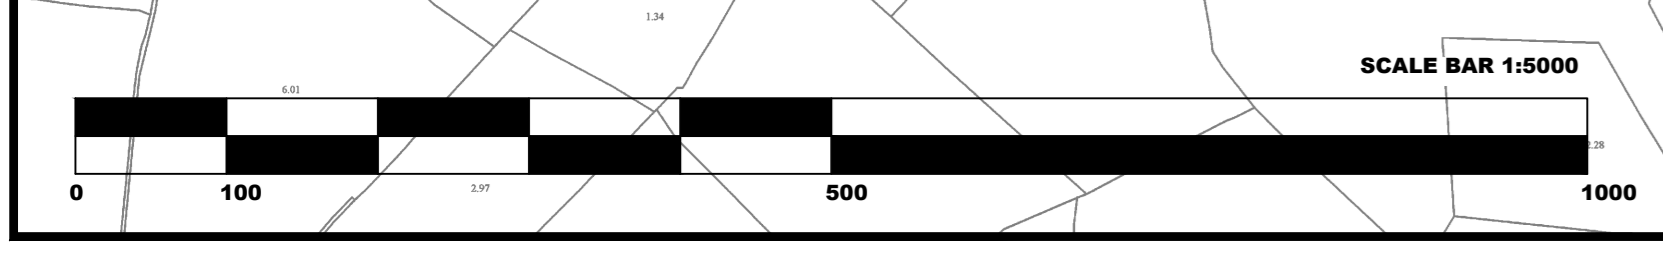

Project: **SUBSTITUTE CONSENT APPLICATION BOORA BOG**

Title: **DRAINAGE LAYOUT PLAN**

REVISION	By	Date	Chg	Title

Dimensions in METRES
Scale: 1:5,000 @ A0

Drawn By: SD 02/04/20
Checked By: PNI 02/04/20
Approved By: DK 03/04/20

BORD NA MONA
Naturally Driven
Soil to Grow Engineering Department
LEAMING: TULLAMORE CO. OFFICE
Tel: 057 934500 Fax: 057 934510

Drawing No: SC-0500-BO-D07
Revision:
Sheet: 2 of 2