

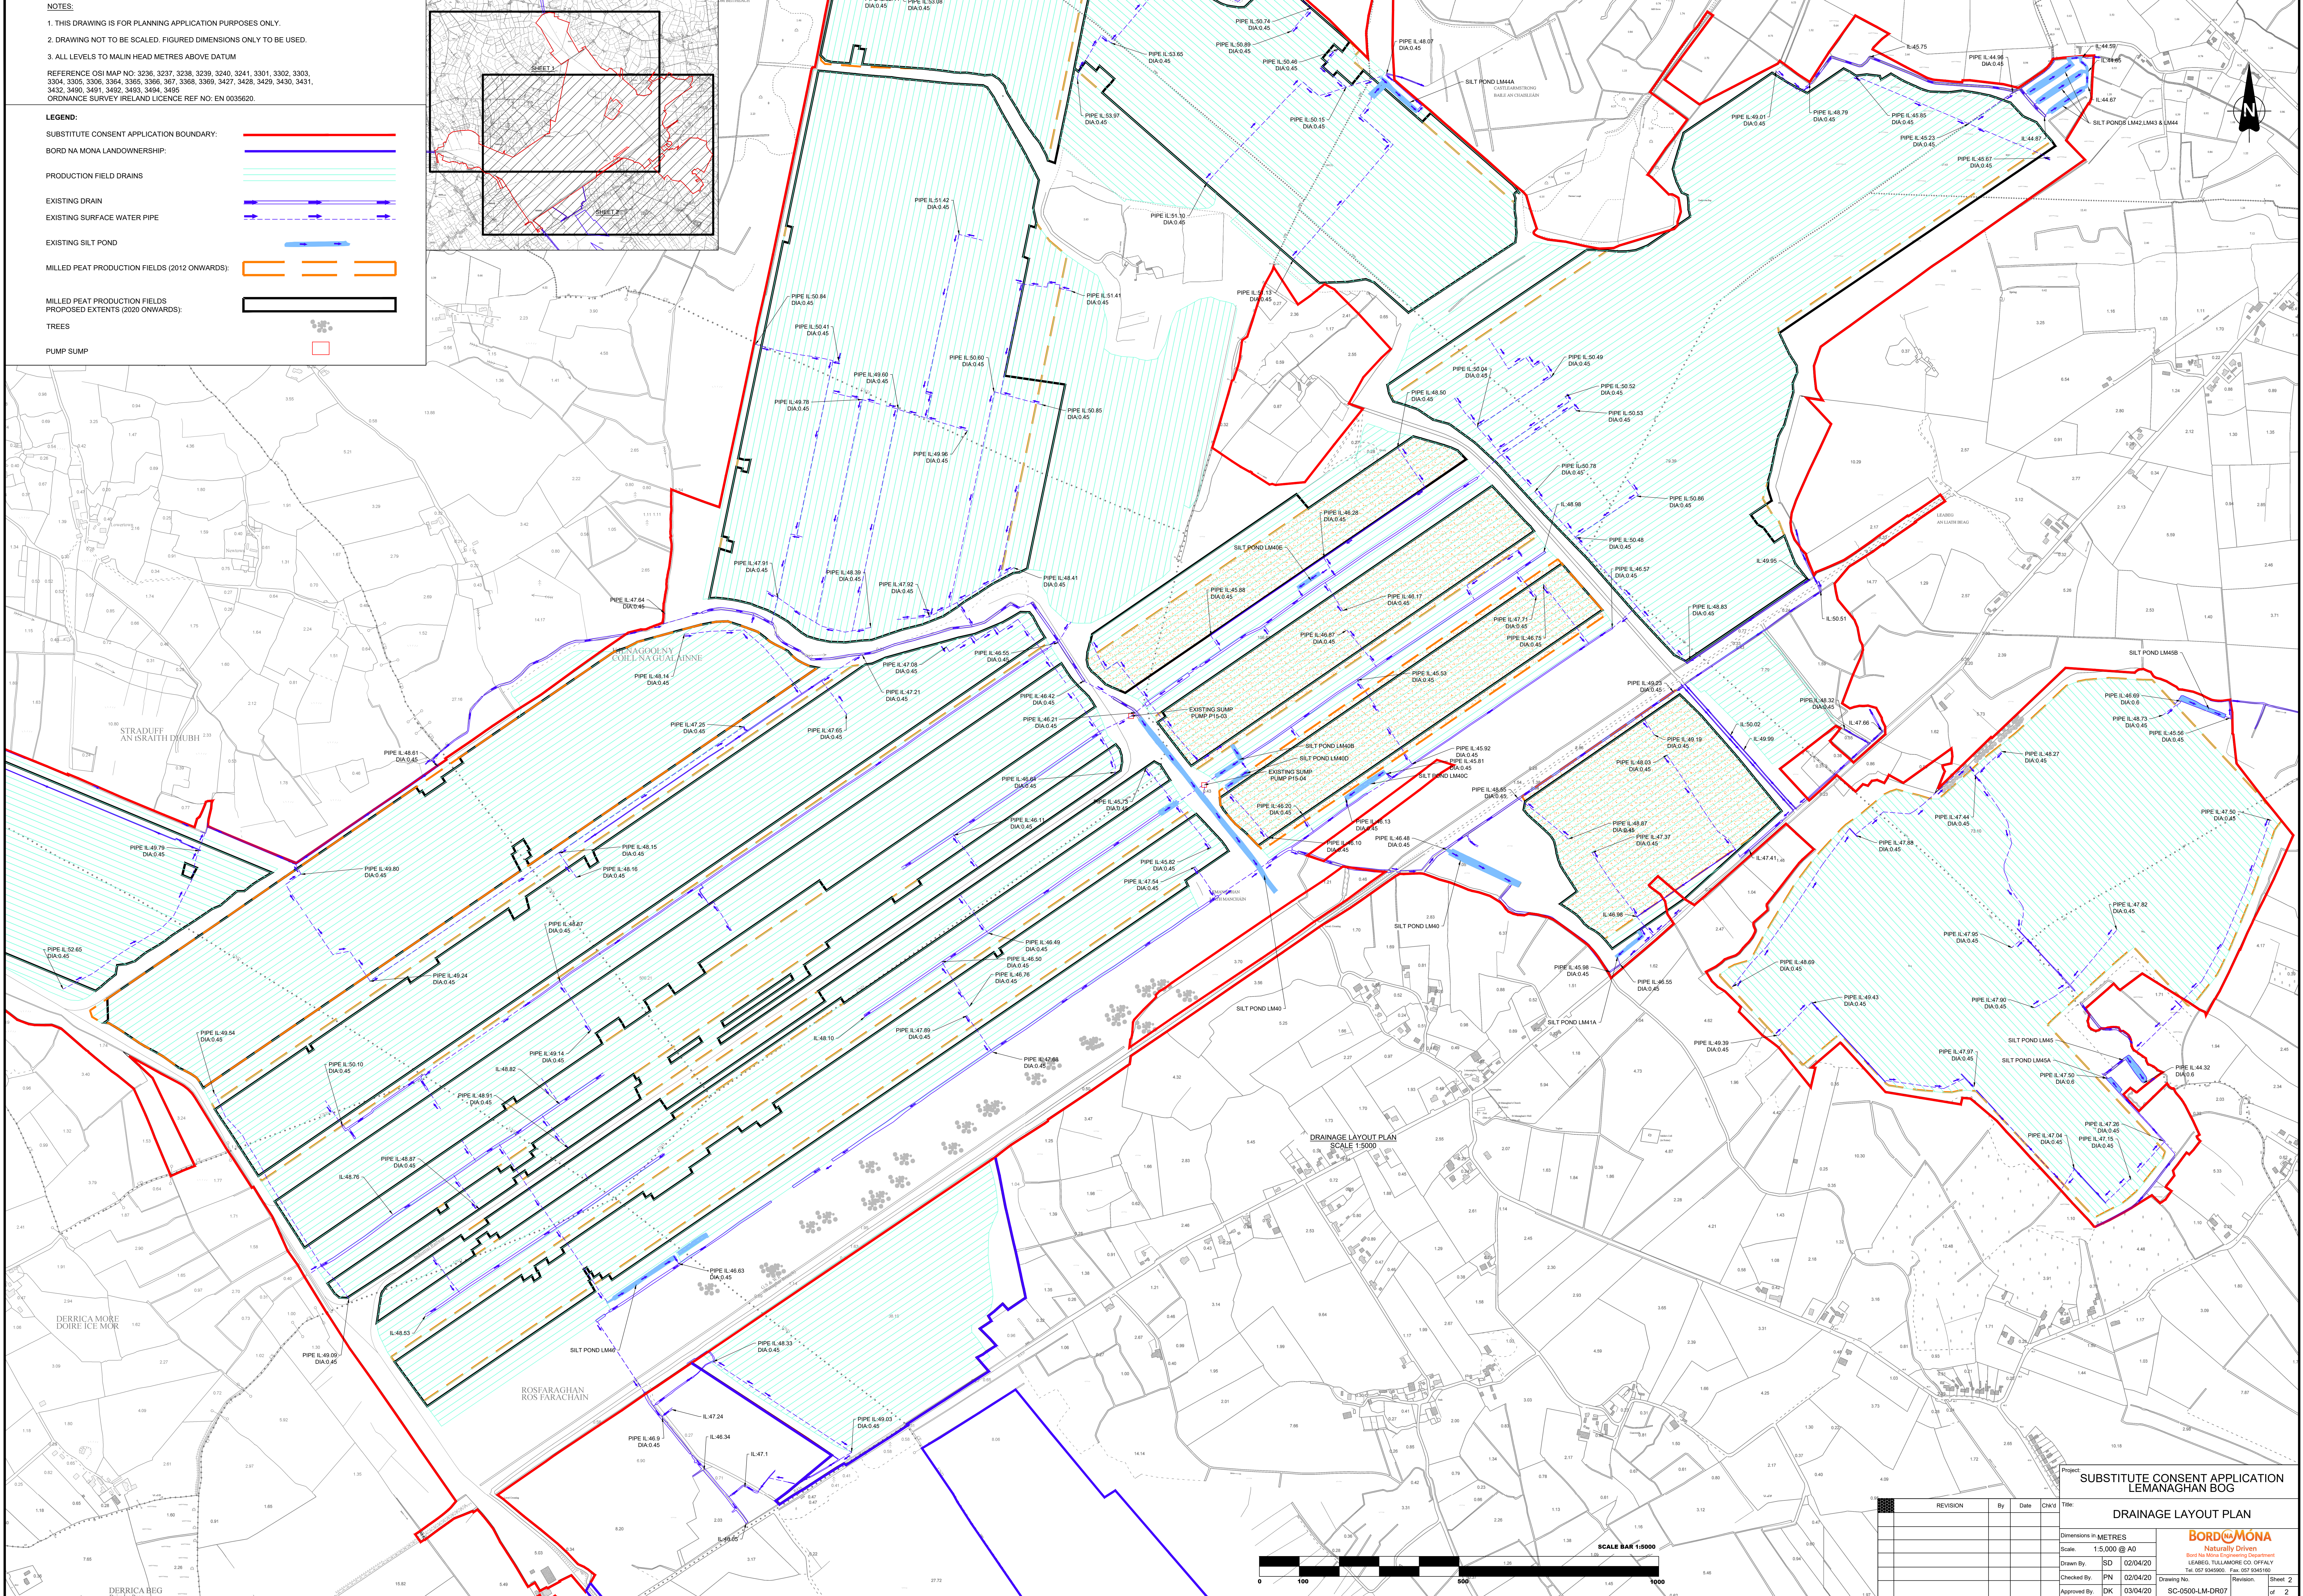


NOTES:
 1. THIS DRAWING IS FOR PLANNING APPLICATION PURPOSES ONLY.
 2. DRAWING NOT TO BE SCALED. FIGURED DIMENSIONS ONLY TO BE USED.
 3. ALL LEVELS TO MALIN HEAD METRES ABOVE DATUM
 REFERENCE OSI MAP NO: 3236, 3237, 3238, 3239, 3240, 3241, 3301, 3302, 3303, 3304, 3305, 3306, 3364, 3365, 3366, 367, 3368, 3369, 3427, 3428, 3429, 3430, 3431, 3432, 3430, 3491, 3492, 3493, 3494, 3495
 ORDANCE SURVEY IRELAND LICENCE REF NO: EN 0035620.

LEGEND:
 SUBSTITUTE CONSENT APPLICATION BOUNDARY:
 BORD NA MONA LANDOWNERSHIP:
 PRODUCTION FIELD DRAINS:
 EXISTING DRAIN:
 EXISTING SURFACE WATER PIPE:
 EXISTING SILT POND:
 MILLED PEAT PRODUCTION FIELDS (2012 ONWARDS):
 MILLED PEAT PRODUCTION FIELDS PROPOSED EXTENTS (2020 ONWARDS):
 TREES:
 PUMP SUMP:

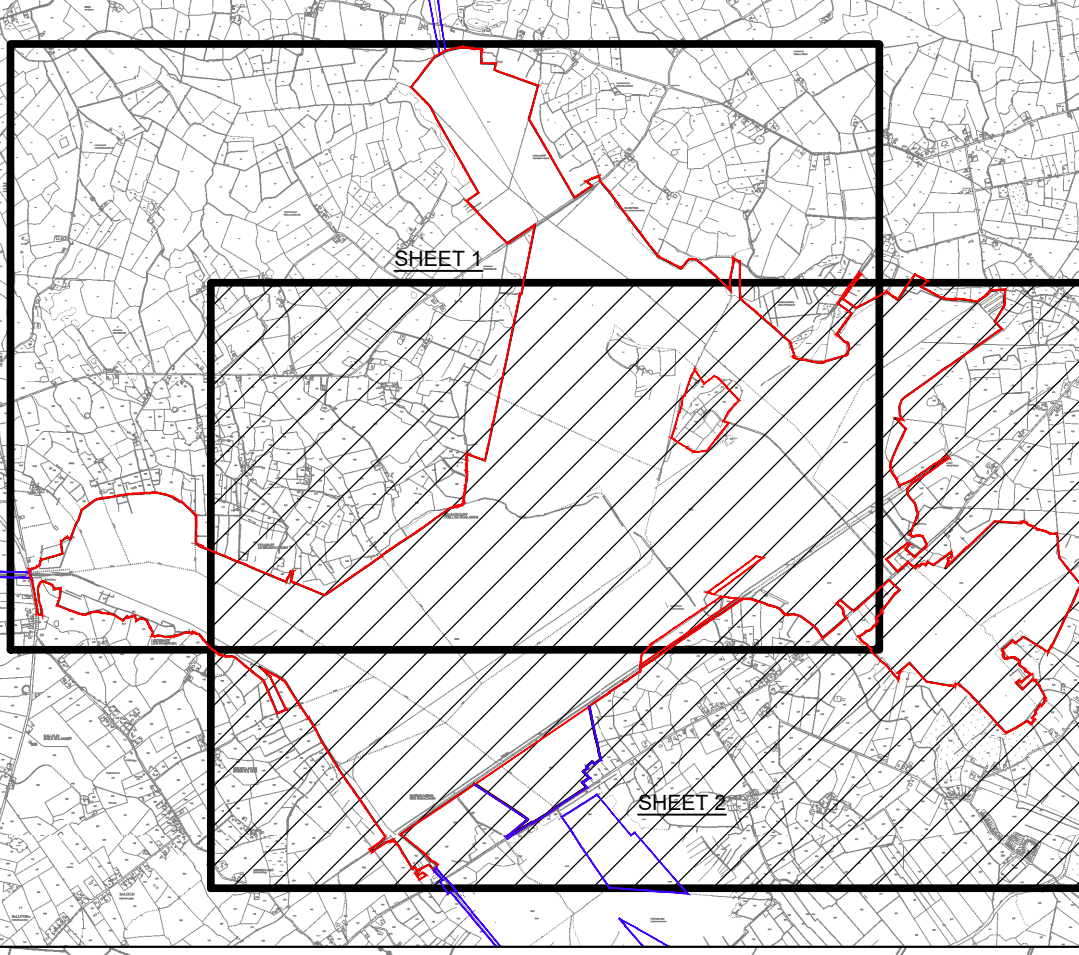

DRAINAGE LAYOUT PLAN
 SCALE 1:5000

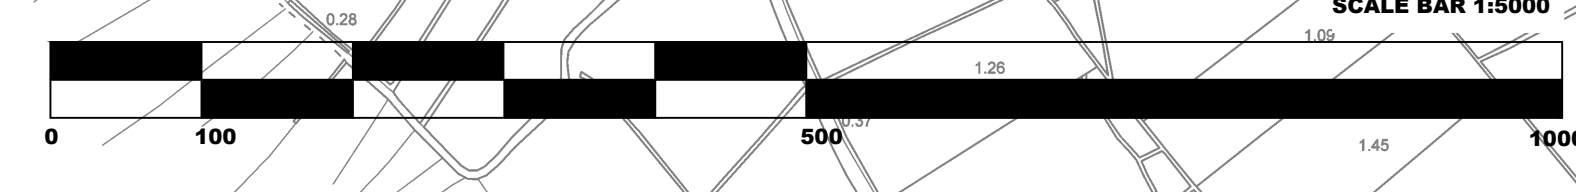

REVISION	By	Date	CHKD	Title

Project:	SUBSTITUTE CONSENT APPLICATION LEMANAGHAN BOG		
Drawn By:	SD	02/04/20	
Checked By:	PN	02/04/20	
Approved By:	DK	03/04/20	

Dimensions in METRES	Scale: 1:5,000 @ A2
Drawn By: SD	02/04/20
Checked By: PN	02/04/20
Approved By: DK	03/04/20

BORD NA MONA Naturally Driven Best to Grow Engineering Department LEASING, TULLAMORE CO. OFFICE Tel: 027 9345955 Fax: 027 9345160	
Drawing No:	SC-0500-LM-DR07
Revision:	2
Sheet:	2