
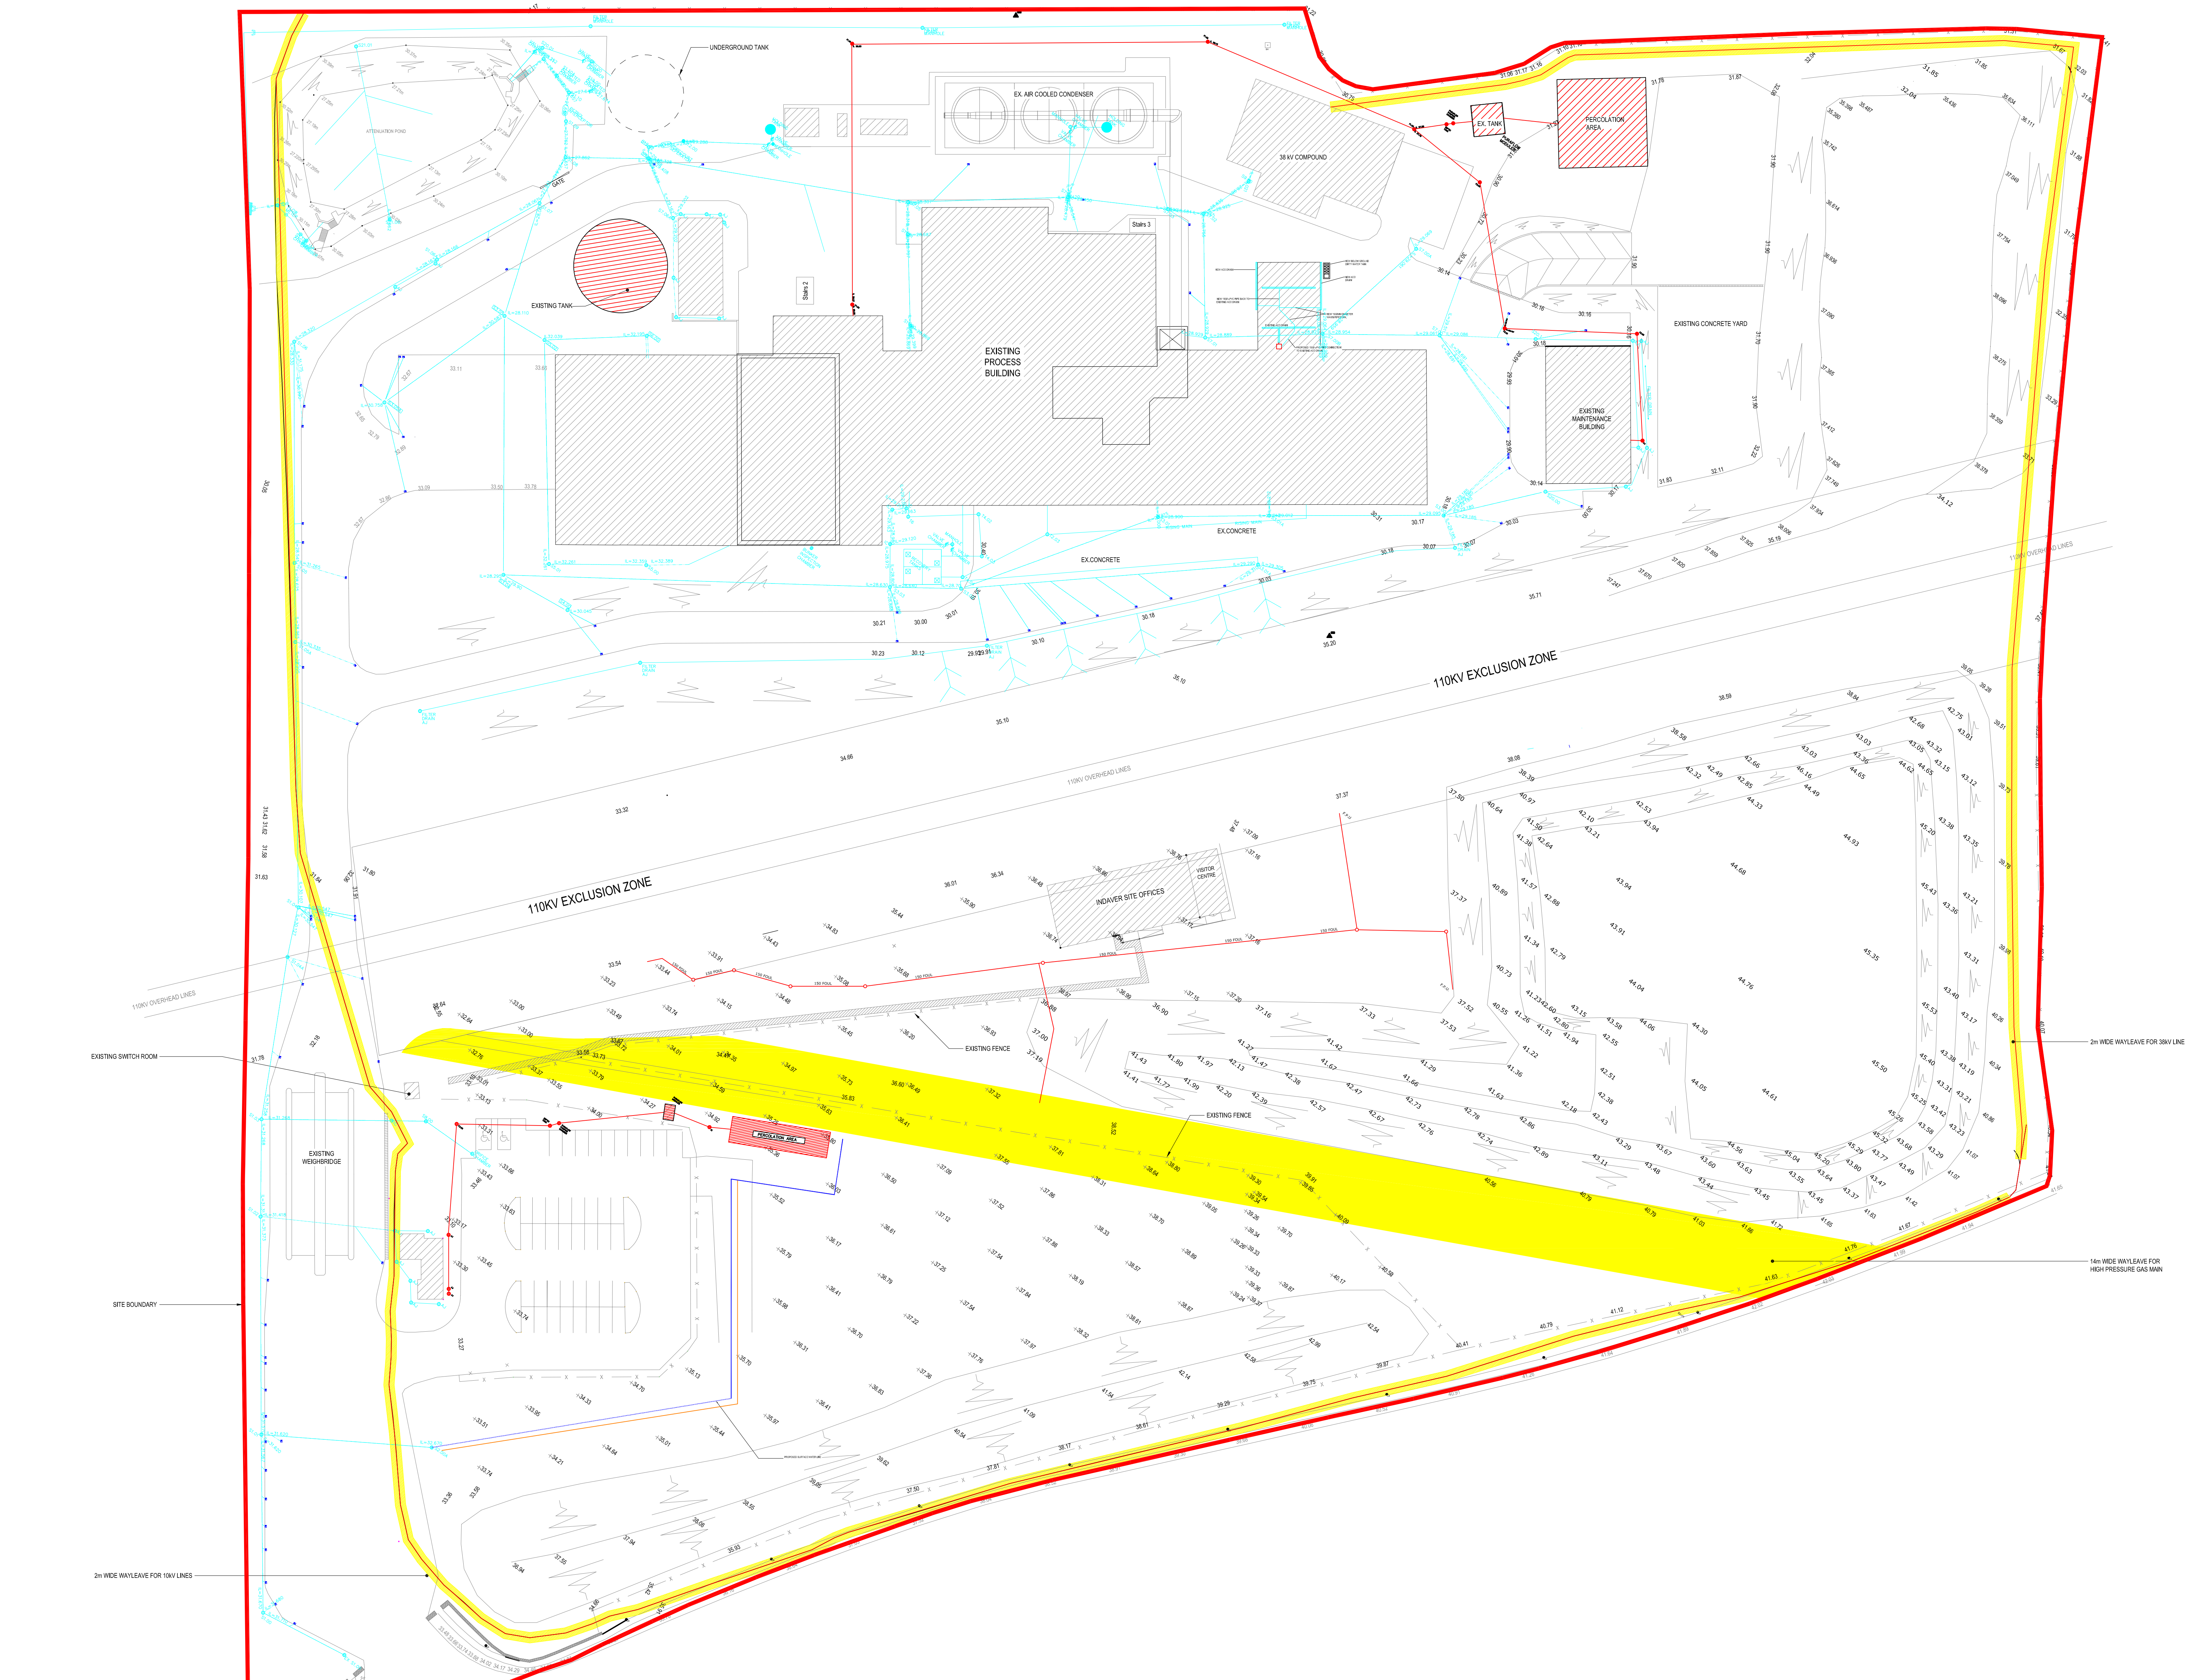


NOTES

- FOR STANDARD NOTES REFER TO DRAWING NO. 29043CD000.
- THIS DRAWING IS TO BE READ IN CONJUNCTION WITH ALL RELEVANT ARCHITECTURAL SERVICES & M.E.C.A. DRAWINGS.
- ALL DIMENSIONS ARE IN MILLIMETRES UNLESS OTHERWISE NOTED. LEVELS ARE STRUCTURAL LEVELS IN METRES TO ORDNANCE DATUM. THIS DRAWING MUST NOT BE SCALED.

LEGEND:

- DENOTES EXISTING WAYLEAVE
- SITE BOUNDARY
- EX. SURFACE WATER SWH (SHAW) & SK LINE
- A/C DRAIN
- GULLY
- EXISTING FOLL WATER LINE

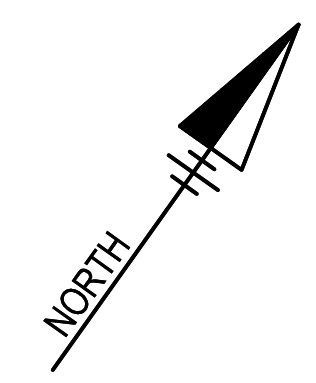

EXISTING DRAINAGE LAYOUT SCALE 1:500

REV.	DESCRIPTION	BY	APPR.	DATE
E	ISSUED FOR PLANNING	DS	JMD	19/05/20
D	REVISED AND REISSUED FOR PLANNING	DS	JMD	19/05/20
C	ISSUED FOR PLANNING	AD	NK	14/05/20
B	FOLA DRAINAGE REVIEW	BN	NK	29/11/19
A	ISSUED FOR COMMENT	DS	NK	22/11/19

THIS DOCUMENT IS THE PROPERTY OF M&E ASSOCIATES. THE DOCUMENT IS NOT TO BE REPRODUCED, COPIED OR QUOTED IN ANY MANNER WITHOUT THE WRITTEN PERMISSION OF M&E ASSOCIATES.

**M&E McElroy Associates**  
ENGINEERS TO INDUSTRY  
72 Hedding Road, Ballykeigh, Co. Wick. Tel: 060 9000 E Mail: info@m&e.ie www.m&e.ie

CLIENT: **INDAVER** INDAVER IRELAND  
INDAVER IRELAND  
INDAVER IRELAND  
INDAVER IRELAND  
INDAVER IRELAND  
INDAVER IRELAND  
INDAVER IRELAND  
INDAVER IRELAND

PROJECT: **SITE SUSTAINABILITY PROJECT**

TITLE: **EXISTING DRAINAGE LAYOUT**

DESIGNED:	CHECKED:	APPROVED:
JMD	JMD	NK
DATE:	DATE:	SCALE:
OCT 19		AS SHOWN @ A0
ORIGINAL:	29043/CD/001	REV: E