



IMPORTANT : It is the responsibility of the Contractor to check and agree with Frank Fox & Associates all levels, datum and reference points prior to commencement of contract. This drawing shall not be altered or copied without the consent of Frank Fox & Associates.

NOTES:

This drawing is not to be scaled:
Figured dimensions only are to be taken from this drawing.
All setting out dimensions are to be checked and confirmed on site prior to commencement of work.
Any discrepancies encountered to be brought to the attention of Frank Fox & Associates without delay.
IF IN DOUBT ASK.I

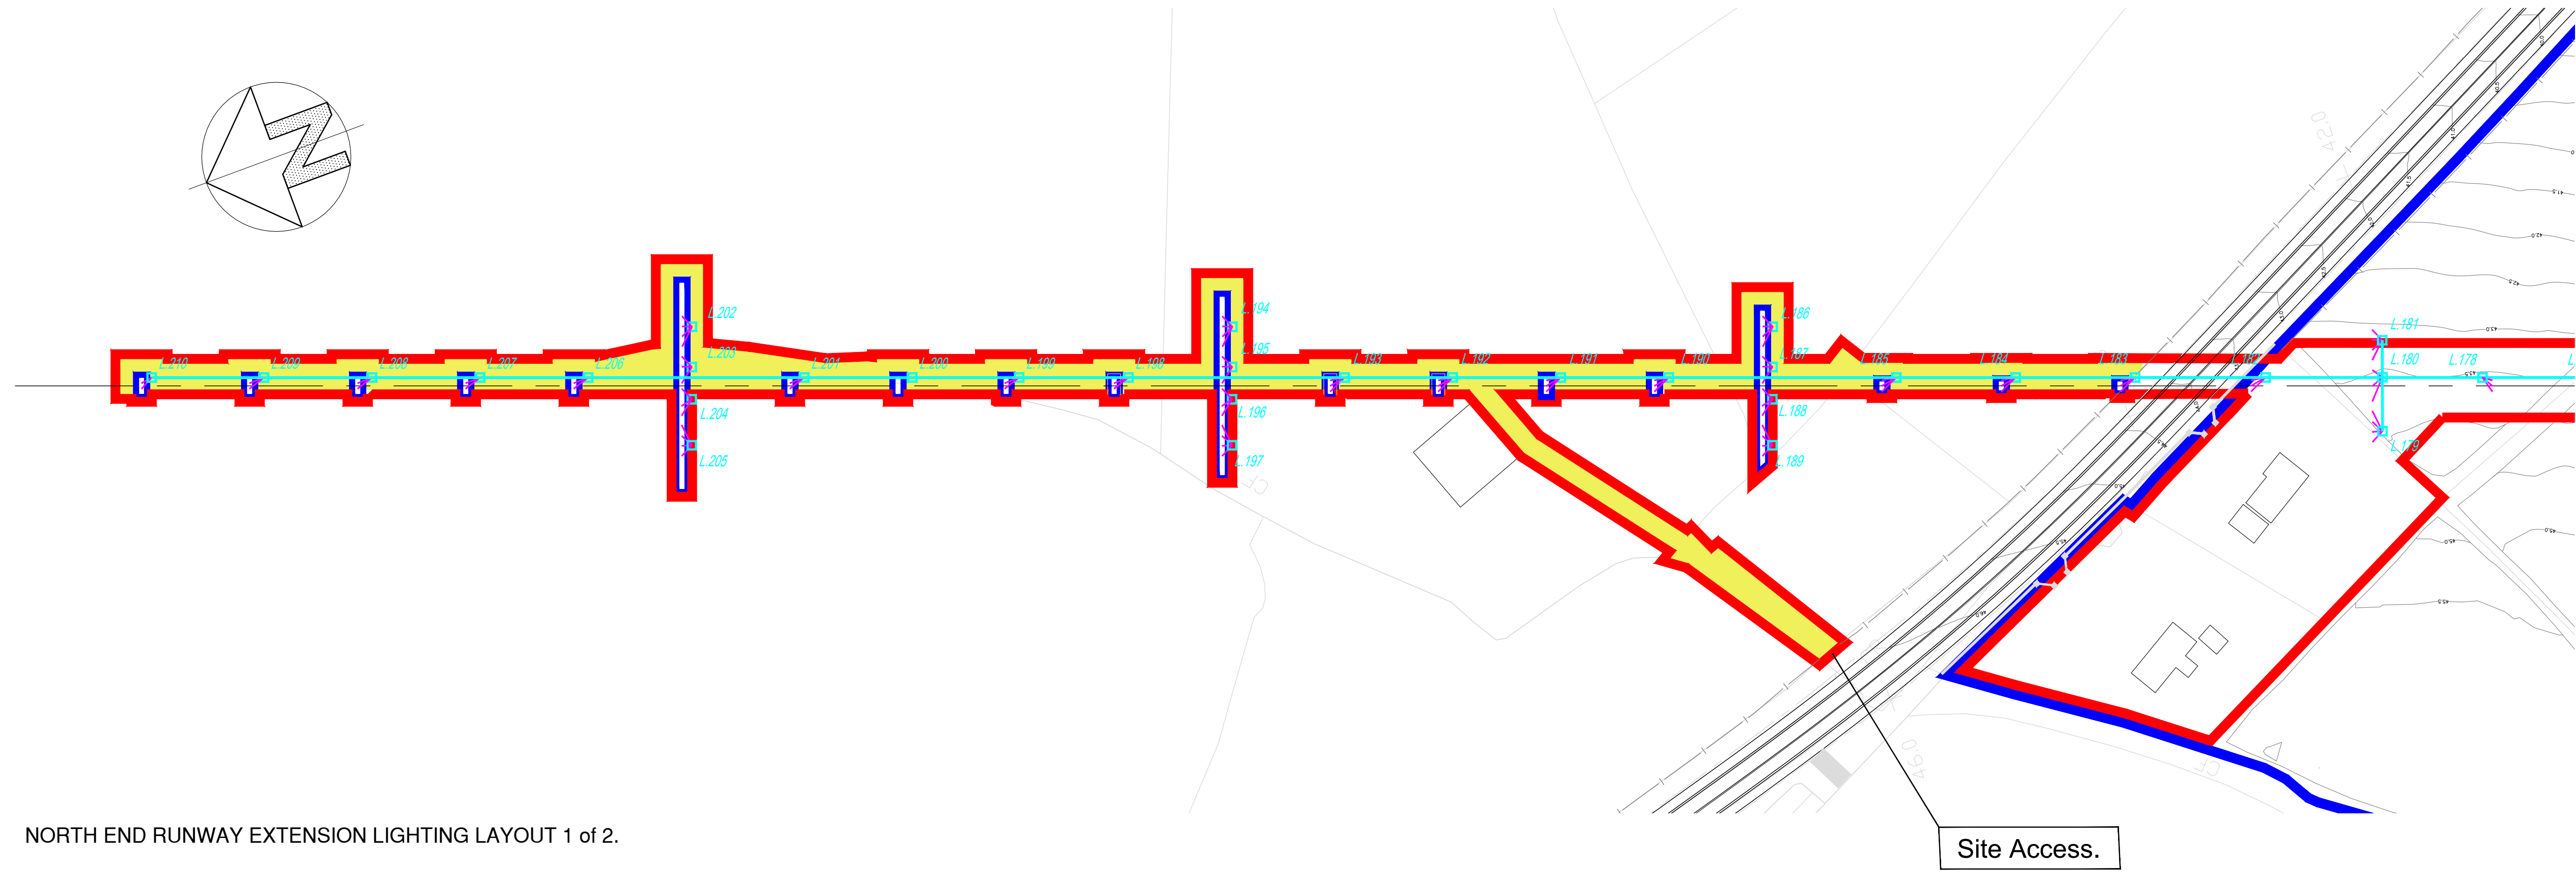

NORTH END RUNWAY EXTENSION LIGHTING LAYOUT 1 of 2.

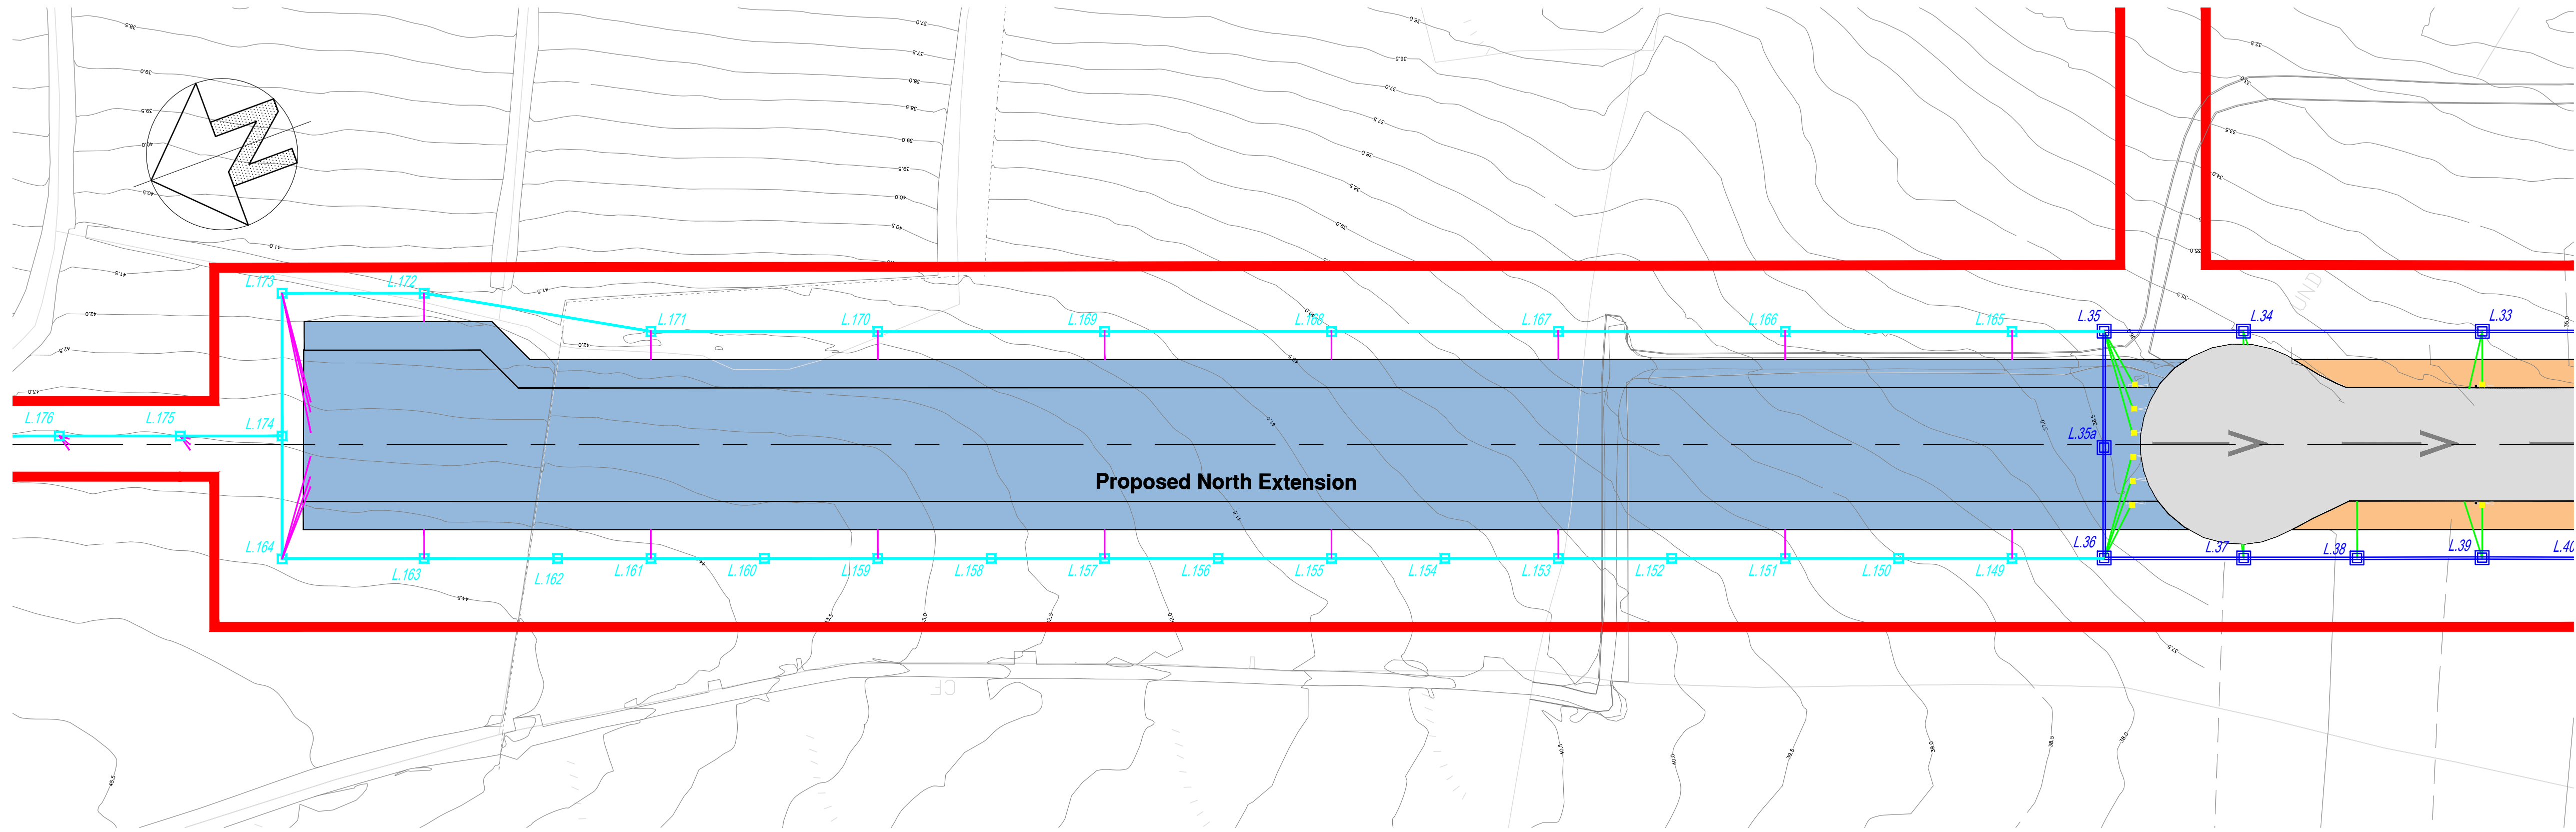

NORTH END RUNWAY EXTENSION LIGHTING LAYOUT 2 of 2.

KEY

- Ducts
- Ex Airfield Lighting
- Proposed Airfield Lighting
- Ex 63mm Secondary Duct
- Proposed 63mm Secondary Duct

Friday 10th JULY 2020
FOR PLANNING
THIS DRAWING IS NOT TO BE USED
FOR CONSTRUCTION PURPOSES

- SITE BOUNDARY
- OUTLINE OF LAND UNDER WATERFORD REGIONAL AIRPORT plc & WATERFORD CITY & COUNCIL CONTROL.

- KEY PLAN
- Existing Runway/Taxiway
 - Proposed Runway Extension
 - Proposed Runway Widening
 - Wayleave

REV	DESCRIPTION	BY	DATE
PROJECT TITLE			
WATERFORD AIRPORT. PROPOSED RUNWAY EXTENSION.			
DWG. TITLE			
RUNWAY LIGHTING LAYOUTS. SHEET 2.			
DRAWN S.Laaksonen	CHECKED F.Fox	DATE 11.07.2018	SCALE 1:2000 (A1)
PROJECT No. 218034		DWG. No. LP/02	REV

FRANK FOX & ASSOCIATES
CIVIL & STRUCTURAL CONSULTING ENGINEERS
7 BANK PLACE WATERFORD, IRELAND
TEL: 353-51-872799 Fax: 353-51-870626
Email: design@foeng.com