

IMPORTANT : It is the responsibility of the Contractor to check and agree with Frank Fox & Associates all levels, datum and reference points prior to commencement of contract. This drawing shall not be altered or copied without the consent of Frank Fox & Associates.

NOTES:

This drawing is not to be scaled:
Figured dimensions only are to be taken from this drawing.
All setting out dimensions are to be checked and confirmed on site prior to commencement of work.
Any discrepancies encountered to be brought to the attention of Frank Fox & Associates without delay.
IF IN DOUBT ASK.1

KEY


Ducts

Ex Airfield Lighting

Proposed Airfield Lighting

Ex 63mm Secondary Duct

Proposed 63mm Secondary Duct

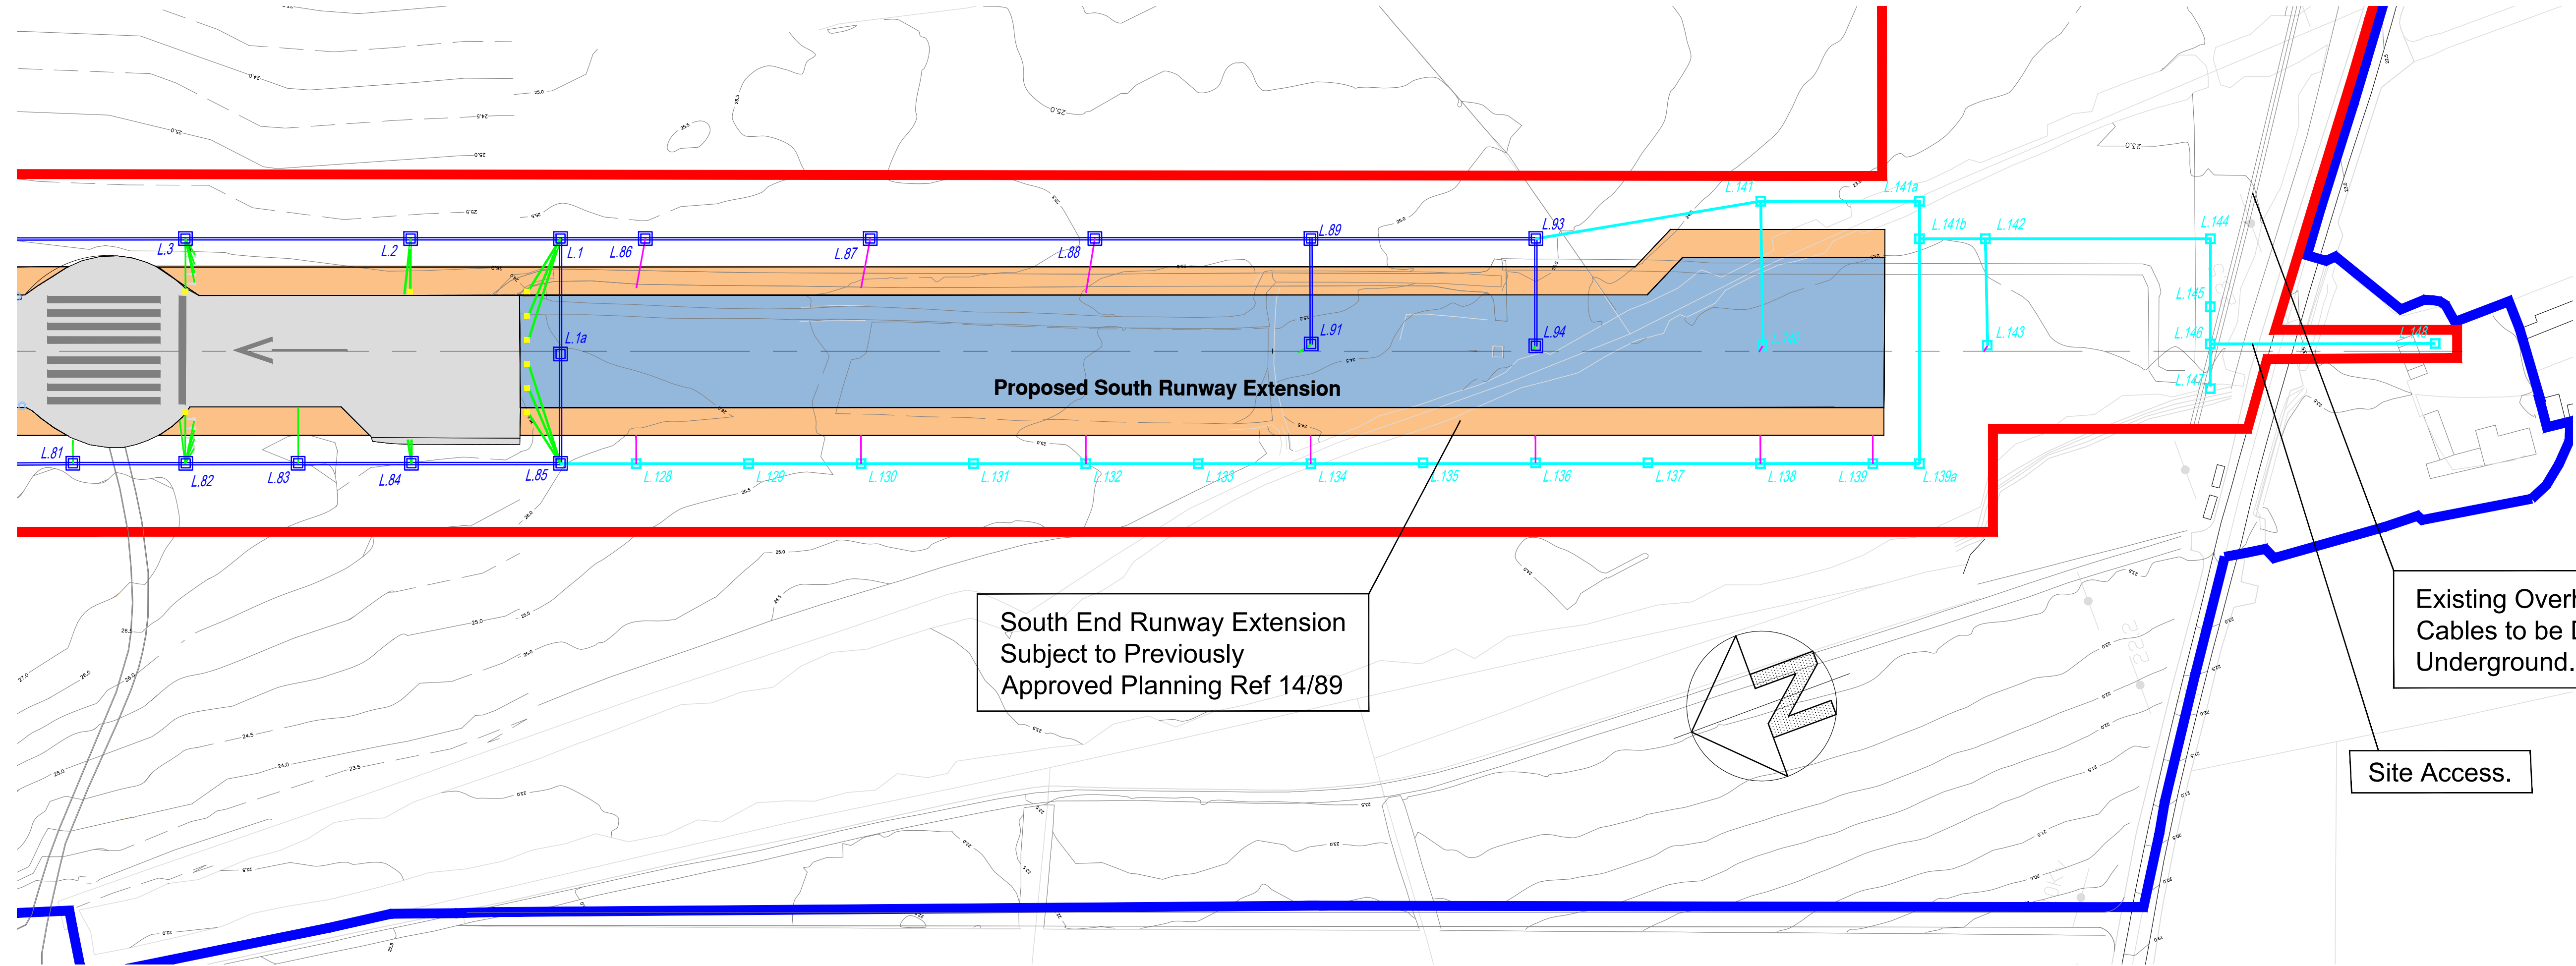

SOUTH END RUNWAY EXTENSION LIGHTING LAYOUT

KEY PLAN

- = Existing Runway/Taxiway
- = Proposed Runway Extension
- = Proposed Runway Widening
- = Wayleave

- SITE BOUNDARY
- OUTLINE OF LAND UNDER WATERFORD REGIONAL AIRPORT plc & WATERFORD CITY & COUNCIL CONTROL.



REV	DESCRIPTION	BY	DATE
PROJECT TITLE			
WATERFORD AIRPORT. PROPOSED RUNWAY EXTENSION.			
DWG. TITLE			
RUNWAY LIGHTING LAYOUT. SHEET 2.			
DRAWN S.Laaksonen	CHECKED F.Fox	DATE 11.07.2018	SCALE 1:2000 (A1)
PROJECT No. 218034		DWG. No. LP/03	CAD REF. plan
FRANK FOX & ASSOCIATES CIVIL & STRUCTURAL CONSULTING ENGINEERS 7 BANK PLACE WATERFORD, IRELAND TEL: 353-51-872799 Fax: 353-51-879626 Email: design@foeng.com			