


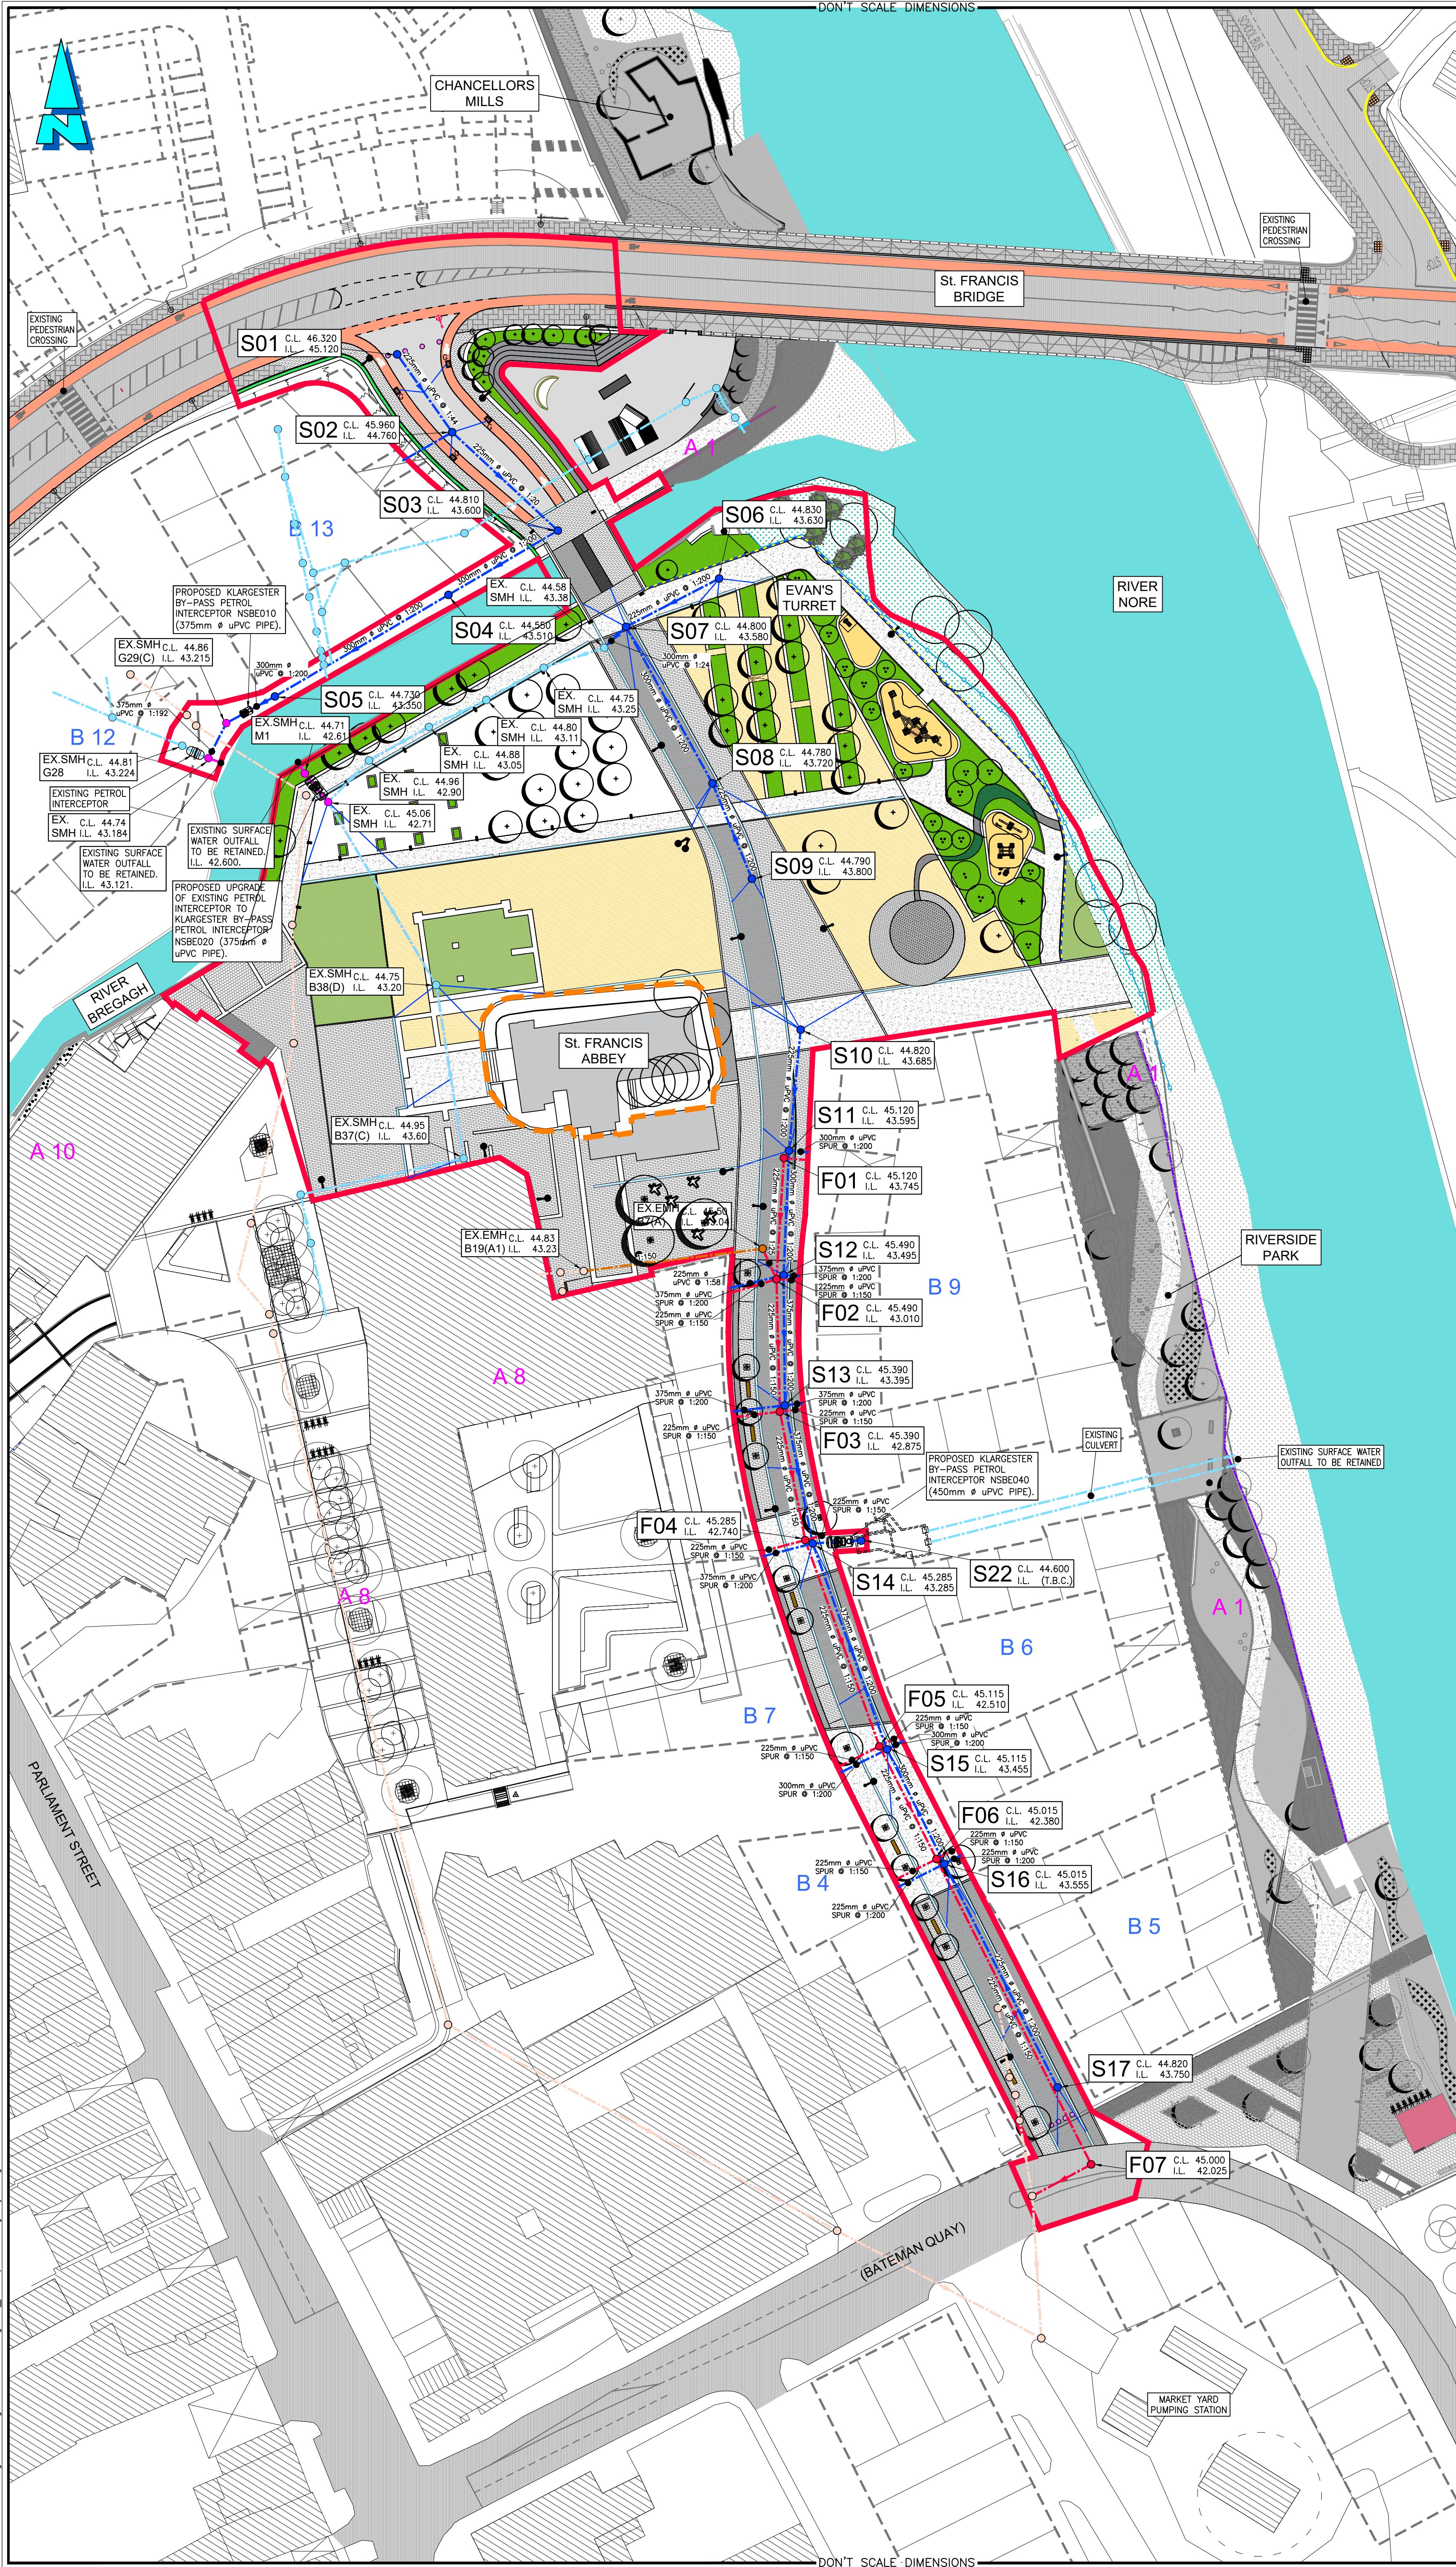

- Notes:**
- NO PART OF THIS DRAWING MAY BE REPRODUCED OR TRANSMITTED IN ANY FORM OR STORED IN ANY RETRIEVAL SYSTEM OF ANY NATURE WITHOUT THE WRITTEN PERMISSION OF MALONE O'REGAN CONSULTING ENGINEERS AS COPYRIGHT HOLDER EXCEPT AS AGREED FOR USE ON THE PROJECT FOR WHICH THE DRAWING WAS ORIGINALLY ISSUED.
 - THE APPOINTMENT OF THE PROJECT SUPERVISOR DESIGN PROCESS IS THE CLIENT'S RESPONSIBILITY.
 - ALL DIMENSIONS IN mm UNLESS NOTED OTHERWISE.
 - THE CONTRACTOR SHALL CHECK ALL DIMENSIONS PRIOR TO COMMENCEMENT OF CONSTRUCTION. DISCREPANCIES SHALL BE REPORTED TO THIS OFFICE IN WRITING.
 - THIS DRAWING TO BE READ IN ACCORDANCE WITH ALL RELEVANT ENGINEERS' DRAWINGS AND SPECIFICATIONS.

LEGEND

- PROPOSED PLANNING AREA (14,416m²)
- AREA EXCLUDED FROM PLANNING
- EXISTING SURFACE DRAIN
- EXISTING SURFACE DRAIN TO BE REPLACED
- PROPOSED SURFACE DRAIN
- PROPOSED ACO DRAIN WITH 150mm uPVC CONNECTION DRAIN
- PROPOSED LAND/FILTER DRAIN
- EXISTING FOUL DRAIN
- EXISTING FOUL DRAIN TO BE REPLACED
- PROPOSED FOUL DRAIN

REFER TO ARCHITECT'S DRAWINGS FOR PROPOSED SITE LEVELS AND PROPOSED SITE FINISHES

P	PLANNING ISSUE	24.07.2020	JD	PR	PR
Rev.	Description	Date	Drawn	Chkd	Appr.

THIS DRAWING TO BE USED FOR PLANNING PURPOSES ONLY

ADR
MALONE O'REGAN
CONSULTING ENGINEERS

3-4 Canada Street
Waterford
Co. Waterford.
X91 V52K
Tel: +353 51 876 855
Email: waterford@moroe.ie
Web: www.maloneoregan.com

Offices also in:
DUBLIN : Tel: +353 1 260 2655 Email: dublin@moroe.ie
GALWAY: Tel: +353 91 531 069 Email: galway@moroe.ie
LONDON: Tel: +44 208 5281685 Email: london@moroe.ie

Client KILKENNY COUNTY COUNCIL

Job ABBEY QUARTER URBAN PARK AND STREET

Drawing PROPOSED DRAINAGE LAYOUT

Job No	Dwg No	Stage	Revision	Scale
W14017	P812	PL	P	A1 1:500 A3 1:1000