


GREEN ROOF DETAILS

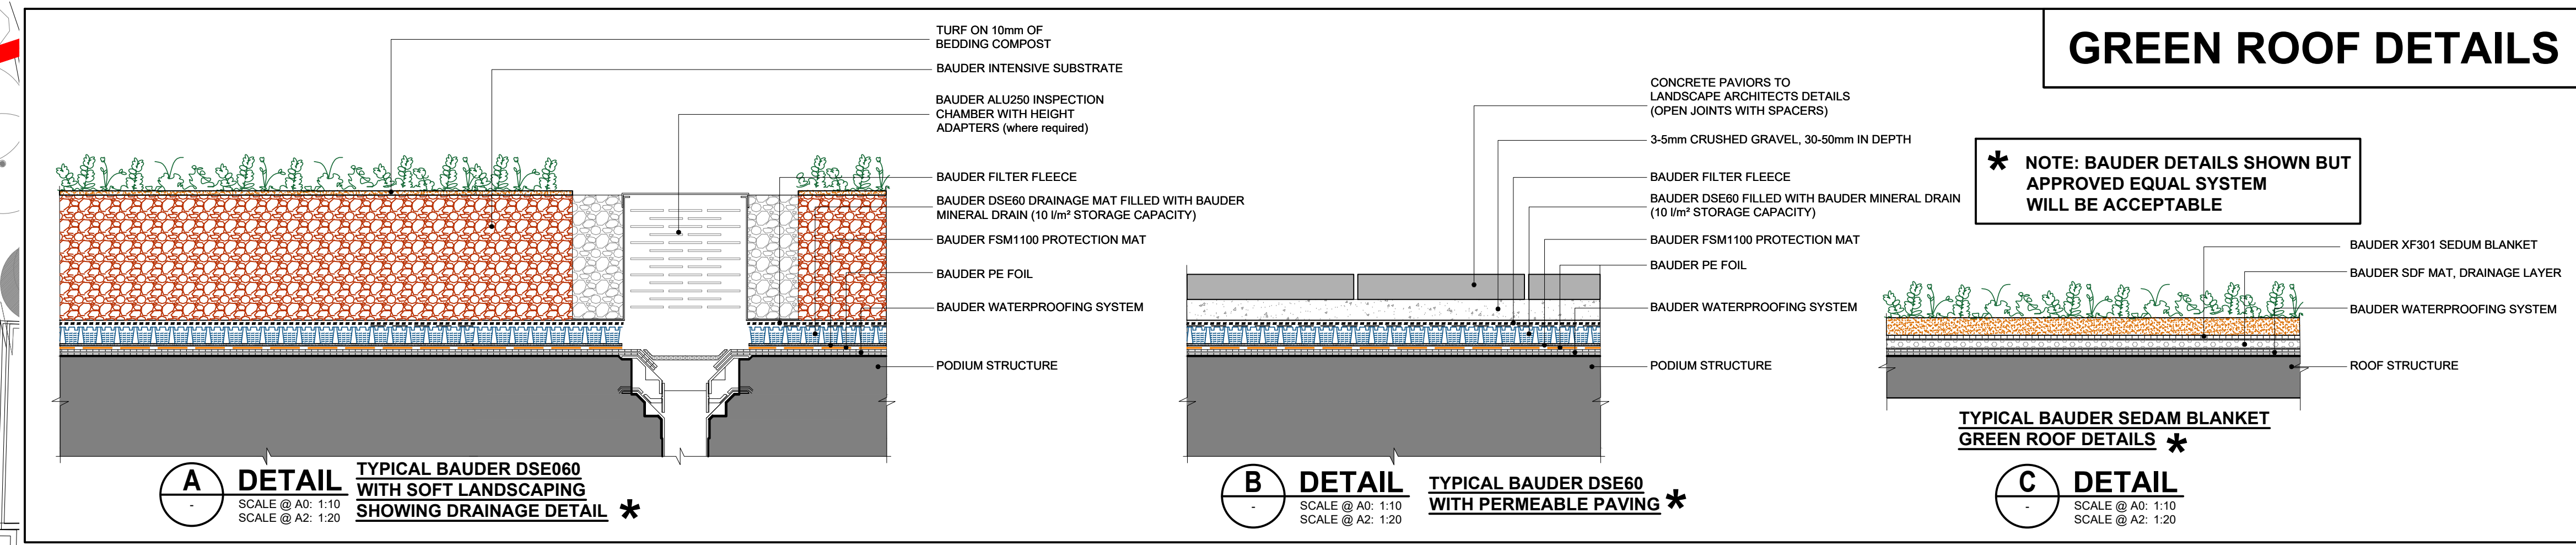

NOTES

- THIS DRAWING IS TO BE READ IN CONJUNCTION WITH ALL ENGINEERS & ARCHITECTS DRAWINGS & DIMENSIONS ONLY (NOT SCALING) TO BE USED. WHERE A CONFLICT OF INFORMATION EXISTS OR IF IN ANY DOUBT - ASK.
- CONSULTANTS TO BE INFORMED IMMEDIATELY OF ANY DISCREPANCIES BEFORE WORK PROCEEDS.

CIVIL LEGEND


EX. FOUL MANHOLE	Ex.F
EX. FOUL PIPE	PIPE DESCRIPTION
NEW FOUL MANHOLE	F
NEW FOUL PIPE	PIPE DESCRIPTION
EX. SURFACE WATER MANHOLE	Ex.S
EX. SURFACE WATER PIPE	PIPE DESCRIPTION
NEW SURFACE WATER MANHOLE	S
NEW SURFACE WATER PIPE	PIPE DESCRIPTION
EX. COMBINED MANHOLE	Ex.C
EX. COMBINED PIPE	PIPE DESCRIPTION
NEW COMBINED MANHOLE	C
NEW COMBINED PIPE	PIPE DESCRIPTION
NEW RISING MAIN	PIPE DESCRIPTION
PIPE CROSSOVER	PIPE DESCRIPTION
NEW ROOF RAIN WATER MANHOLE	R
NEW ROOF RAIN WATER PIPE	PIPE DESCRIPTION
EX. ROOF RAIN WATER MANHOLE	Ex.R
EX. ROOF RAIN WATER PIPE	PIPE DESCRIPTION
FOUL ACCESS JUNCTION	AJ
SURFACE ACCESS JUNCTION	AJ
RAINWATER PIPE	RWP
SOIL VENT PIPE	SV
ROAD GULLY	G
BACK INLET GULLY TRAP	BIGT
FOUL RODDING EYE	RE
SURFACE RODDING EYE	RE
GULLY TRAP	GT
PIPE DROP TO LEVEL BELOW	PD
EX. WATERMAIN	Ex.W
WATERMAIN	W
SLUICE VALVE	SV
STOP COCK	SC
AIR VALVE	AV
FIRE HYDRANT	H
MAGNETIC FLOW WATER METER	M
IRRIGATION VALVE	I
THRUST BLOCK	TB

LEGEND

GREEN ROOF - EXTENSIVE SEDUM ROOF	INTENSIVE GREEN ROOF
INTERCEPTION STORAGE 120l/m ²	INTERCEPTION STORAGE 120l/m ²
GREEN ROOF - LANDSCAPED COURTYARD	HARD & SOFT LANDSCAPING
INTERCEPTION STORAGE 120l/m ²	INTERCEPTION STORAGE 120l/m ²
FLAT ROOF WITH MAZE PLANT ENCLOSURES	

OUTLINE OF SITE TO WHICH APPLICATION RELATES

EXTENT OF PROPOSED PHASE 1 & PHASE 2 DEVELOPMENT

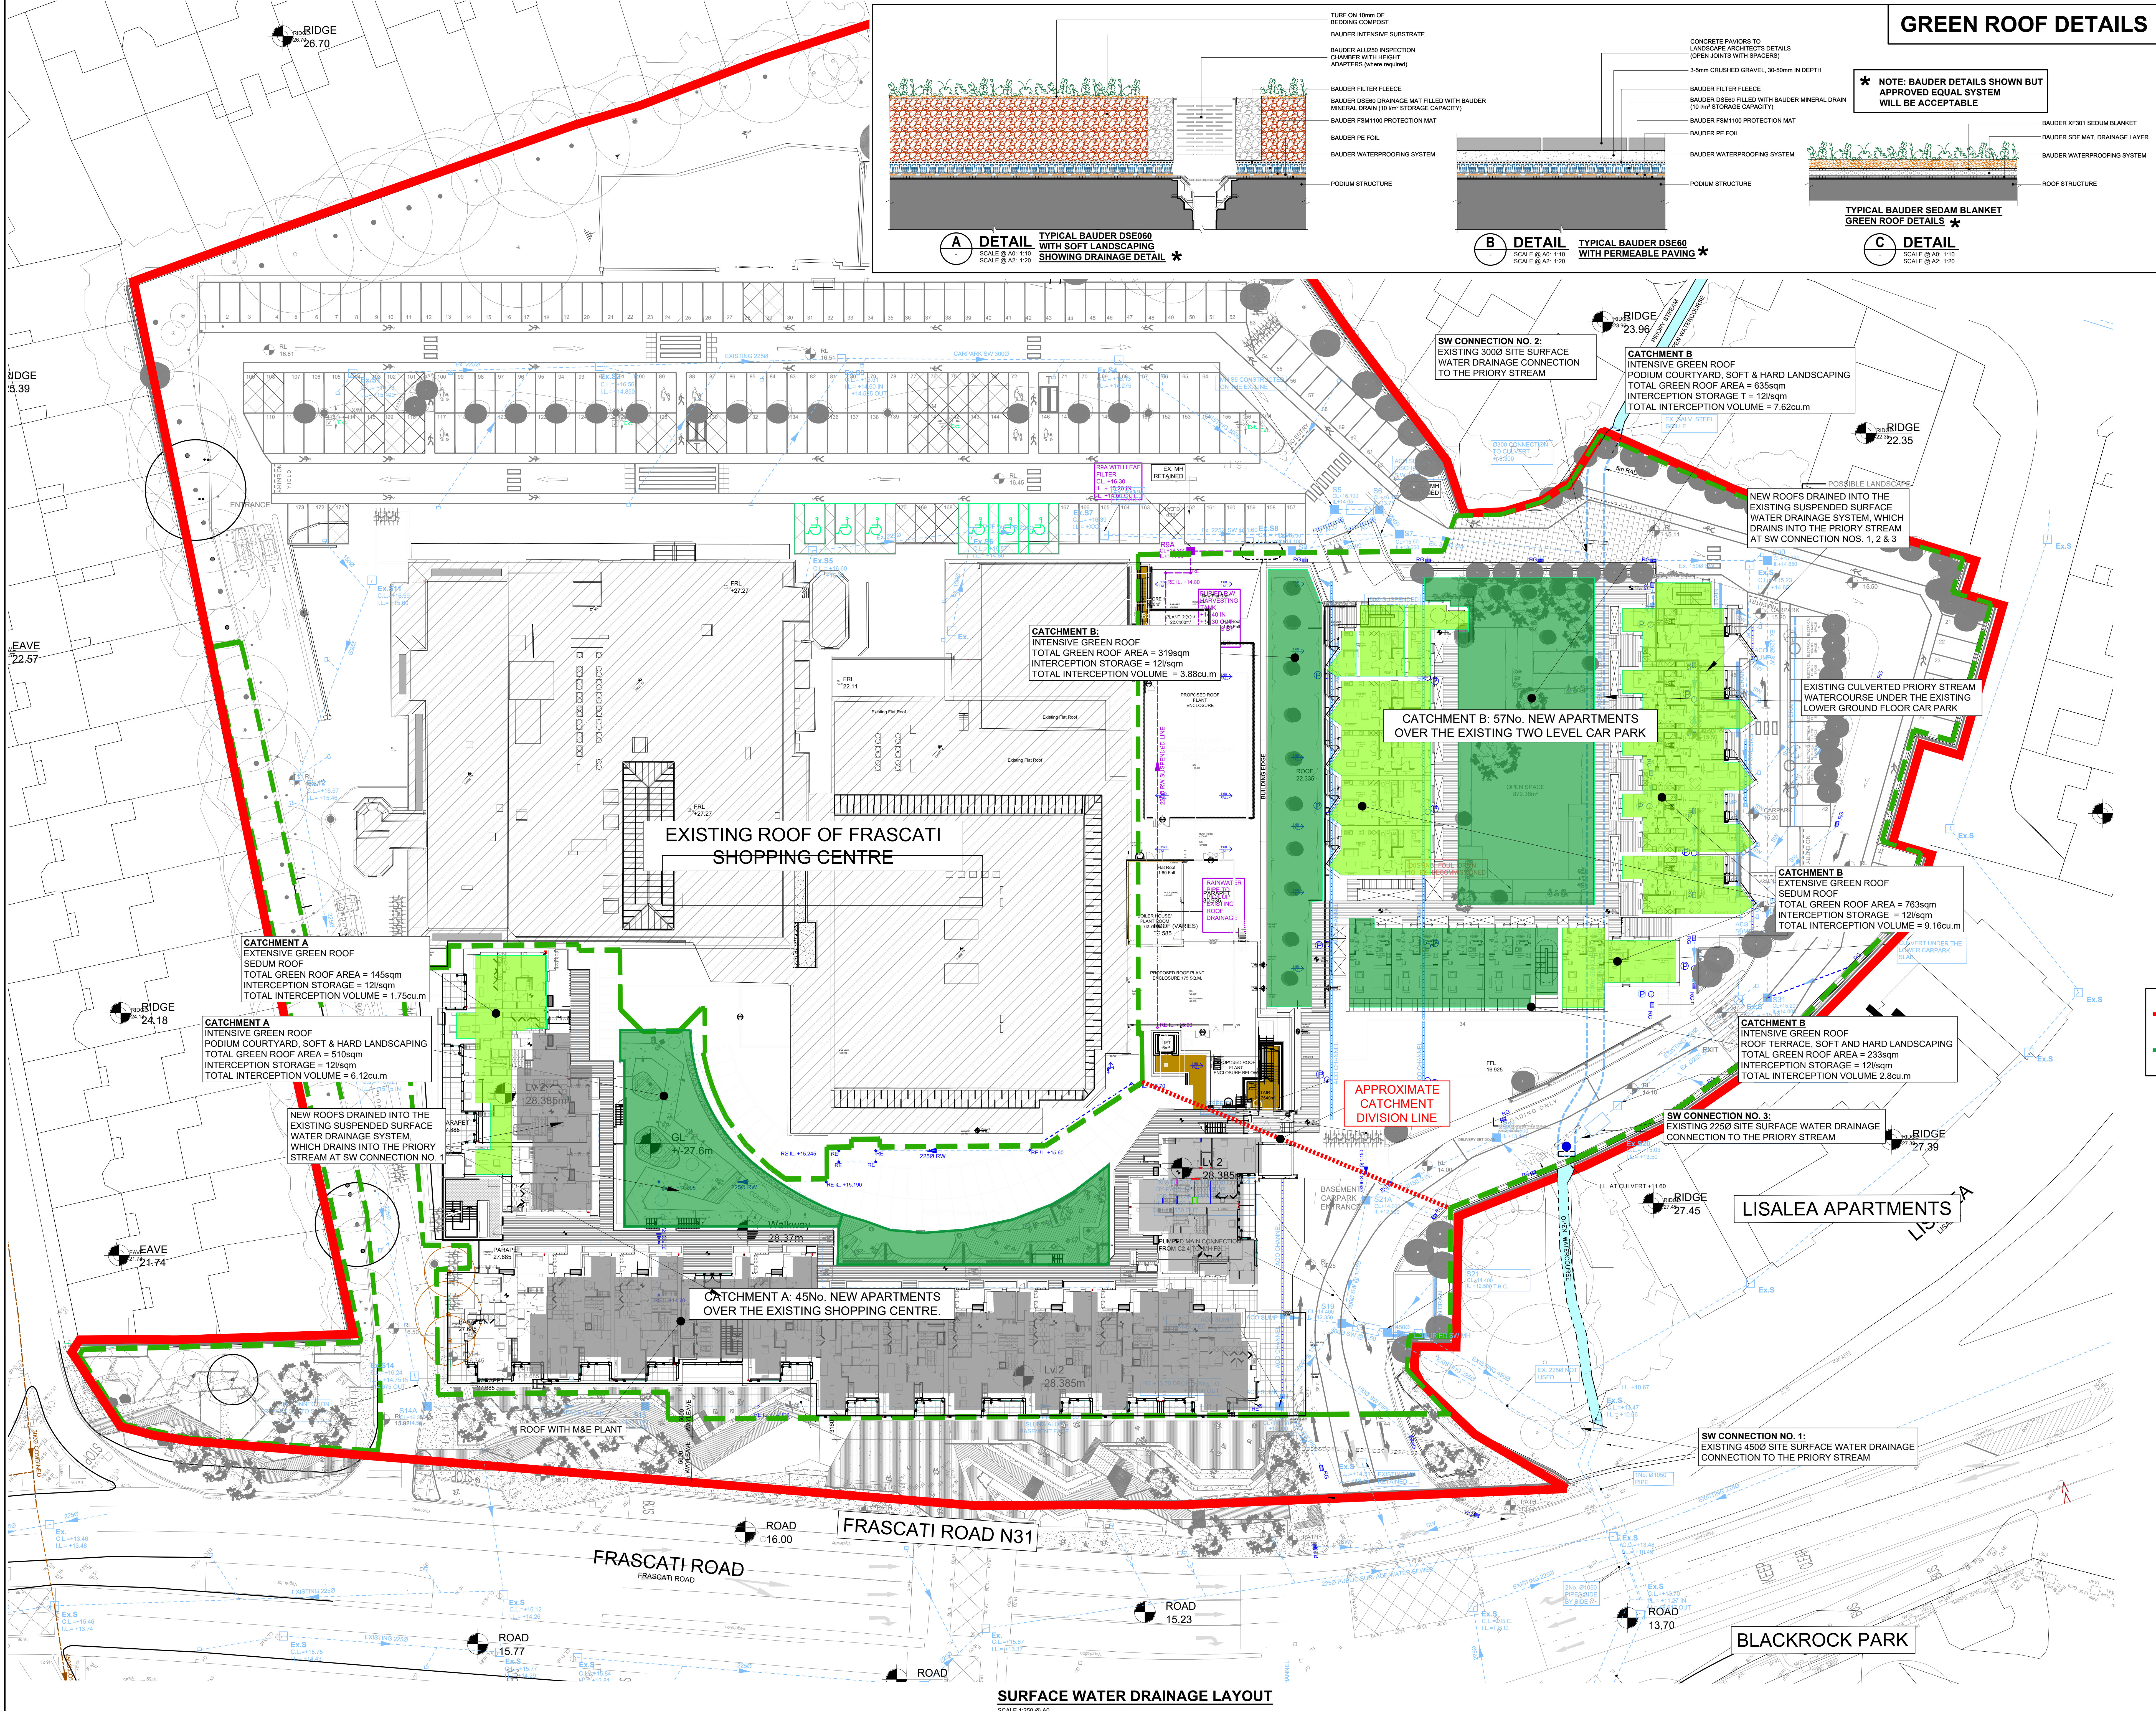

SURFACE WATER DRAINAGE LAYOUT
SCALE: 1:250 @ A0

PL4	17.08.20	PLANNING ISSUE	PL4
PL3	12.08.20	PLANNING ISSUE	PL3
PL2	24.06.20	PLANNING ISSUE	PL2
PL1	16.03.20	PLANNING ISSUE	PL1
P1	14.02.20	PRELIMINARY ISSUE	P1

ISSUE	DATE	DESCRIPTION	APPROVED BY
PRELIMINARY (P1, P2, P3 etc.)			
TENDER (T1, T2, T3 etc.)			
PLANNING (PL1, PL2, PL3 etc.)			
FOR CONSTRUCTION (C1, C2 etc.)			

BM
Dorset masonry
Construction Services, Civil, Structural & Project Management, E-mail: info@bm.co.uk, Web: www.bm.co.uk

CLIENT: **IMRF II FRASCATI PARTNERSHIP**

PROJECT TITLE: **FRASCATI RESIDENTIAL PHASE II**

DRAWING TITLE: **SURFACE WATER DRAINAGE LAYOUT**

PROJECT NO: **19248** | DRAWING NO: **C1001** | ISSUE: **PL4** | STATUS: **PLANNING**