
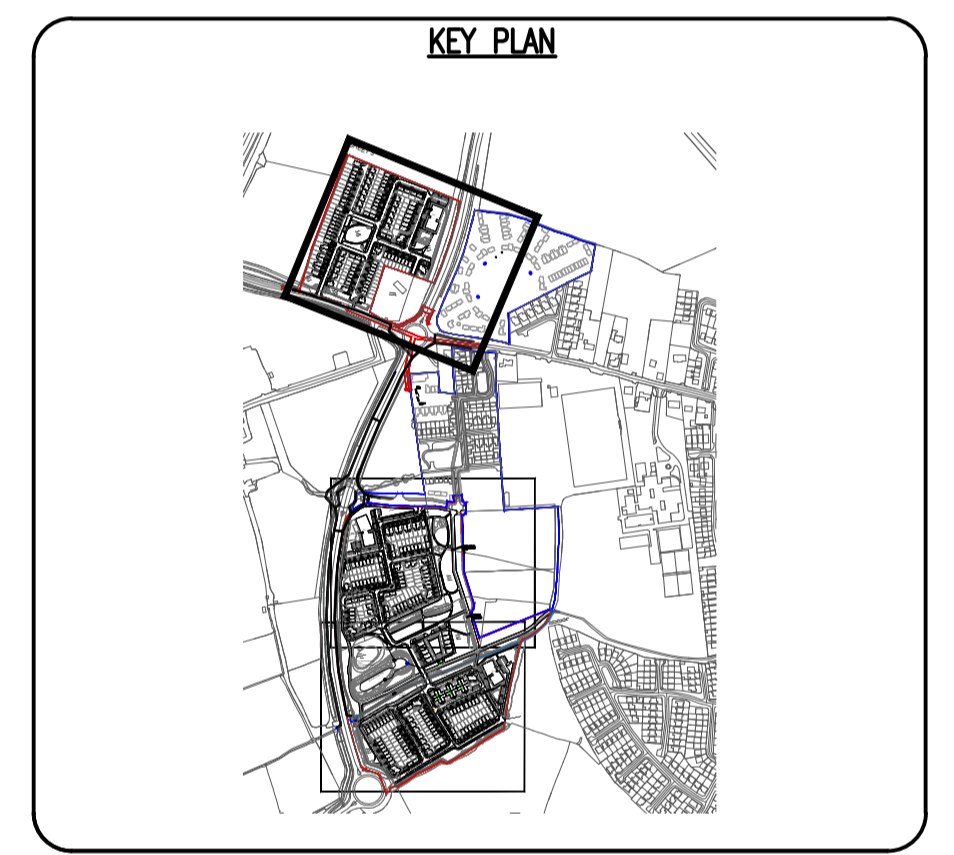


- NOTES:
1. DO NOT SCALE. USE FIGURED DIMENSIONS ONLY.
 2. THIS DRAWING IS TO BE READ IN CONJUNCTION WITH ALL OTHER RELEVANT ARCHITECTURAL AND ENGINEERING DRAWINGS.
 3. IT IS THE CONTRACTORS RESPONSIBILITY TO ENSURE THAT ALL WORKS ARE CONSTRUCTED IN ACCORDANCE WITH THE IRISH WATER CODE OF PRACTICE AND STANDARD DETAILS. THE CODE OF PRACTICE AND STANDARD DETAILS ARE AVAILABLE TO DOWNLOAD FROM THE IRISH WATER WEB SITE AT WWW.WATER.IE/CONNECTIONS/DEVELOPER-SERVICES/ WHERE THE DETAILS CONTAINED ON THIS DRAWING DIFFER FROM THE IRISH WATER CODE OF PRACTICE OR STANDARD DETAILS THIS MUST BE BROUGHT TO THE ATTENTION OF THE ENGINEER IMMEDIATELY. IRISH WATER STANDARDS WILL TAKE PRECEDENCE.

LEGEND

	SITE BOUNDARY PHASE 2
	SITE BOUNDARY PHASE 1 APPROVED DEVELOPMENT ABP REF. PL17.241988 UNDER CONSTRUCTION
	EXISTING SURFACE WATER SEWER WITH PIPE SIZE, GRADE, MANHOLE REF. AND INVERT LEVEL
	EXISTING FOUL WATER SEWER WITH PIPE SIZE, GRADE, MANHOLE REF. AND INVERT LEVEL
	PROPOSED SURFACE WATER SEWER WITH PIPE SIZE, GRADE, MANHOLE REF. AND INVERT LEVEL
	PROPOSED FOUL WATER SEWER WITH PIPE SIZE, GRADE, MANHOLE REF. AND INVERT LEVEL

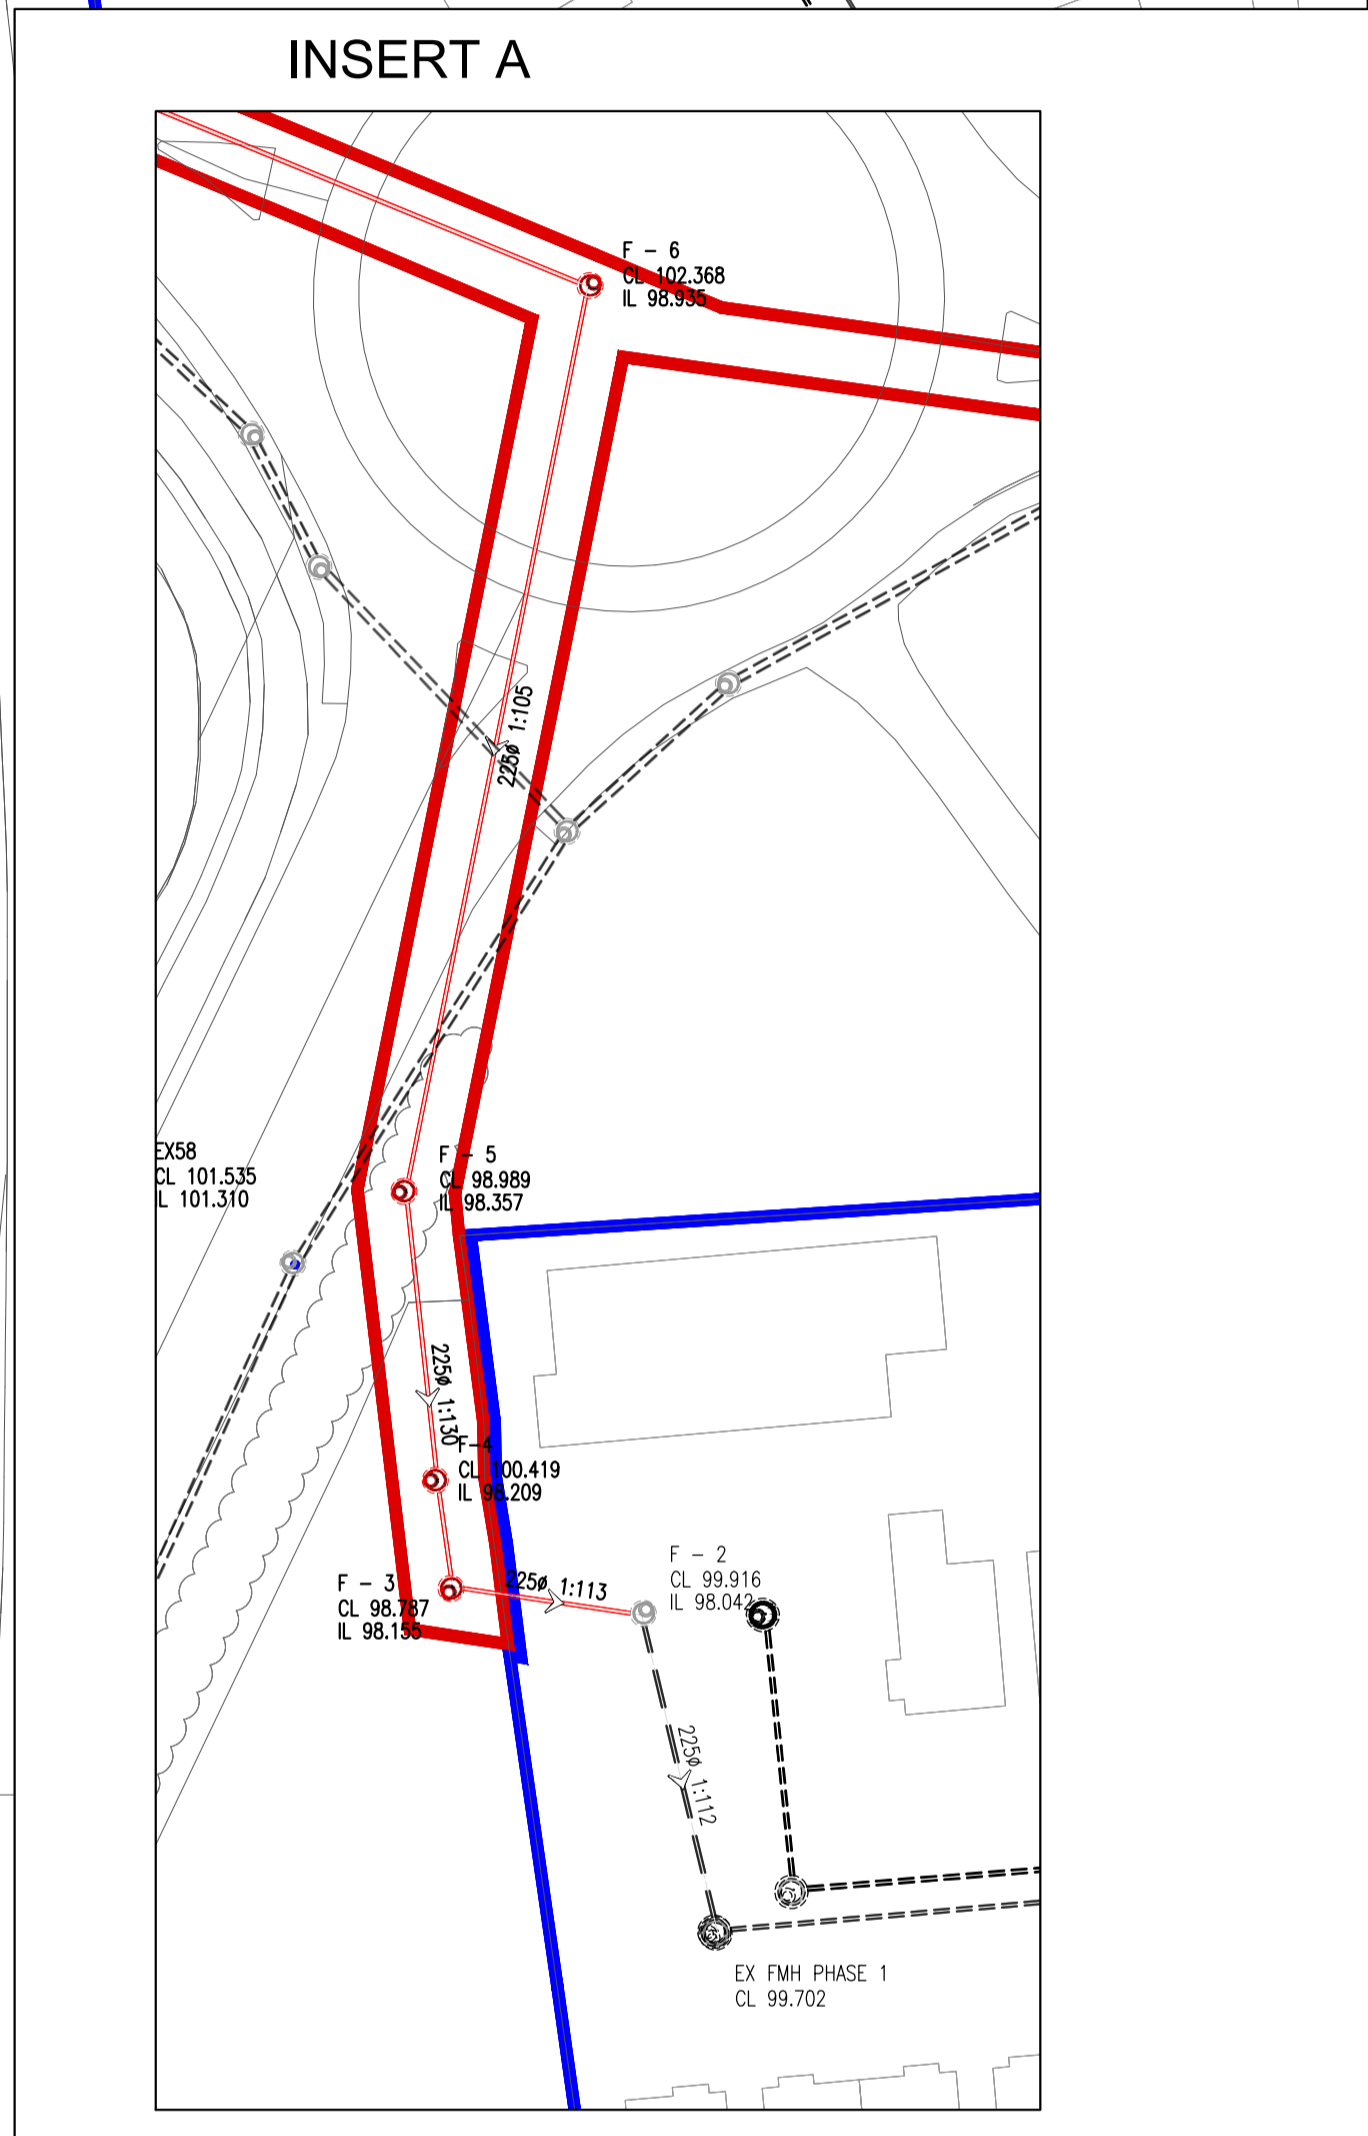

Ordnance Survey Ireland Licence No. EN 0006020
© Ordnance Survey Ireland/Government of Ireland.

REV.	DATE	AMENDMENT	DRN	APPD
A	02/10/20	SHD APPLICATION ISSUE	MK	IS
~	18/03/20	SHD PRE-APPLICATION ISSUE	MK	IS

STATUS **FOR SHD APPLICATION**

Waterman Moylan
Engineering Consultants

BLOCK 5, EASTPOINT BUSINESS PARK, ALFIE BYRNE ROAD, DUBLIN D03 H3F4 IRELAND. Tel: (01) 664 8900
Email: info@waterman-moylan.ie www.waterman-moylan.ie

CLIENT	CASTELTHORN CONSTRUCTION ULC
ARCHITECT	O'MAHONY PIKE ARCHITECTS
PROJECT	PROPOSED PHASE 2 RESIDENTIAL DEVELOPMENT AT DUNSHAUGHLIN, CO. MEATH
TITLE	DRAINAGE LAYOUT SHEET 3 OF 3

DRAWN	DESIGNED	APPROVED	DATE
MK	KV	IS	MARCH 2020
SCALE	JOB NO.	DRG. NO.	REVISION
1:500 @ A1	12-081A	P213	A

CONNECTION TO EXISTING FILTER DRAINS AS DISCUSSED ON SITE WITH MEATH CC.

SEE INSERT A