


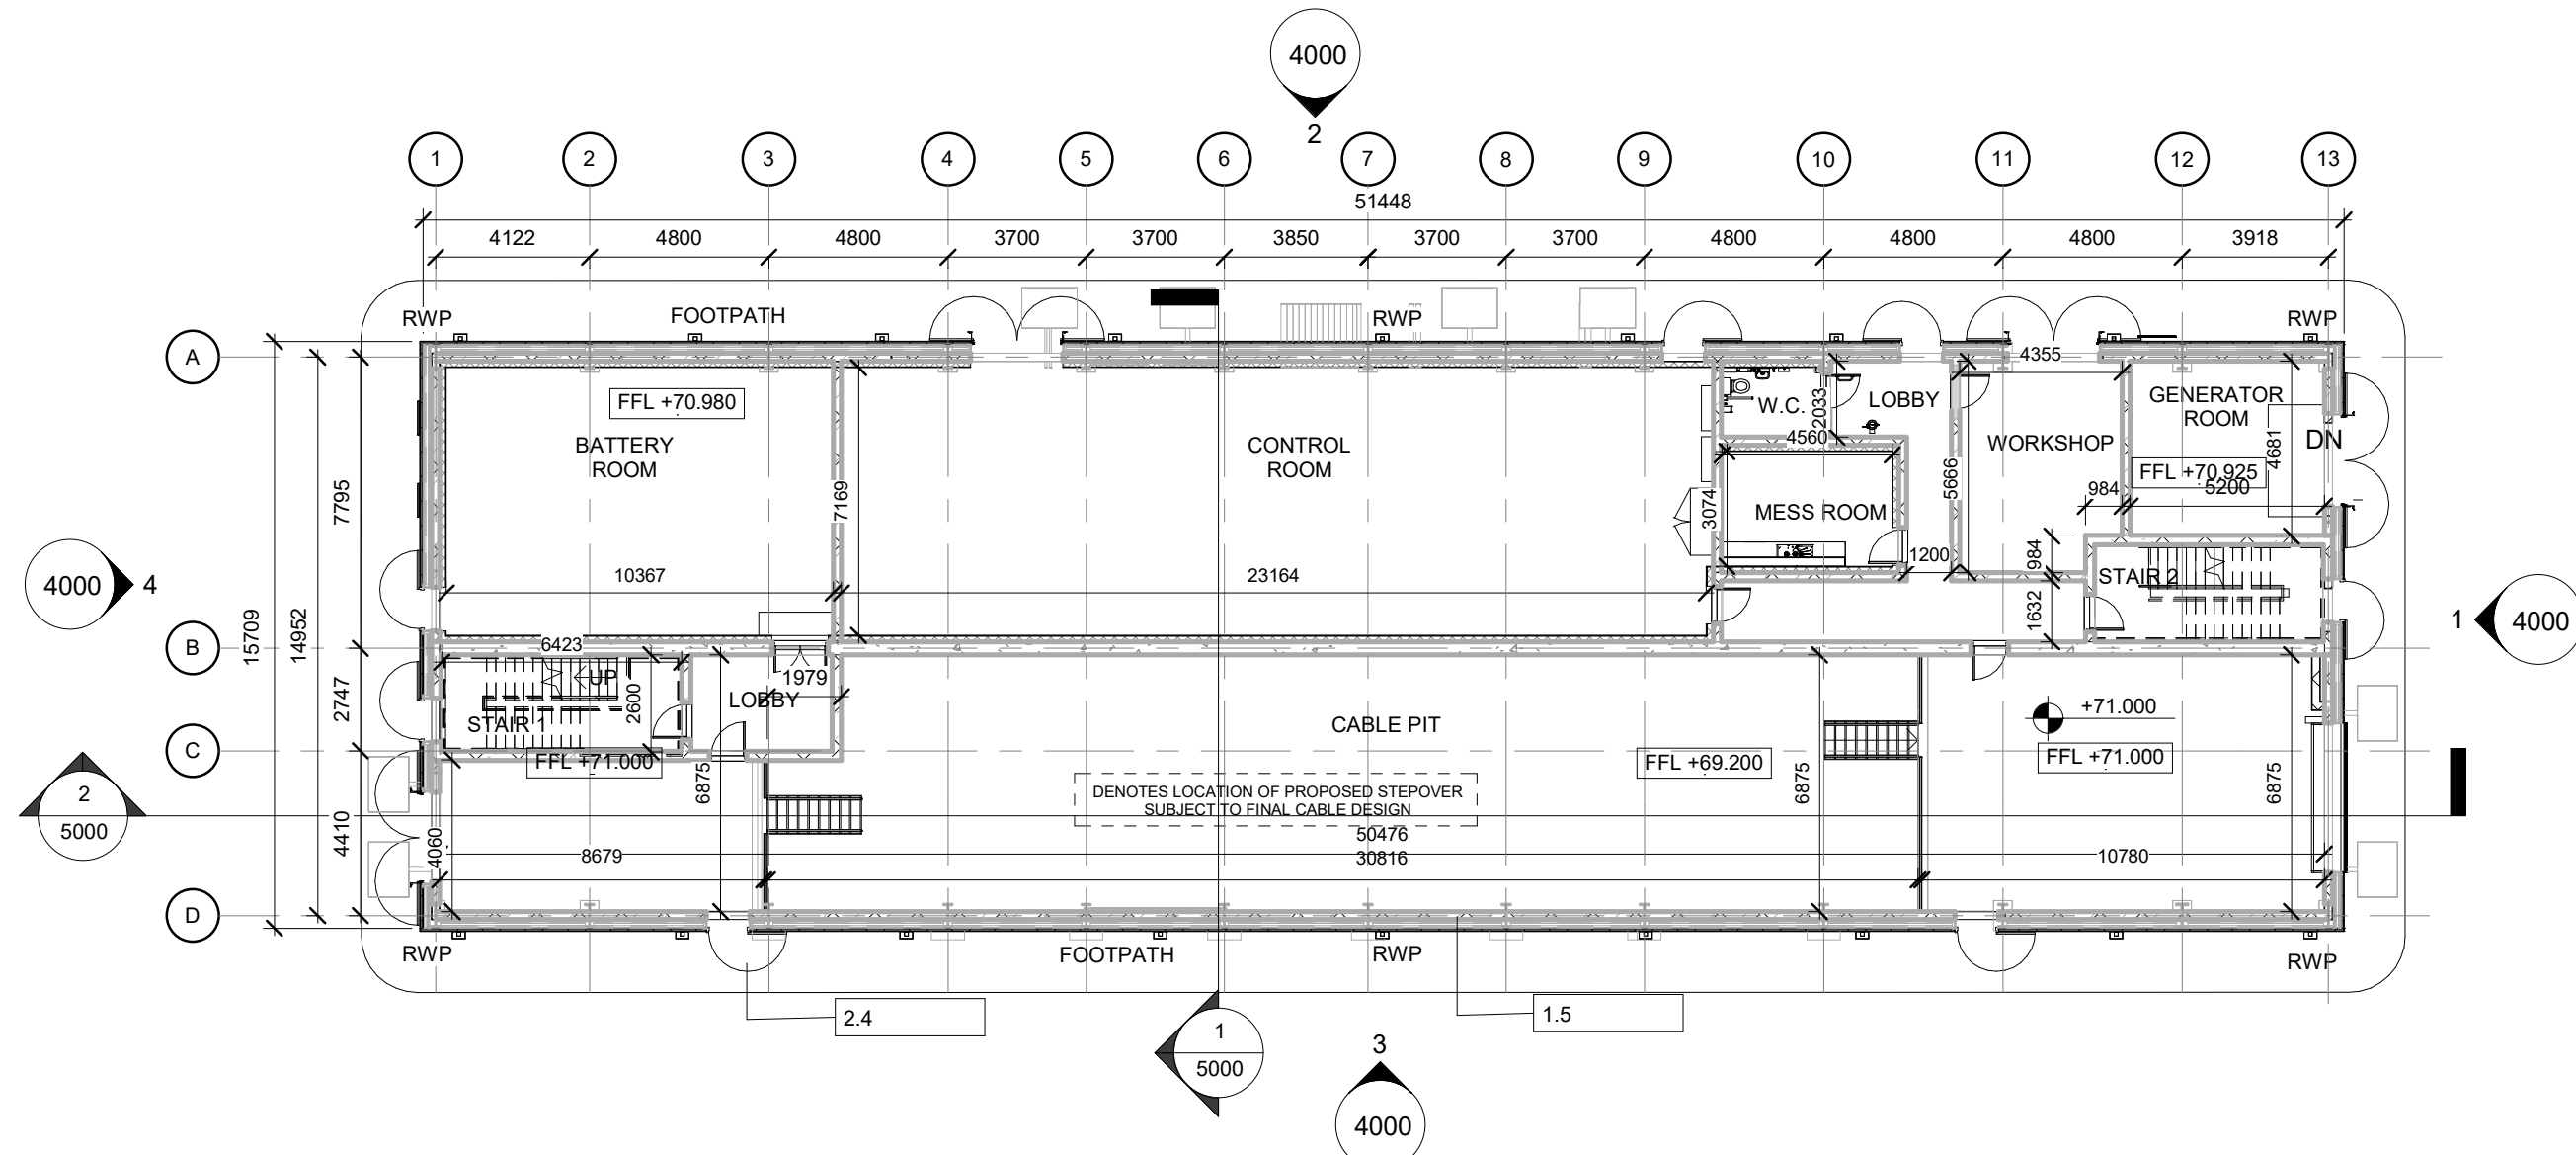


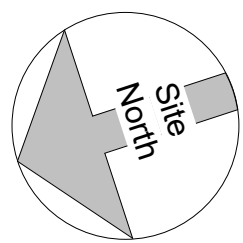

1 **GROUND FLOOR PLAN**
1 : 200

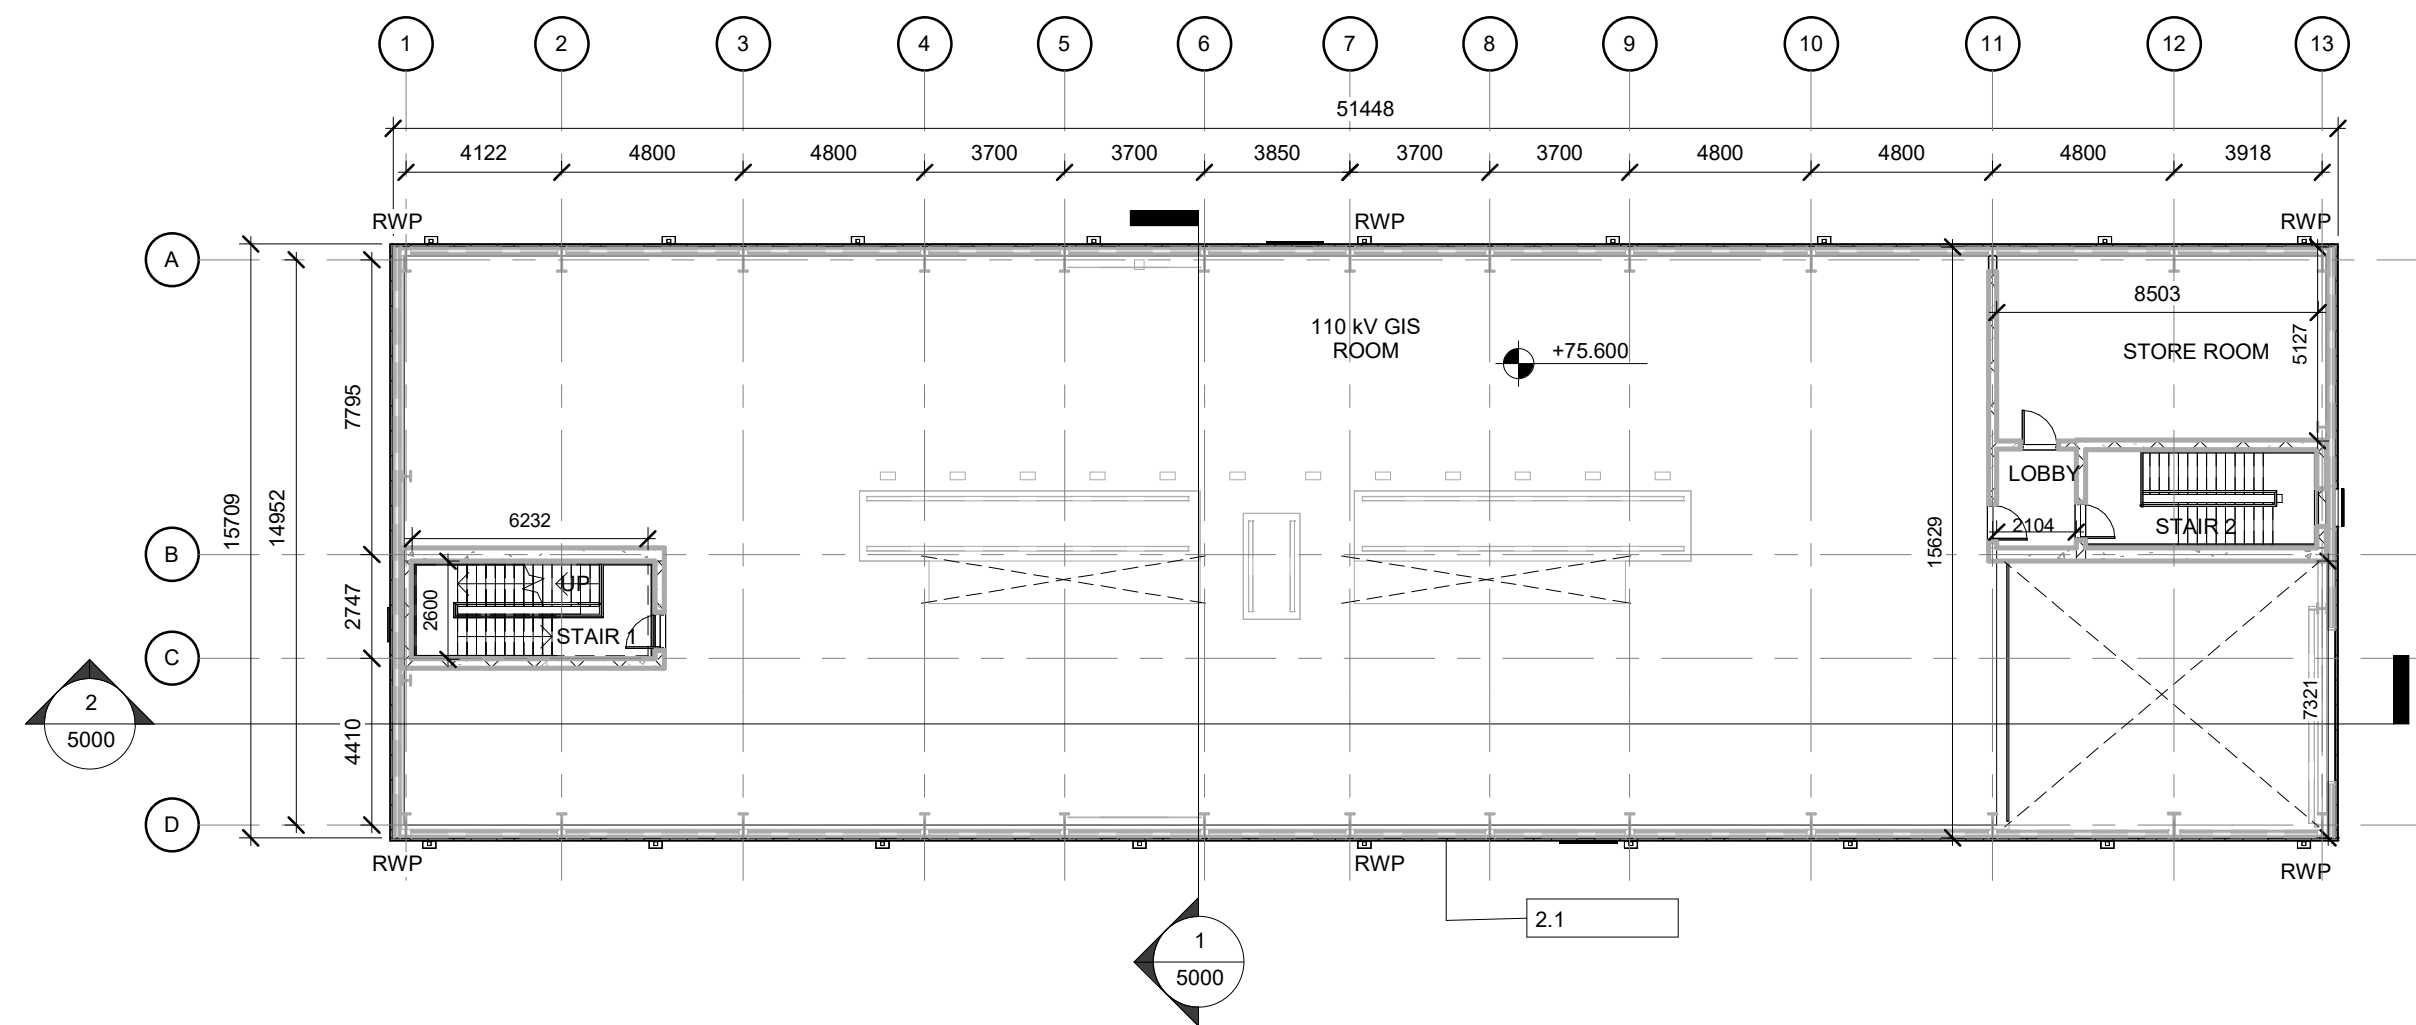

2 **FIRST FLOOR PLAN**
1 : 200

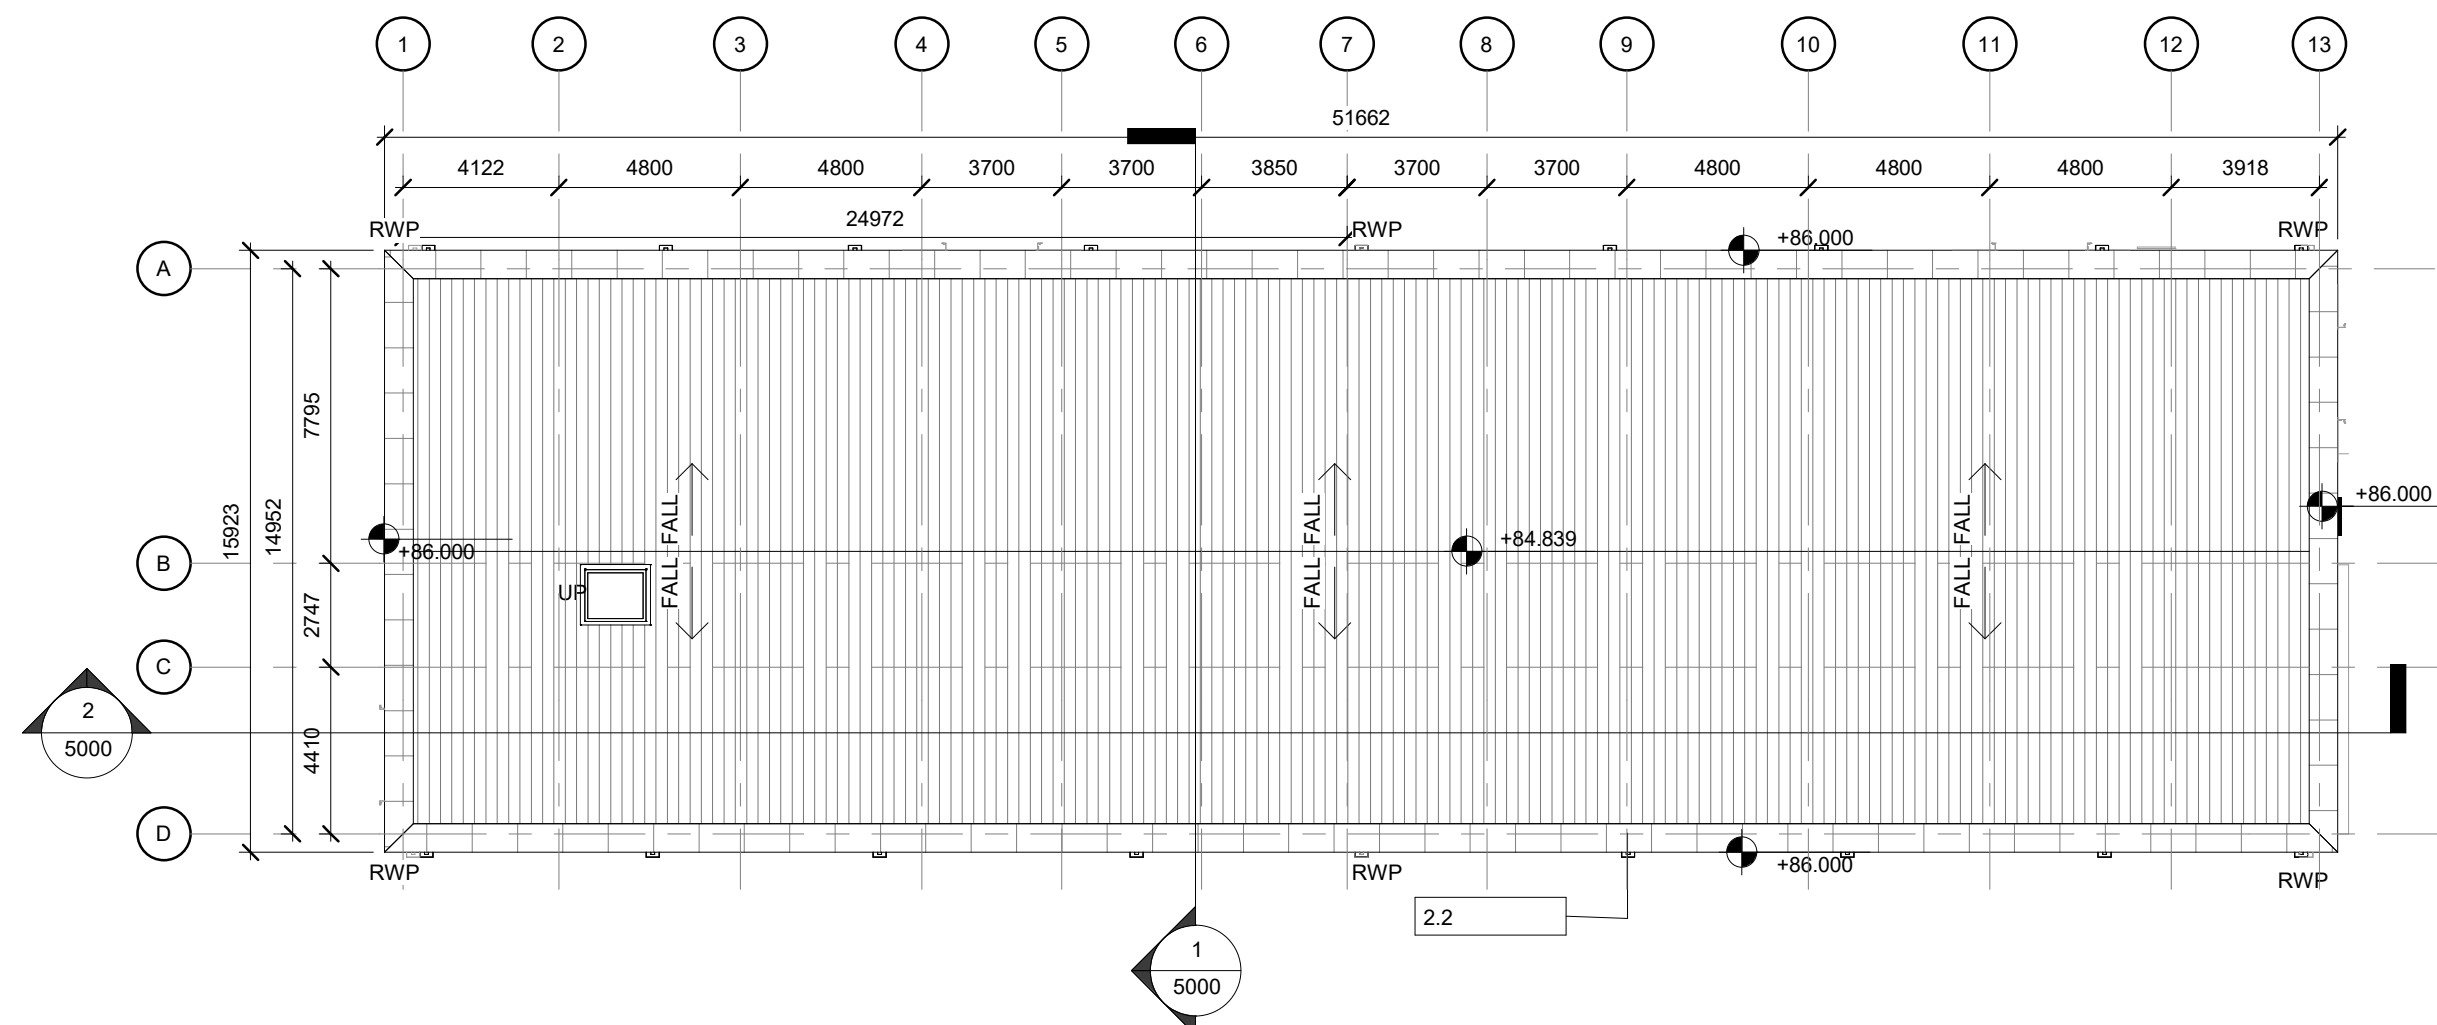

3 **ROOF PLAN**
1 : 200

MAIN CONTRACTOR



JOHN PAUL CONSTRUCTION
Dundrum Business Park
Dundrum rd,
Dublin, D14 E1R9
Tel: +353 (0) 1 215 6100
Mail: info@johnpaul.ie
Web: www.johnpaul.ie

John Paul Construction


ARCHITECT

Henry J Lyons

STRUCTURAL ENGINEER



HV Main Contractor

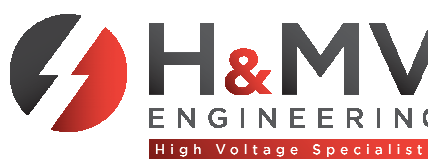

LEGEND / NOTES:

- 1.5 GIS BUILDING
- 2.1 TRAPEZOIDAL METAL CLADDING PANEL SYSTEM TO SELECTED COLOUR
- 2.2 PPC ALUMINIUM PARAPET CAPPING
- 2.4 EXTERNAL GRADE STEEL DOORS POWDER COATED TO SELECTED COLOUR

PROJECT

Clutterland 110 kV GIS
Substation

Rev	Drn	Ckd	Description	Date
P05	BK		ISSUED FOR PLANNING	04/11/2020

CONFIDENTIAL INFORMATION: This drawing/document and all design, details, inventions or developments covered or derived thereby are confidential and the exclusive property of the owner (or its affiliates), which reserve all rights in the is drawing/document. Copying, reproduction, duplication, or distribution to a third party, in whole or in part, is forbidden unless expressly authorised in writing

STATUS: PLANNING

Drawn by JB	Checked by FG	Date 10/07/20
----------------	------------------	------------------

Scale (@ A1) 1 : 200	Project number 950771
-------------------------	--------------------------

Drawing Title
Proposed GIS Building Floor
Plans

Drawing Number (Project Code-Originator-Volume-Level-Type-Role-Sheet no.) CLDHV-HJL-02-ZZ-DR-A-2000	Revision P05
---	-----------------