


LEGEND:

- LANDS IN THE OWNERSHIP OF THE APPLICANT/ LANDOWNER.
- PROPOSED SID APPLICATION SITE BOUNDARY
- PROPOSED COMPOUND FENCE
- PROPOSED ASPHALT ROAD
- PROPOSED STONED AREA
- PROPOSED CONCRETE FOOTPATH
- PROPOSED CONCRETE SLAB
- PROPOSED ASPHALT SURFACE
- PROPOSED MAINTENANCE GRAVEL ROAD
- PROPOSED LANDSCAPING
- PROPOSED UNIT SUB
- PROPOSED MARSHALLING KIOSK
- PROPOSED LIGHTNING MAST PLINTH
- - - PROPOSED FOUL SEWER
- PROPOSED 1200Ø FOUL SEWER MANHOLE
- PROPOSED PUMPING CHAMBER
- >> PROPOSED FOUL RAISING MAIN
- TG** PROPOSED TRAPPED GULLY
- >> 80mmØ FOUL RAISING MAIN
- PERMITTED 2.4m PALISADE SECURITY FENCE
- PERMITTED FOUL SEWER NETWORK
- PERMITTED FOUL SEWER MANHOLE
- PERMITTED ASPHALT ROAD
- PERMITTED EMBANKMENT AREA
- PERMITTED CONCRETE FOOTPATH

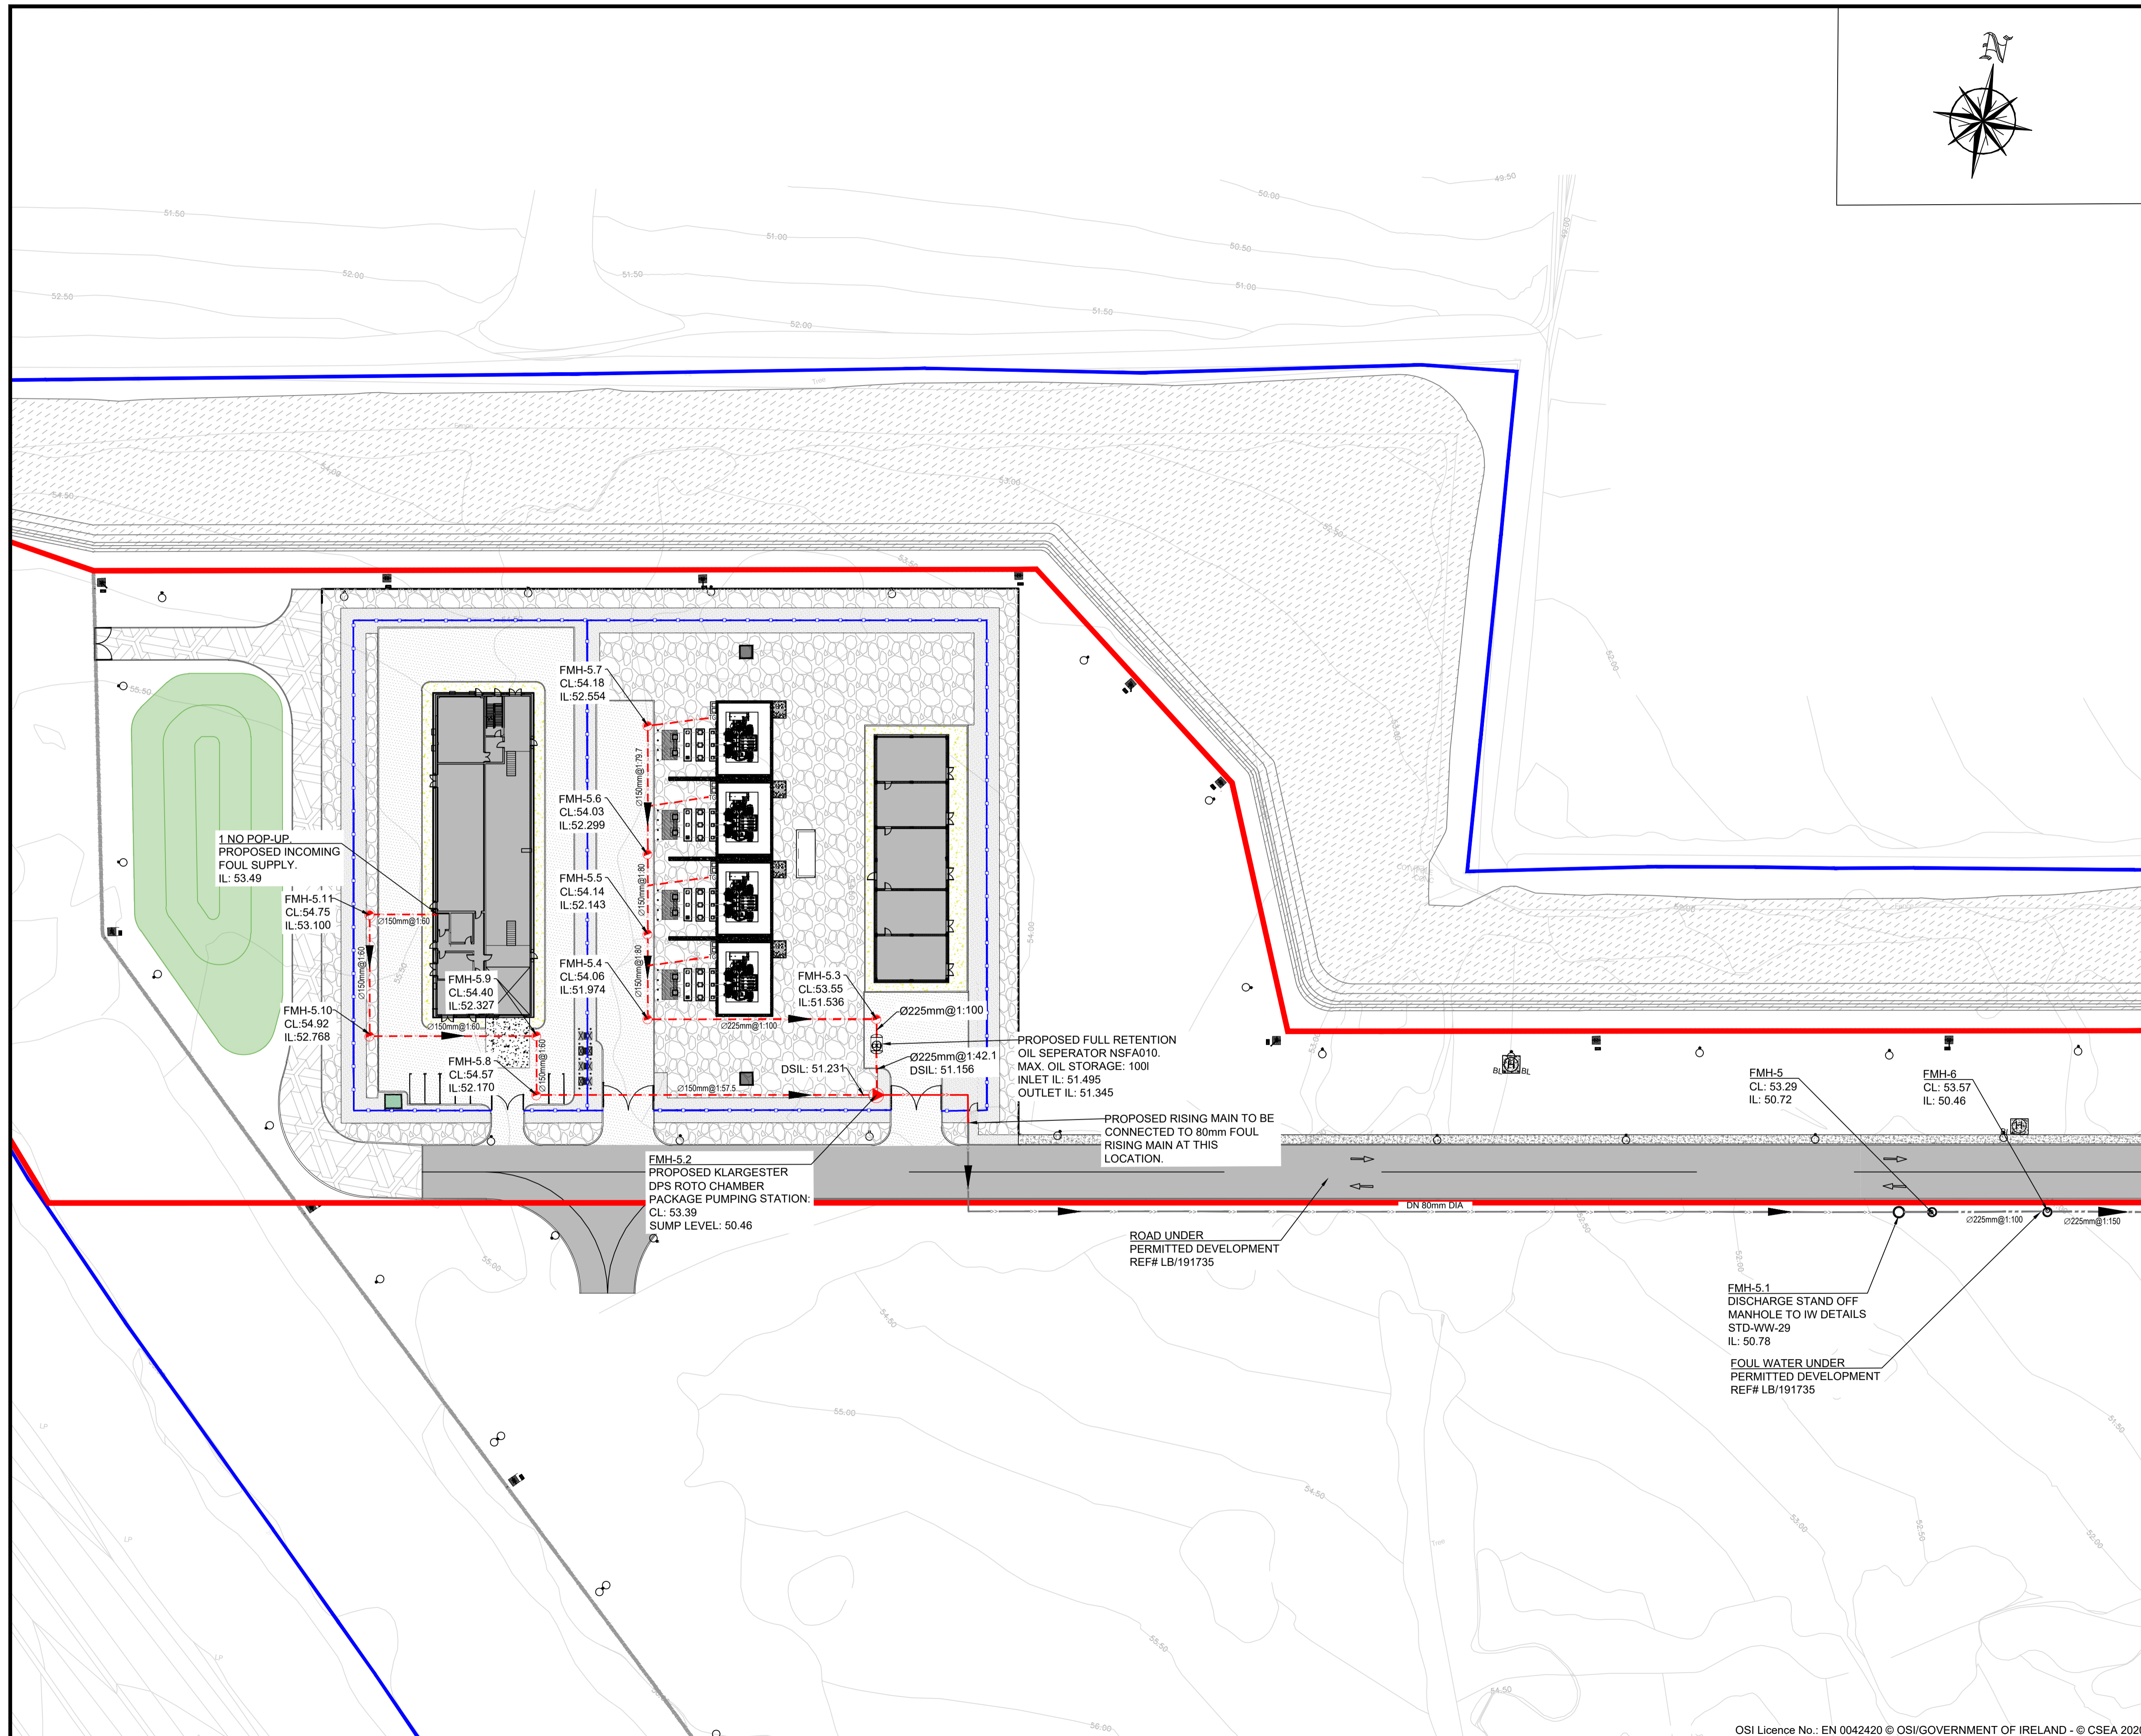

Rev	Description	Drawn	Checked	Date
P05	SID ISSUE	DM	PM	05.11.2020
P04	SID ISSUE	DM	PM	03.11.2020
P03	EIRGRID REVIEW	DM	PM	13.10.2020
P02	DP01 ISSUE	DM	PM	10.09.2020
P01	FOR DISCUSSION	DM	LM	28.07.2020

**Clifton Scannell Emerson Associates**

Clifton Scannell Emerson Associates Limited  
Consulting Engineers,  
Seaforth Lodge,  
Castledawson Avenue,  
Blackrock, Co. Dublin,  
Ireland, A94 P768

T: +353 1 288 5006  
F: +353 1 283 3466  
E: info@csea.ie  
W: www.csea.ie

**CAP DEVELOPMENTS LLC**

Client: **OLDBRIDGE 110KV SUBSTATION**

Project: **PROPOSED & EXISTING FOUL WATER DRAINAGE LAYOUT**

Dwg. Title: **20\_057**

Drawn By: **DM** Date: **OCTOBER 2020**

Checked By: **LM** Scale: **1:500 @ A1**

Project Code: **CAP - CSE - 00 - XX - DR - C - 2111**

Status Code: **S2** Suitability Description: **SUITABLE FOR INFORMATION**

Revision: **P05** Project Status: **PLANNING**