


ESB International ESB Engineering & Facility Management Ltd. Stephen Court, 18/21 St. Stephen's Green, Dublin 2, Ireland Telephone: 353-1-703 8000 Fax: 353-1-661-6600 Website: www.esb.ie Registered Office as above Registered in Ireland No. 155249	Client	ESB NETWORKS	Drawing title	C2 COMMUNICATIONS CHAMBER REINFORCEMENT DETAILS	Copyright ESB International Ltd. All rights reserved. No part of this work may be modified or reproduced or copied in any form or by any means - graphic, electronic or mechanical, including photocopying, recording, taping or information and retrieval systems, or used for any purpose other than its designated purpose, without the written permission of ESB International Limited.					
	Project	HV Cables Standards	Drawn	J.Dillon	Verified	K.Coughlan	Approved	J.Daly	Approved date	16/04/2009
	Contract	CABLES SERVICES TO ESB	Client ref.	TC200033	No. of sheets	4	Size	A3	Scale	
	Production unit	High Voltage Engineering	Drawing number	PE424-D7001-004-003-001		Sheet	Rev			

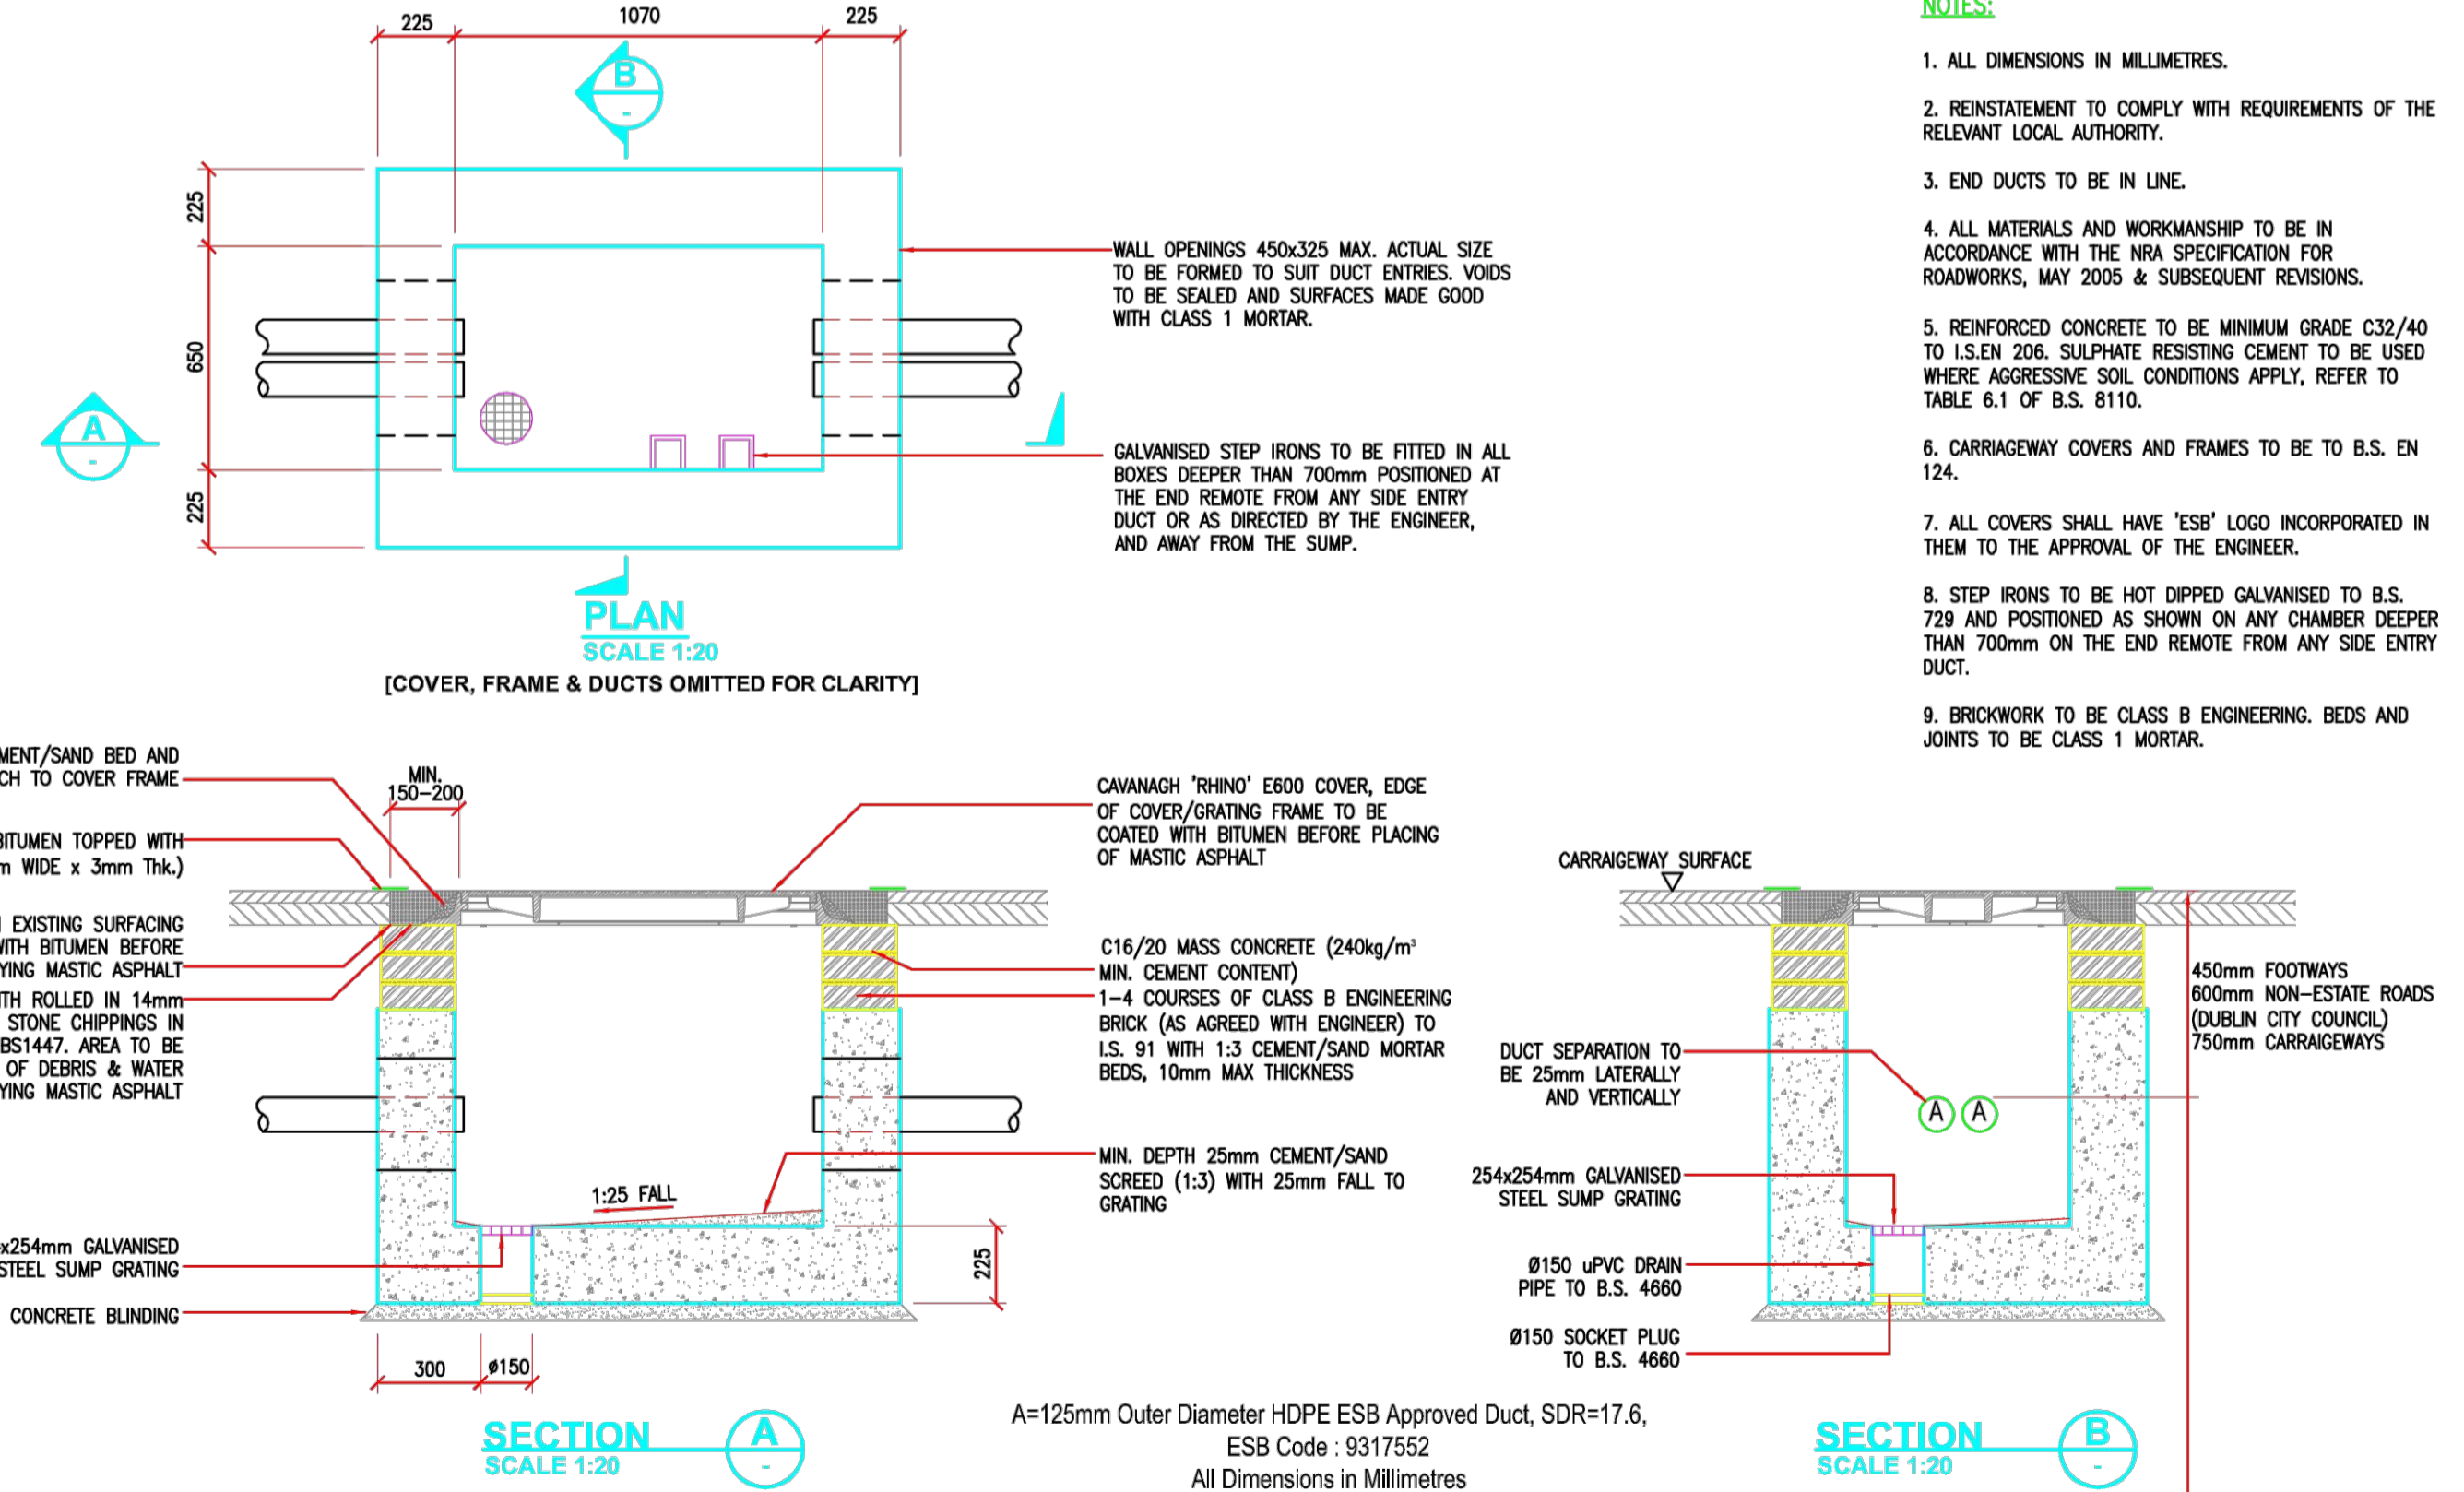

ESB International ESB Engineering & Facility Management Ltd. Stephen Court, 18/21 St. Stephen's Green, Dublin 2, Ireland Telephone: 353-1-703 8000 Fax: 353-1-661-6600 Website: www.esb.ie Registered Office as above Registered in Ireland No. 155249	Client	ESB NETWORKS	Drawing title	C2 COMMUNICATIONS CHAMBER GENERAL ARRANGMENT	Copyright ESB International Ltd. All rights reserved. No part of this work may be modified or reproduced or copied in any form or by any means - graphic, electronic or mechanical, including photocopying, recording, taping or information and retrieval systems, or used for any purpose other than its designated purpose, without the written permission of ESB International Limited.					
	Project	HV Cables Standards	Drawn	J.Dillon	Verified	M.Byrne	Approved	M.Byrne	Approved date	19/07/11
	Contract	CABLES SERVICES TO ESB	Client ref.	TC200033	No. of sheets	4	Size	A3	Scale	A3
	Production unit	High Voltage Engineering	Drawing number	PE424-D7001-004-002-001		Sheet	Rev			

Project:	HV Cables Standards												
Title:	R.C. DETAILS OF COMMUNICATIONS CHAMBER												
DRG. No.	REV.												
PE424-7001-004-003	001												
* Specified to Nearest 5mm		All Bending Dimensions are in accordance with B.S. 4466 (1989)											
+ Specified to Nearest 25mm													
Member	Bar Mark	Type	Size (mm)	Nr. of Mbrs.	Nr. in Each	Total Nr.	Length of Each Bar mm +	Shape Code	A * mm	B * mm	C * mm	D * mm	E/r * mm
BASE	01	T	12	1	9	9	2625	38	975	730			
	02	T	12	1	9	9	1225	35	1020				
	03	T	12	1	7	7	3025	38	975	1150			
	04	T	12	1	7	7	1650	35	1440				
	05	T	12	1	28	28	1425	37	975				
WALLS	04	T	12	2	5	10	1650	35	1440				
	06	T	12	2	10	20	1350	37	750				
	07	T	12	2	5	10	2600	38	750	1150			

ESB International ESB Engineering & Facility Management Ltd. Stephen Court, 18/21 St. Stephen's Green, Dublin 2, Ireland Telephone: 353-1-703 8000 Fax: 353-1-661-6600 Website: www.esb.ie Registered Office as above Registered in Ireland No. 155249	Client	ESB NETWORKS	Drawing title	C2 COMMUNICATIONS CHAMBER STEEL REINFORCEMENT SCHEDULE	Copyright ESB International Ltd. All rights reserved. No part of this work may be modified or reproduced or copied in any form or by any means - graphic, electronic or mechanical, including photocopying, recording, taping or information and retrieval systems, or used for any purpose other than its designated purpose, without the written permission of ESB International Limited.					
	Project	HV Cables Standards	Drawn	J.Dillon	Verified	K.Coughlan	Approved	J.Daly	Approved date	28/04/2009
	Contract	CABLES SERVICES TO ESB	Client ref.	TC200033	No. of sheets	4	Size	A4	Scale	N/A
	Production unit	High Voltage Engineering	Drawing number	PE424-D7001-004-004-000		Sheet	Rev			

Clifton Scannell Emerson Associates
 Clifton Scannell Emerson Associates Limited
 Consulting Engineers, Seafort Lodge, Castledawson Avenue, Blackrock, Co. Dublin, Ireland, A94 P768
 T: +353 1 283 5006
 F: +353 1 283 3466
 E: info@csea.ie
 W: www.csea.ie

Client: CAP DEVELOPMENTS LLC
 Project: OLDBRIDGE 110KV SUBSTATION
 Dwg. Title: TYPICAL DETAILS FOR C2 CHAMBER
 Drawn By: DM Date: OCTOBER 2020
 Checked By: PM AS INDICATED @ A1 Scale: CSEA Job No. 20_057
 Project Code: DUB062HV - CSE - 00 - XX - DR - C - 2161
 Status Code: S2 SUITABLE FOR INFORMATION
 P02 PLANNING