


Notes :


1. All drawings are to be read in conjunction with all relevant Specifications, Bills of Quantities, Architectural, Services and Engineering Drawings.
2. Any discrepancies between these documents shall be brought to the attention of the Engineer.
3. All dimensions are in millimetres, unless noted otherwise.
4. All levels are in metres related to Ordnance Datum.
5. Drawings are not to be scaled.
6. The finalised layout may be subject to micro-siting due to unforeseen ground conditions. The extent of flexibility will be site specific and should generally not extend beyond 20 metres.

Reference Drawings :

19107-5013 Drainage Layout Master Sheet

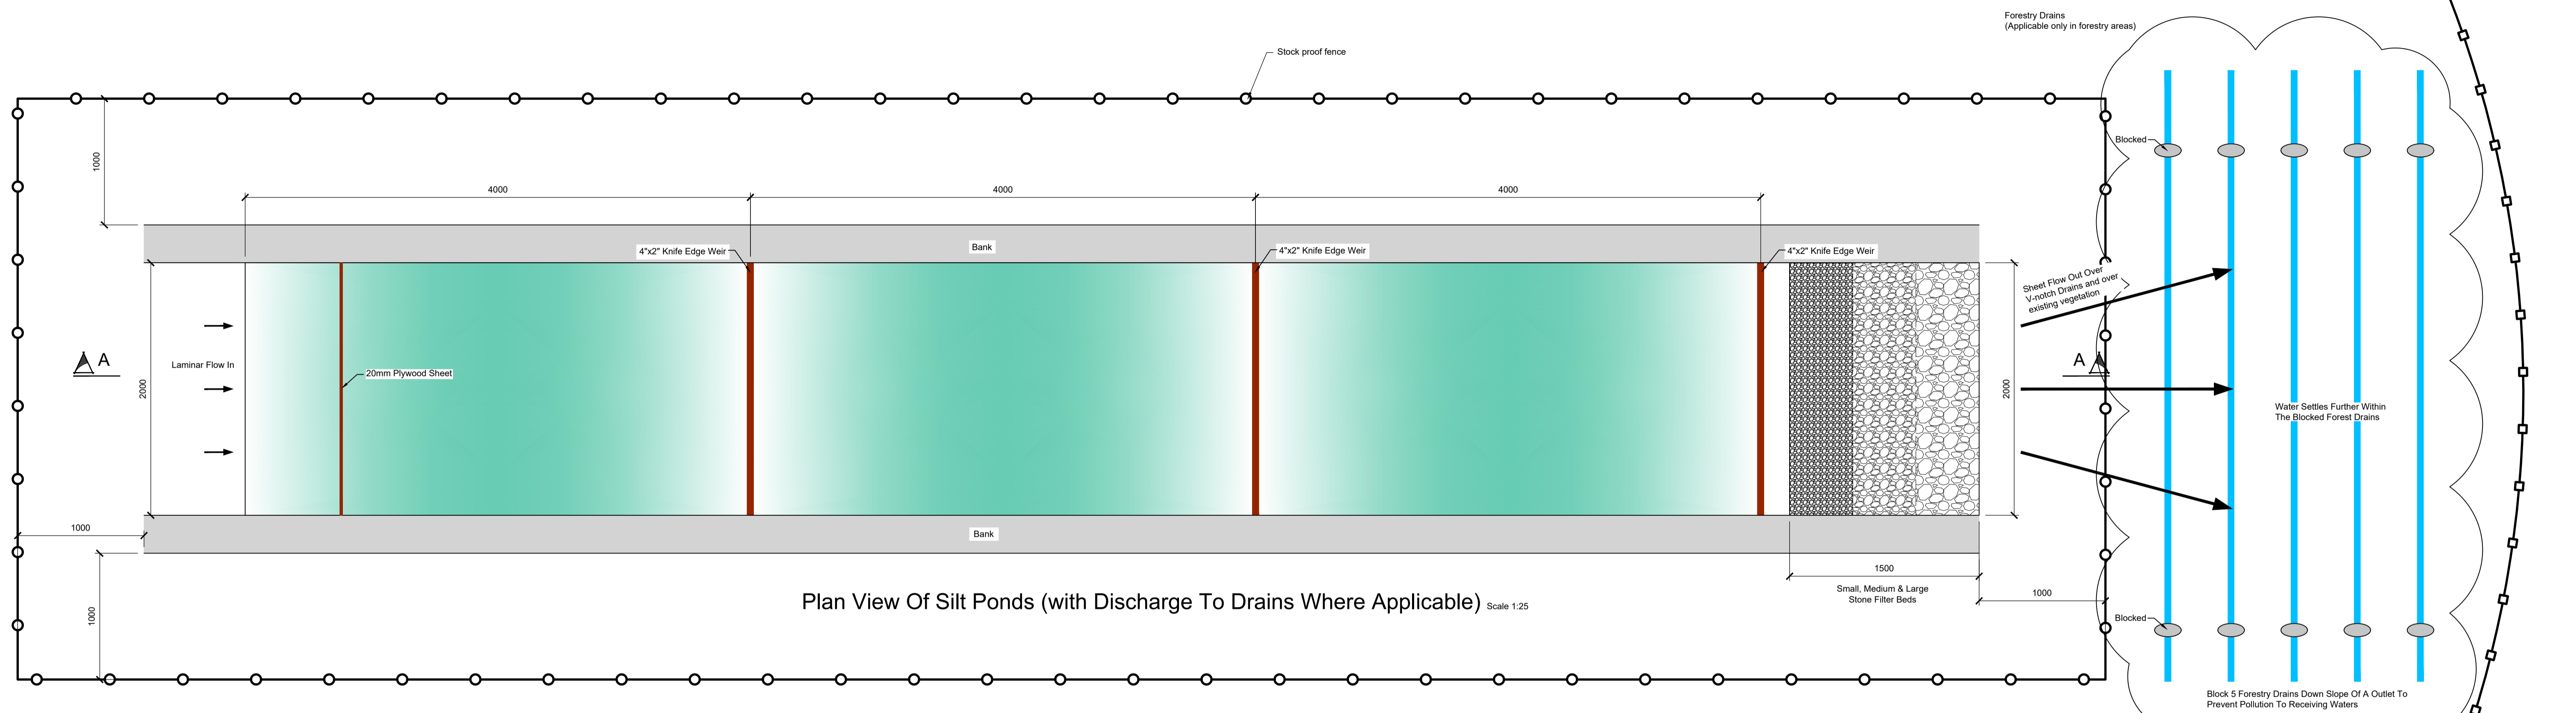

Plan View Of Silt Ponds (with Discharge To Drains Where Applicable) Scale 1:25

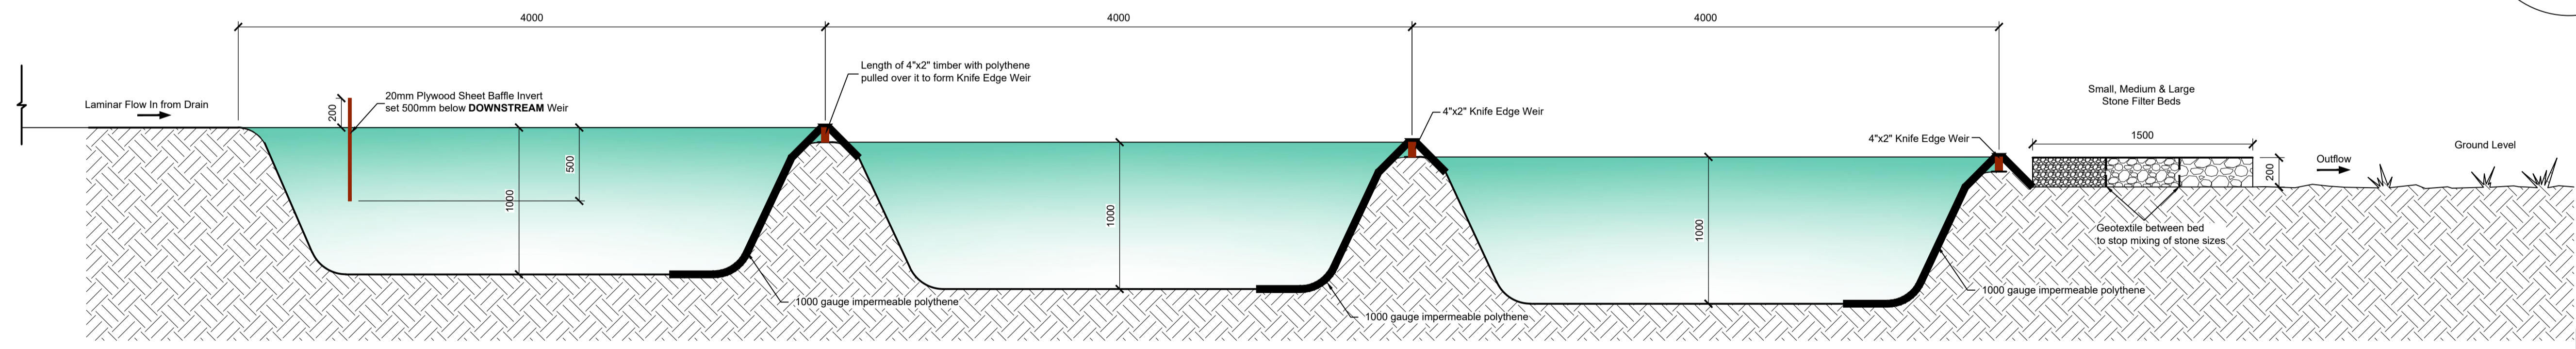



Section A-A Scale 1:25



Baffle/Weir Detail



Completed Settling Pond System

Rev.	Date	Description	by	chk'd	app
A	03.07.2020	Issued For Planning	JK	CM	HBR
Project					
Carrowmagowan Wind Farm					
Title					
Drainage Details - Sheet 1					
Client					
					
					
Reen Point, Blennerville, Tralee, Co. Kerry. Tel: +353 (0)66 7423494 Fax: +353 (0)66 7126886 E-mail: tralee@mwp.ie					
Scales (A1)		1:25	Drg. No.		Rev.
Drawn	JK	04.11.2019	19107-5024		A
Ch'd (DO)	JK	04.11.2019			
Ch'd (Eng)	ON	07.11.2019			
Approved	JL	07.11.2019			