




Baffle/Weir Detail



Completed Settling Pond System

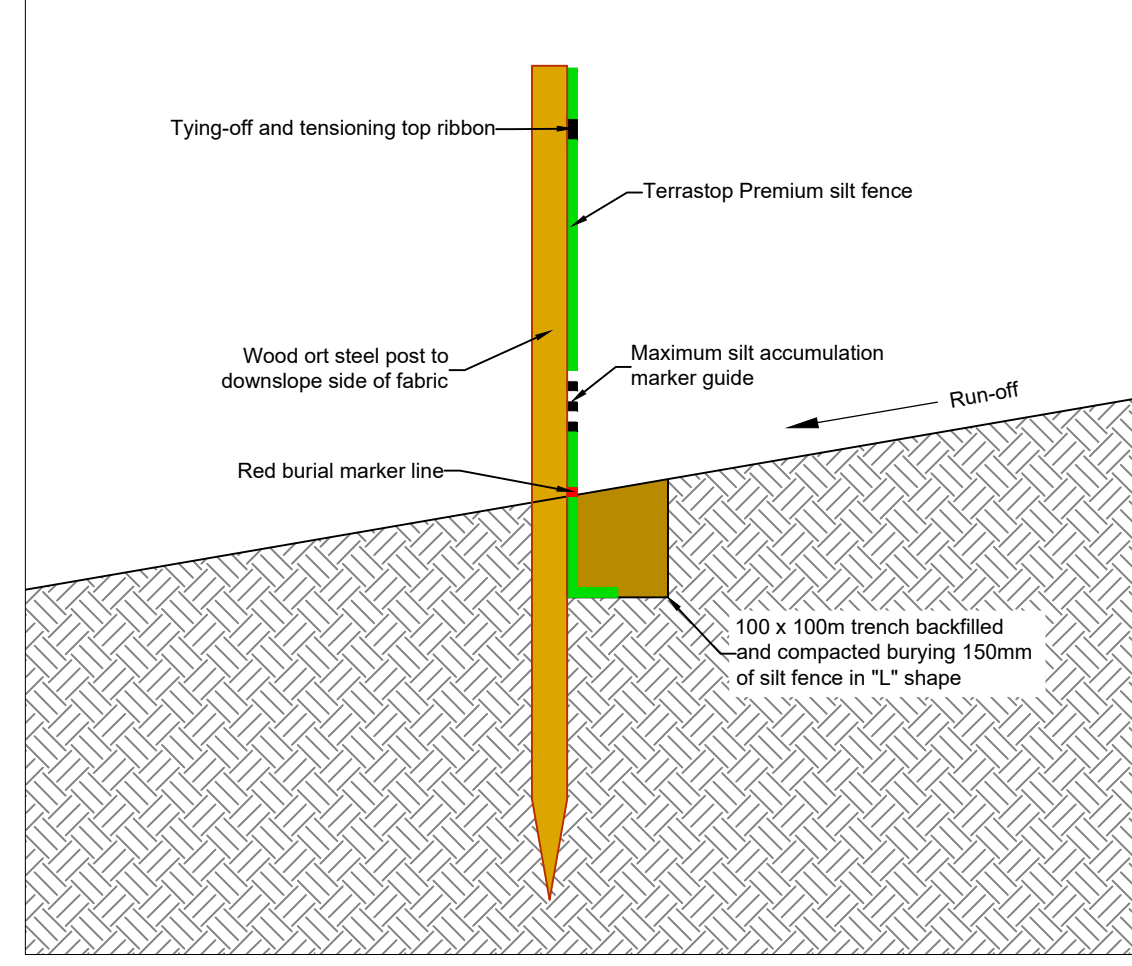


Schematic Detail of a Terra-Stop Weir

DO NOT SCALE FROM THIS DRAWING. USE FIGURED DIMENSIONS IN ALL CASES. VERIFY DIMENSIONS ON SITE AND REPORT ANY DISCREPANCIES TO THE DESIGNERS IMMEDIATELY.
THIS DRAWING IS TO BE READ IN CONJUNCTION WITH THE DESIGNERS SPECIFICATION.
© THIS DRAWING IS COPYRIGHT AND MAY ONLY BE REPRODUCED WITH THE DESIGNERS PERMISSION.


- NOTES:
1. ALL DRAWINGS ARE TO BE READ IN CONJUNCTION WITH ALL RELEVANT SPECIFICATIONS, BILLS OF QUANTITIES, ARCHITECTURAL, SERVICES AND ENGINEERING DRAWINGS.
 2. ALL LEVELS ARE IN METRES RELATED TO ORDNANCE DATUM MALIN HEAD.
 3. ANY DISCREPANCIES BETWEEN THESE DOCUMENTS SHALL BE BROUGHT TO THE ATTENTION OF THE ENGINEER.
 4. DRAWINGS ARE NOT TO BE SCALED.
 5. ALL DIMENSIONS ARE IN MILLIMETRES, UNLESS NOTED OTHERWISE.
 6. THE FINALISED LAYOUT MAY BE SUBJECT TO MICRO-SITING DUE TO UNFORESEEN GROUND CONDITIONS. THE EXTENT OF FLEXIBILITY WILL BE SITE SPECIFIC AND SHOULD GENERALLY NOT EXTEND BEYOND 20 METRES.

REFERENCE DRAWINGS:

DRAWING No.	Proposed Site Layout - Master Sheet
19876-MWP-00-00-DR-C-5005	Proposed Site Drainage Layout - Master Sheet
19876-MWP-00-00-DR-C-5011	Proposed Site Drainage Layout - Master Sheet

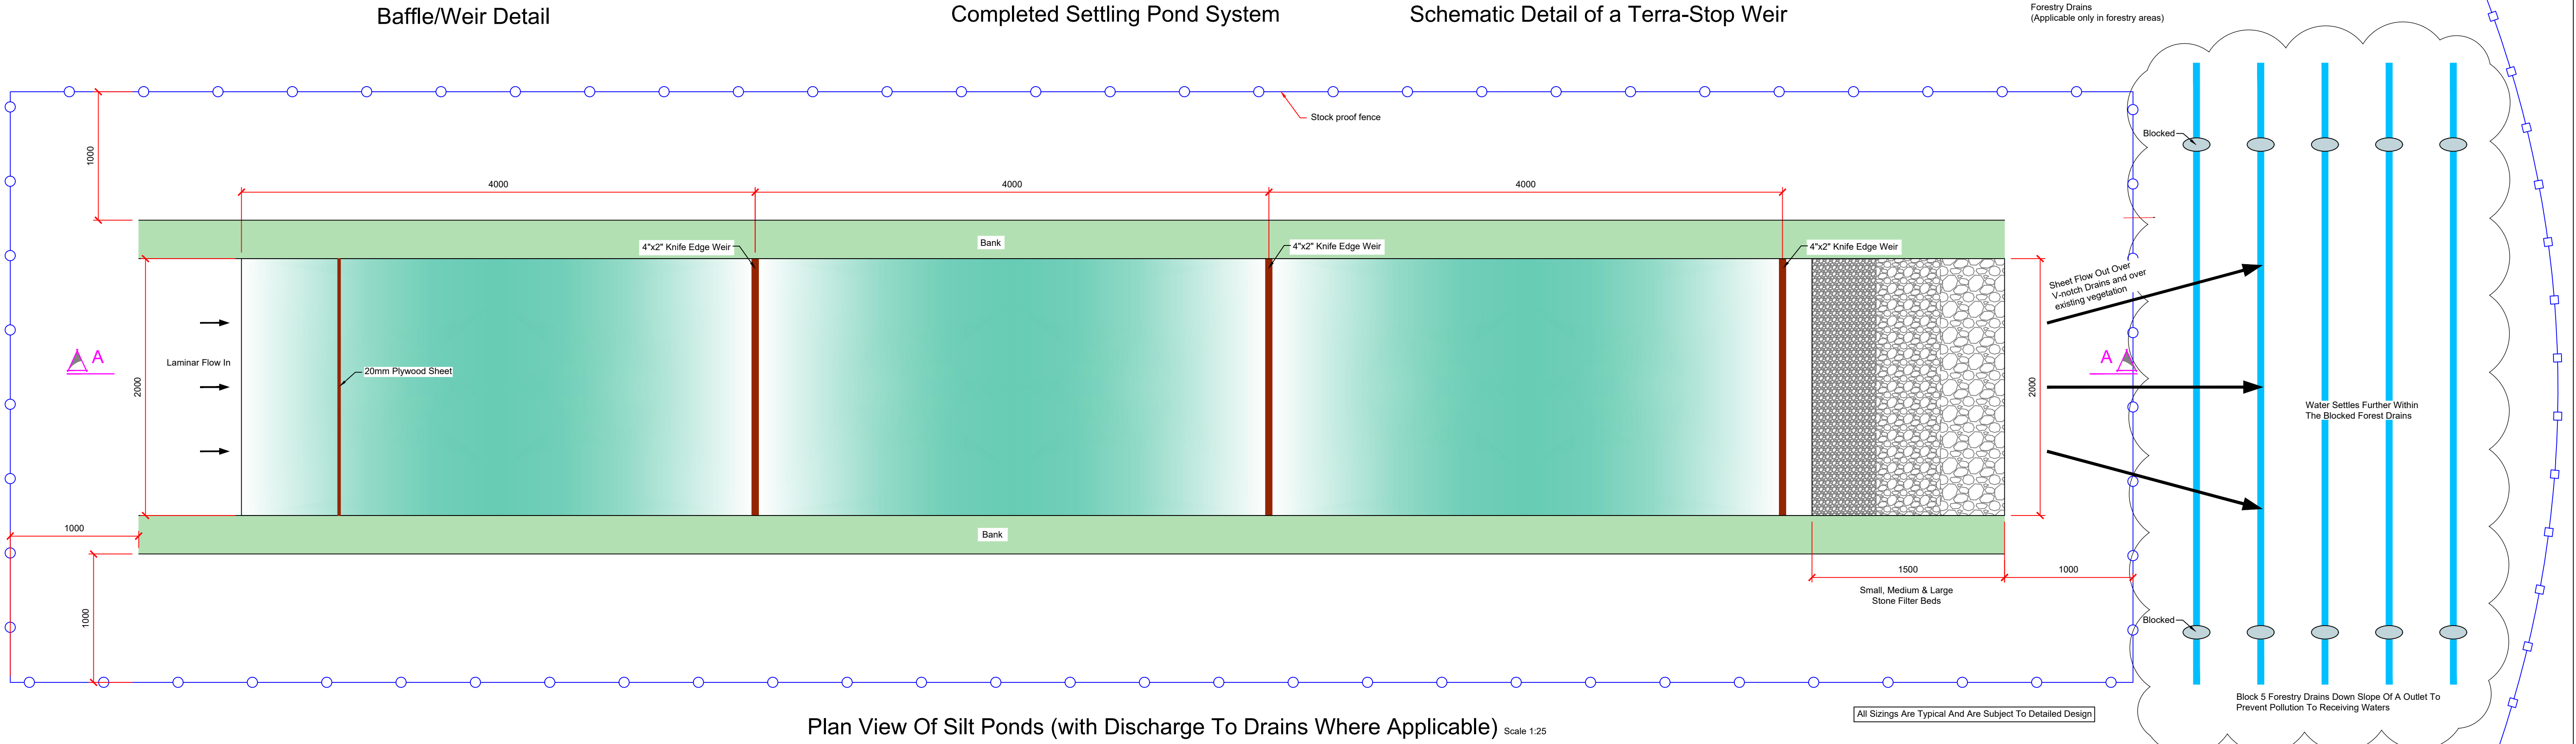

Plan View Of Silt Ponds (with Discharge To Drains Where Applicable) Scale 1:25

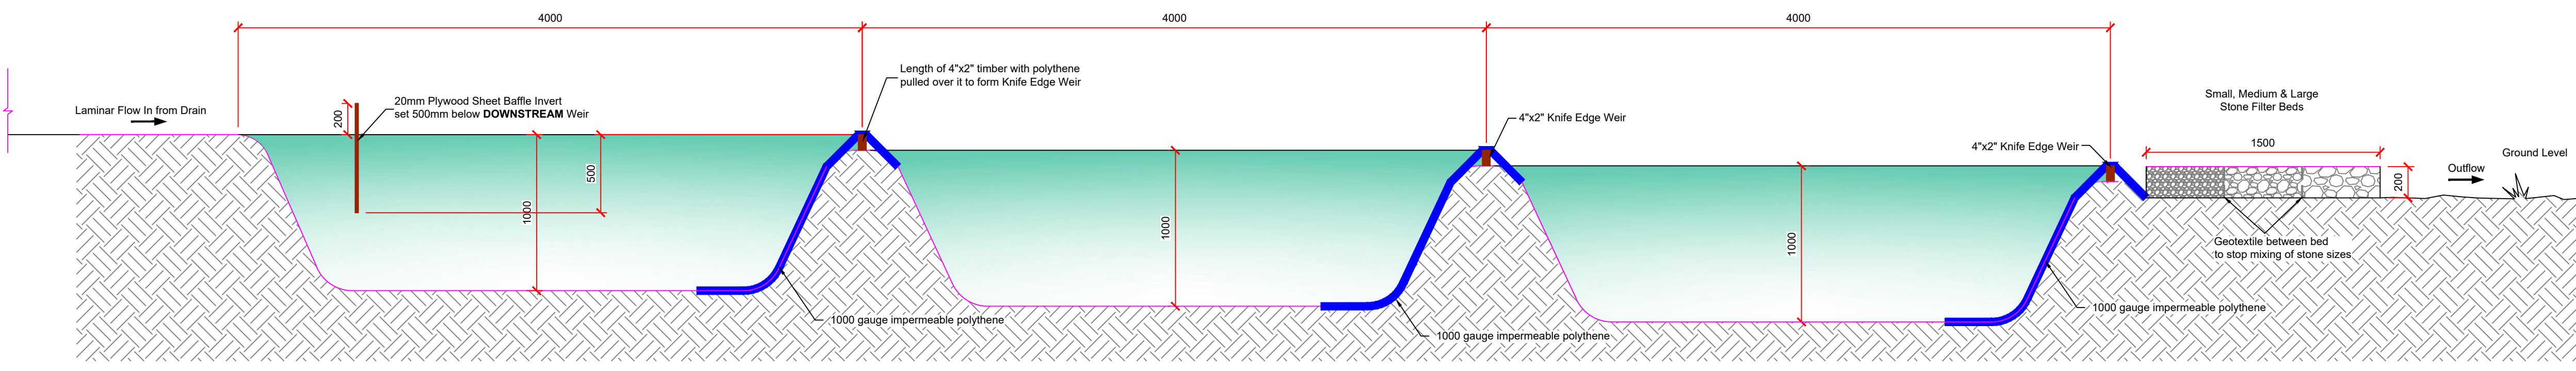

Section A-A Scale 1:25

REV	DATE	Issued For Planning	JK	KF
			BY	APP
PROJECT: Shronowen Wind Farm				
TITLE: Drainage Details - Sheet 1				
CLIENT: Shronowen Wind Farm Limited				
<p>Malachy Walsh and Partners Engineering and Environmental Consultants Cork Tralee London Limerick</p> <p>Reen Point, Blennerville, Tralee, Co. Kerry, V92 X2TK</p> <p>Tel: +353 (0) 66 7123404 Fax: +353 (0) 66 7125686 E-mail: tralee@mwp.ie Web: www.mwp.ie</p>				
DRAWN: JK	CHECKED: PC	APPROVED: PC		
DATE: September 2020	SCALE @ A1: As Shown			
PROJECT NUMBER: 19876	DRAWING STATUS: S2			
DRAWING NUMBER: 19876-MWP-00-00-DR-C-5404	REV: P01			