




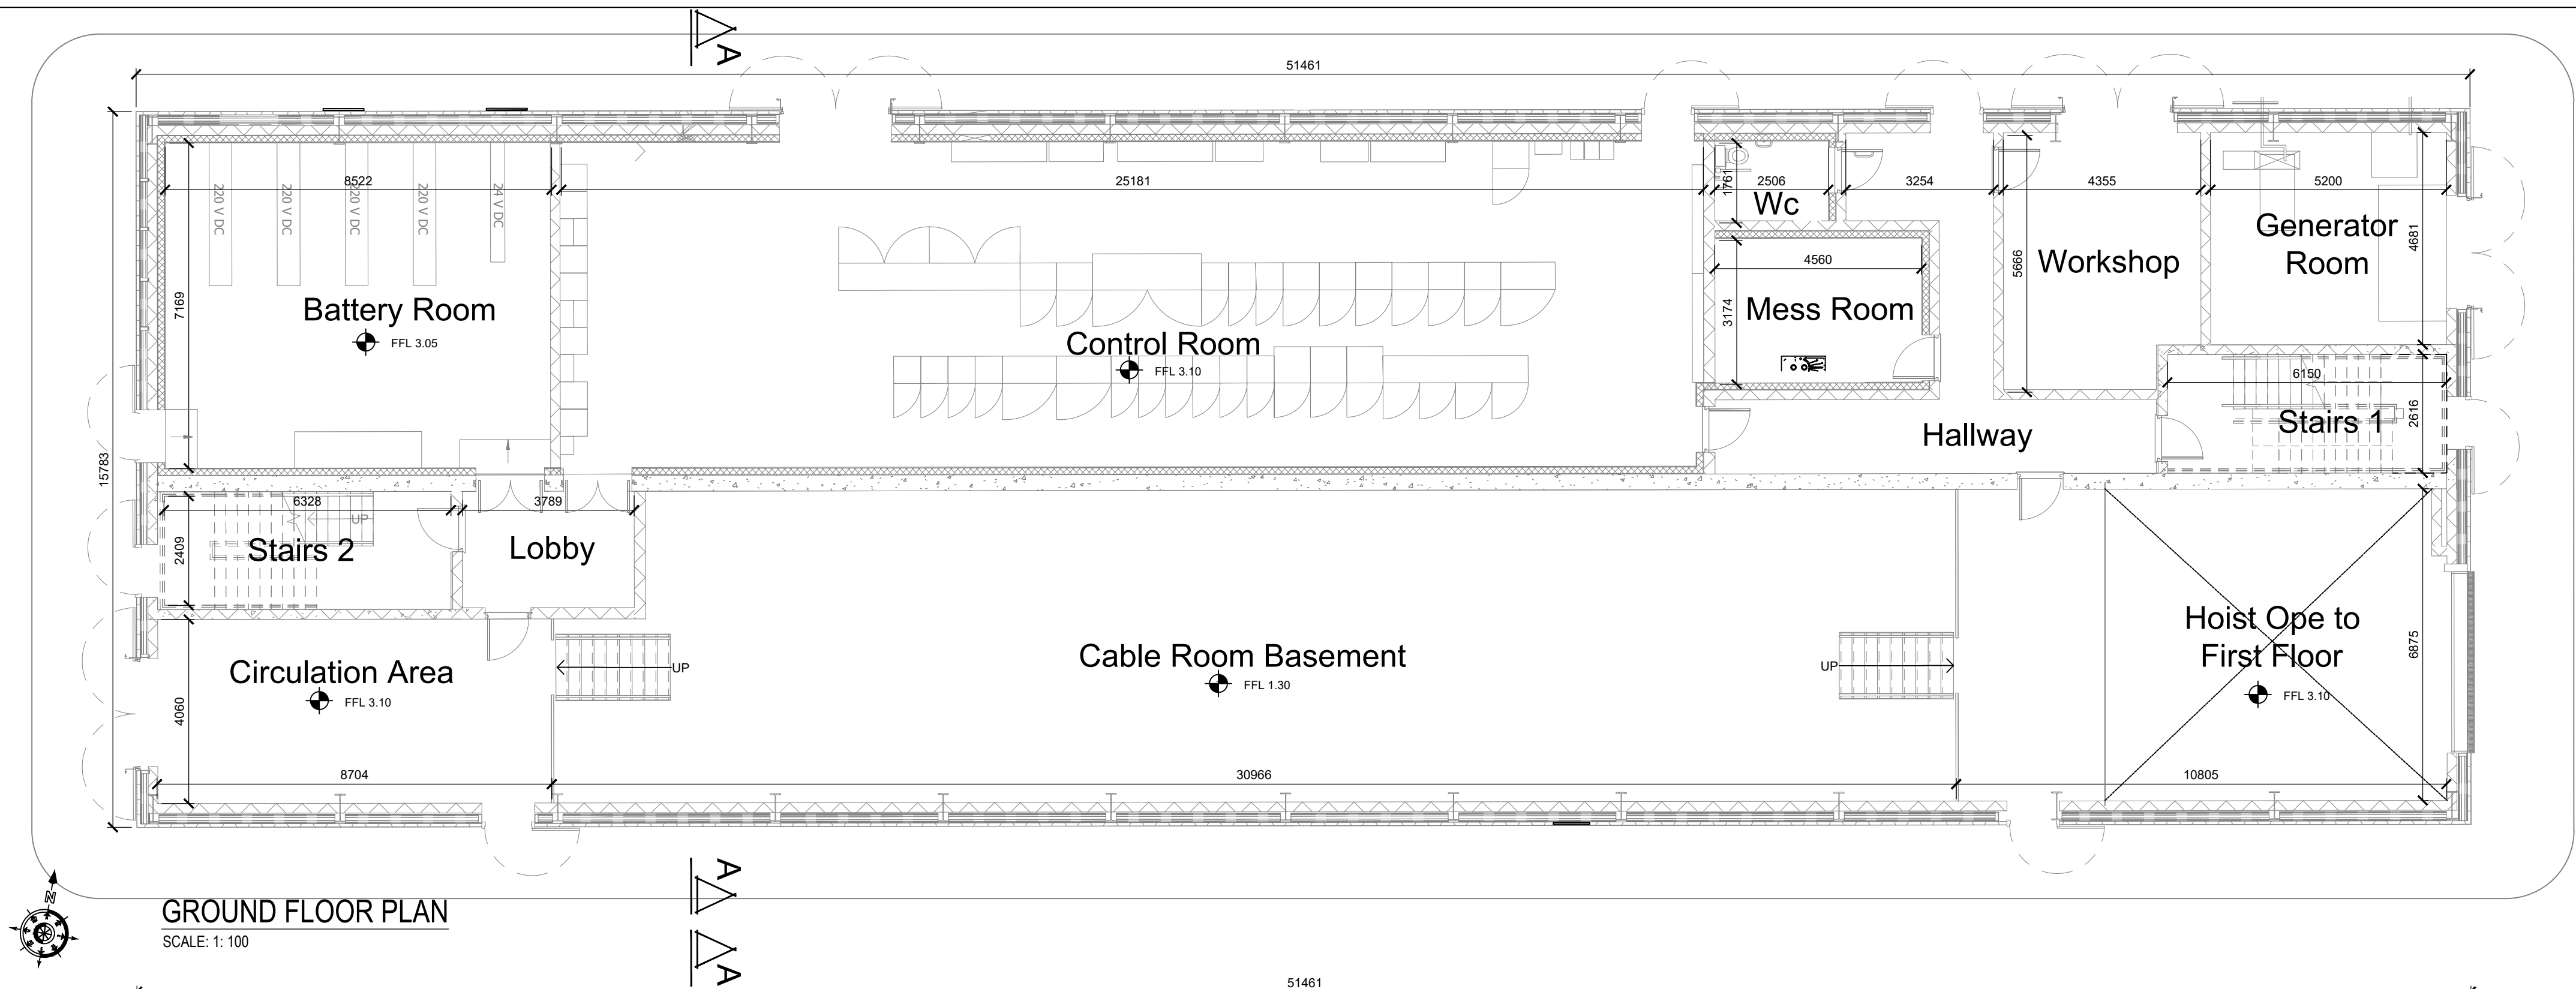

GROUND FLOOR PLAN
SCALE: 1: 100

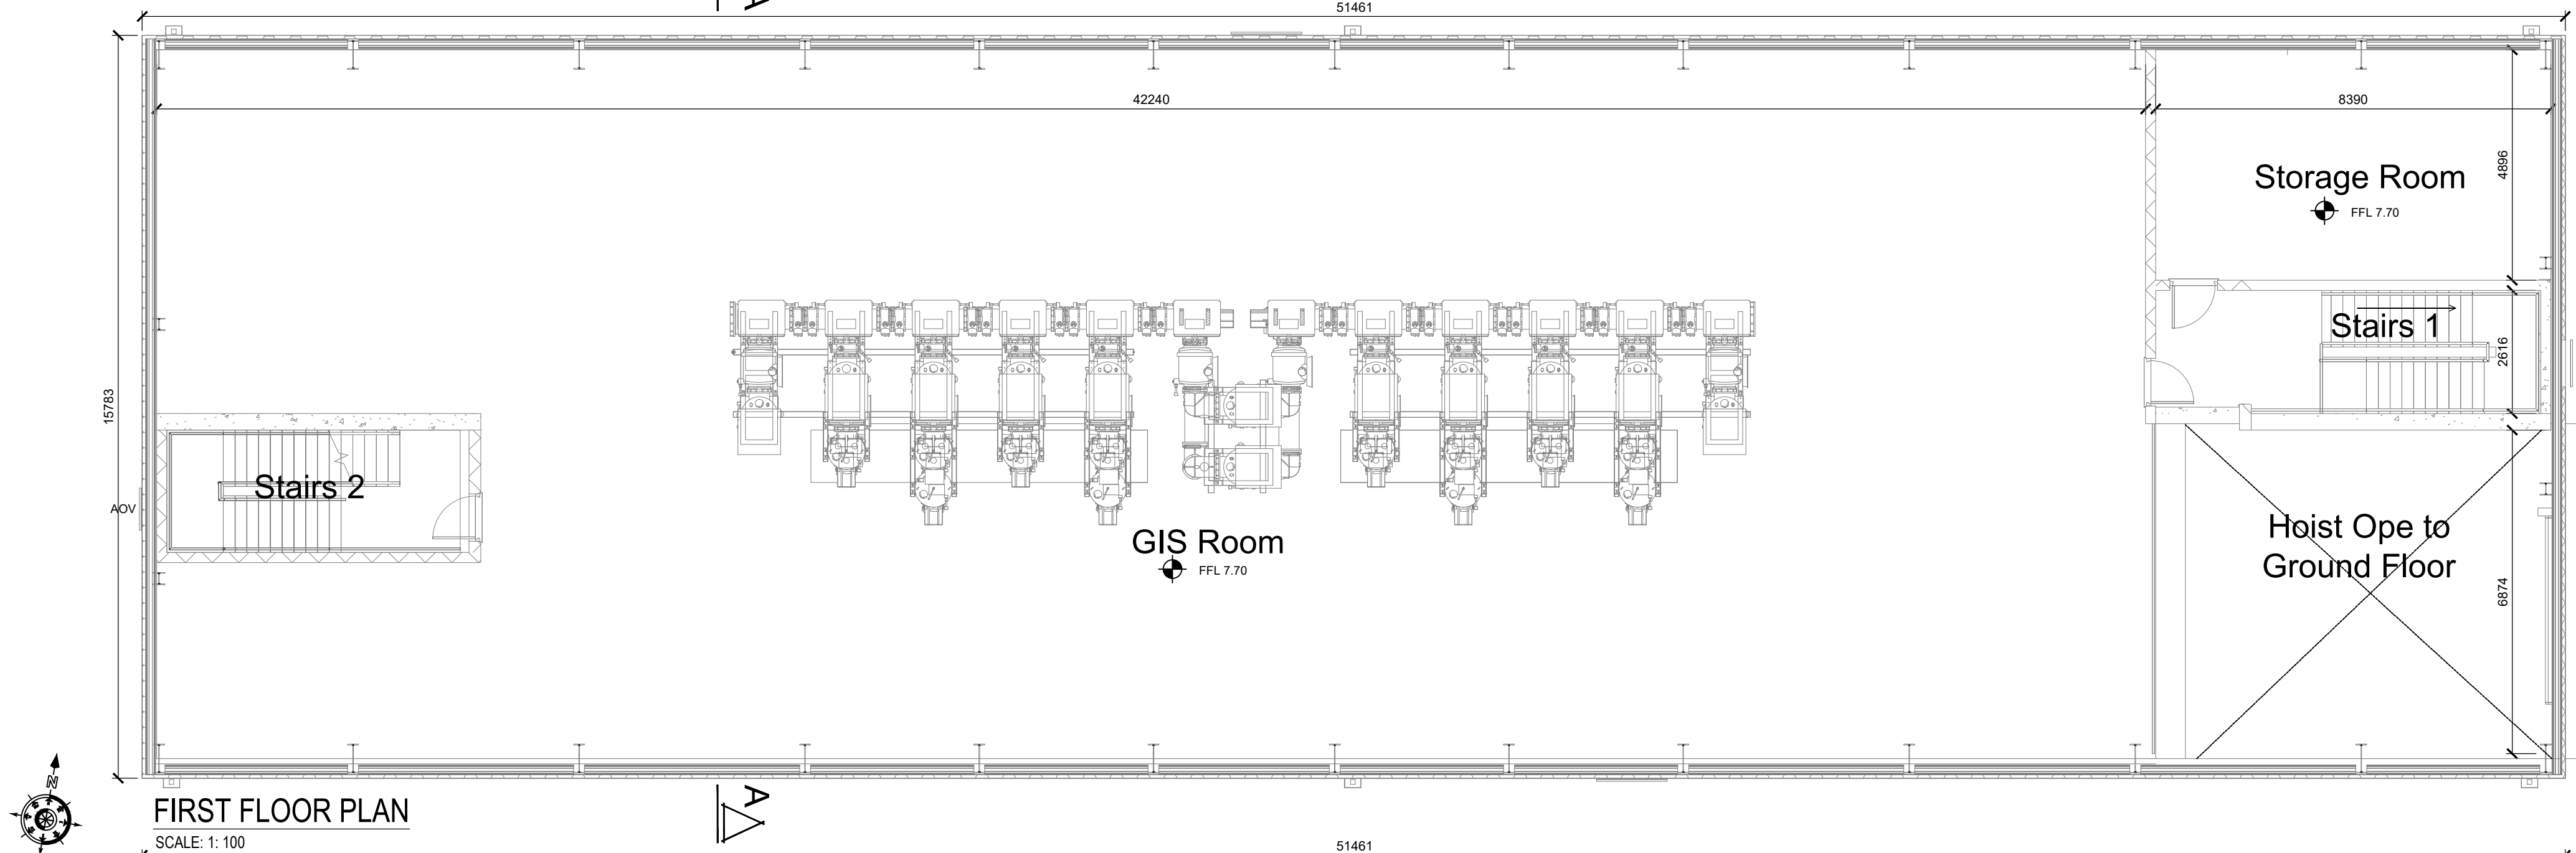

FIRST FLOOR PLAN
SCALE: 1: 100

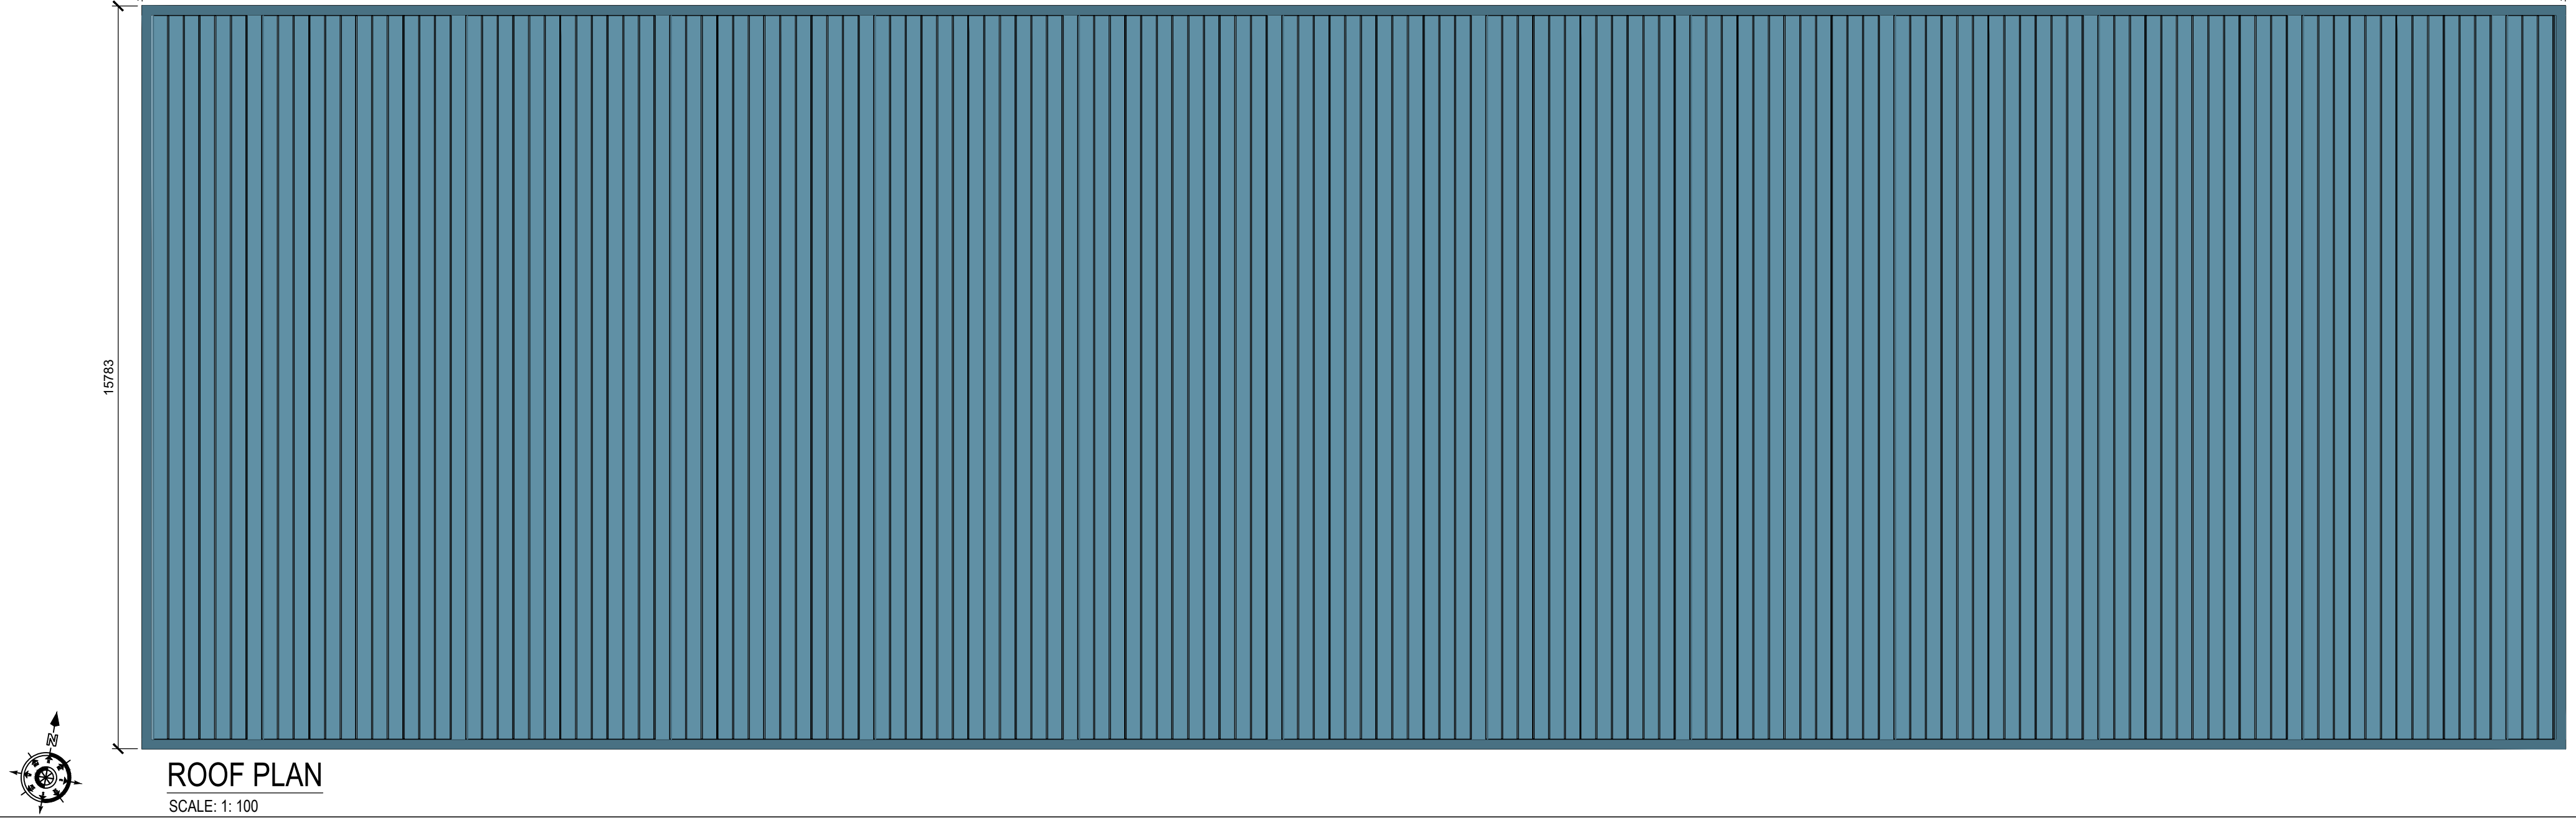

ROOF PLAN
SCALE: 1: 100

DO NOT SCALE FROM THIS DRAWING. USE FIGURED DIMENSIONS IN ALL CASES. VERIFY DIMENSIONS ON SITE AND REPORT ANY DISCREPANCIES TO THE DESIGNERS IMMEDIATELY. THIS DRAWING IS TO BE READ IN CONJUNCTION WITH THE DESIGNERS SPECIFICATION. © THIS DRAWING IS COPYRIGHT AND MAY ONLY BE REPRODUCED WITH THE DESIGNERS PERMISSION.

NOTES:

1. ALL DRAWINGS ARE TO BE READ IN CONJUNCTION WITH ALL RELEVANT SPECIFICATIONS, BILLS OF QUANTITIES, ARCHITECTURAL, SERVICES AND ENGINEERING DRAWINGS.
2. ALL LEVELS ARE IN **METRES** RELATED TO ORDNANCE DATUM MALIN HEAD, OSGM15.
3. ANY DISCREPANCIES BETWEEN THESE DOCUMENTS SHALL BE BROUGHT TO THE ATTENTION OF THE ENGINEER.
4. DRAWINGS ARE NOT TO BE SCALED.
5. ALL DIMENSIONS ARE IN **MILLIMETRES**, UNLESS NOTED OTHERWISE.

REV	DATE	DESCRIPTION	BY	APP
P04	26.11.2020	ISSUED FOR INFORMATION	NT	GMN
P03	16.11.2020	ISSUED FOR INFORMATION	NT	GMN
P02	06.11.2020	ISSUED FOR INFORMATION	NT	GMN
P01	23.10.2020	ISSUED FOR INFORMATION	NT	GMN

PROJECT: ECHOLON/POLLAHONEY 110KV SUBSTATION

TITLE: GIS BUILDING PLAN

CLIENT: **H&MV**
ENGINEERING
MALIN, TRALEE & LIMERICK

Malachy Walsh and Partners
Engineering and Environmental Consultants
Cork | Tralee | London | Limerick

The Elm Suite,
Loughmore Centre,
Limerick,
V94 R578
Tel: +353 (0) 61 480164
Fax: +353 (0) 61 441125
E-mail: limerick@mwp.ie
Web: www.mwp.ie

DRAWN: NT	CHECKED: GMN	APPROVED: BS
DATE: OCT '20	SCALE @ A1: 1:100	
PROJECT NUMBER: 21697	DRAWING STATUS: S2	

DRAWING NUMBER: 21697-MWP-SS-00-DR-C-0007 REV: P04