


LEGEND.

SITE BOUNDARY ————
 LANDOWNERSHIP ————

LEGEND:

EXISTING COMBINED SEWER ————
 PROPOSED FOUL SEWER ————
 PROPOSED SURFACE WATER SEWER ————
 PROPOSED FOUL RISING MAIN ————
 PROPOSED SURFACE WATER RISING MAIN ————

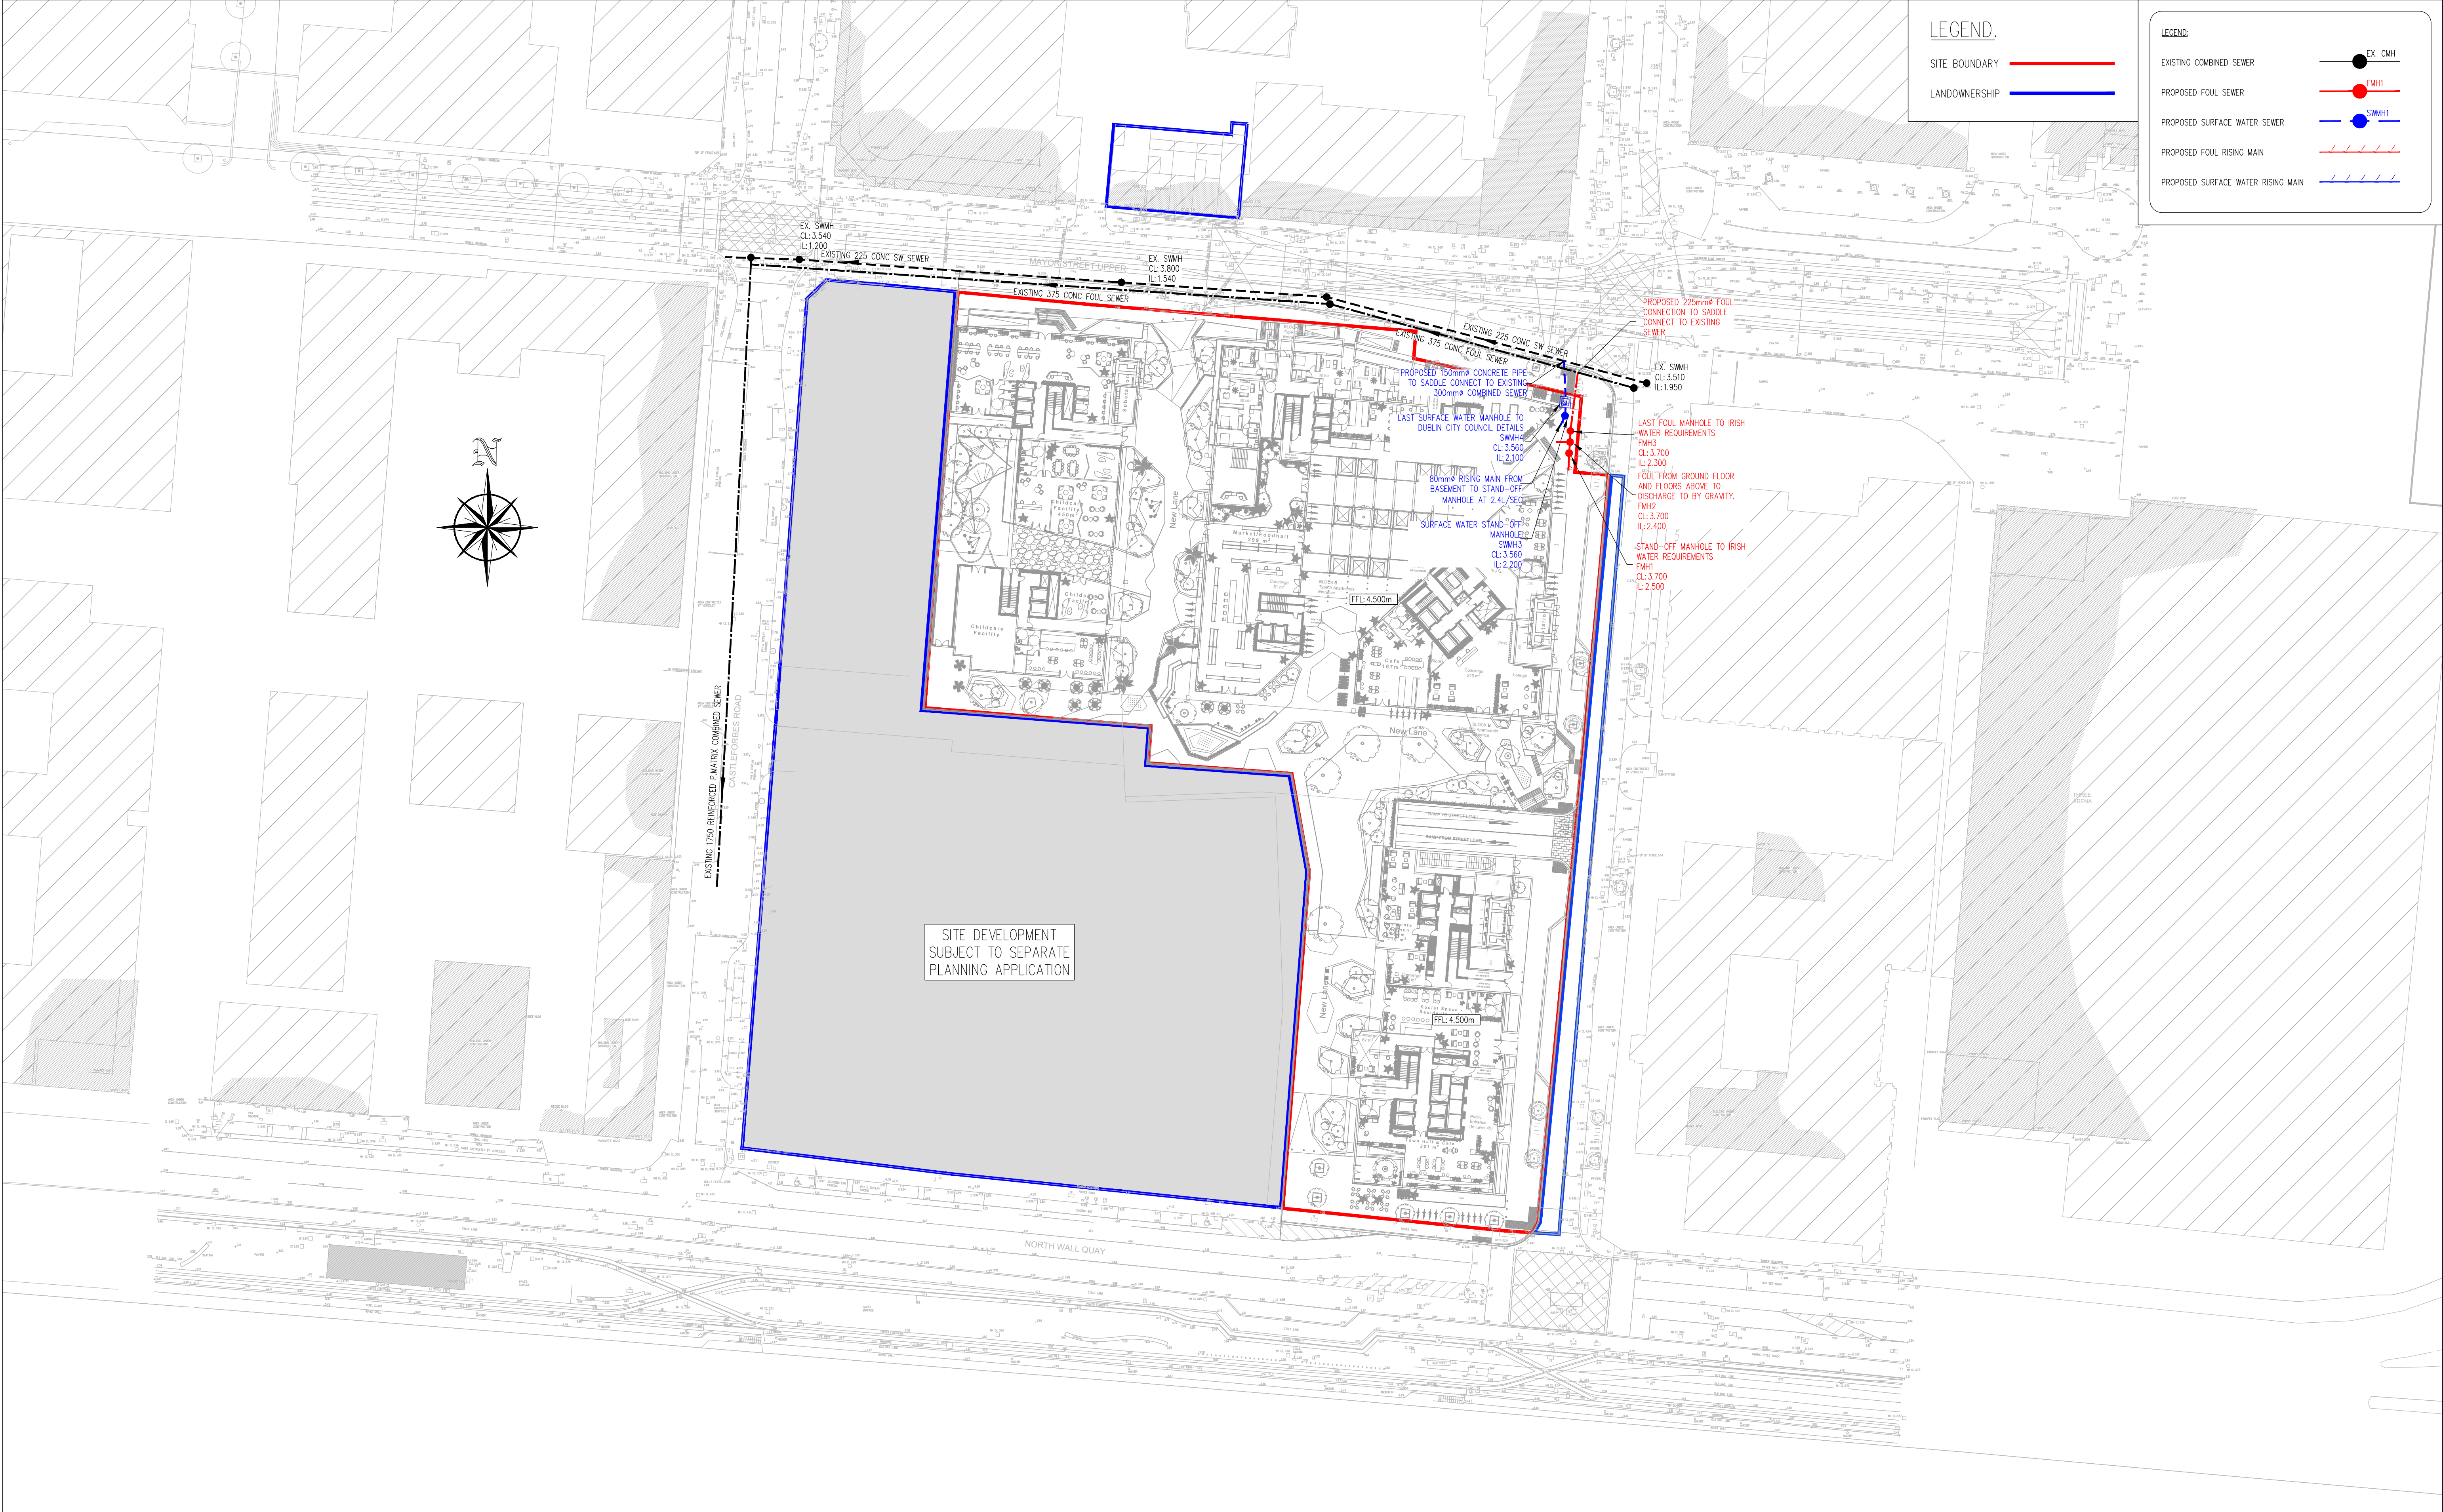

SITE DEVELOPMENT
 SUBJECT TO SEPARATE
 PLANNING APPLICATION

PLANNING DRAWING.
 NOT FOR CONSTRUCTION.
 ALL LEVELS GIVEN ARE
 RELATIVE TO ORDNANCE DATUM.
 THIS DRAWING HAS BEEN ISSUED FOR INFORMATION
 PURPOSES ONLY AND MUST NOT BE USED
 FOR CONSTRUCTION UNDER ANY CIRCUMSTANCES

- NOTES**
- For setting out refer to Architect's drawings.
 - This drawing to be read in conjunction with all other Architectural and Engineering drawings and all other relevant drawings and Specifications.
 - DO NOT SCALE THIS DRAWING. Use figured dimensions only.
 - No part of this document may be reproduced or transmitted in any form or stored in any retrieval system of any nature without the written permission as copyright holder except as agreed for use on the project for which the document was originally issued.
 - Ordnance Survey Ireland Licence Number EN 0074021

Rev. No.	Date	REVISION NOTE	Drn. By	Chkd. By
A	21.05.2020	Response to ABP comments An Bord Pleanála	JS	RFM
B	18/09/2020	Site Layout Revised	JS	NB
C	16/11/2020	Site Layout and Site Boundary Revised	JS	MD
D	08/01/2021	Revised for SHD Application.	JS	MD
E	15/01/2021	Site Boundary Revised	JS	MD

Architect	Henry J Lyons	
Project	Waterfront South Central SHD	
Title	Proposed Drainage Layout Ground Floor Layout	
Drn. by	DD	Chkd. by RFM
Date	Nov 2019	Scale 1:500 @ A1
Dwg. No.	R064-201	
Revision	E	

CS Consulting Group
 DUBLIN | LONDON | LIMERICK

Head Office
 19-22 Dame Street, Dublin 2.
 T: +353 (0)1 5480663 F: +353 (0)1 9011355
 e: info@csconsulting.ie
 w: www.csconsulting.ie

Quality Environment I.S. EN ISO 9001:2008
 NSAI Certified Energy I.S. EN ISO 14001:2004
 Health & Safety OHSAS 18001:2007