




NOTES:
 1. DO NOT SCALE. USE FIGURED DIMENSIONS ONLY.
 2. THIS DRAWING IS TO BE READ IN CONJUNCTION WITH ALL OTHER RELEVANT ARCHITECTURAL AND ENGINEERING DRAWINGS.

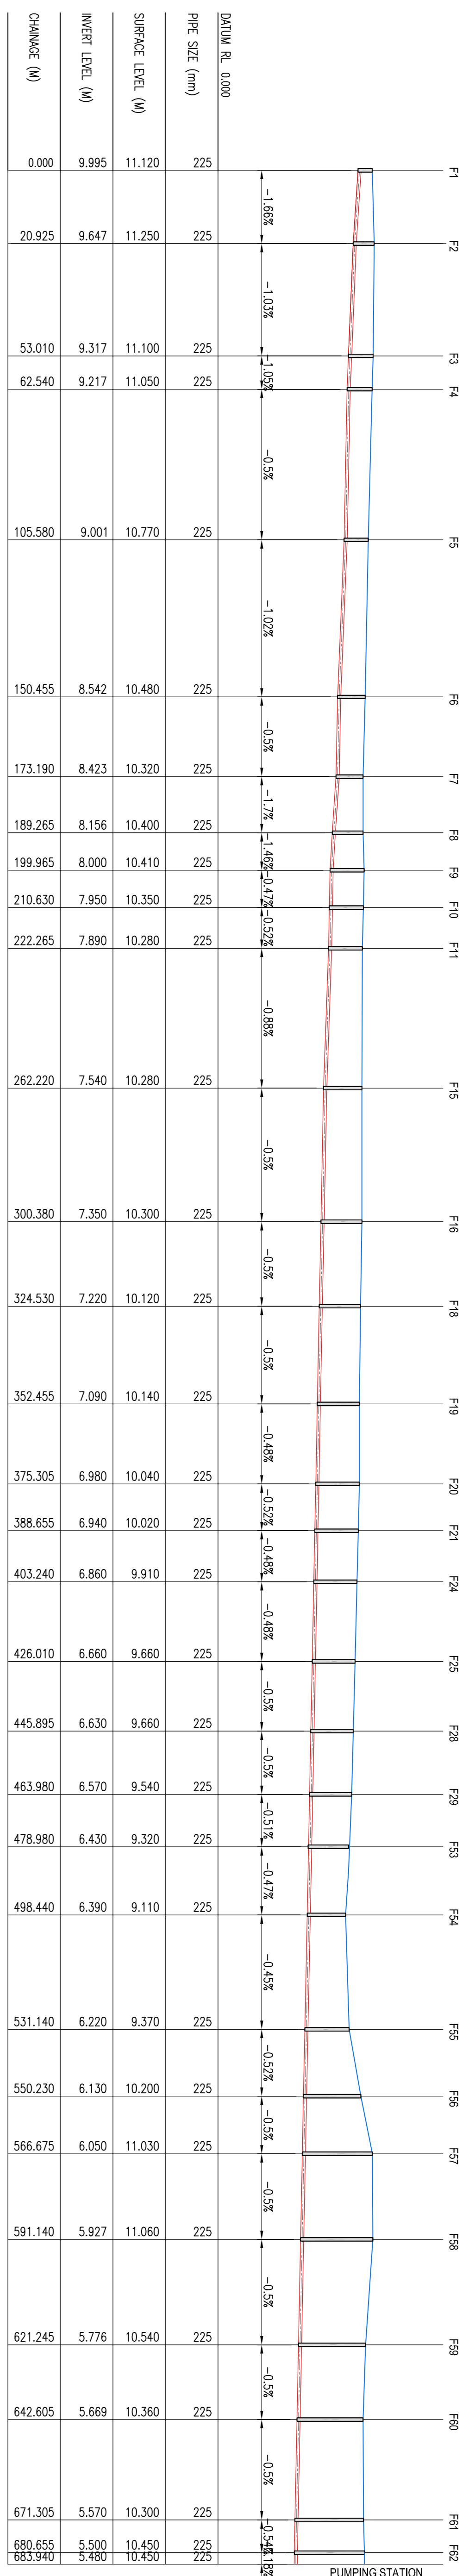


LONGITUDINAL SECTION FROM
 MANHOLE F1 TO FOUL PUMPING STATION
 SCALES - 1:1000 H
 1:250 V

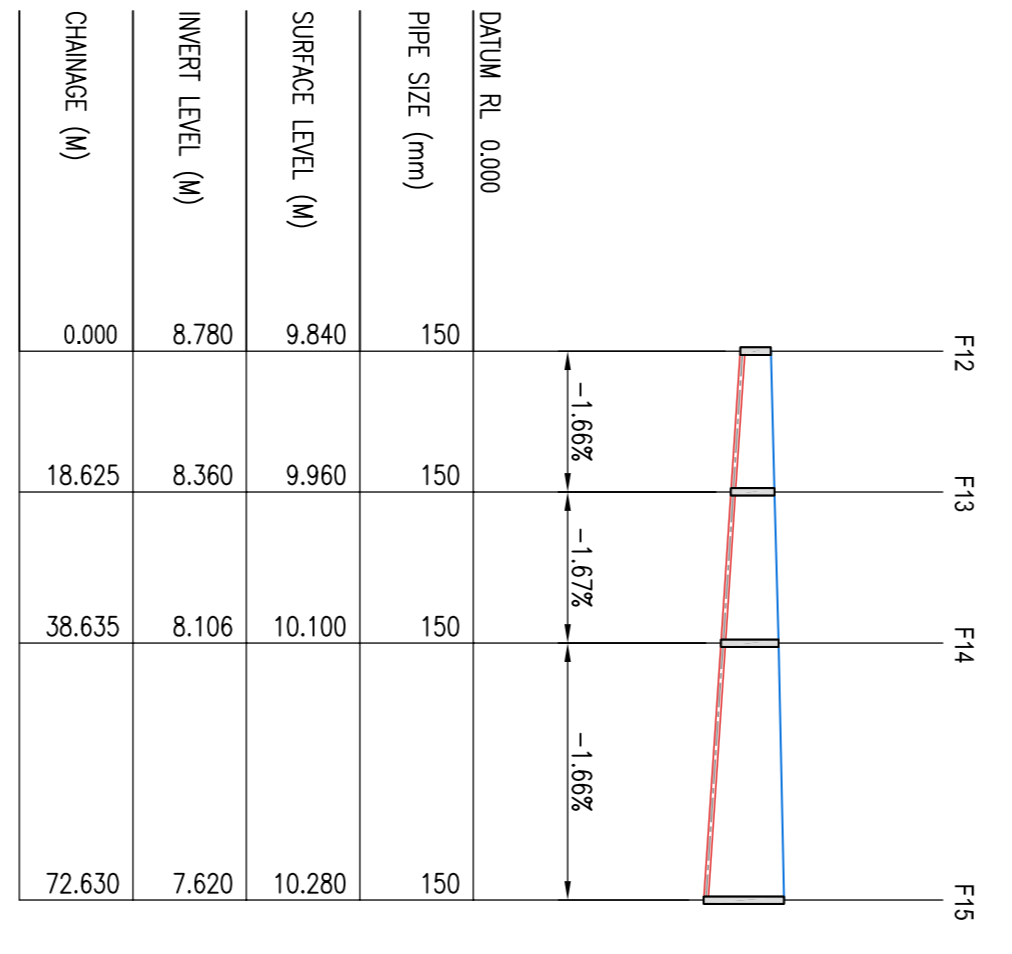


LONGITUDINAL SECTION FROM
 MANHOLE F12 TO F15
 SCALES - 1:1000 H
 1:250 V

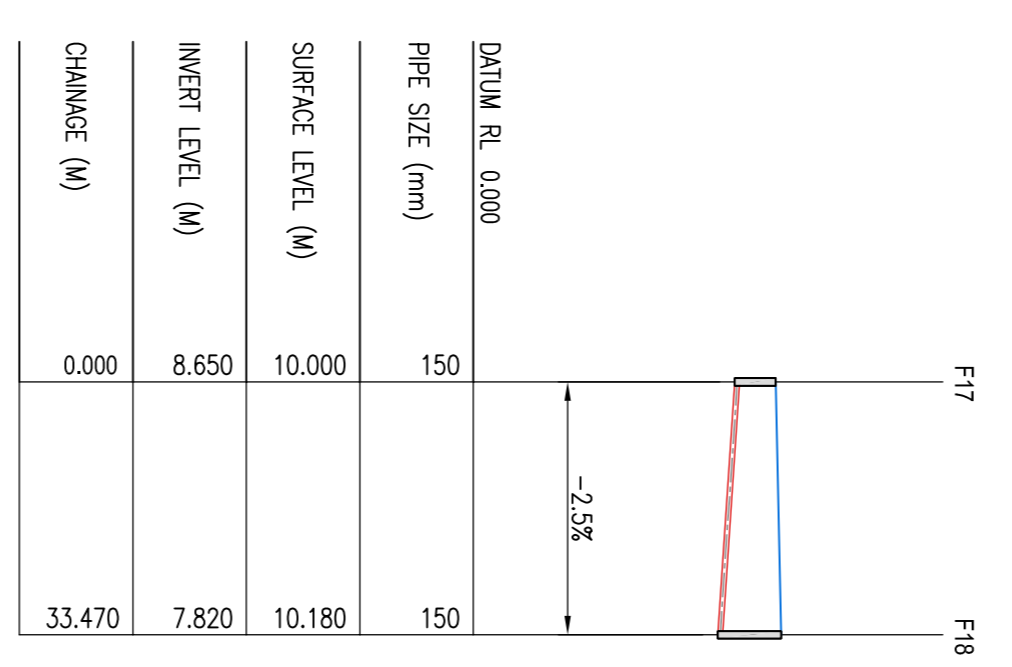


LONGITUDINAL SECTION FROM
 MANHOLE F17 TO F18
 SCALES - 1:1000 H
 1:250 V

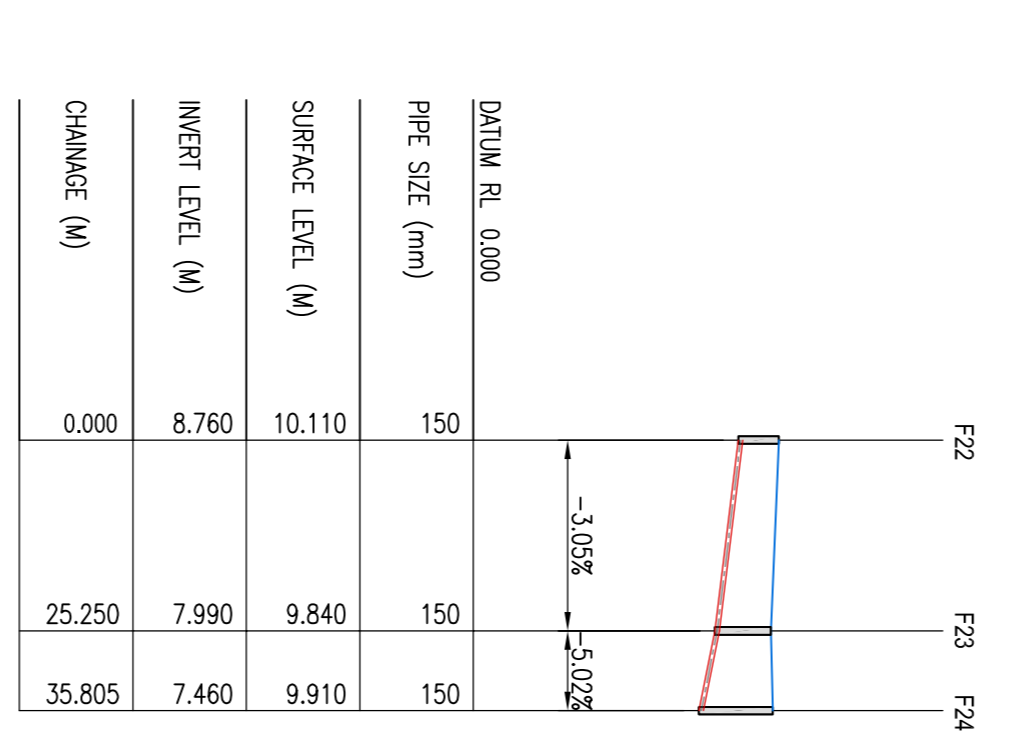


LONGITUDINAL SECTION FROM
 MANHOLE F22 TO F24
 SCALES - 1:1000 H
 1:250 V

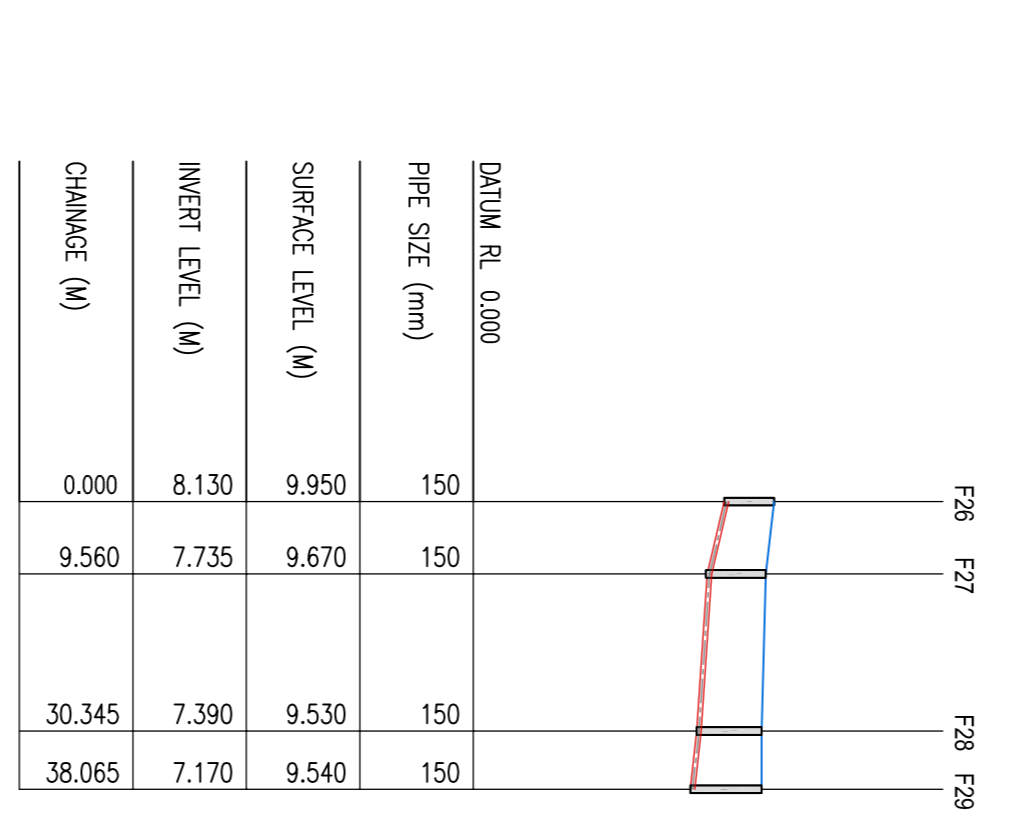


LONGITUDINAL SECTION FROM
 MANHOLE F26 TO F29
 SCALES - 1:1000 H
 1:250 V

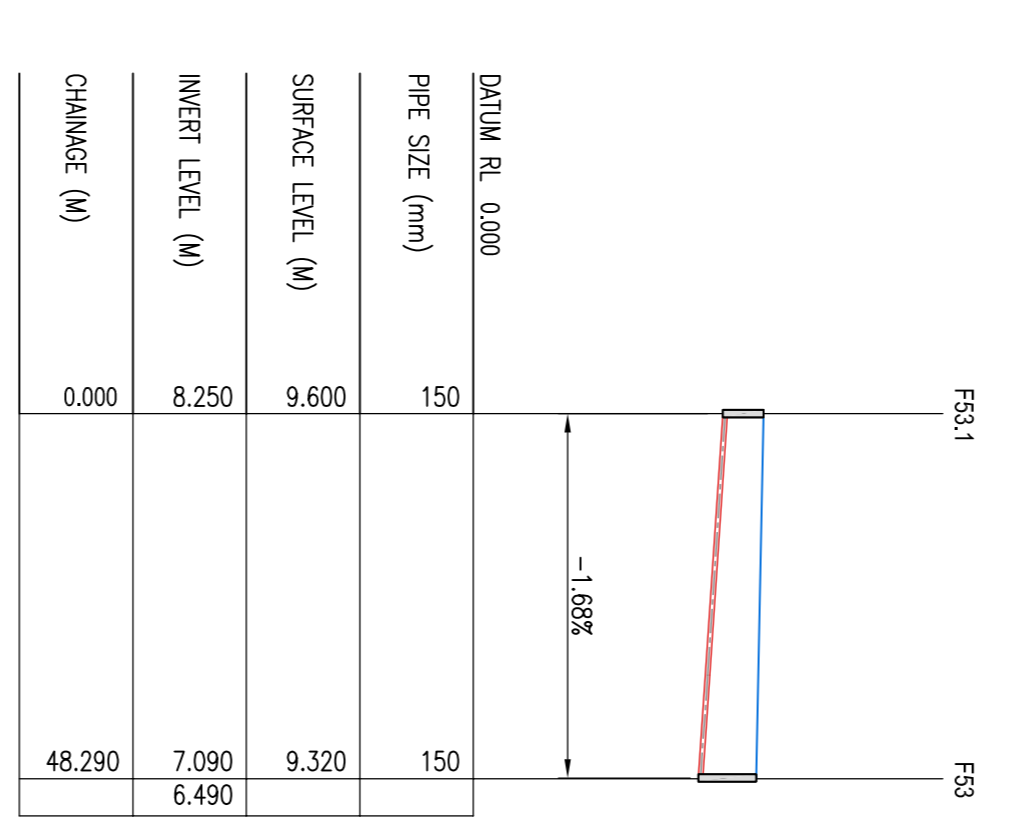


LONGITUDINAL SECTION FROM
 MANHOLE F31 TO F33.1
 SCALES - 1:1000 H
 1:250 V

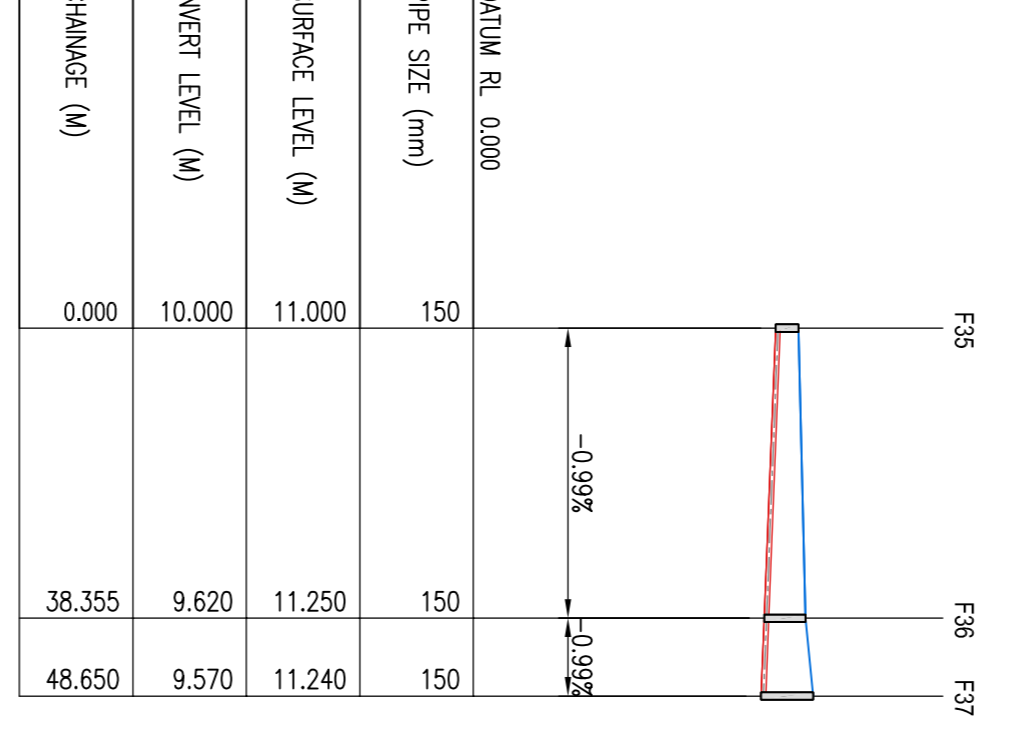


LONGITUDINAL SECTION FROM
 MANHOLE F35 TO F37
 SCALES - 1:1000 H
 1:250 V

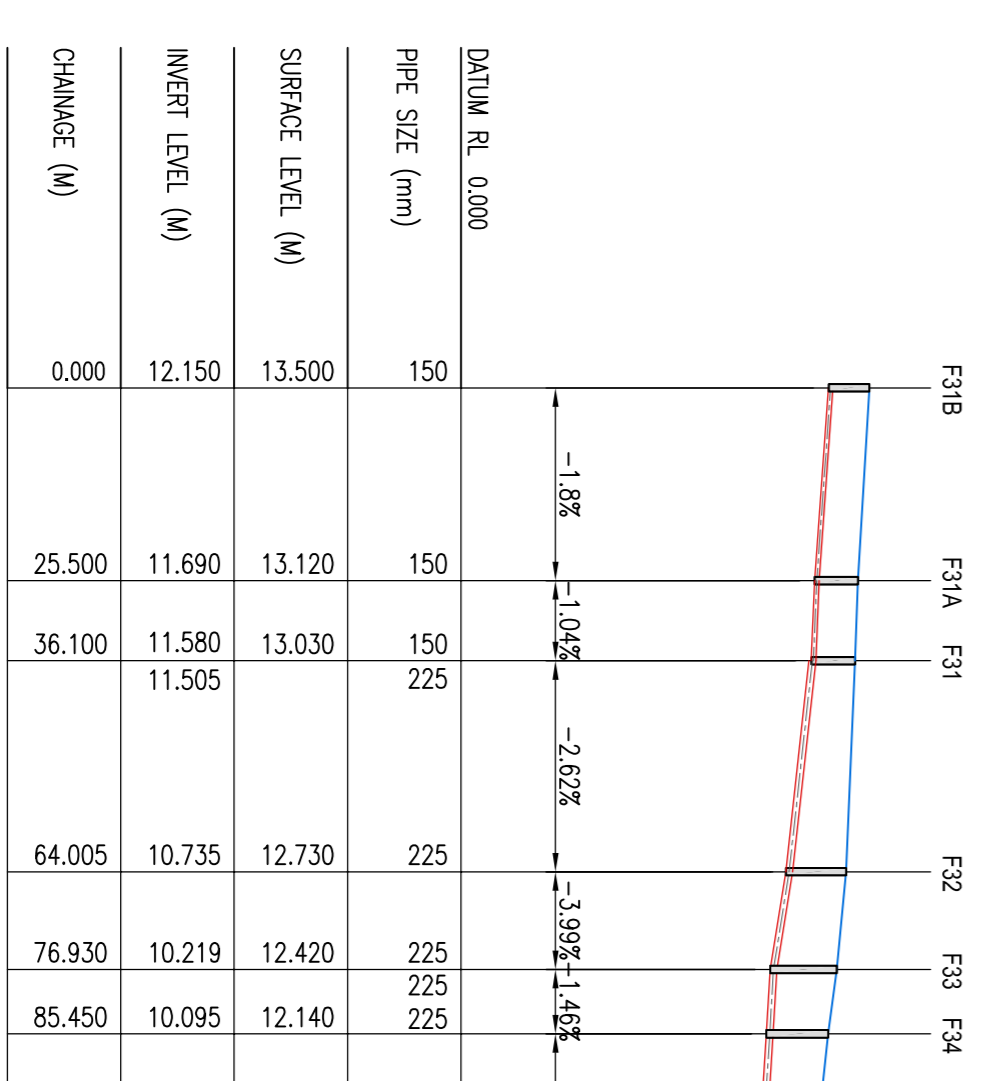


LONGITUDINAL SECTION FROM
 MANHOLE F31 TO F35
 SCALES - 1:1000 H
 1:250 V

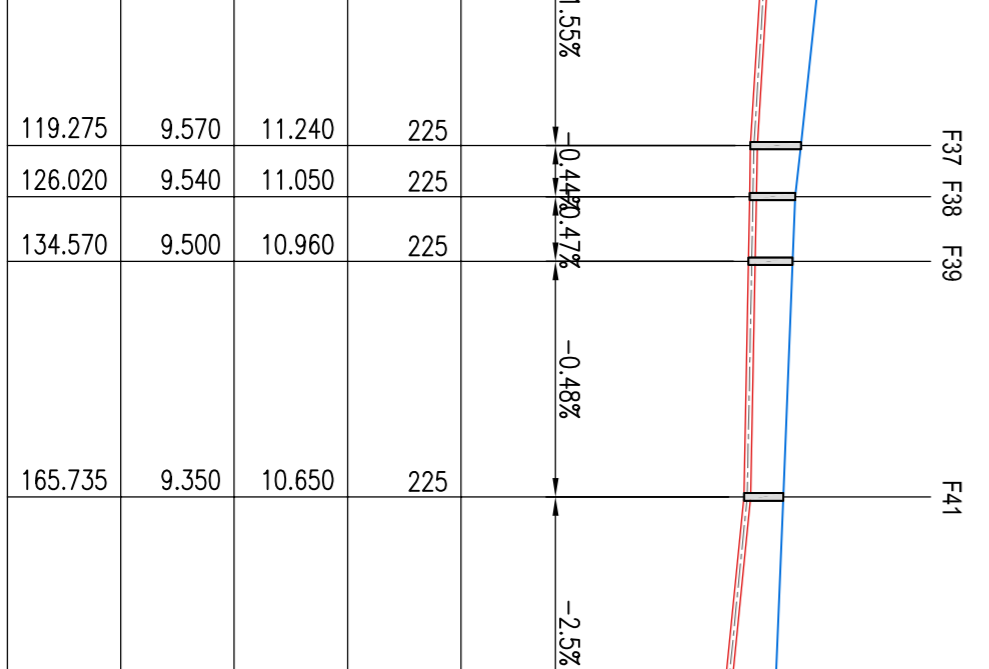


LONGITUDINAL SECTION FROM
 MANHOLE F37 TO F41
 SCALES - 1:1000 H
 1:250 V

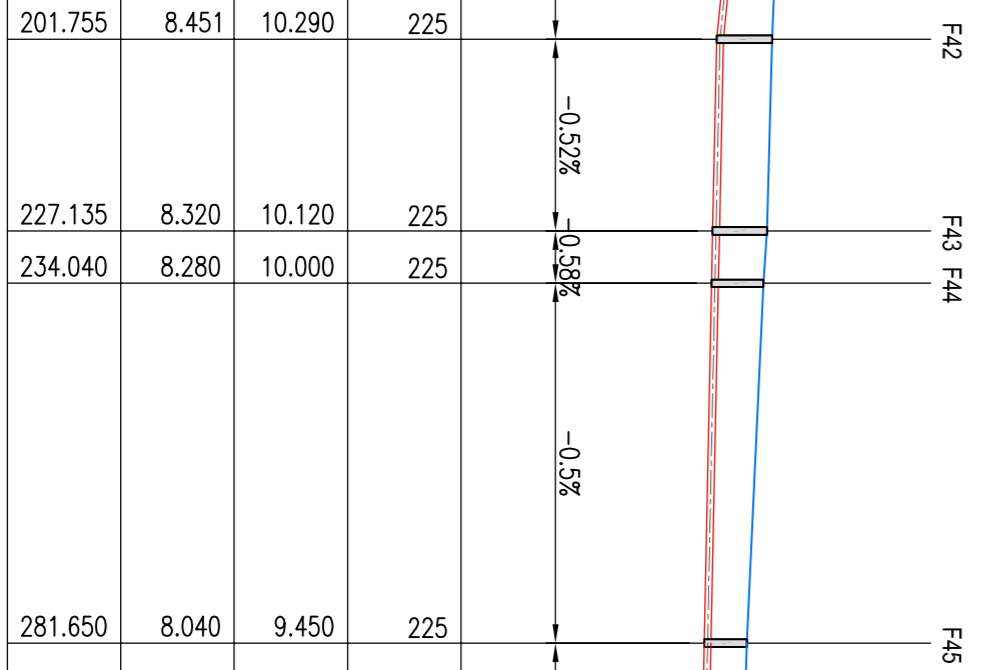


LONGITUDINAL SECTION FROM
 MANHOLE F42 TO F44
 SCALES - 1:1000 H
 1:250 V

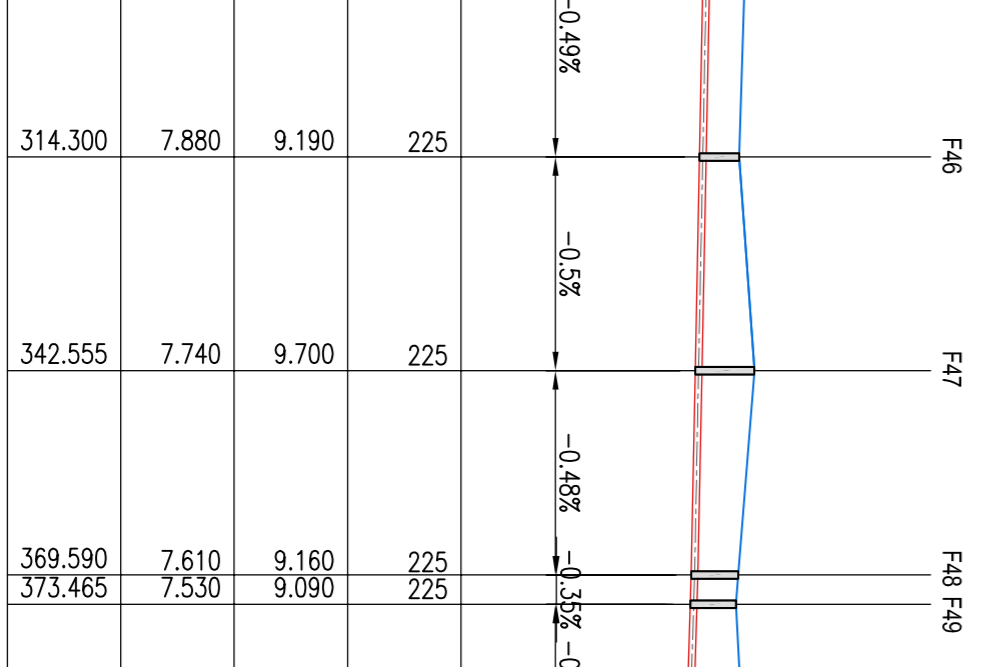


LONGITUDINAL SECTION FROM
 MANHOLE F46 TO F49
 SCALES - 1:1000 H
 1:250 V

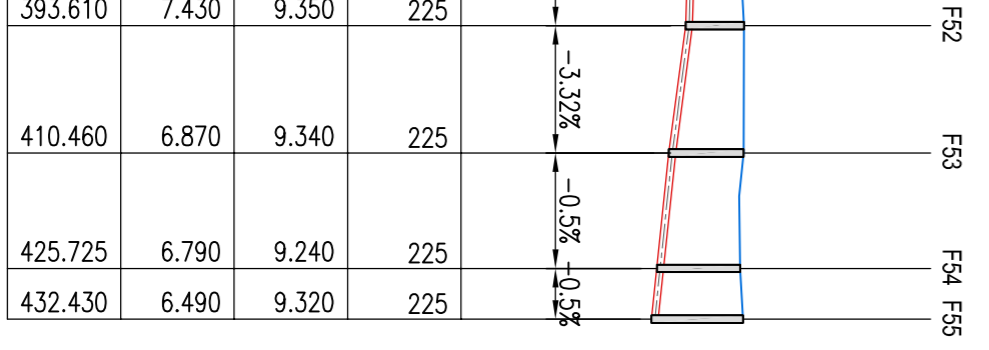


LONGITUDINAL SECTION FROM
 MANHOLE F49 TO F51
 SCALES - 1:1000 H
 1:250 V

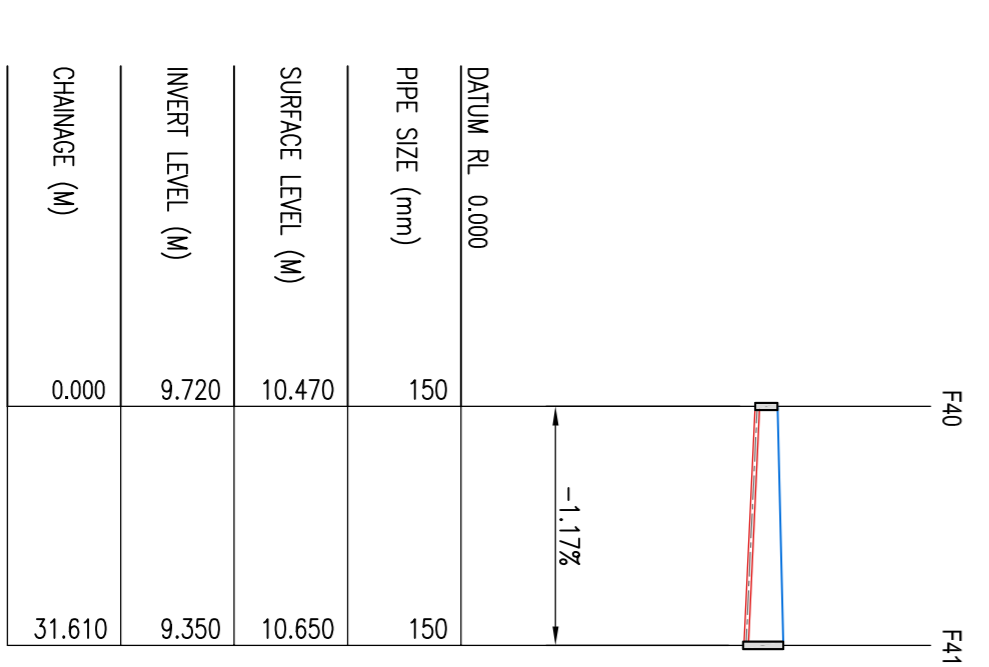


LONGITUDINAL SECTION FROM
 MANHOLE F40 TO F41
 SCALES - 1:1000 H
 1:250 V

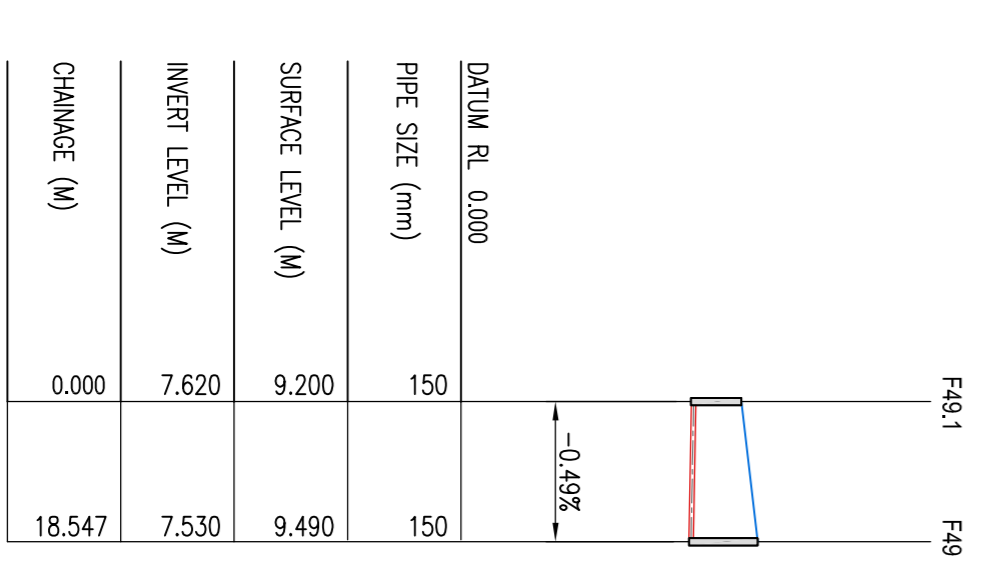

LONGITUDINAL SECTION FROM
 MANHOLE F49 TO F49.1
 SCALES - 1:1000 H
 1:250 V

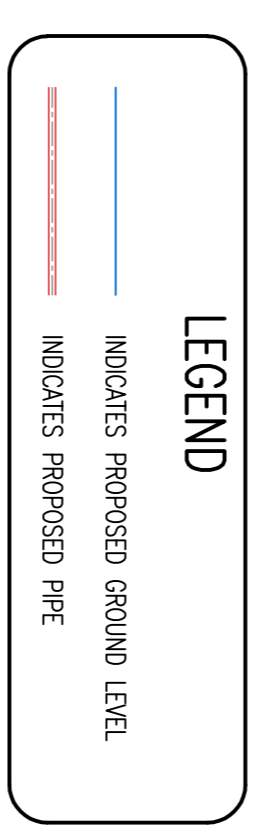

NOTE:
 REFER TO DRAWING 19-020, P201, P202, P203
 FOR DRAINAGE LAYOUTS

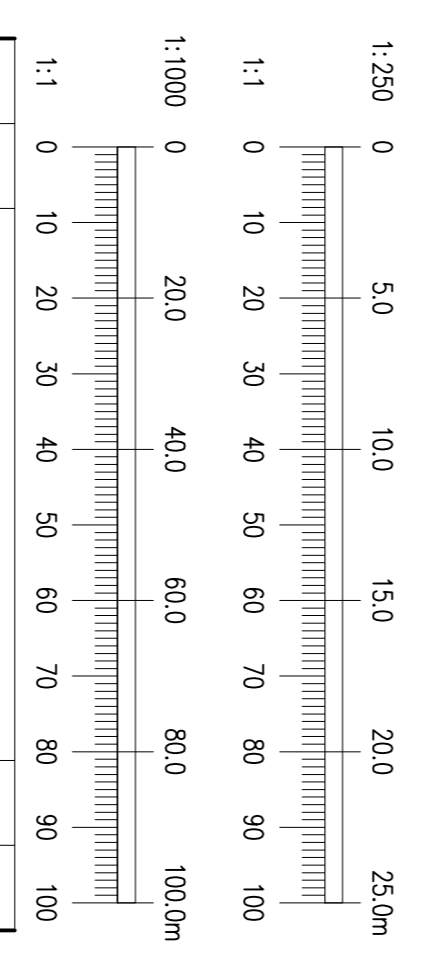

REV.	DATE	DESCRIPTION	DRN	APPD
A	07/11/21	REVISED FOR FINAL SUBMISSION	PJD	MD
		AMENDMENT		

Waterman Moylan
 Engineering Consultants
 BLOCK 5, EASTPOINT BUSINESS PARK, ALFIE BRYNE ROAD,
 DUBLIN D03 H9F4 IRELAND.
 Tel: 01761 8801 Fax: 01761 861 3818
 Email: info@watermanmoylan.ie www.watermanmoylan.ie

KINNEST LTD.
 CLIENT
 ARCHITECT CONROY CROWE KELLY ARCHITECTS
 PROJECT
 ALBURN, MALAHIDE, CO. DUBLIN

FOUL DRAINAGE LONGITUDINAL SECTIONS

DRAWN	DESIGNED	APPROVED	DATE
PJD	MD	MD	NOV '20
SCALE	JOB NO.	DRG NO.	REVISION
1:1000H, 1:250 V	19-020	P204	A