


SIXTH FLOOR FINISHED FLOOR LEVEL - 105.650
 SLAB LEVEL - 105.630
 CEILING LEVEL - 108.285



- LEGEND**
- RESIDENTS AMENITIES
 - RESIDENTS AMENITIES (SPECIFIED HOURS FOR USE BY LOCAL COMMUNITY)
 - SHARED AMENITIES (FOR USE BY RESIDENTS AND LOCAL COMMUNITY)
 - STUDIO
 - 1 BED APARTMENT - 2 PERSON
 - 2 BED APARTMENT - 3 PERSON
 - 2 BED APARTMENT - 4 PERSON
 - 3 BED APARTMENT - 5 PERSON
 - SHARED RESIDENTIAL AMENITY ENTRANCES
 - RESIDENTIAL ENTRANCES
 - APPLICATION SITE BOUNDARY (RED LINE)
- REFER TO LANDSCAPE ARCHITECTS DRAWING FOR FURTHER DETAILS OF HARD AND SOFT LANDSCAPING AND BOUNDARY FINISHES

FLOOR	STUDIO	1 BED 2 P	2 BED 3P	2 BED 4P	3 BED 5P	TOTAL
1	3	32	-	11	-	46
2	2	33	-	10	2	47
3	2	33	-	10	2	47
4	2	27	2	12	2	45
5	2	27	2	12	2	45
6	3	28	-	10	-	41
7	11	21	2	7	-	41
8	9	16	-	4	-	29
9	2	15	-	3	-	20
10	2	15	-	3	-	20
11	-	7	-	1	-	8
12	-	7	-	1	-	8
13	-	7	1	-	-	8
14	-	7	1	-	-	8
15	3	4	1	-	-	8
16	1	6	1	-	-	8
TOTAL	41	285	10	84	8	428

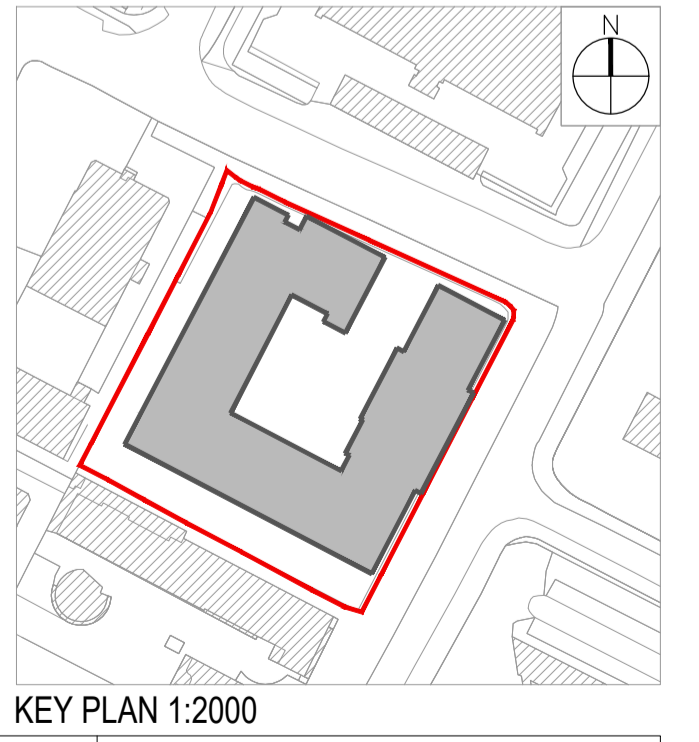

Notes

- Copyright Reserved
- Work to figured dimensions only. Do not scale drawing
- The contractor is responsible for checking all levels and dimensions on site and shall refer all discrepancies to the Architect
- Where appropriate, for details of i.c. structure, or mechanical and electrical details, see Engineers drawings
- Proprietary items shall be checked in strict accordance with manufacturers instructions.
- Sizes of proprietary items shall be checked with manufacturer.
- The contractor shall be responsible for the coordination of structure, finishes and services.

Issue Status

Progress	Planning Application	Fire Cert	Disability Cert	Tender	Construction	As Built	Information Only

W:\Project Section - Current\6246 Residential Development Sandford Avid Site\CAD\Drawings\Construction\Plans\6246 - Plans.dwg 05/03/2021 22:09:45

No.	Date	Revision	Initials
PL1	JUNE 2020	PLANNING APPLICATION ISSUE	FF
PL2	JAN 2021	PLANNING APPLICATION ISSUE	ML

Project Carmanhall Road SHD Atlas GP Ltd.

Drawing Title Proposed Sixth Floor Plan

Drawing No 6246-108

Scale 1:200@A1 **Rev** PL2 **Drawn** ML **Date** 05/03/20

6-7 HARDCOURT TERRACE, DUBLIN 2, IRELAND
 T: +353 1 418 2400 F: +353 1 476 7305
 www.bkd.ie

bkdarchitects
 BURKE-KENNEDY DOYLE