

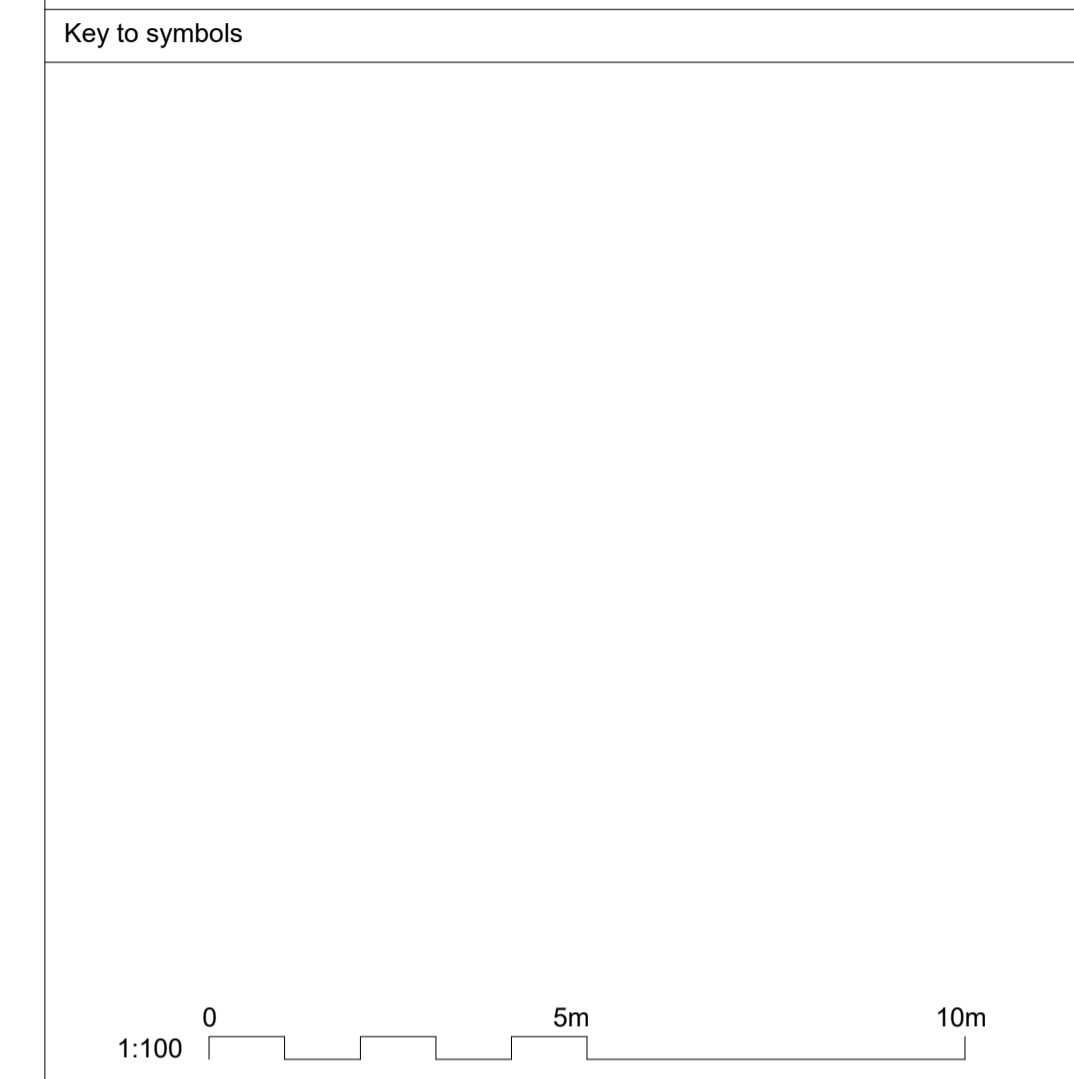
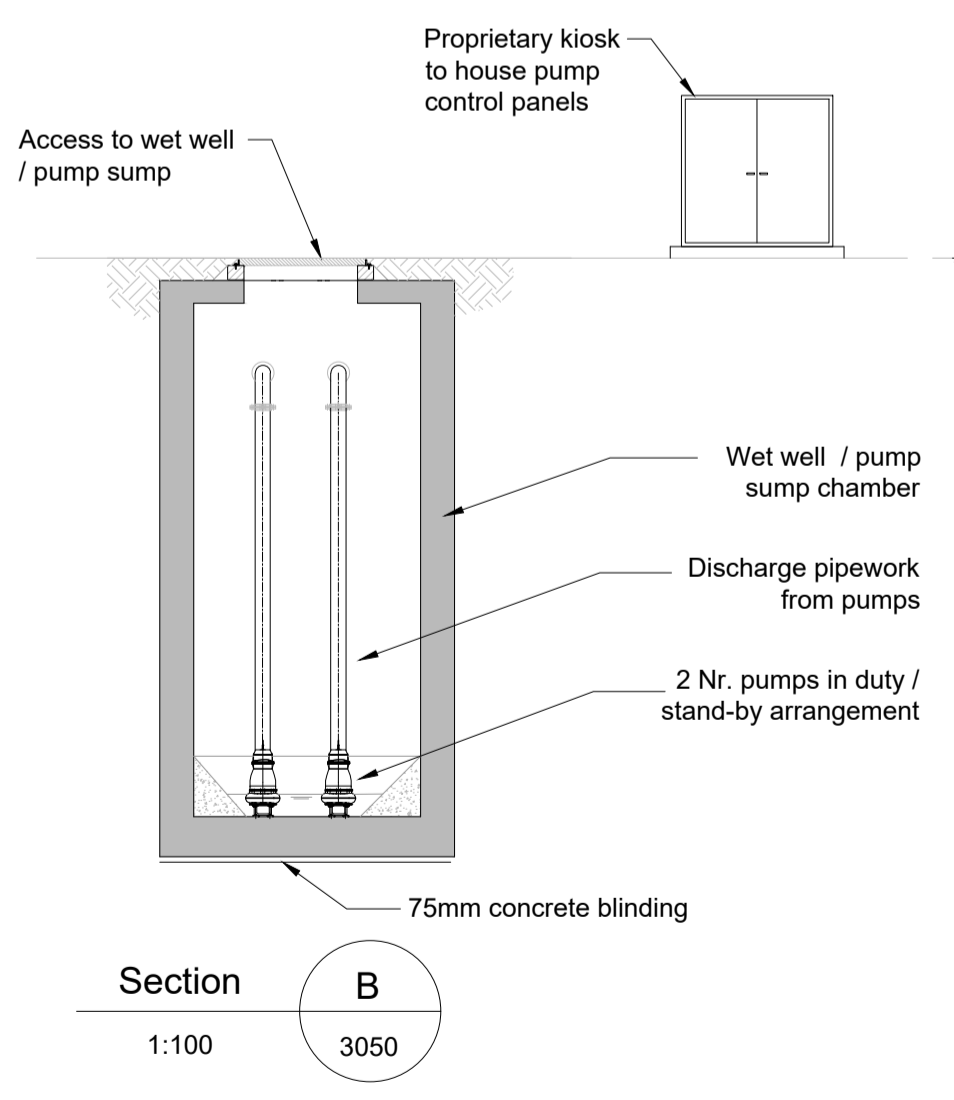


- Notes
1. Design suitable for Planning purposes only. Not suitable for Construction.
 2. This drawing to be read in conjunction with all other drawings and specifications.
 3. All levels are in metres relative to Ordnance Datum at Malin Head.
 4. Do not scale off this drawing. Use figured dimensions only.
 5. Layout and depth of tank is indicative and subject to change pending outcome of stakeholder consultations, detailed design and site investigations.

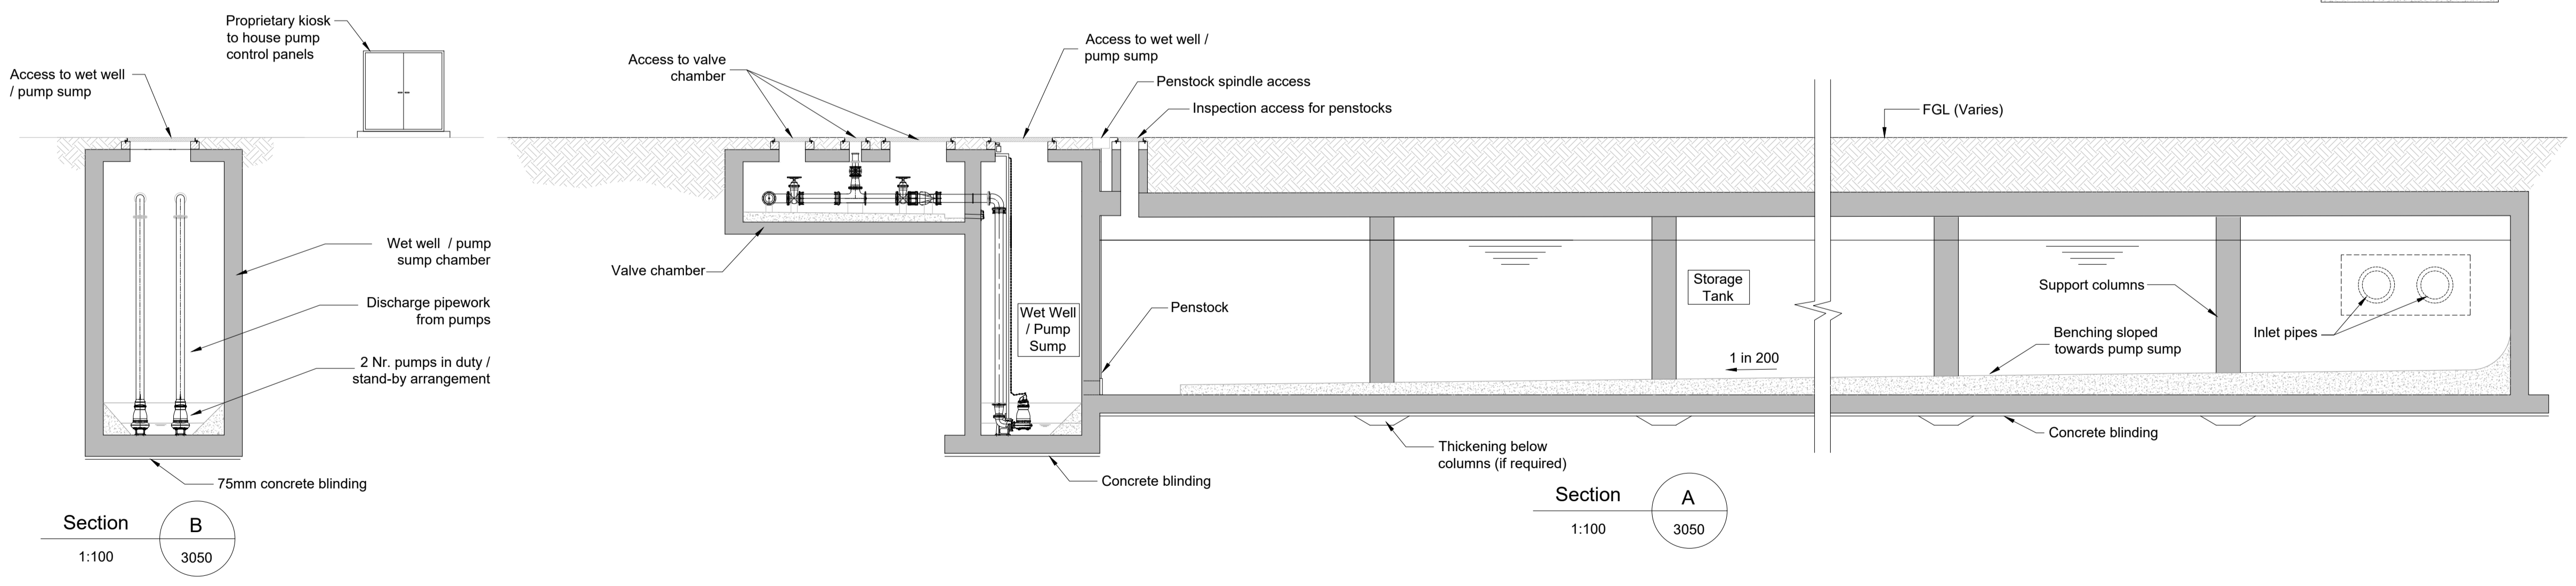

- Reference drawings
- 229100428-MMD-00-XX-DR-E-3040 - Overview of Water and Drainage Proposals
 - 229100428-MMD-00-XX-DR-E-3041 - Proposed Storm Water Drainage Layout Sheet 1 of 2
 - 229100428-MMD-00-XX-DR-E-3042 - Proposed Storm Water Drainage Layout Sheet 2 of 2
 - 229100428-MMD-00-XX-DR-E-3043 - Proposed Foul Drainage Layout
 - 229100428-MMD-00-XX-DR-E-3044 - Proposed Watermain Layout - Sheet 1 of 2
 - 229100428-MMD-00-XX-DR-E-3045 - Proposed Watermain Layout - Sheet 2 of 2
 - 229100428-MMD-00-XX-DR-E-3046 - Typical Drainage Details Sheet 1 of 6 - Stormwater Manholes and Gullies
 - 229100428-MMD-00-XX-DR-E-3047 - Typical Drainage Details Sheet 2 of 6 - Oil / Fuel Interceptor
 - 229100428-MMD-00-XX-DR-E-3048 - Typical Drainage Details Sheet 3 of 6 - Flow Control Chamber
 - 229100428-MMD-00-XX-DR-E-3049 - Drainage Details Sheet 4 of 6 - Attenuation Storage Tank
 - 229100428-MMD-00-XX-DR-E-3051 - Drainage Details Sheet 6 of 6 - Emergency Shut-Off Valve Chamber

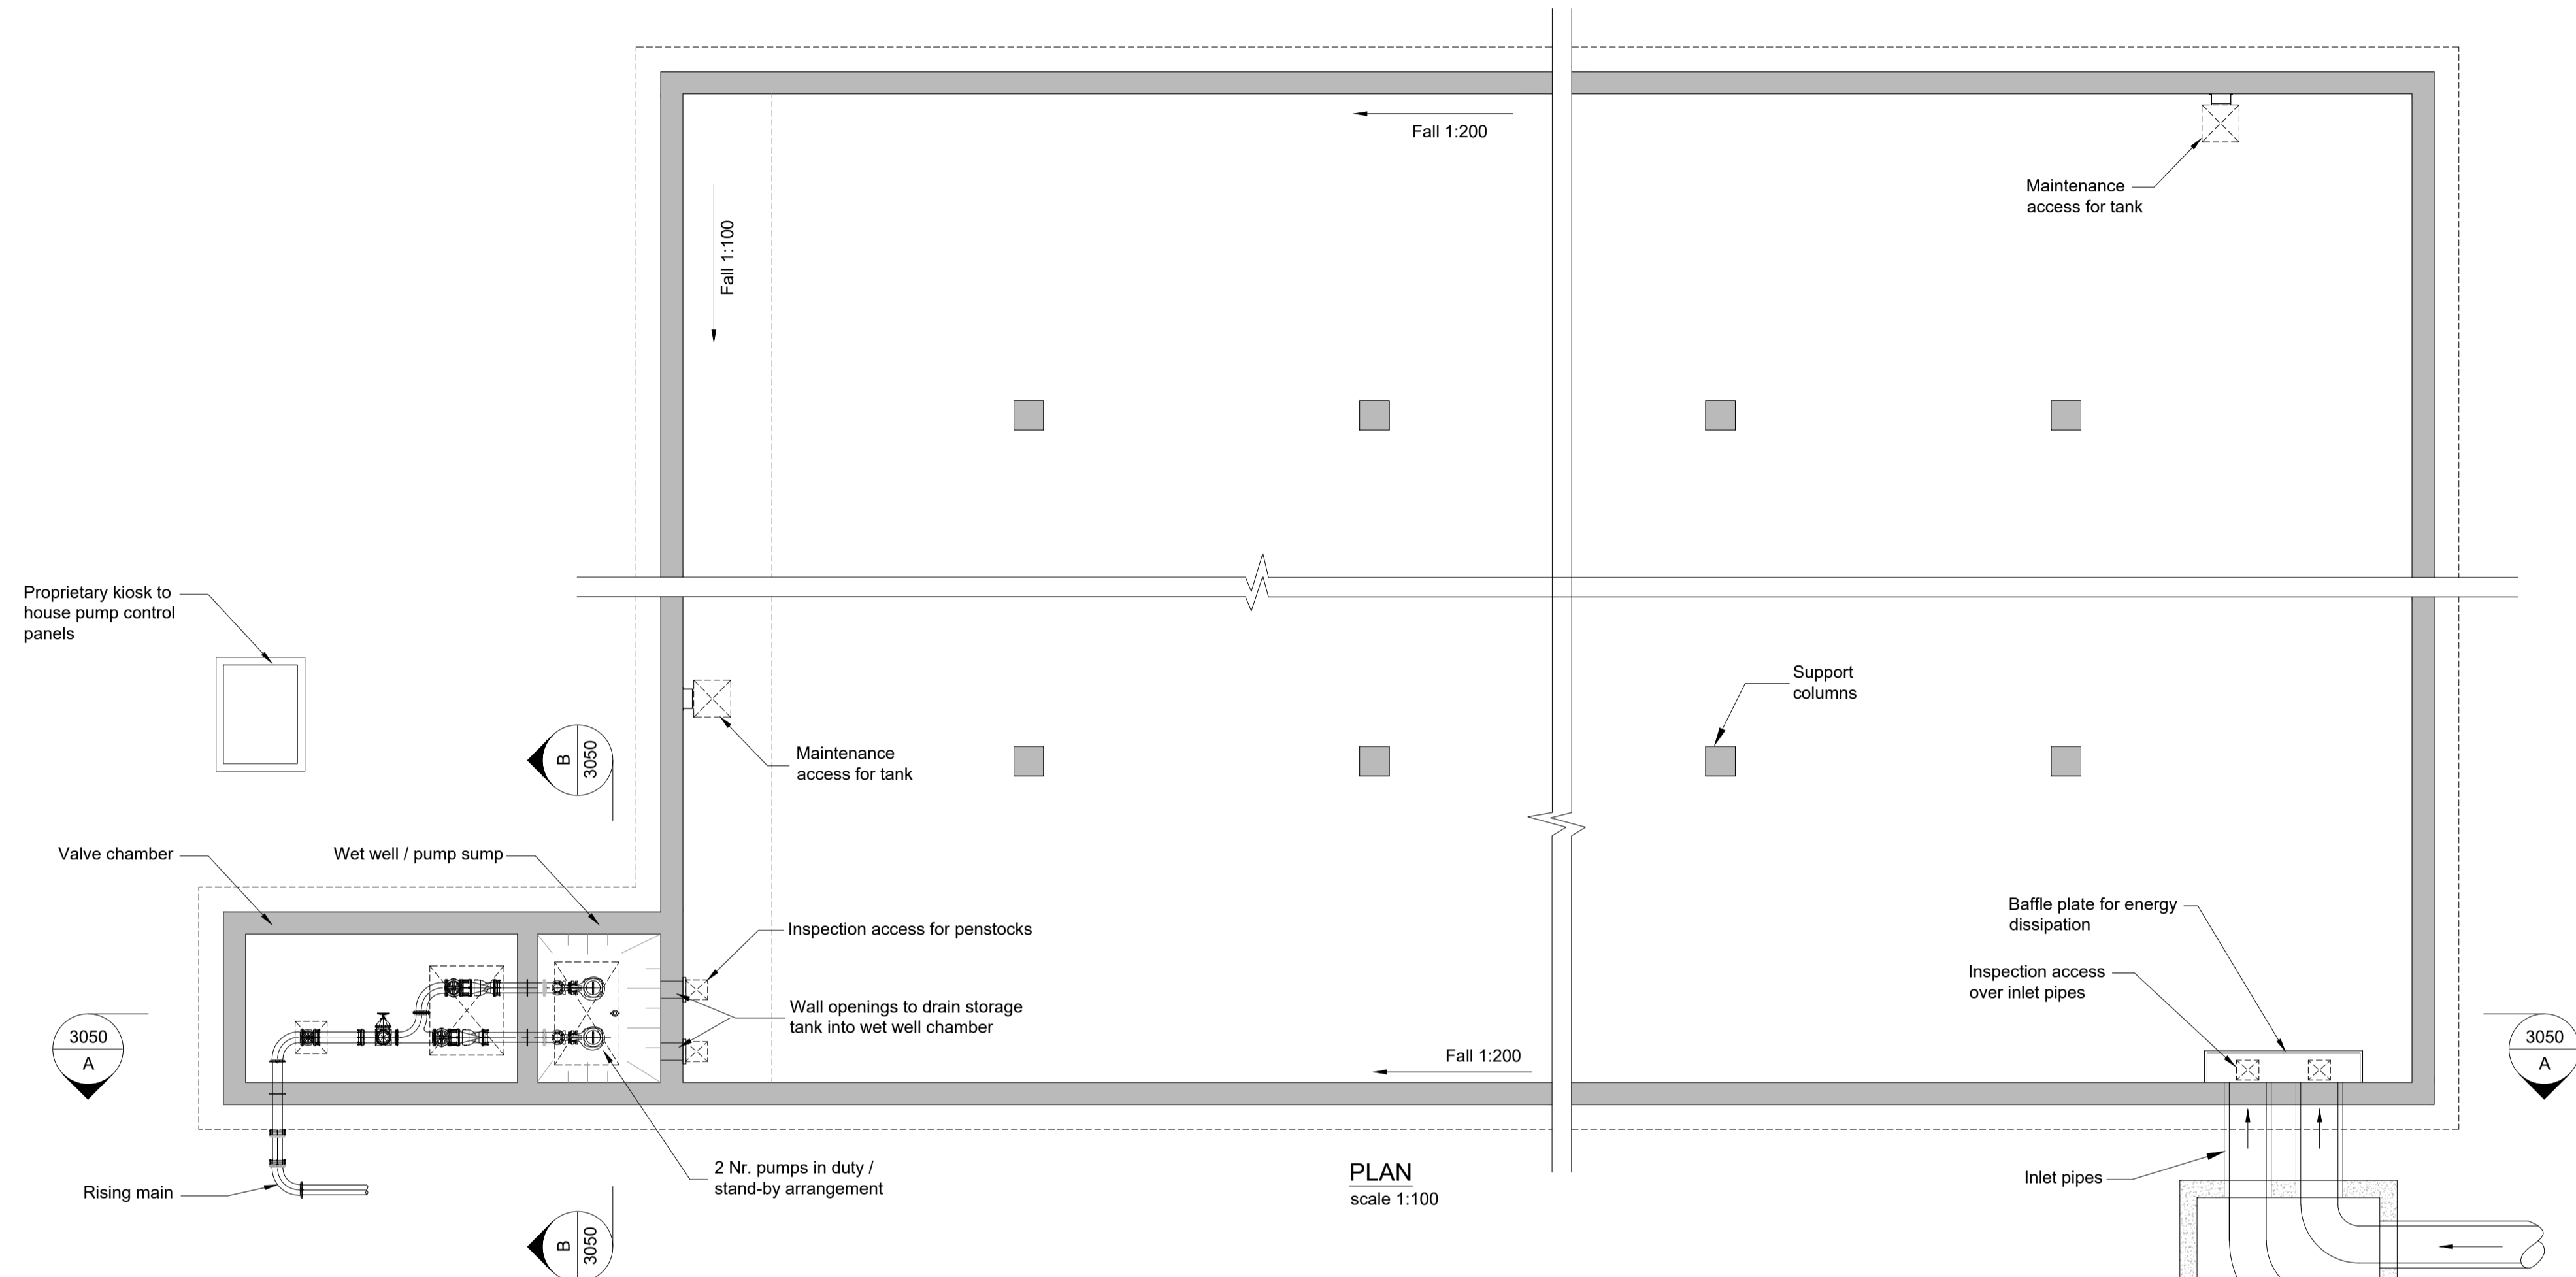

| | | | | | |
|-----|------------|-------|---------------------|--------|-------|
| PL1 | 25/06/2021 | SHY | Issued for Planning | DH | TK |
| Rev | Date | Drawn | Description | Ch'k'd | App'd |

MOTT MACDONALD

South Block
Rockfield
Dundrum
Dublin 16
Ireland
T +353 (0)1 291 6700
F
W www.mottmac.com



Title

Celtic Interconnector

Converter Station Site (at Ballyadam)

Typical Drainage Details - Sheet 5 of 6

Compensation Storage Tank

| | | | |
|----------------|--------------|-------------------------------|------------|
| Designed | D.Murphy | Eng check | D.Murphy |
| Drawn | E.Richardson | Coordination | D.Monaghan |
| Dwg check | D.Murphy | Approved | T. Keane |
| Scale at A1 | Status | Rev | Security |
| As Shown | APR | PL1 | STD |
| Drawing Number | | 229100428-MMD-00-XX-DR-E-3050 | |