


LEGEND

1	PLANNING BOUNDARY (RED LINE)
2	SITE BOUNDARY (BLUE LINE)
3	LNG POWER PLANT, REF. PLANT DRAWINGS FOR DETAILS
4	FSRU JETTY, REF. MARINE DRAWINGS FOR DETAILS
5	CONSTRUCTION LAYDOWN AREA
6	IGN PROCESSING PLANT, REF. IGN DRAWINGS FOR DETAILS
7	NOT USED
8	NOT USED
9	SITE ROADWAYS, REF. PLANT DRAWINGS FOR DETAILS
10	NOT USED
11	STREAM CROSSING, REF. PLANT DRAWINGS FOR DETAILS
12	SITE FENCING AND GATE, REF. PLANT DRAWINGS FOR DETAILS
13	REVISED GRADING, REF. PLANT DRAWINGS FOR DETAILS

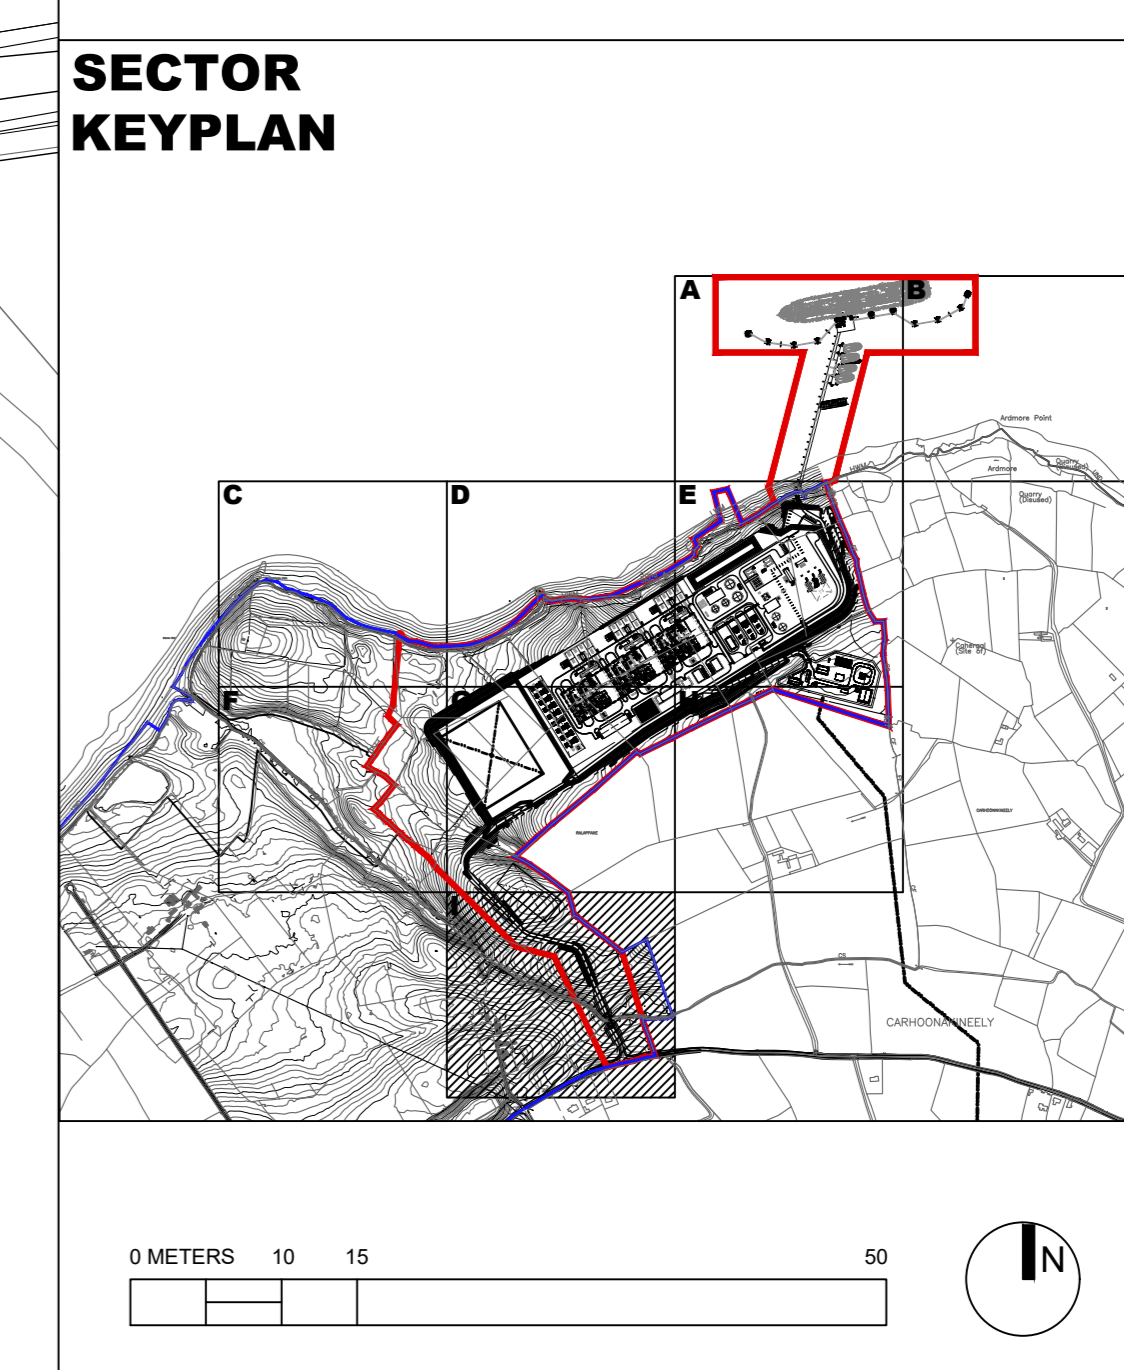

BLACK & VEATCH

moftatt & nichol

SHEEHAN NAGLE HARTRAY ARCHITECTS

02 Landscape Architecture
Masterplanning
Environmental Design

MINNEAPOLIS | CHICAGO

No.	Description	Date

SHEET REVISIONS

PROJECT ISSUANCES

PROJECT:
SHANNON TECHNOLOGY
AND ENERGY PARK (STEP)
SHANNON LNG LIMITED

DWG. TITLE
SITE LAYOUT
PLAN SECTOR I

PROJECT NO: **DWG. NO:**
DATE: 13/08/2021 **SP120.I**
SCALE: 1:500
SCALE: SHEET SIZE: A0