


- NOTES:
1. THE ENCLOSED DESIGN IS FOR PLANNING PURPOSES ONLY AND NOT FOR CONSTRUCTION. EQUIPMENT LOCATIONS ARE INDICATIVE ONLY AND ARE SUBJECT TO CHANGE WITHIN BUILDING.
  2. AIR COOLER CONDENSER, COLLECTION TANK, CONDENSATE POLISHER ENCLOSURE AND POWER DISTRIBUTION CENTER (PDC) TO BE COLOUR GREY-OLIVE, RAL 6006. AIR COOLER STEAM DUCK PIPING TO BE COLOUR TRAFFIC GREY, RAL 7043.


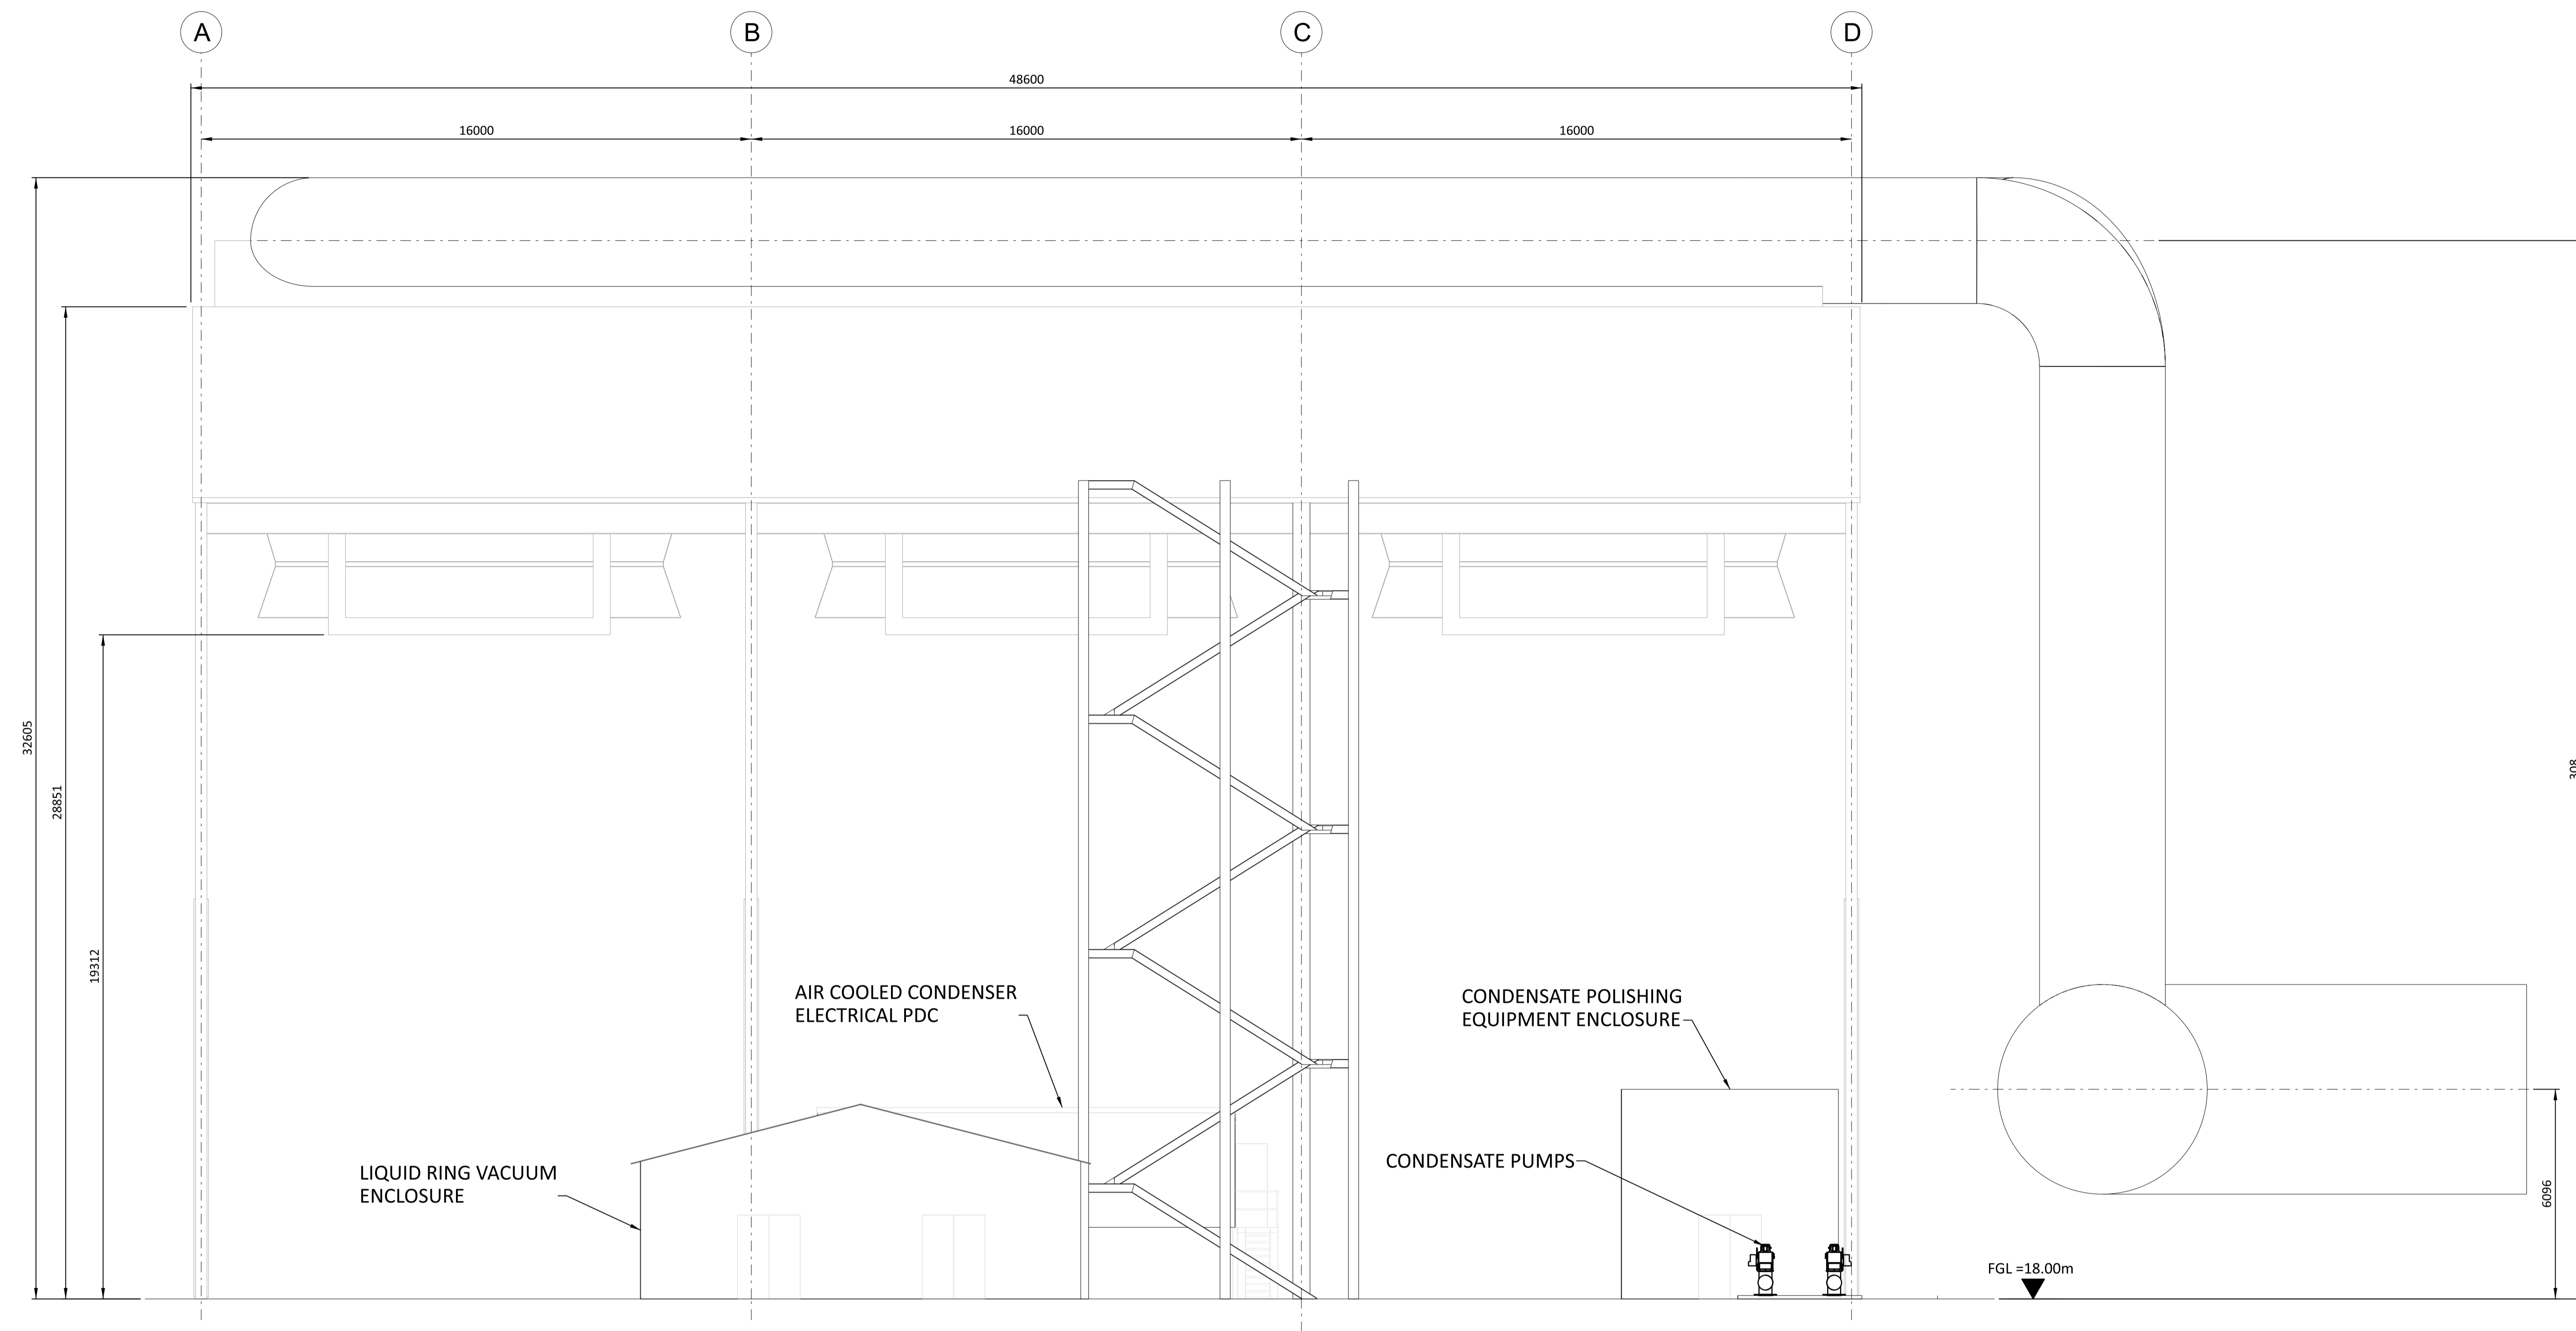


WEST ELEVATION  
SEE DRAWING 198291-SS-A4075A

19/07/2021 10:15:07.4  
 20/08/2021 10:18:44

NO	DATE	REVISIONS AND RECORD OF ISSUE	DRN	DES	CHK	PDE	APP
1	18/JUN/2021	ISSUED FOR PLANNING	TMC	DIL		DAC	
0	30/APR/2021	ISSUED FOR PLANNING	TMC	DIL		DAC	

NO	DATE	REVISIONS AND RECORD OF ISSUE	DRN	DES	CHK	PDE	APP
1	18/JUN/2021	ISSUED FOR PLANNING	TMC	DIL		DAC	
0	30/APR/2021	ISSUED FOR PLANNING	TMC	DIL		DAC	

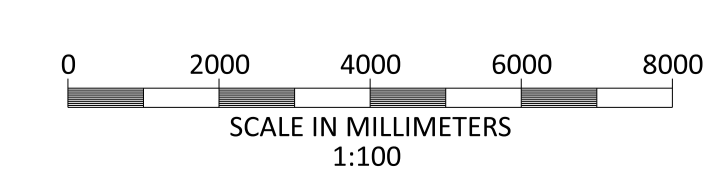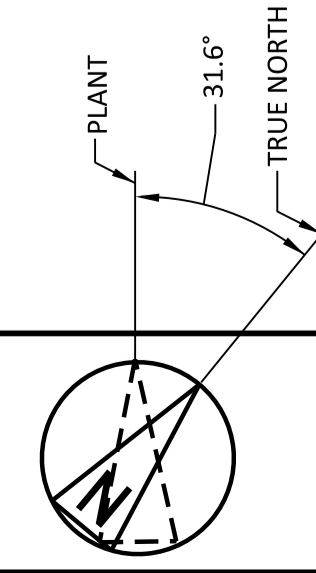

BLACK & VEATCH CORP HEADQUARTERS:  
11401 LAMAR AVENUE, OVERLAND PARK,  
KANSAS, USA

**BLACK & VEATCH**

CHECKED: \_\_\_\_\_ DATE: \_\_\_\_\_  
DRAWN: \_\_\_\_\_

SHANNON LNG LIMITED  
SHANNON TECHNOLOGY AND ENERGY PARK (STEP)  
AIR COOLED CONDENSER  
WEST ELEVATION

PROJECT	DRAWING NUMBER	REV
198291-SS-A4075E		1
CODE	AREA	

**NOT TO BE USED FOR CONSTRUCTION**

THE DISTRIBUTION AND USE OF THE NATIVE FORMAT CAD FILE OF THIS DRAWING IS UNCONTROLLED. THE USER SHALL VERIFY TRACEABILITY OF THIS DRAWING TO THE LATEST CONTROLLED VERSION.