
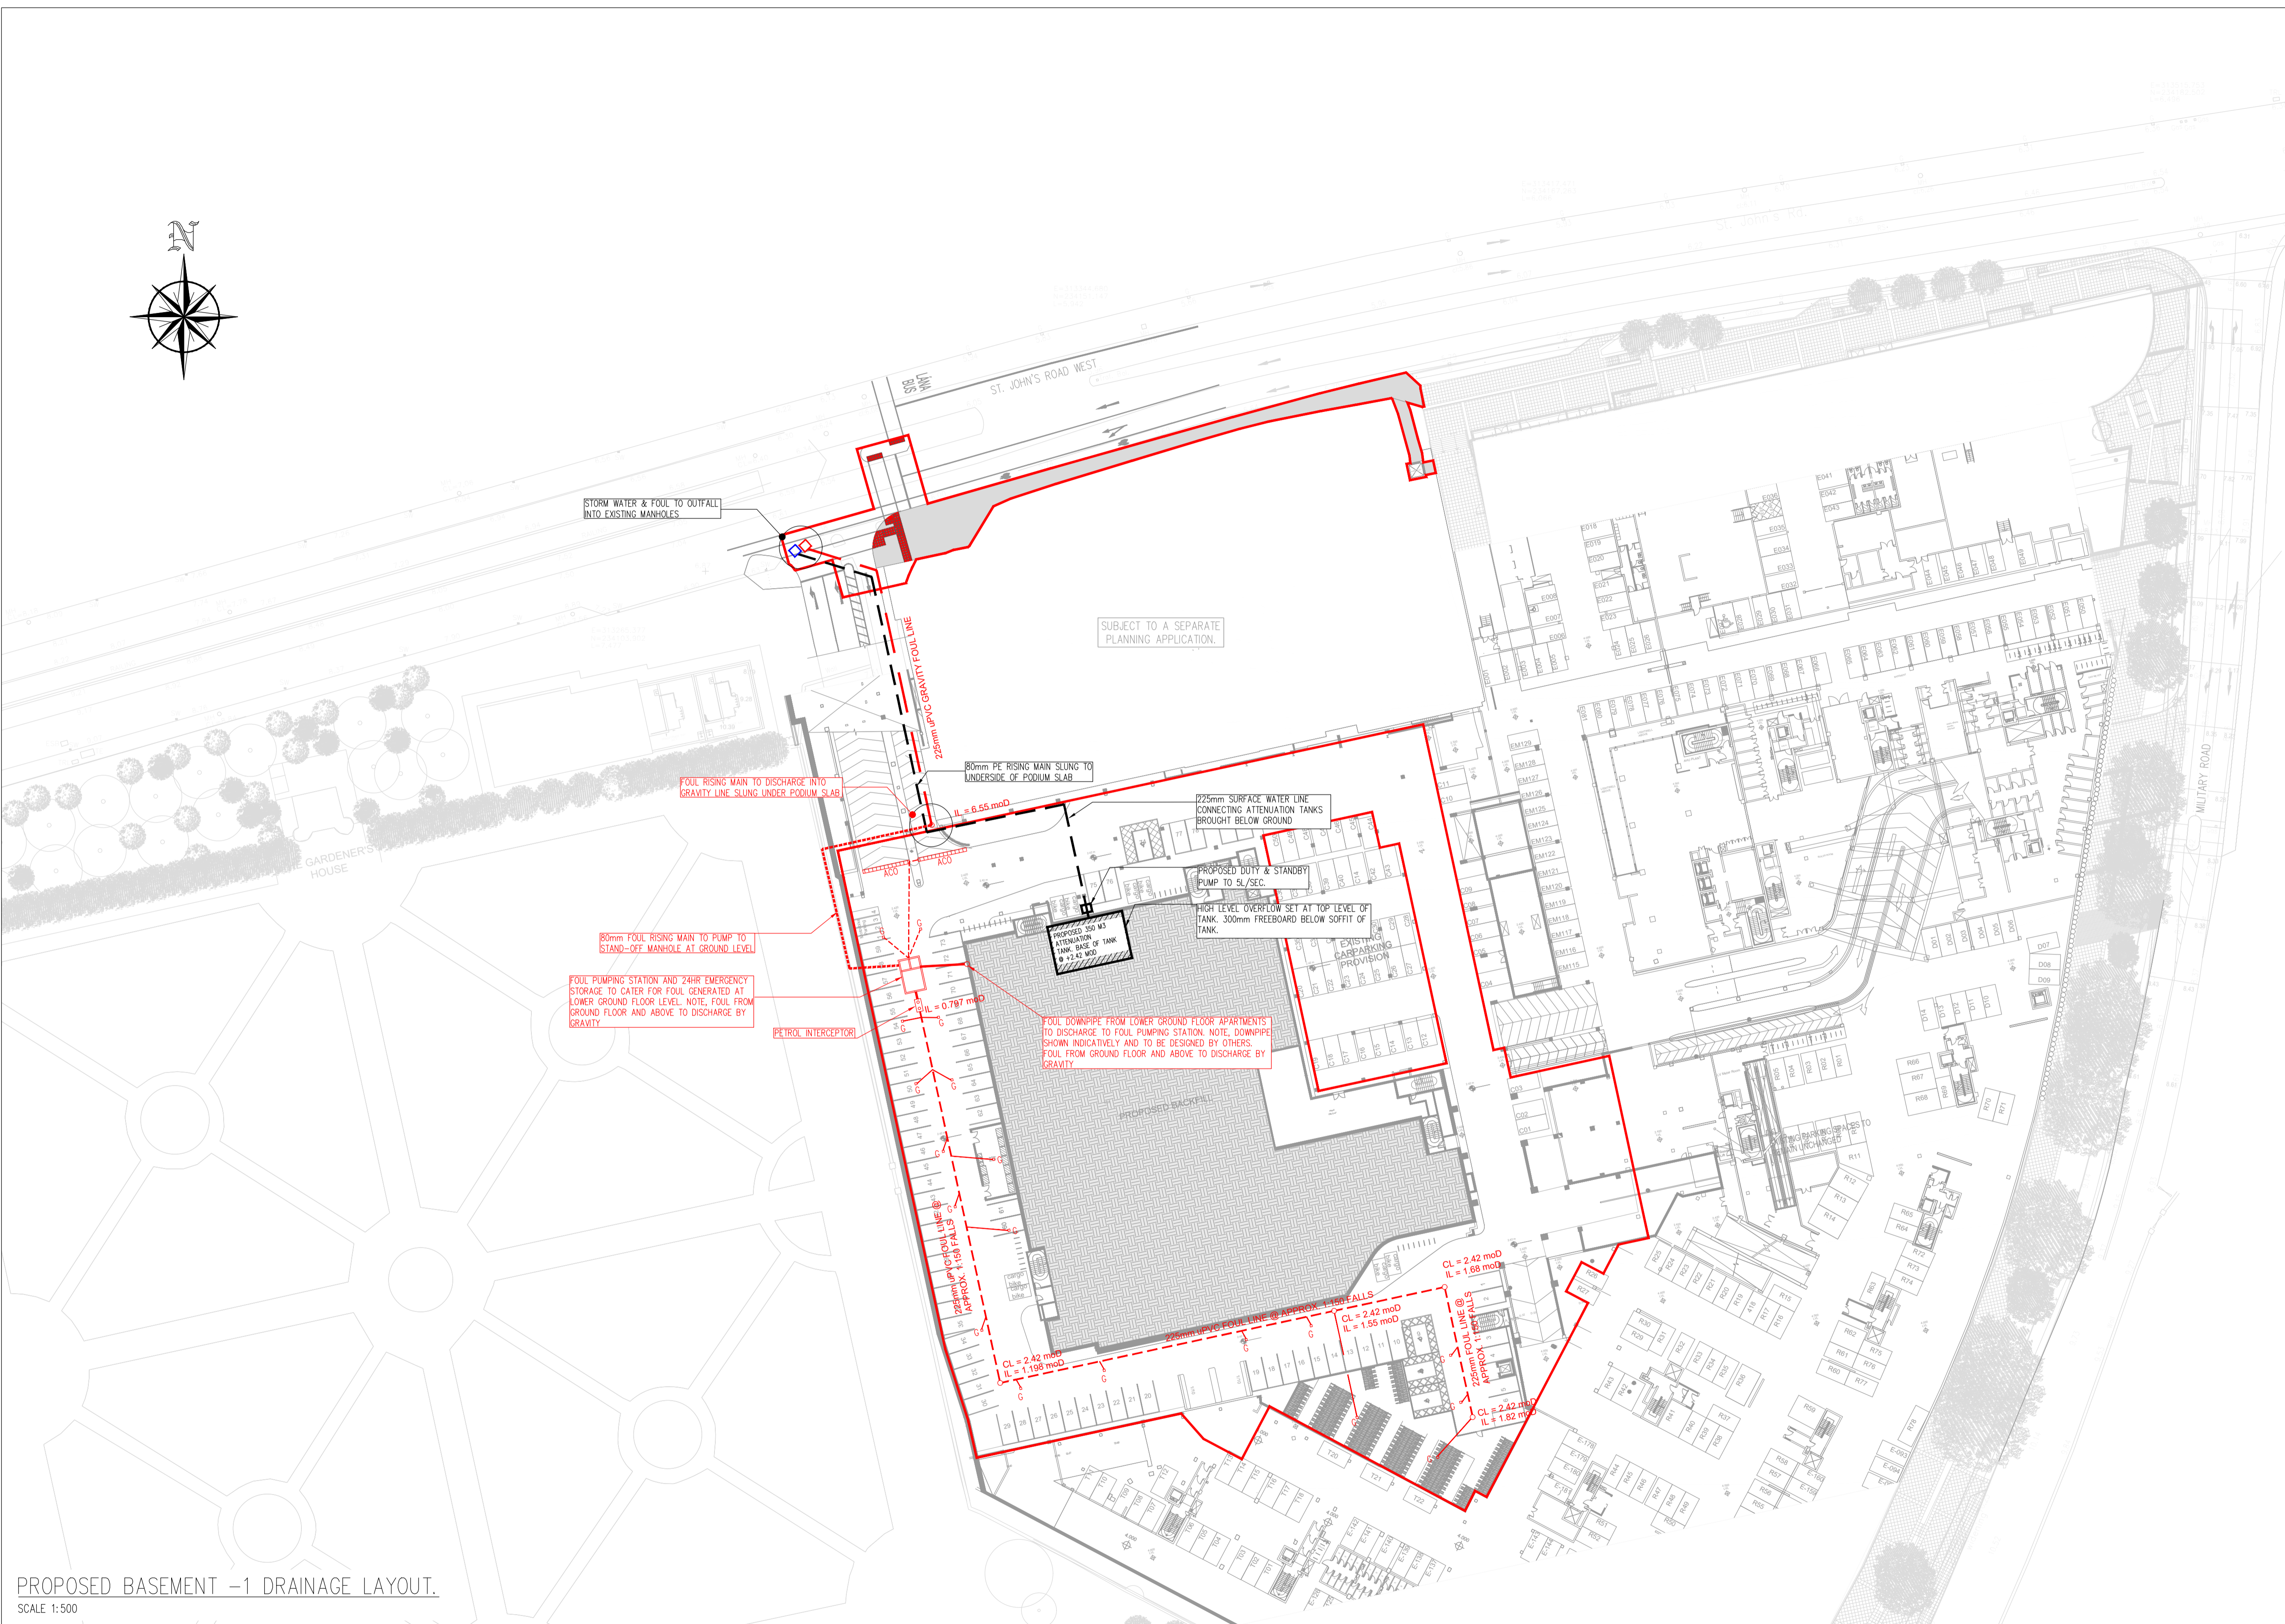


LEGEND:

- PROPOSED FOUL SEWER LINE ---
- PROPOSED SURFACE WATER LINE ---
- PROPOSED ATTENUATION TANK
- TRAPPED FOUL GULLY ••
- TRAPPED ACO CHANNEL ---
- SITE BOUNDARY ---

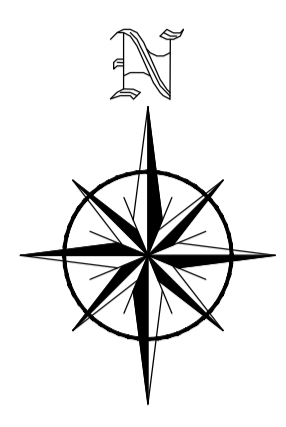

PROPOSED BASEMENT -1 DRAINAGE LAYOUT.
SCALE 1:500

PLANNING DRAWING.
NOT FOR CONSTRUCTION.
ALL LEVELS GIVEN ARE
RELATIVE TO ORDNANCE DATUM.
THIS DRAWING HAS BEEN ISSUED FOR INFORMATION
PURPOSES ONLY AND MUST NOT BE USED
FOR CONSTRUCTION UNDER ANY CIRCUMSTANCES

- NOTES**
- For setting out refer to Architect's drawings.
 - This drawing to be read in conjunction with all other Architectural and Engineering drawings and all other relevant drawings and Specifications.
 - DO NOT SCALE THIS DRAWING. Use figured dimensions only.
 - No part of this document may be reproduced or transmitted in any form or stored in any retrieval system of any nature without the written permission as copyright holder except as agreed.
 - Ordnance Survey Ireland Licence Number EN 0074021

Rev. No	Date	REVISION NOTE	Dim. By	Chk. By
P1	17.09.2021	ISSUED FOR PLANNING STAGE 3	JS	GF

Architect	Reddy Architecture
Project	HEUSTON SOUTH QUARTER, ST. JOHN'S ROAD WEST, KILMAINHAM
Title	PROPOSED BASEMENT -1 DRAINAGE LAYOUT.
Dwg. No.	HSQ-CSC-XX-XX-DR-C-0101
Date	JULY 2021
Dim. by	JS
Chk. by	NB
Apprv. by	DR
Scale	1:500 @ A1
Revision	P1

CS Consulting Group
DUBLIN | LONDON | LIMERICK

Head Office
19-22 Dame Street, Dublin 2.
T: +353 (0)1 5480863 F: +353 (0)1 9011355
e: info@csconsulting.ie
w: www.csconsulting.ie

Quality Environment I.S. EN ISO 9001:2008
NSAI Certified I.S. EN ISO 14001:2004
Health & Safety OHSAS 18001:2007