




LEGEND:

- EXISTING FOUL SEWER LINE —
- EXISTING SURFACE WATER LINE —
- PROPOSED FOUL SEWER LINE - - -
- PROPOSED SURFACE WATER LINE - - -
- PROPOSED ATTENUATION TANK
- TRAPPED FOUL GULLY ••
- TRAPPED ACO CHANNEL -----
- SITE BOUNDARY —

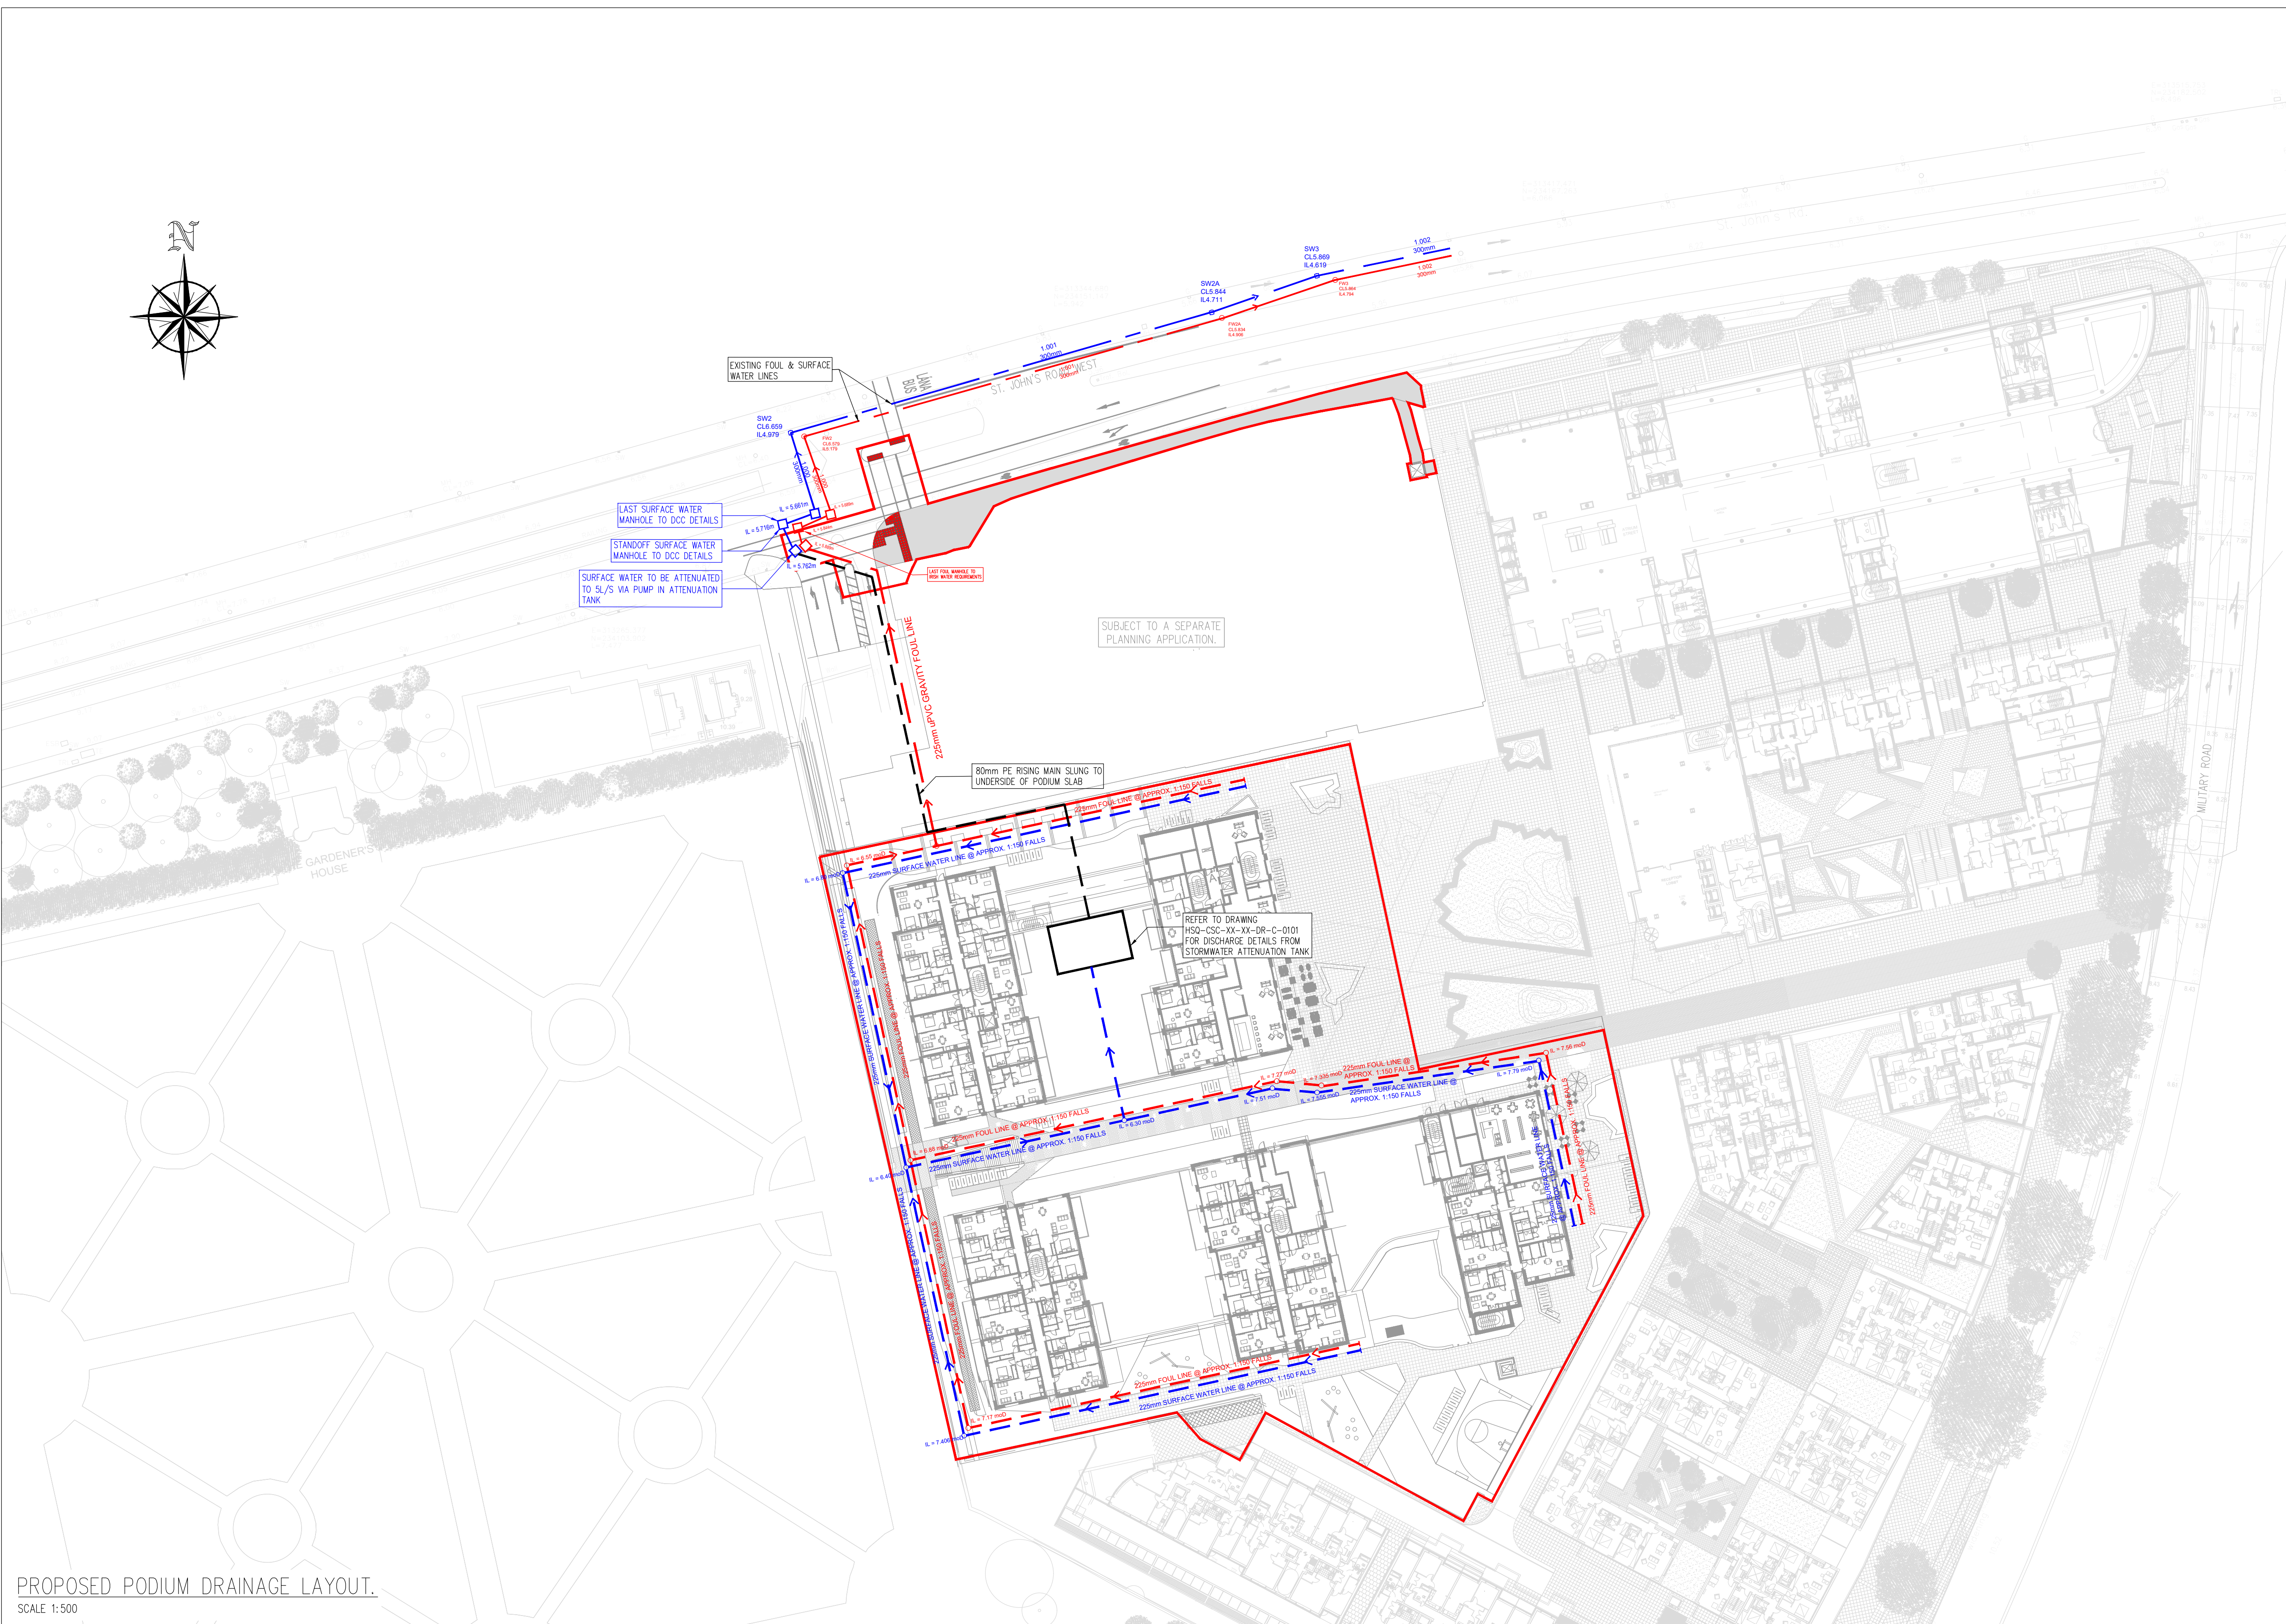

PROPOSED PODIUM DRAINAGE LAYOUT.
SCALE 1:500

PLANNING DRAWING.
NOT FOR CONSTRUCTION.
ALL LEVELS GIVEN ARE
RELATIVE TO ORDNANCE DATUM.
THIS DRAWING HAS BEEN ISSUED FOR INFORMATION
PURPOSES ONLY AND MUST NOT BE USED
FOR CONSTRUCTION UNDER ANY CIRCUMSTANCES

- NOTES**
1. For setting out refer to Architect's drawings.
 2. This drawing to be read in conjunction with all other Architectural and Engineering drawings and all other relevant drawings and Specifications.
 3. DO NOT SCALE THIS DRAWING. Use figured dimensions only.
 4. No part of this document may be reproduced or transmitted in any form or stored in any retrieval system of any nature without the written permission as copyright holder except as agreed for use on the project for which the document was originally issued.
 5. Ordnance Survey Ireland Licence Number EN 0074021

Rev. No.	Date	REVISION NOTE	Dim. By	Chkd. By
P1	17.09.2021	ISSUED FOR PLANNING STAGE 3	JS	GF

Reddy Architecture				
Project HEUSTON SOUTH QUARTER, ST. JOHN'S ROAD WEST, KILMAINHAM				
Title PROPOSED PODIUM DRAINAGE LAYOUT.				
Dwg. No. HSQ-CSC-XX-XX-DR-C-0102				
Date	Dim. by	Chkd. by	Aprvd. by	Scale
JULY 2021	JS	NB	DR	1:500 @ A1
				Revision P1

CS Consulting Group
DUBLIN | LONDON | LIMERICK

Head Office
19-22 Dame Street, Dublin 2.
T: +353 (0)1 5480863 F: +353 (0)1 9011355
e: info@csconsulting.ie
w: www.csconsulting.ie

NSAI Certified

Quality Environment Health & Safety

I.S. EN ISO 9001:2008
I.S. EN ISO 14001:2004
I.S. EN ISO 50001:2011
OHSAS 18001:2007