

See drawing 6158B-P-014 for remaining site area



See drawing 6158B-P-014 for remaining site area

PHASE 1A
ST. MARNOCK BAY
(EXISTING 101 UNITS
CONSTRUCTED)
PL.REF. F13A/0248


PHASE 1C
ST. MARNOCK'S BAY (153
UNITS NOW UNDER
CONSTRUCTION)
ABP REF. ABP-305619-19

RAILWAY
LINEAR PARK


PROPOSED HAUL ROAD
(PERMITTED UNDER REG. REF. F20A/0700)

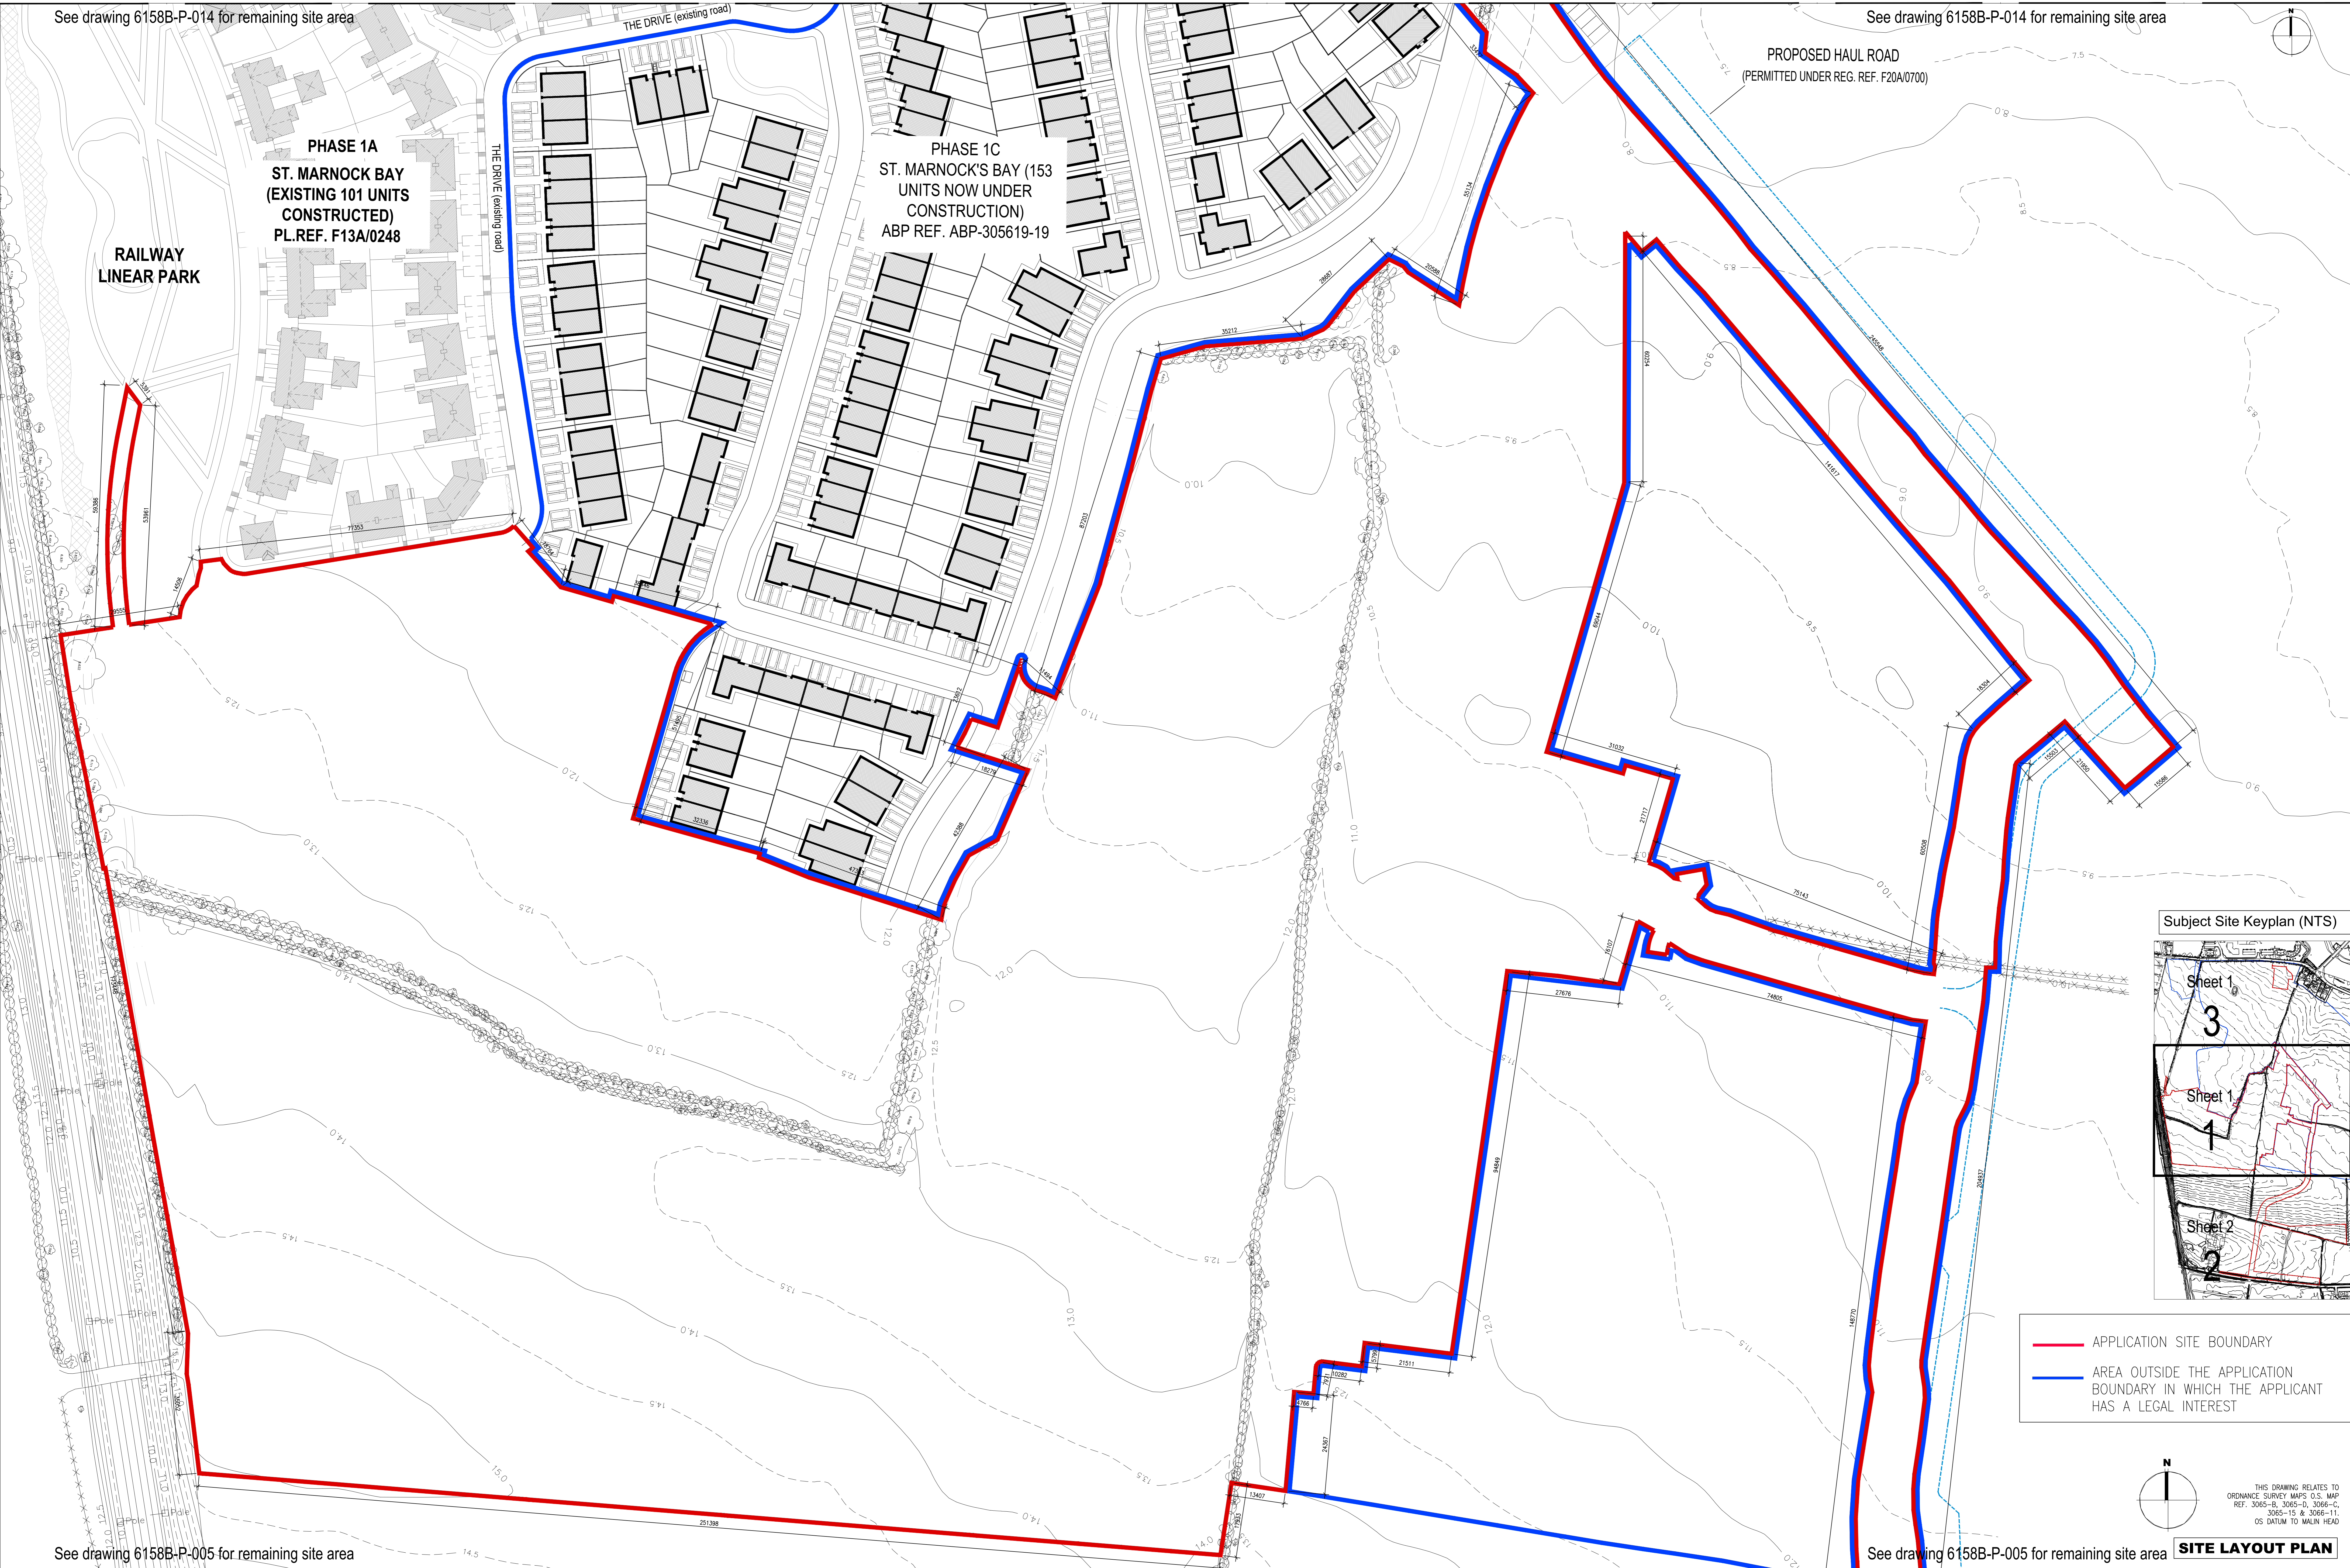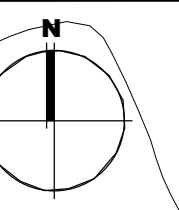

Subject Site Keyplan (NTS)

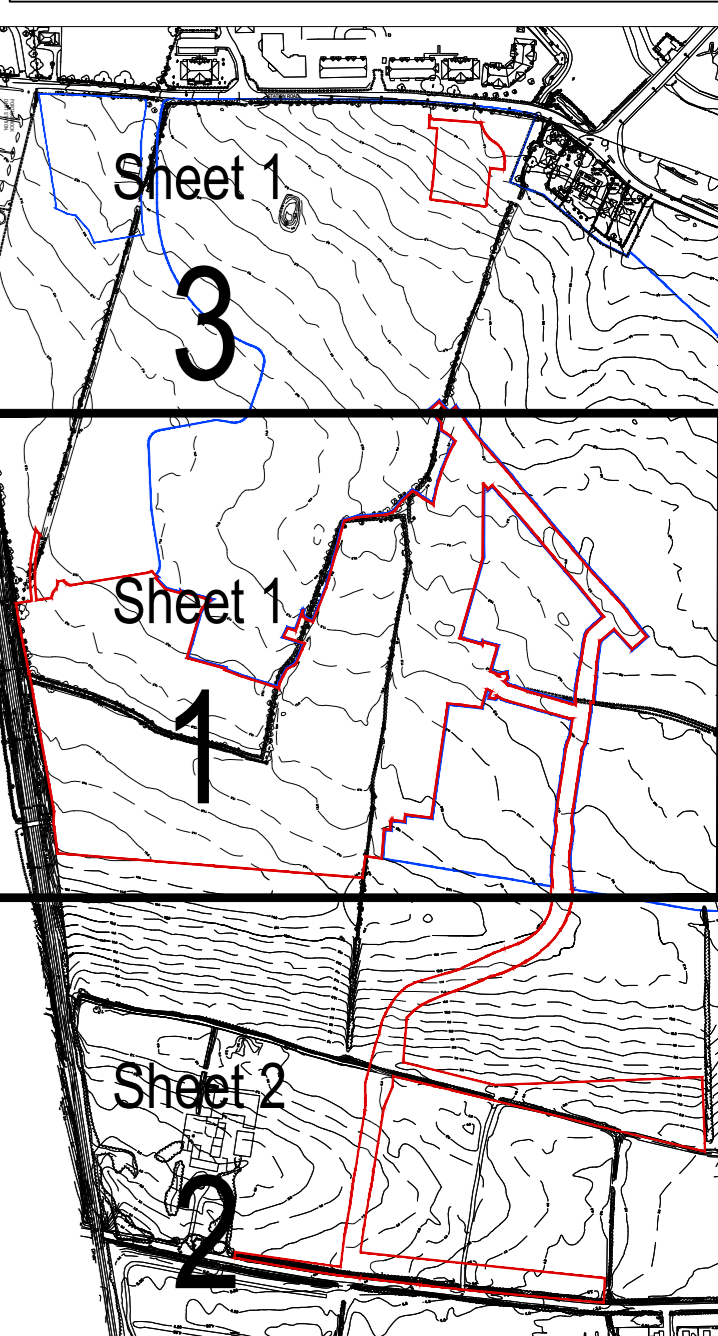

— APPLICATION SITE BOUNDARY
— AREA OUTSIDE THE APPLICATION BOUNDARY IN WHICH THE APPLICANT HAS A LEGAL INTEREST

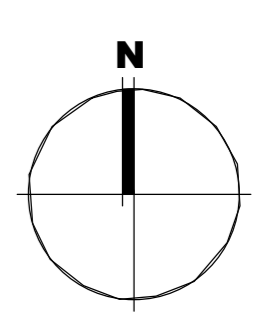

THIS DRAWING RELATES TO
ORDNANCE SURVEY MAPS O.S. MAP
REF. 3065-B, 3065-D, 3066-C,
3065-15 & 3066-11.
OS DATUM TO MALIN HEAD

SITE LAYOUT PLAN

See drawing 6158B-P-005 for remaining site area

See drawing 6158B-P-005 for remaining site area

Notes:
1. Copyright Reserved
2. Work to be done dimensions only. Do not scale drawing.
3. The contractor is responsible for checking all levels and dimensions on site and shall make all adjustments to the finished.
4. Where appropriate, for details of civil, structural, or mechanical and electrical details, see Engineers drawing.
5. Proprietary items shall be fixed in strict accordance with manufacturers instructions.
6. Scope of proprietary items shall be checked with manufacturer.
7. The contractor shall be responsible for the coordination of structure, finishes and services.

Issue Number:
Progress Application
Final Cert
Disability Cert
1. Issues
2. Construction
3. As Built
Information Only

Proj. Name: Portlaoine
Scale: 1:500
Revision: 01
Date: 26.11.21
Revision: 02
Date: 10.09.2019
Revision: 03
Date: 10.09.2019

Project: Portlaoine South Phase 1D
Quintain Developments Ireland Limited
Drawing Title: EXISTING SITE LAYOUT PLAN SHEET 1 OF 3
Drawing No: 6158B-P-004
Scale: 1:500@A0
Rev: 01
Drawn: DL
Date: 10.09.2019
bkd architects
BURREN-SHERIDAN DOYLE

© 2019 Burren Sheridan Doyle Architects. All rights reserved. This drawing is the property of Burren Sheridan Doyle Architects and is not to be used without their written consent.