




SECTION A

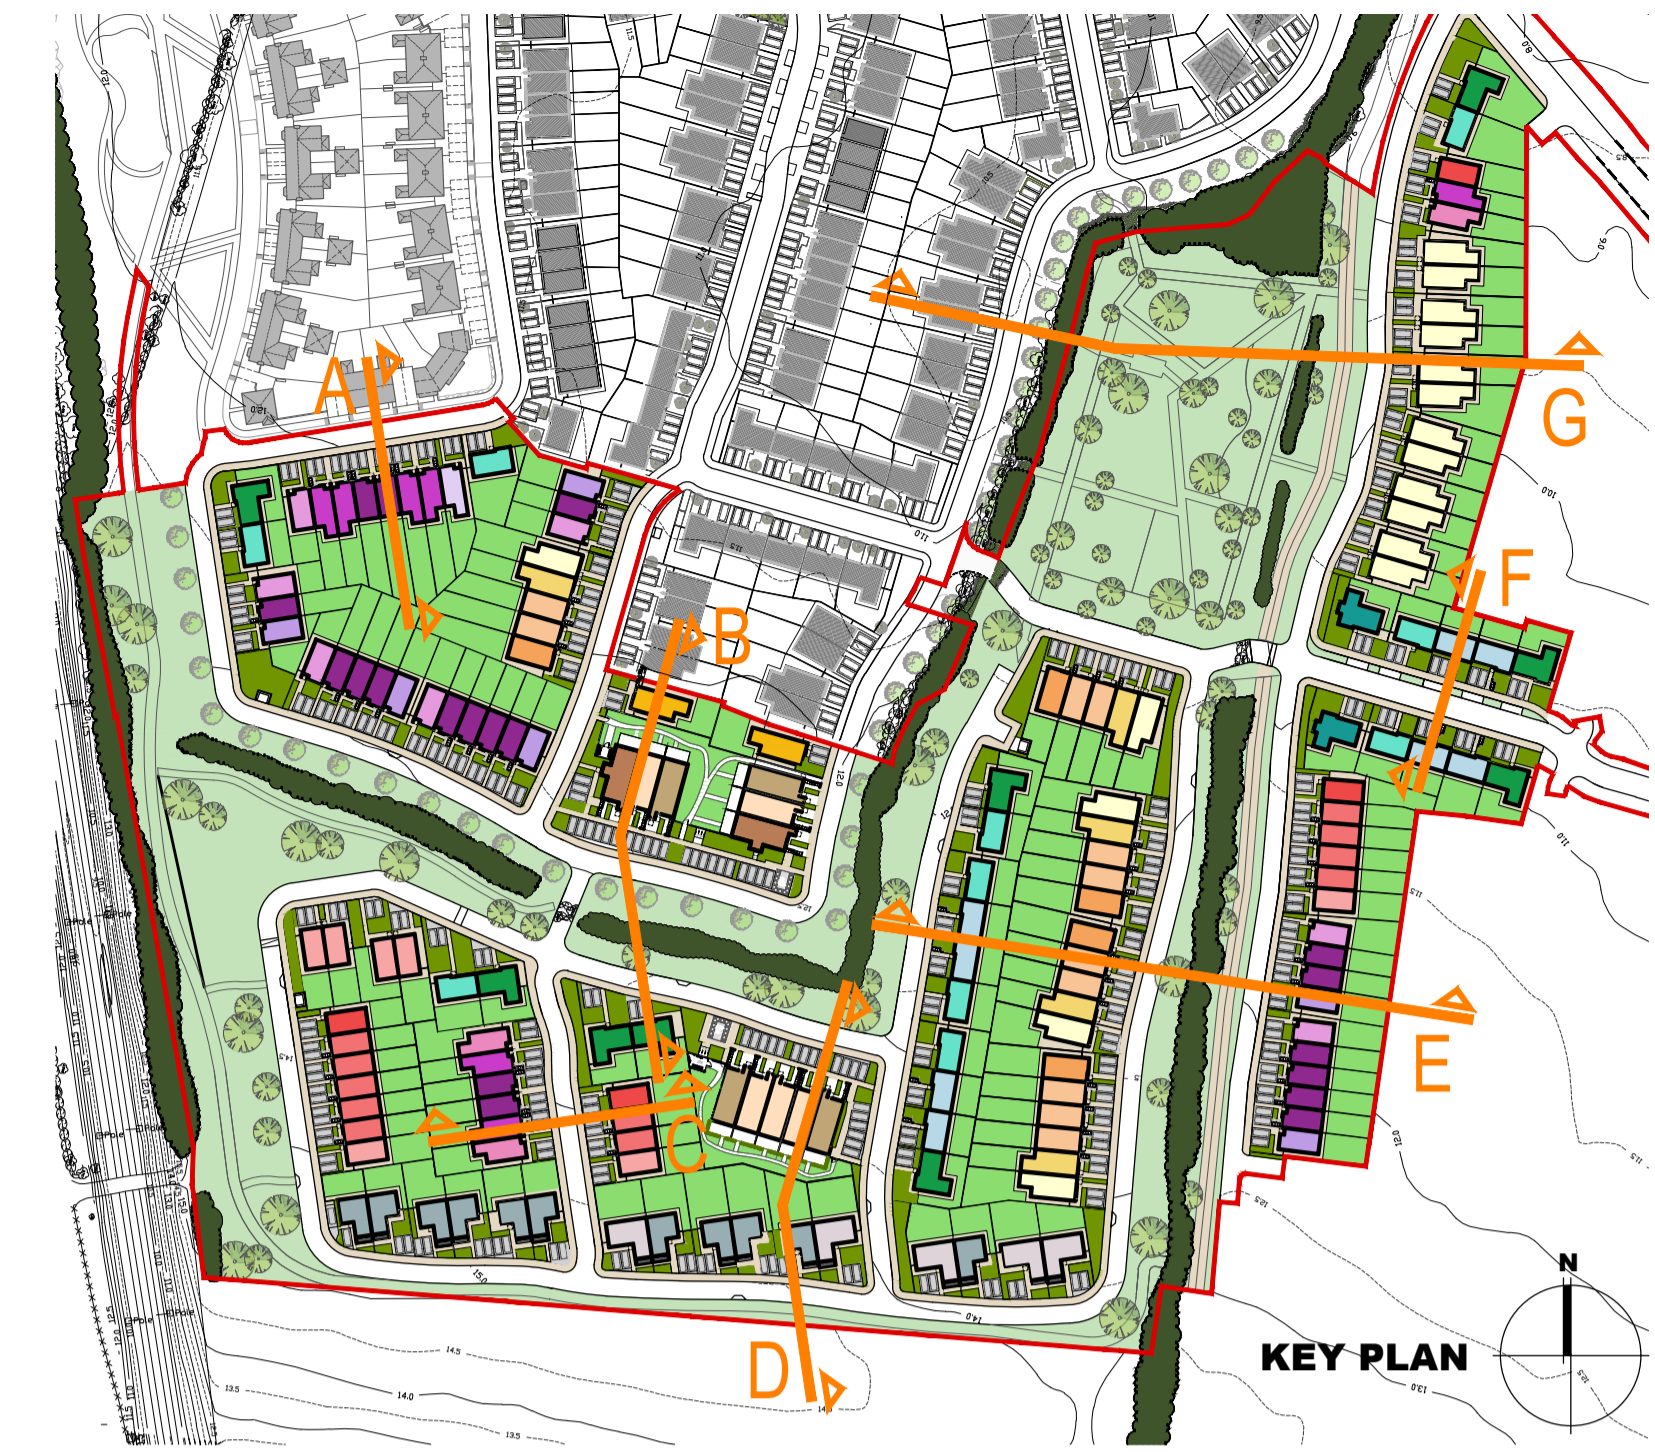


KEY PLAN

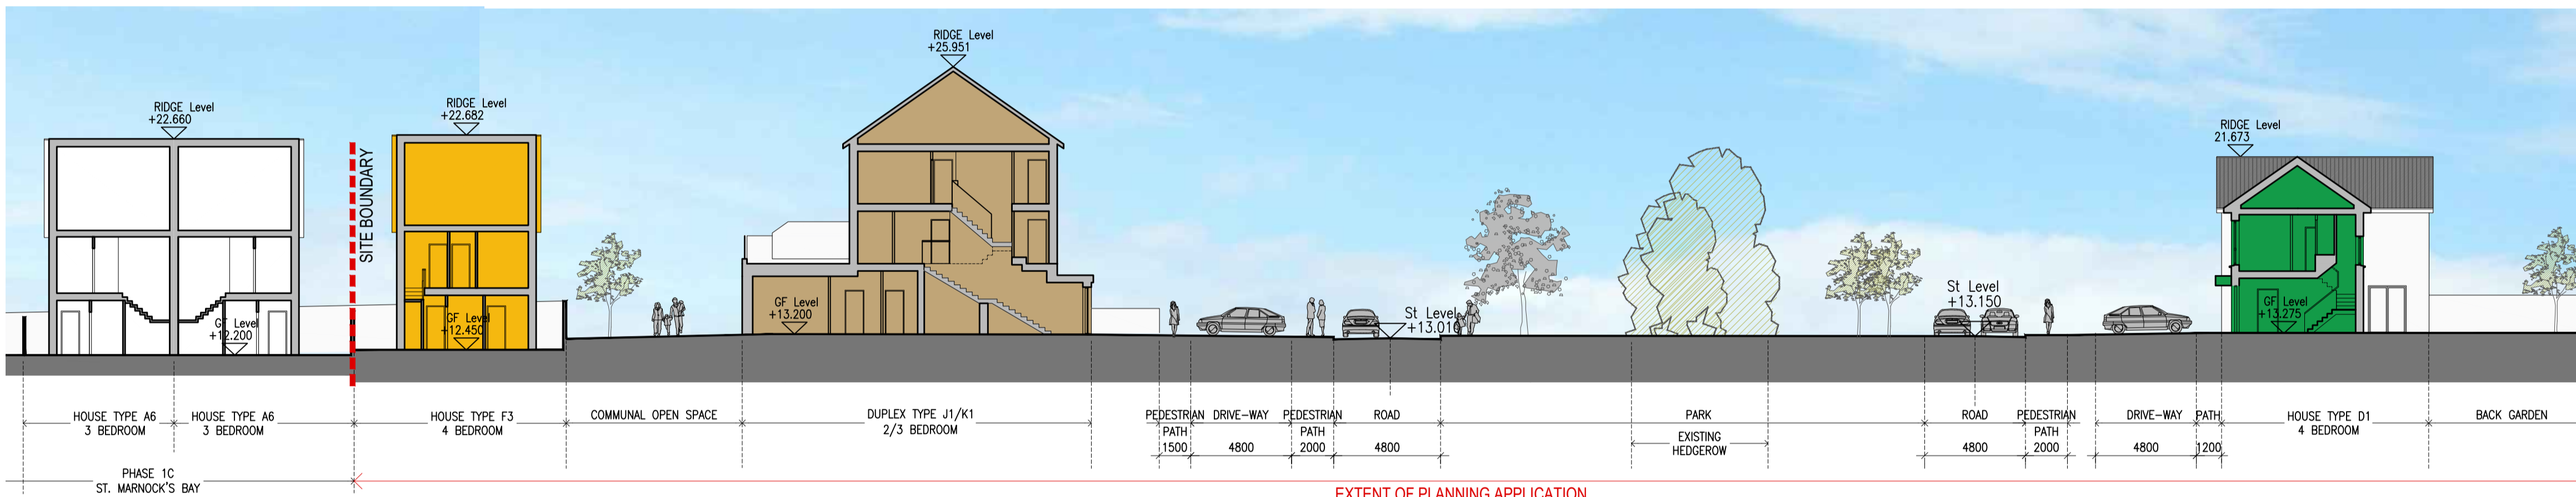

SECTION B

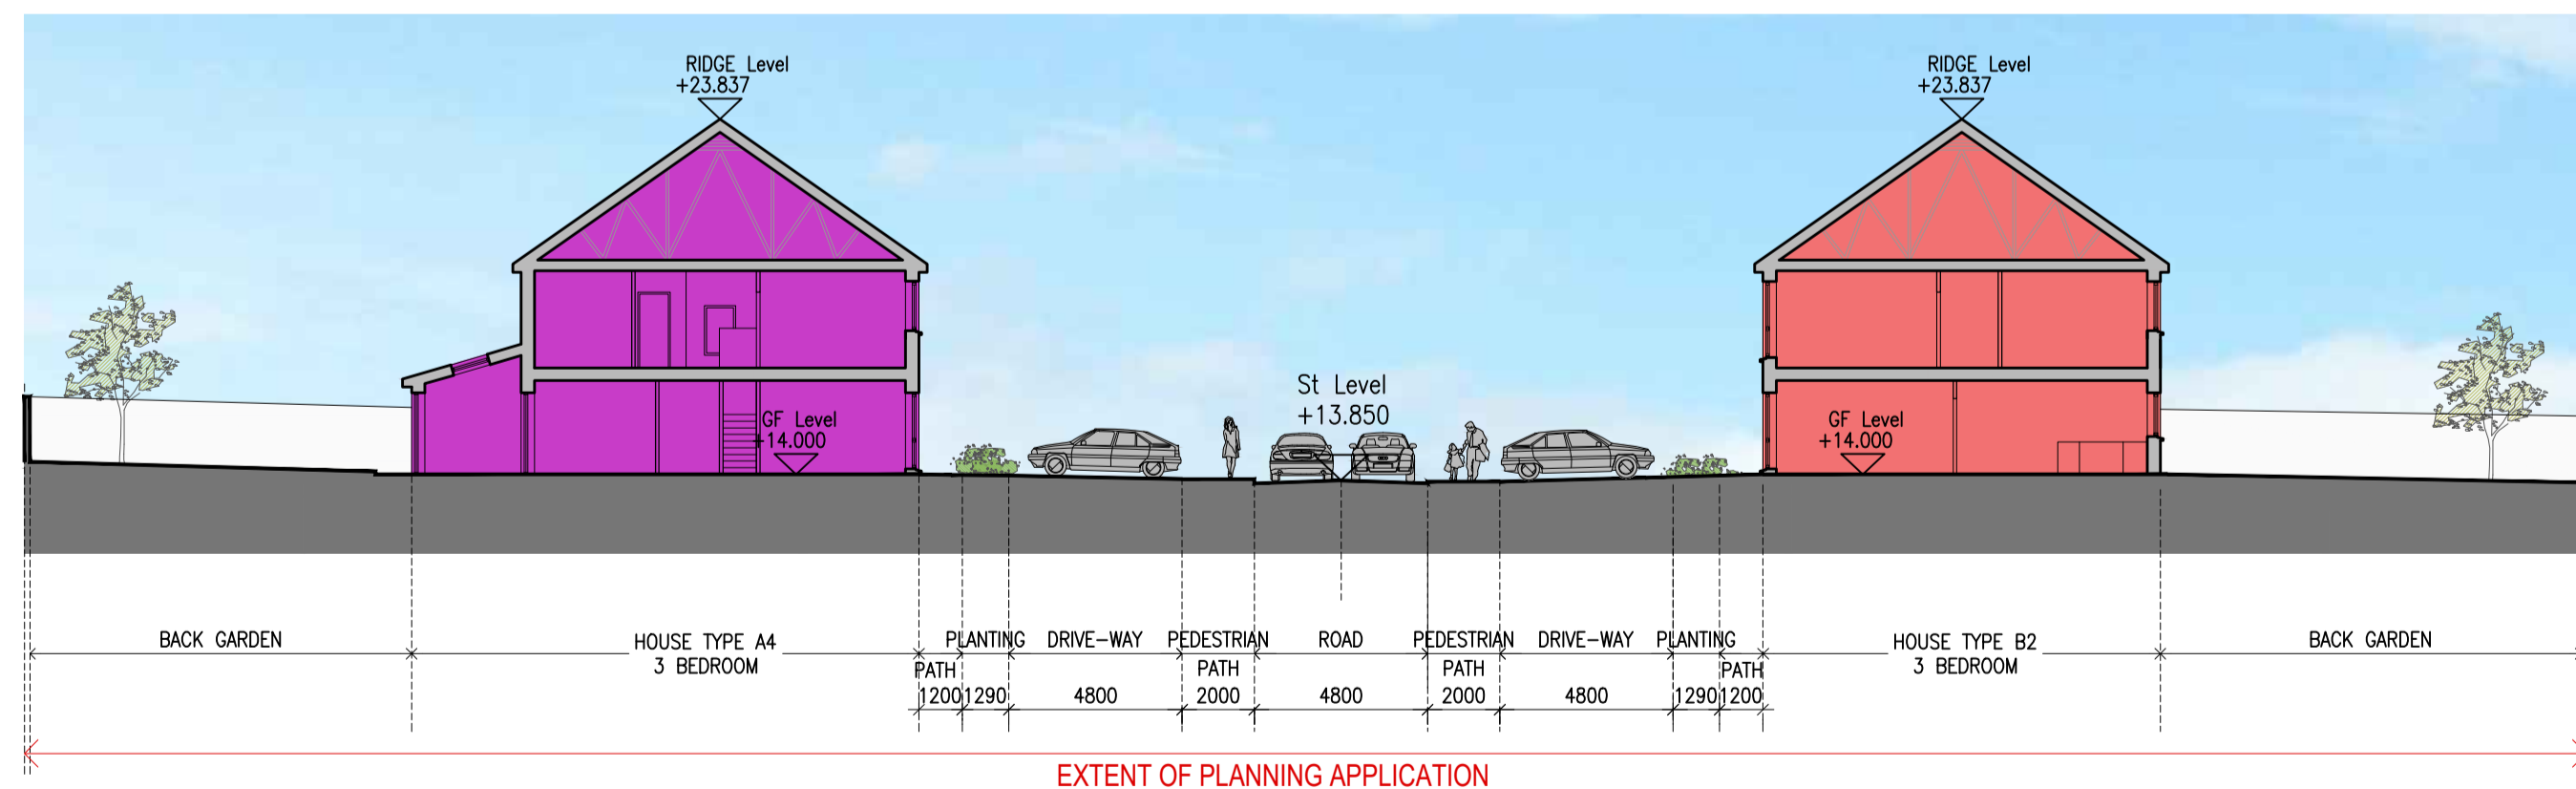

SECTION C

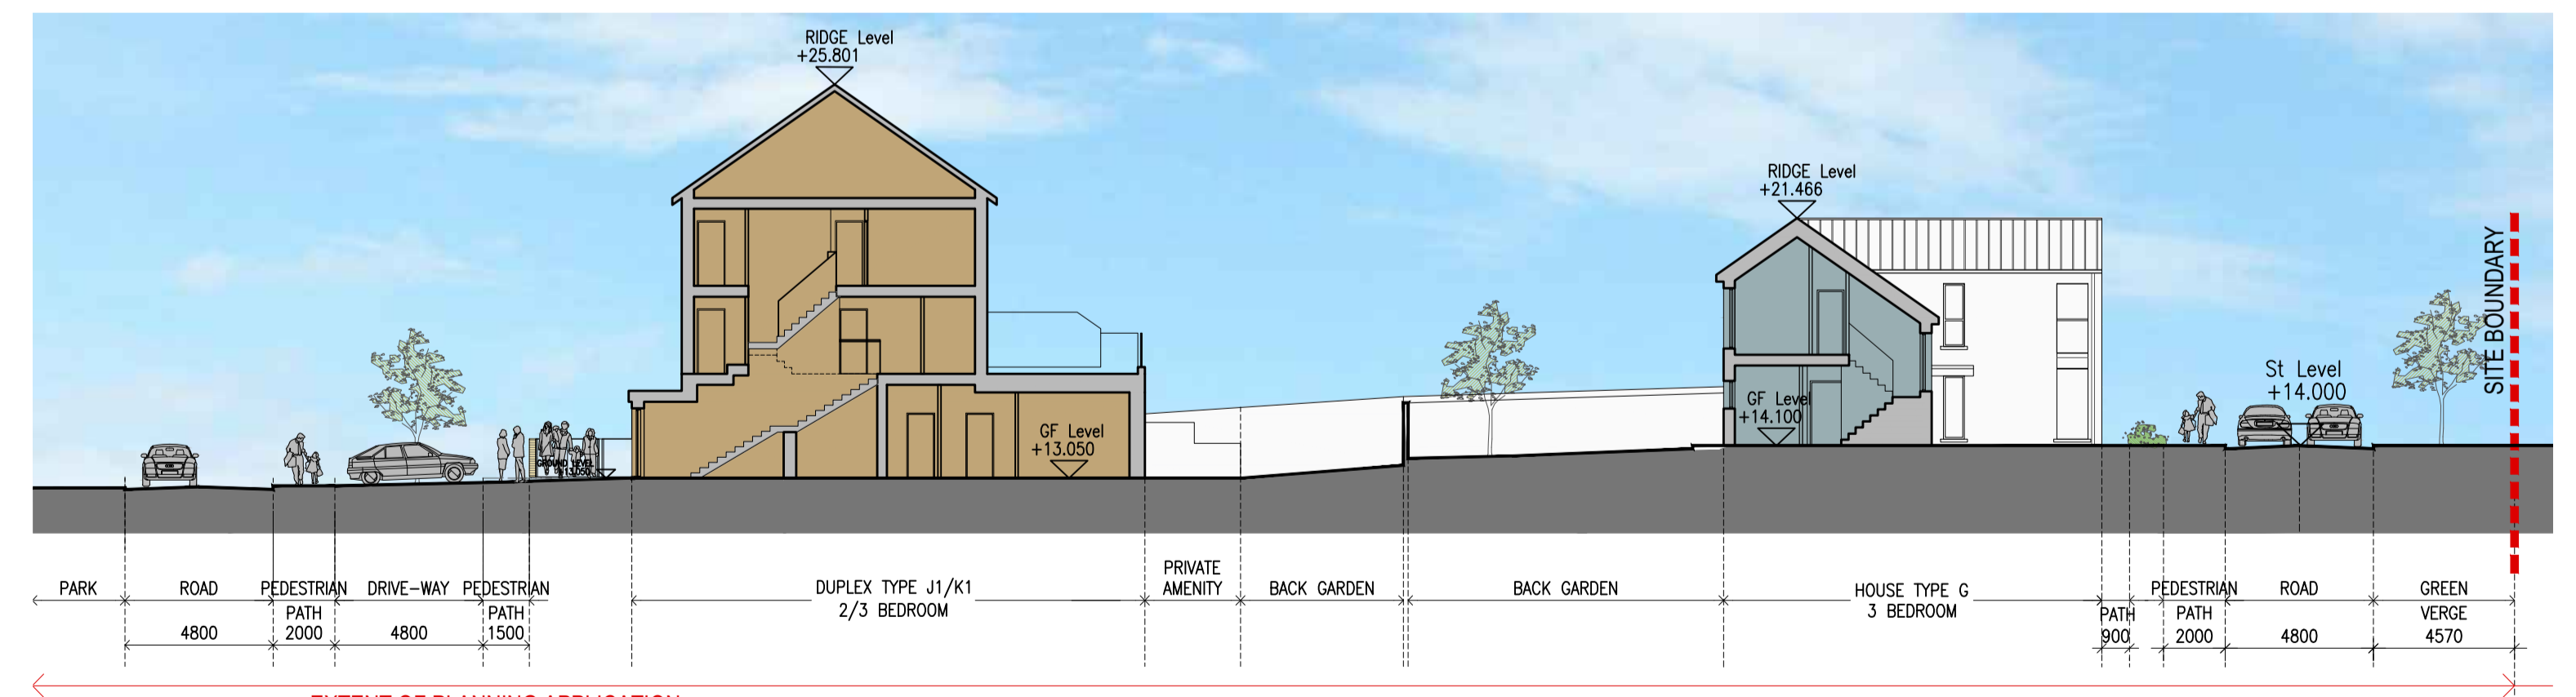

SECTION D

- Notes
1. Copyright Reserved
 2. Work to figured dimensions only. Do not scale drawing
 3. The contractor is responsible for checking all levels and dimensions on site and shall refer all discrepancies to the Architect
 4. Where appropriate, for details of r.c. structure, or mechanical and electrical details, see Engineers drawings
 5. Proprietary items shall be fixed in strict accordance with manufacturers instructions.
 6. Sizes of proprietary items shall be checked with manufacturer.
 7. The contractor shall be responsible for the coordination of structure, finishes and services.

Issue Status	Progress
Planning Application	■
Fire Cert	
Disability Cert	
Tender	
Construction	
As Built	
Information Only	

No.	Date	Revision	Initials
01	26.11.2021	SHD PLANNING APPLICATION TO ABP	SH

Project	Portmarnock South Phase 1D for Quintain Developments Ireland Limited
Drawing Title	SITE SECTIONS SHEET 1 OF 2
Drawing No	6158B-P-009
Scale	1:200-@A1
Rev	01
Drawn	JN
Date	02/02/2021

6-7 HARDCOURT TERRACE, DUBLIN 2, IRELAND
 T +353-1-6782400 F +353-1-6787395
 www.bkd.ie

bkdarchitects
 BURKE-KENNEDY DOYLE