




01 Proposed Covered Bicycle Parking Type 3- Front Elevation
P201 1:50@A1

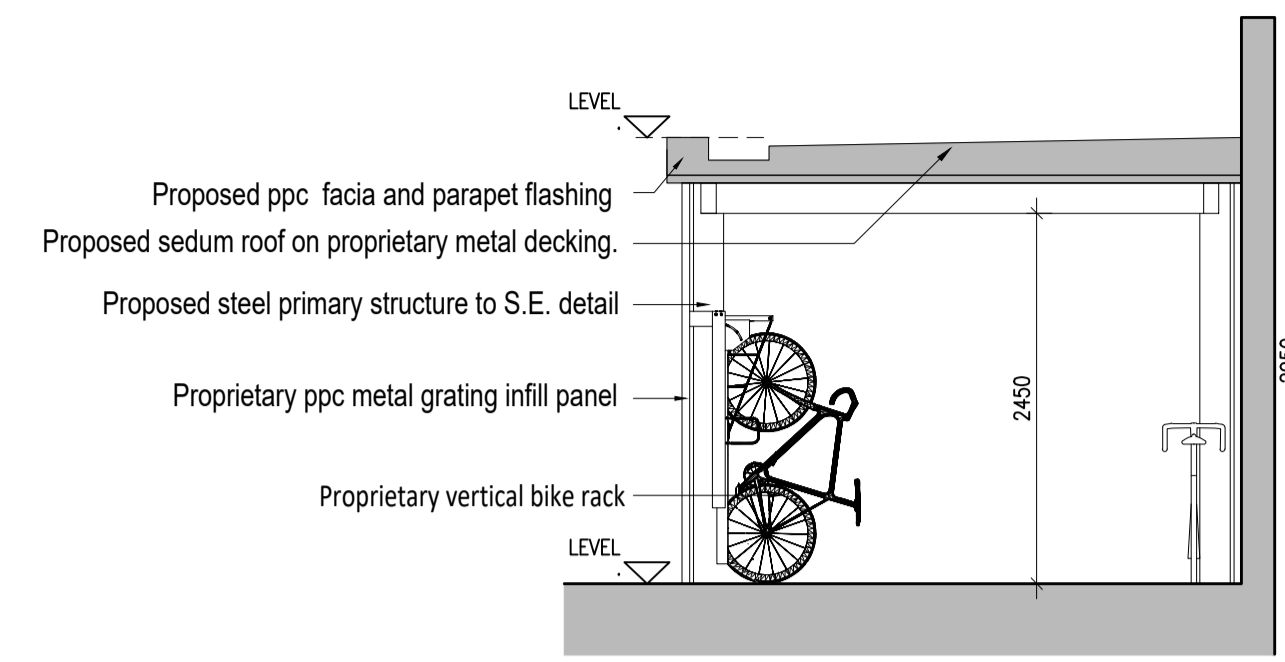


02 Proposed Covered Bicycle Parking Type 3- Section A-A
P201 1:50@A1

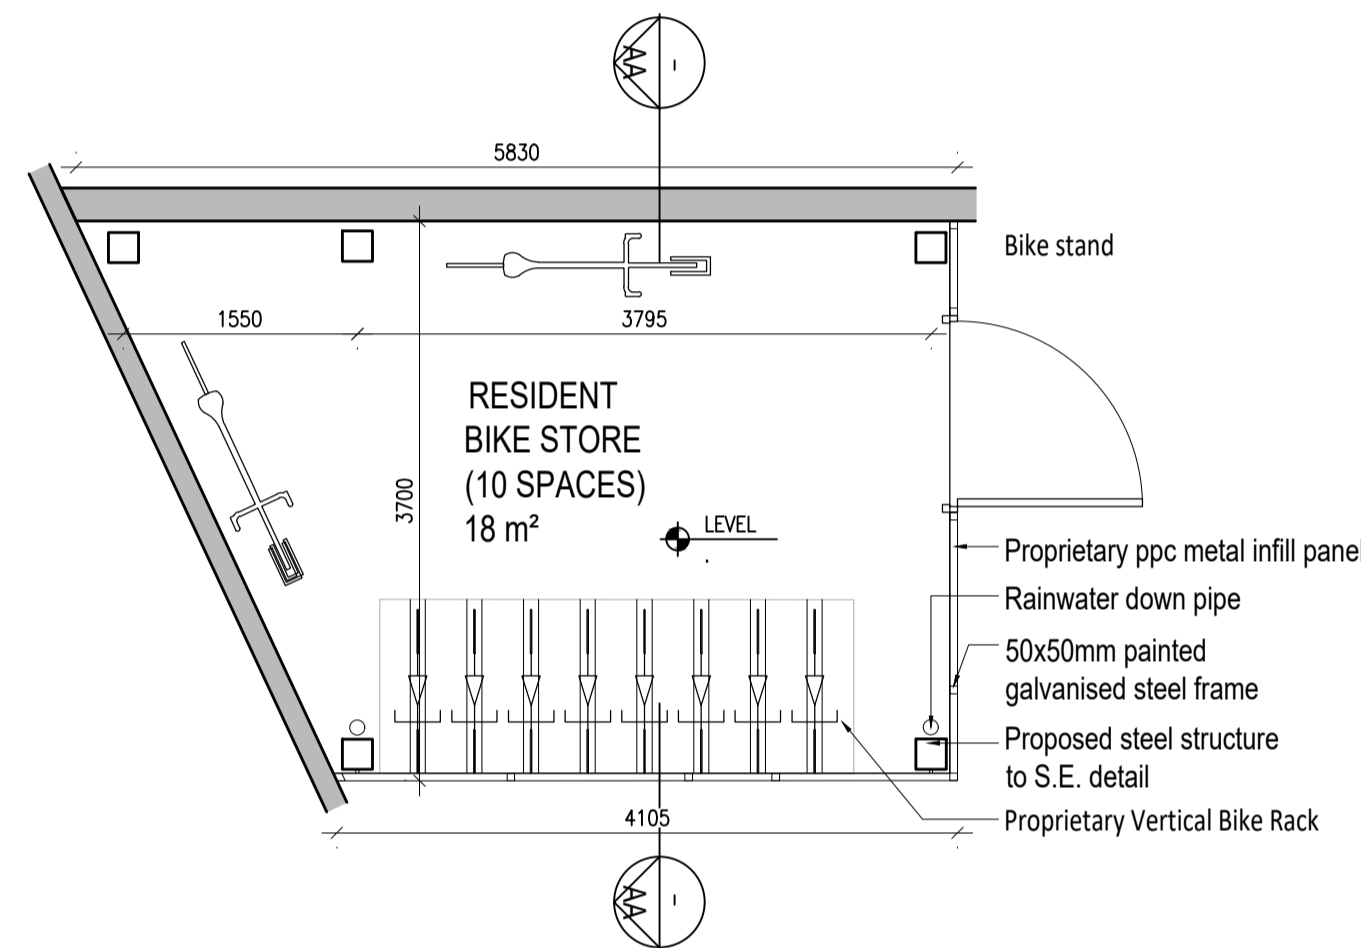

03 Proposed Covered Bicycle Parking Type 3 - Ground Plan
P201 1:50@A1

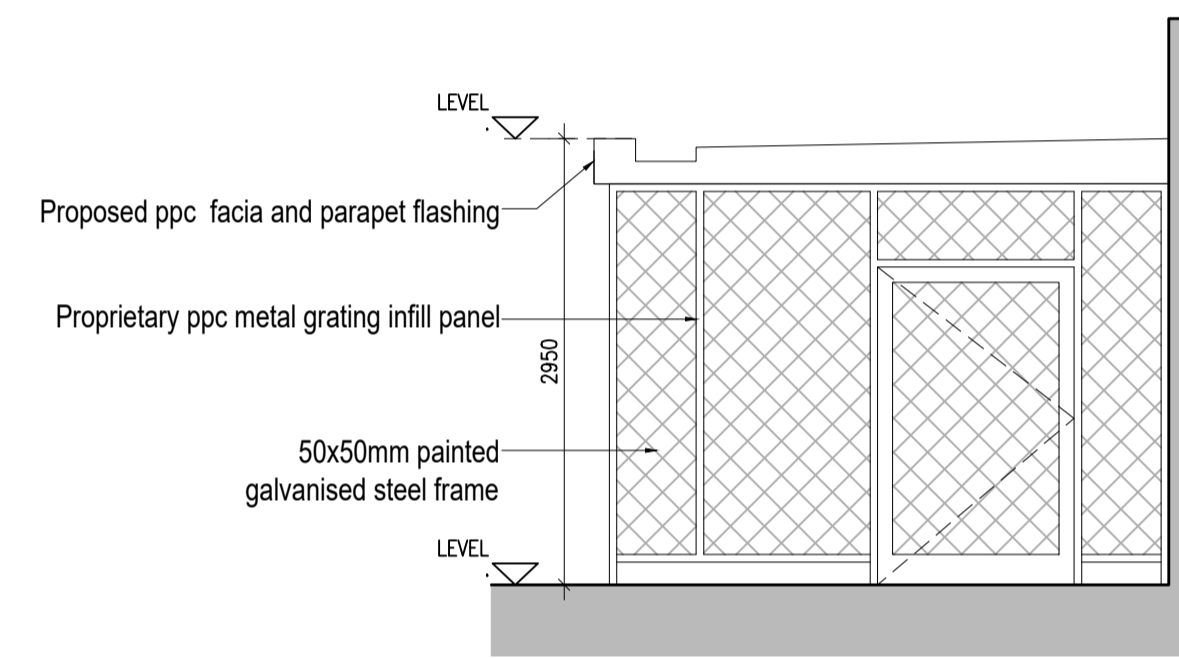

04 Proposed Covered Bicycle Parking Type 3 - Side Elevation 01
P201 1:50@A1

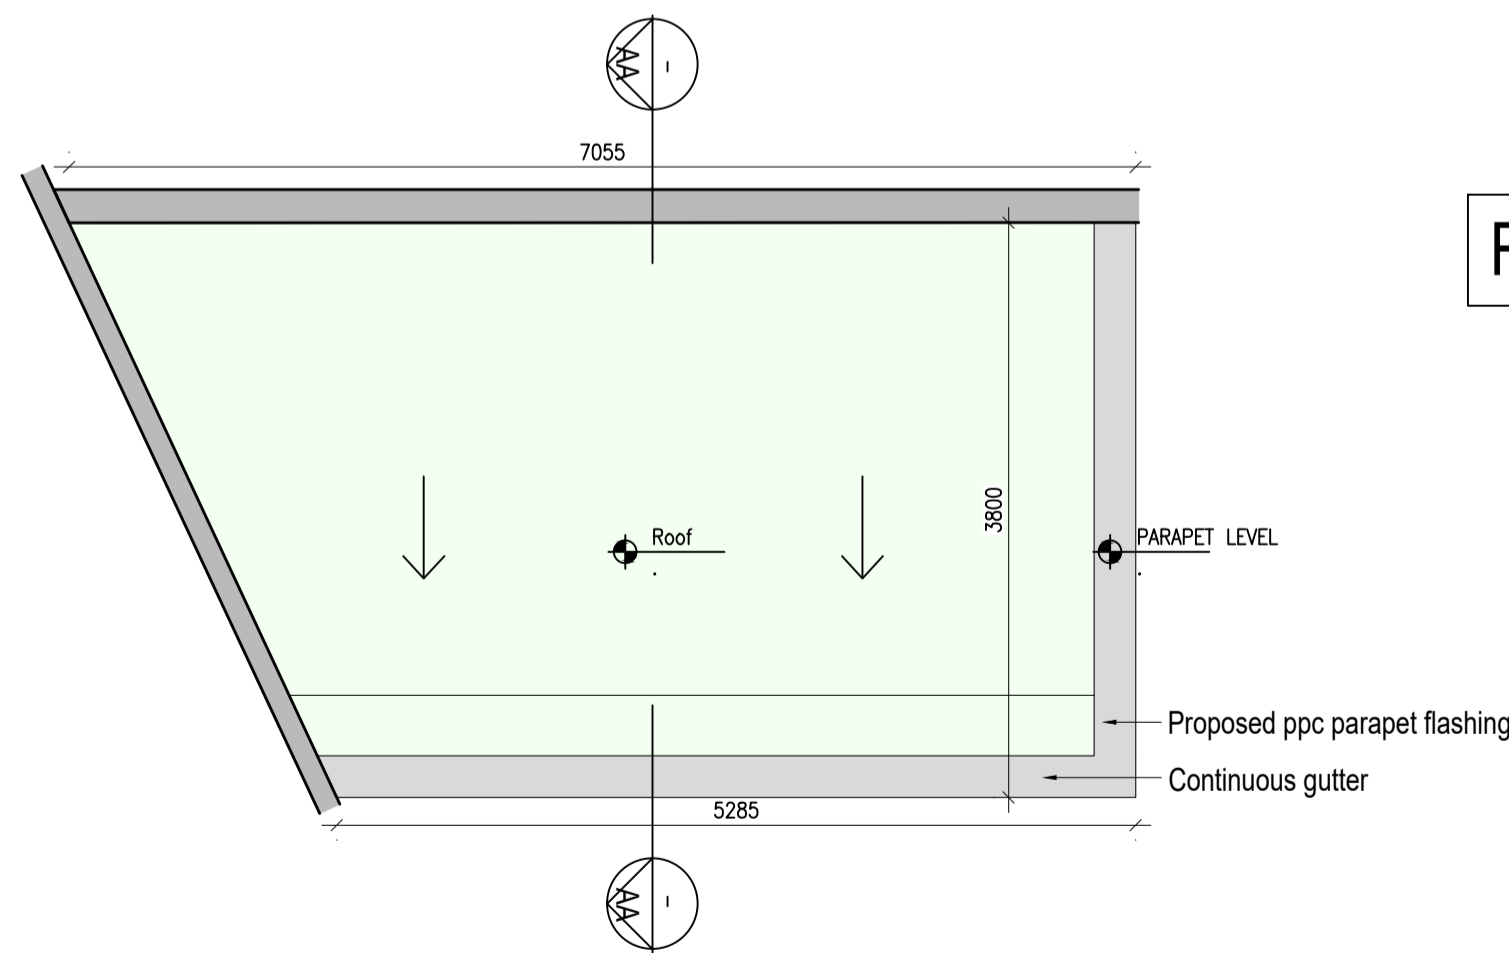

05 Proposed Covered Bicycle Parking Type 3 - Roof Plan
P201 1:50@A1

RESIDENT BIKE PARKING - BLOCK 3



07 Keyplan
P201 1:500@A1

Notes
1. Copyright Reserved
2. Work to agreed dimensions only. Do not scale drawing.
3. The contractor is responsible for checking all levels and dimensions on site and shall refer all discrepancies to the Architect.
4. Where appropriate, for details of r.c. structure, or mechanical and electrical details, see Engineers drawings.
5. Proprietary items shall be fixed in strict accordance with manufacturers instructions.
6. Sizes of proprietary items shall be checked with manufacturer.
7. The contractor shall be responsible for the coordination of structure, finishes and services.

Issue Status	Progress
Planning Application	■
Fire Cert	
Disability Cert	
Tender	
Construction	
As Built	
Information Only	

No.	Date	Revision	Initials
01	26.11.2021	SHD PLANNING APPLICATION TO ABP	AM

Project	Portmarnock South - Phase 1D Quintain Developments Ireland Limited
Drawing Title	Typical Bicycle Shelter Details Sheet 2 of 2
Drawing No	61588-P-201
Scale	1:50@A1
Rev	01
Drawn	AM
Date	26.11.2021

6-7 HARCOURT TERRACE, DUBLIN 2, IRELAND
T +353-1-618 2400 F +353-1-678 7385
www.bkd.ie

bkdarchitects
BURKE-KENNEDY DOYLE