



TYPE 3


House Unit Type:
A2,A4

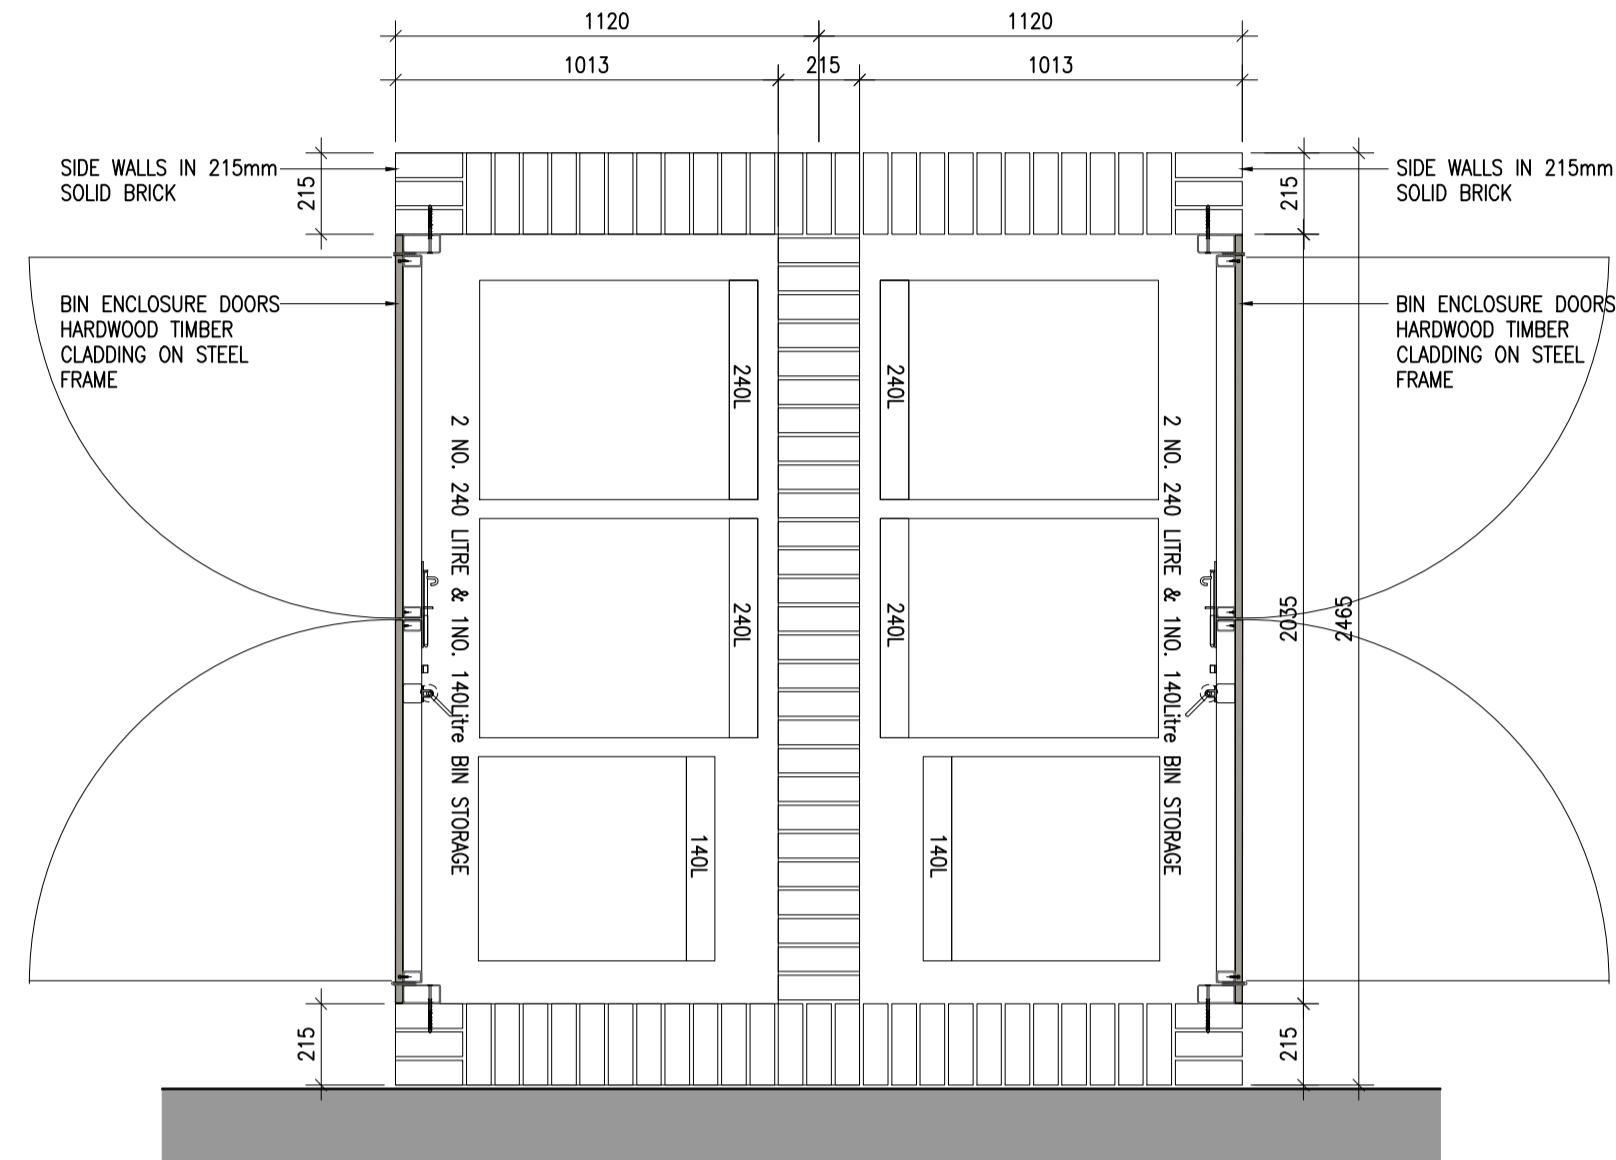


1 Bin store Type 3 Plan
P203 Scale 1:20

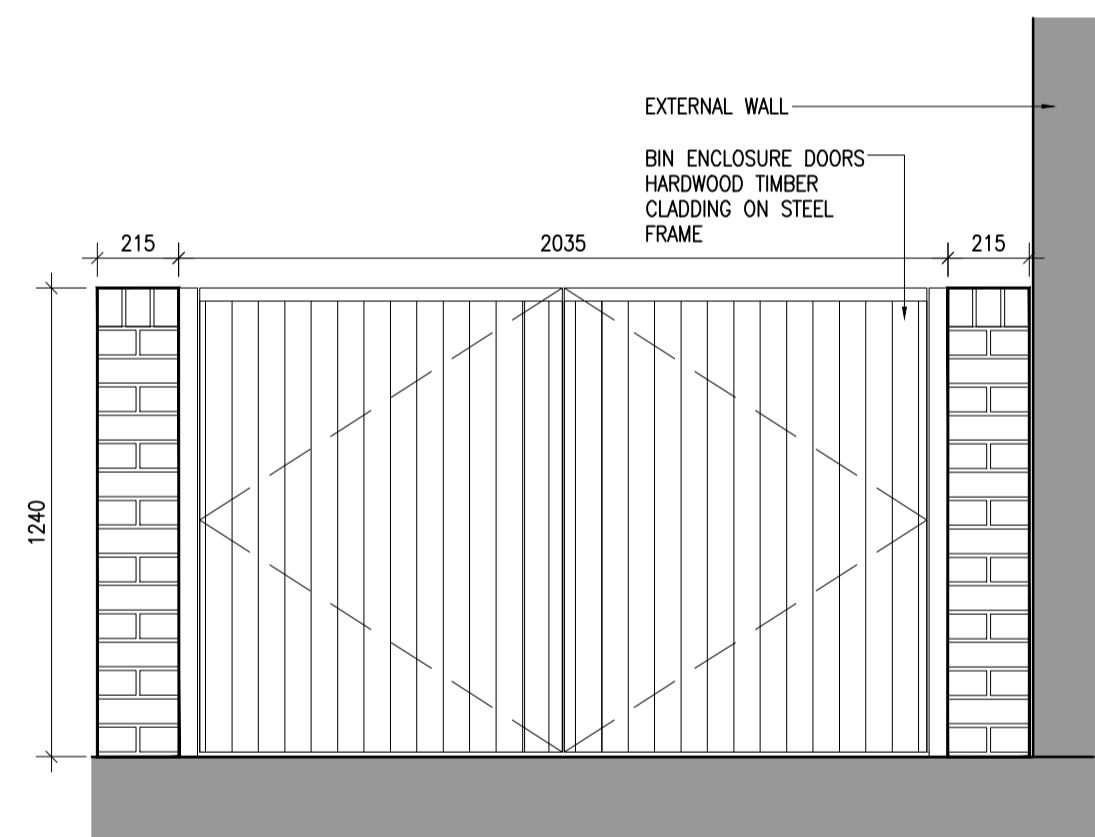

2 Bin store Type 3 Side Elevation
P203 Scale 1:20

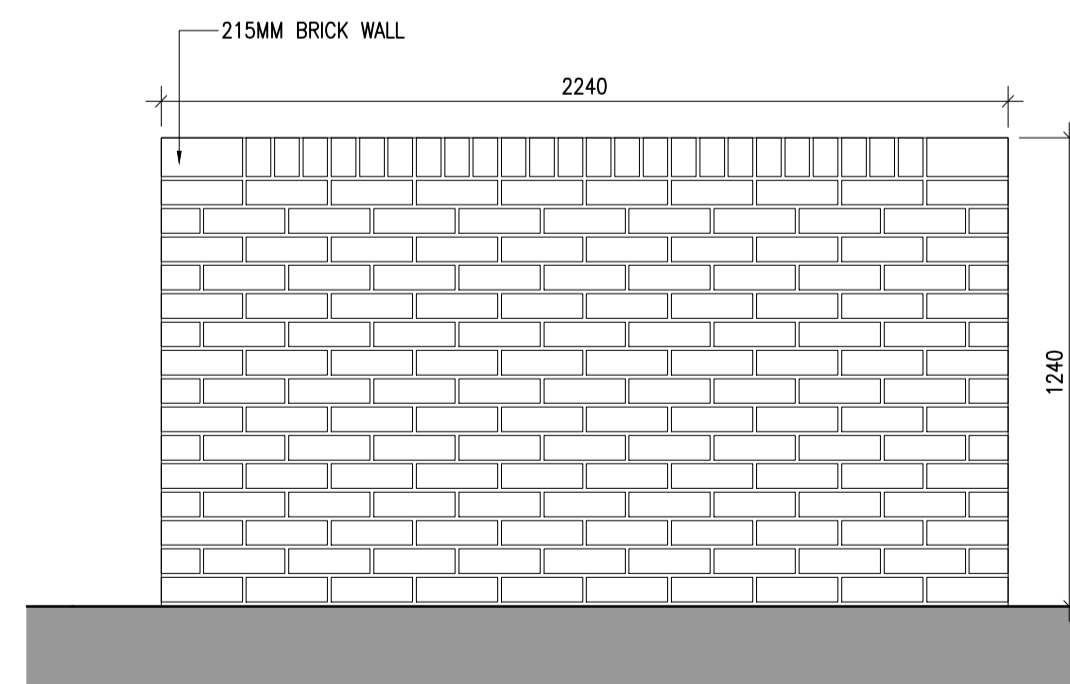


3 Bin store Type 3 Front
P203 Scale 1:20

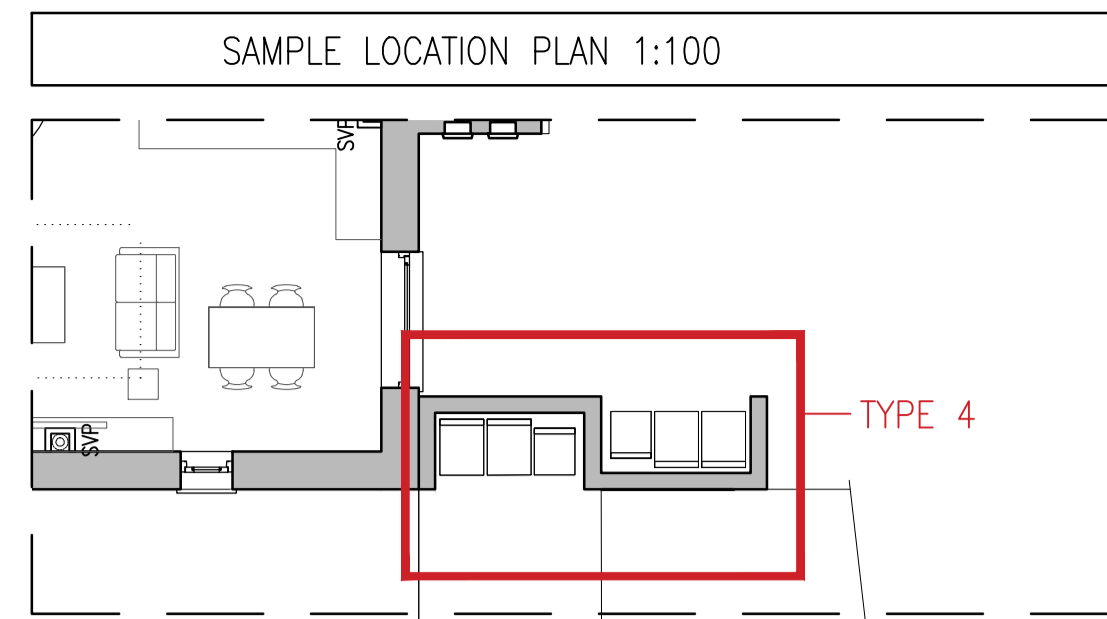


TYPE 4


Duplex Unit Type:
J3,K3

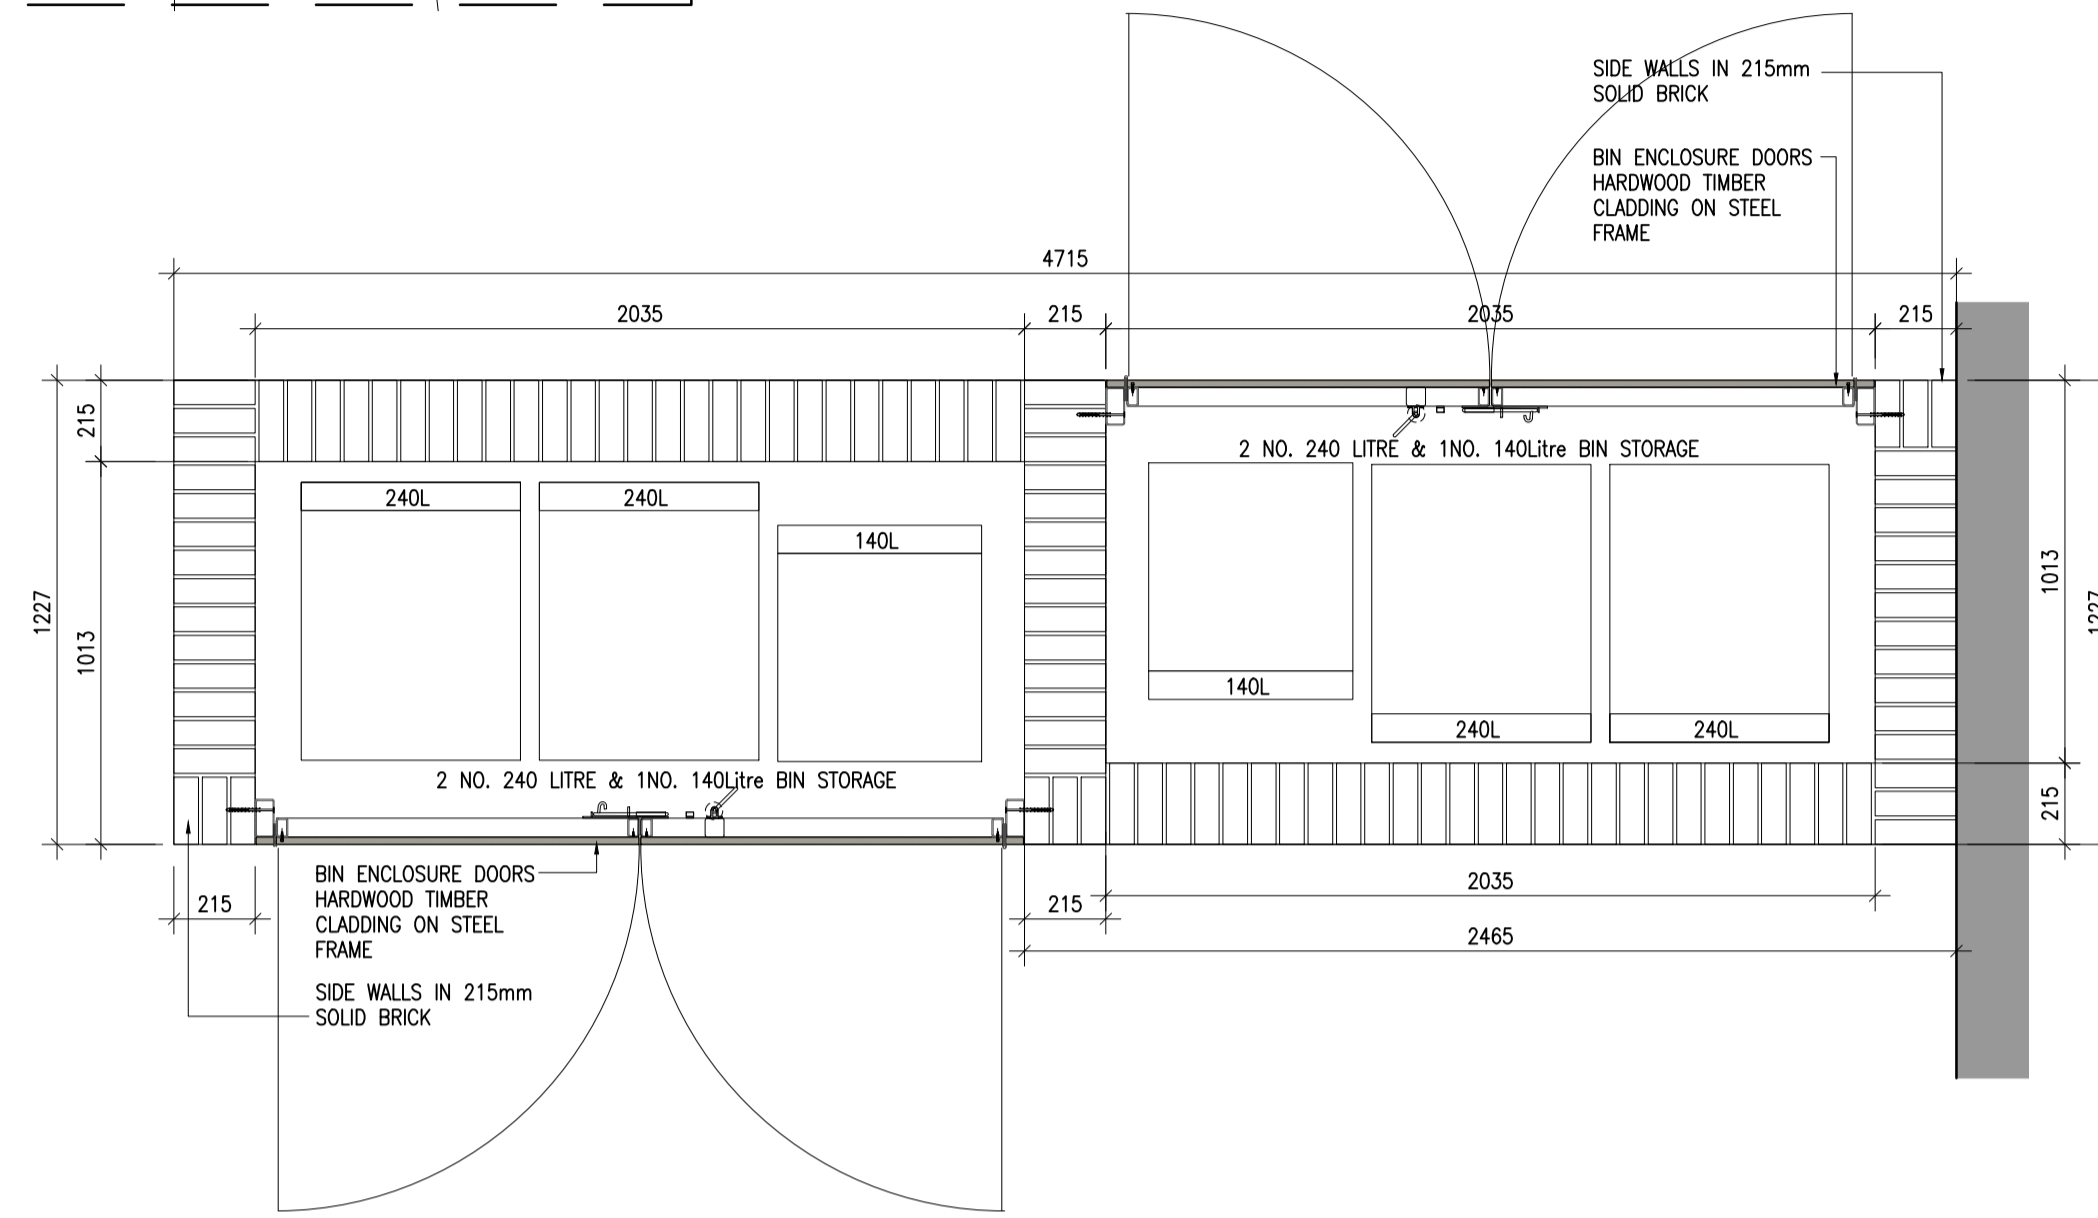


1 Bin store Type 4 Plan
P203 Scale 1:20

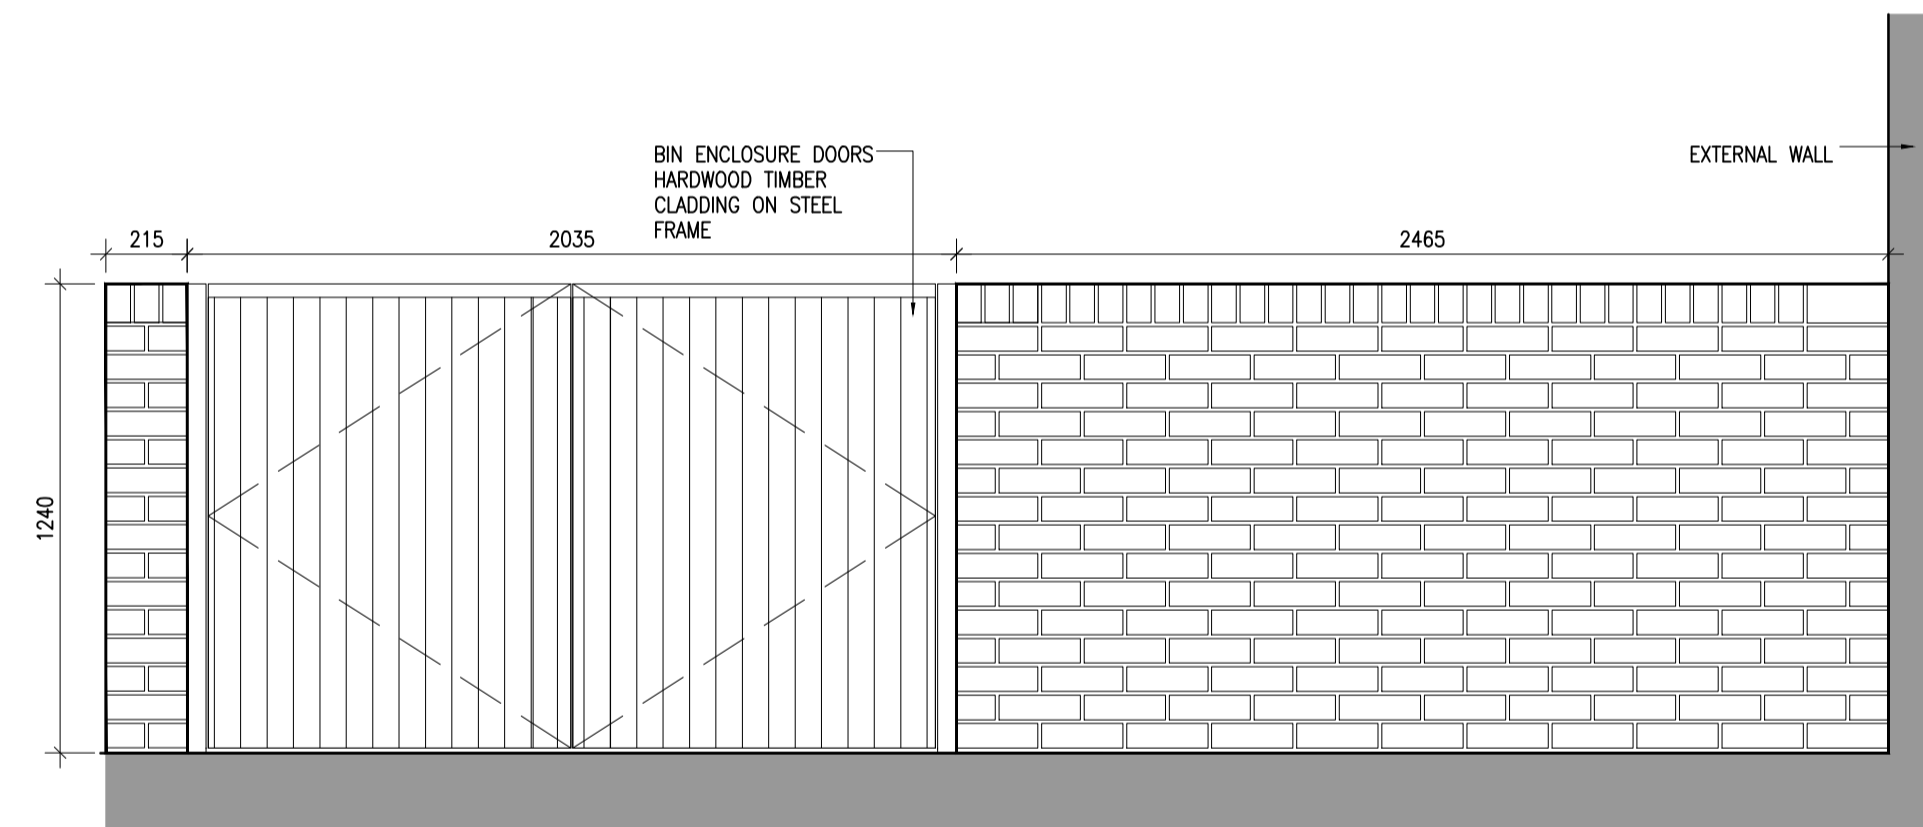

2 Bin store Type 4 Front Elevation
P203 Scale 1:20

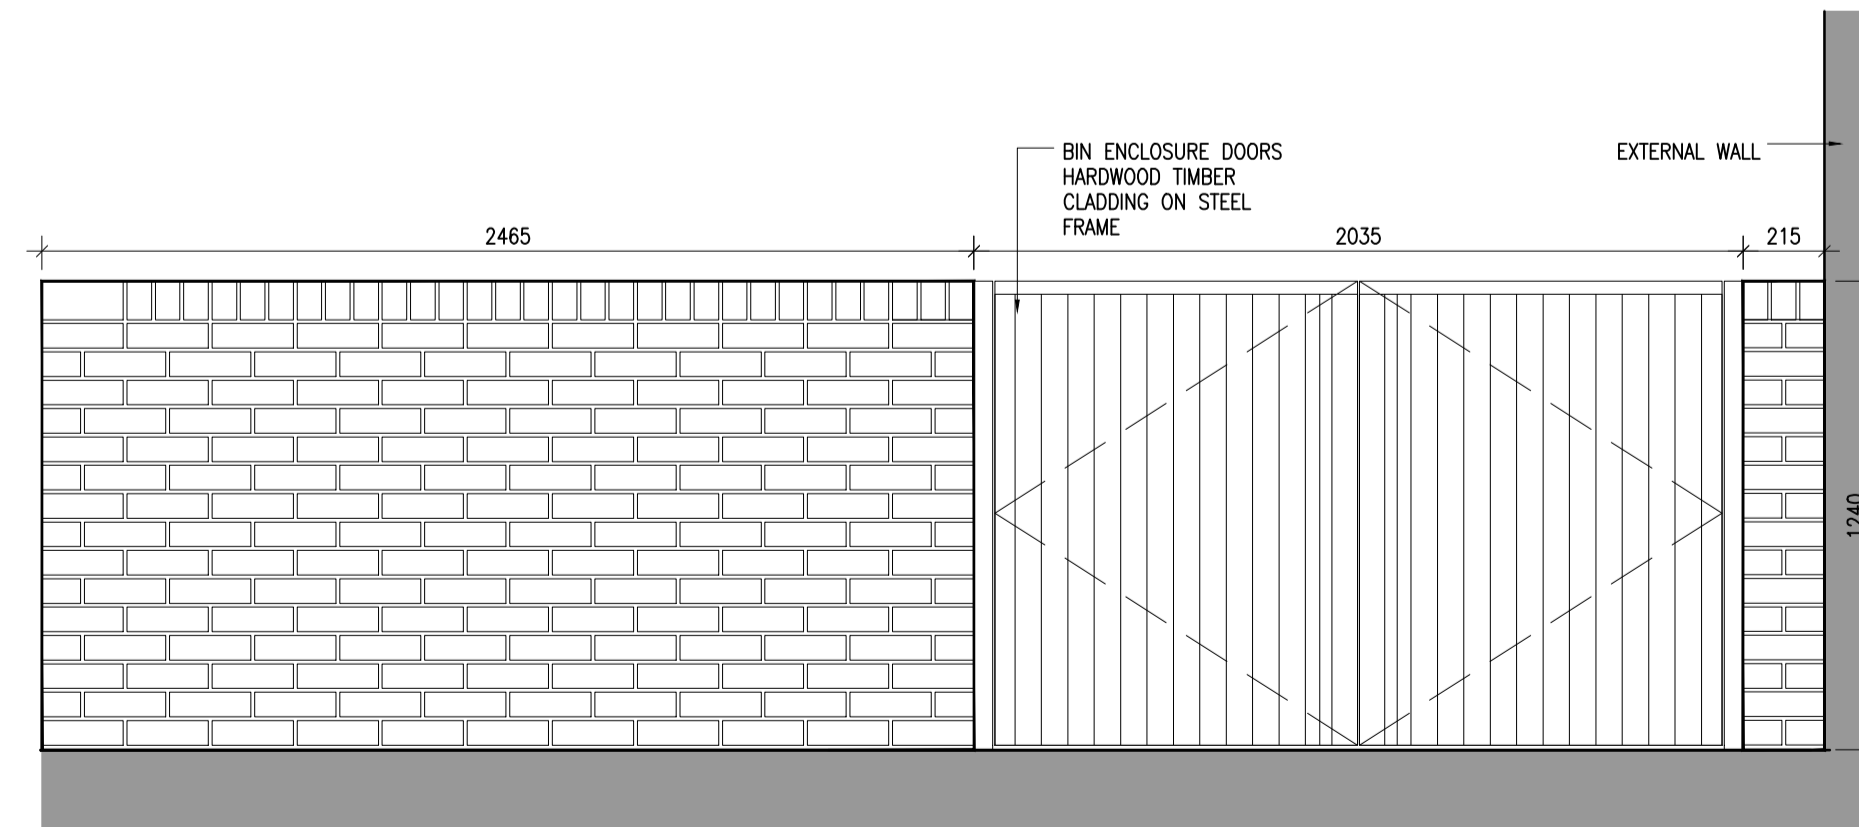

3 Bin store Type 4 Rear Elevation
P203 Scale 1:20

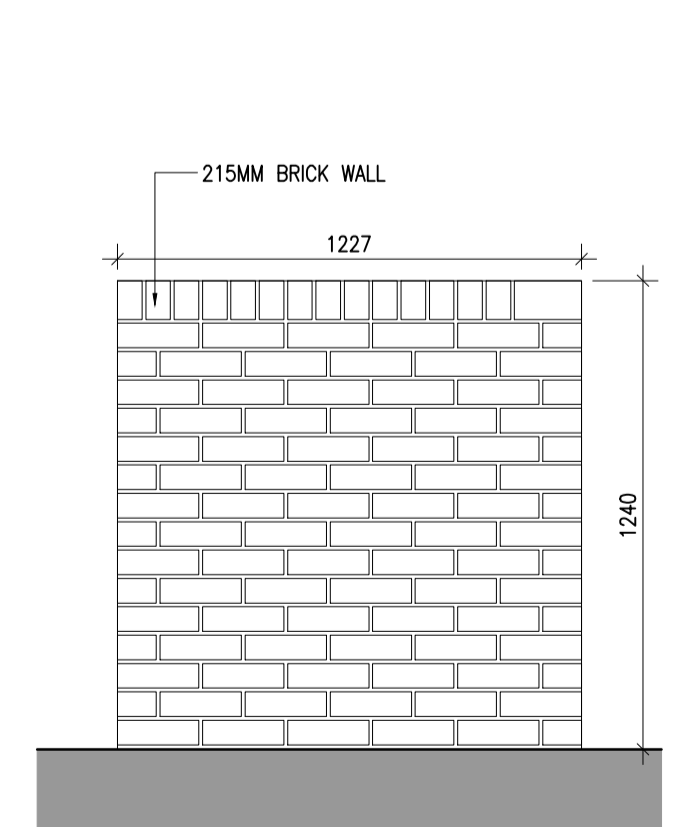

4 Bin store Type 4 Side Elevation
P203 Scale 1:20

Notes	Issue Status
1. Copyright Reserved	Progress
2. Work to agreed dimensions only. Do not scale drawing	Planning Application
3. The contractor is responsible for checking all levels and dimensions on site and shall refer all discrepancies to the Architect	Fire Cert
4. Where appropriate, for details of r.c. structure, or mechanical and electrical details, see Engineers drawings	Disability Cert
5. Proprietary items shall be fixed in strict accordance with manufacturers instructions.	Tender
6. Sizes of proprietary items shall be checked with manufacturer.	Construction
7. The contractor shall be responsible for the coordination of structure, finishes and services.	As Built
	Information Only

No.	Date	Revision	Initials
01	26.11.2021	SHD PLANNING APPLICATION TO ABP	AM

Project	Portmarnock South - Phase 1D Quintain Developments Ireland Limited
Drawing Title	Bin store Details Type 3, 4
Drawing No	61588-P-203
Scale	1:20@A1
Rev	01
Drawn	AM
Date	26.11.2021

6-7 HARDCOURT TERRACE, DUBLIN 2, IRELAND
t +353-1-618 2400 f +353-1-676 7396
www.bkd.ie

bkdarchitects
BURKE-KENNEDY DOYLE