



TYPE 7


House Unit Type:
F1, F2, B2, F4

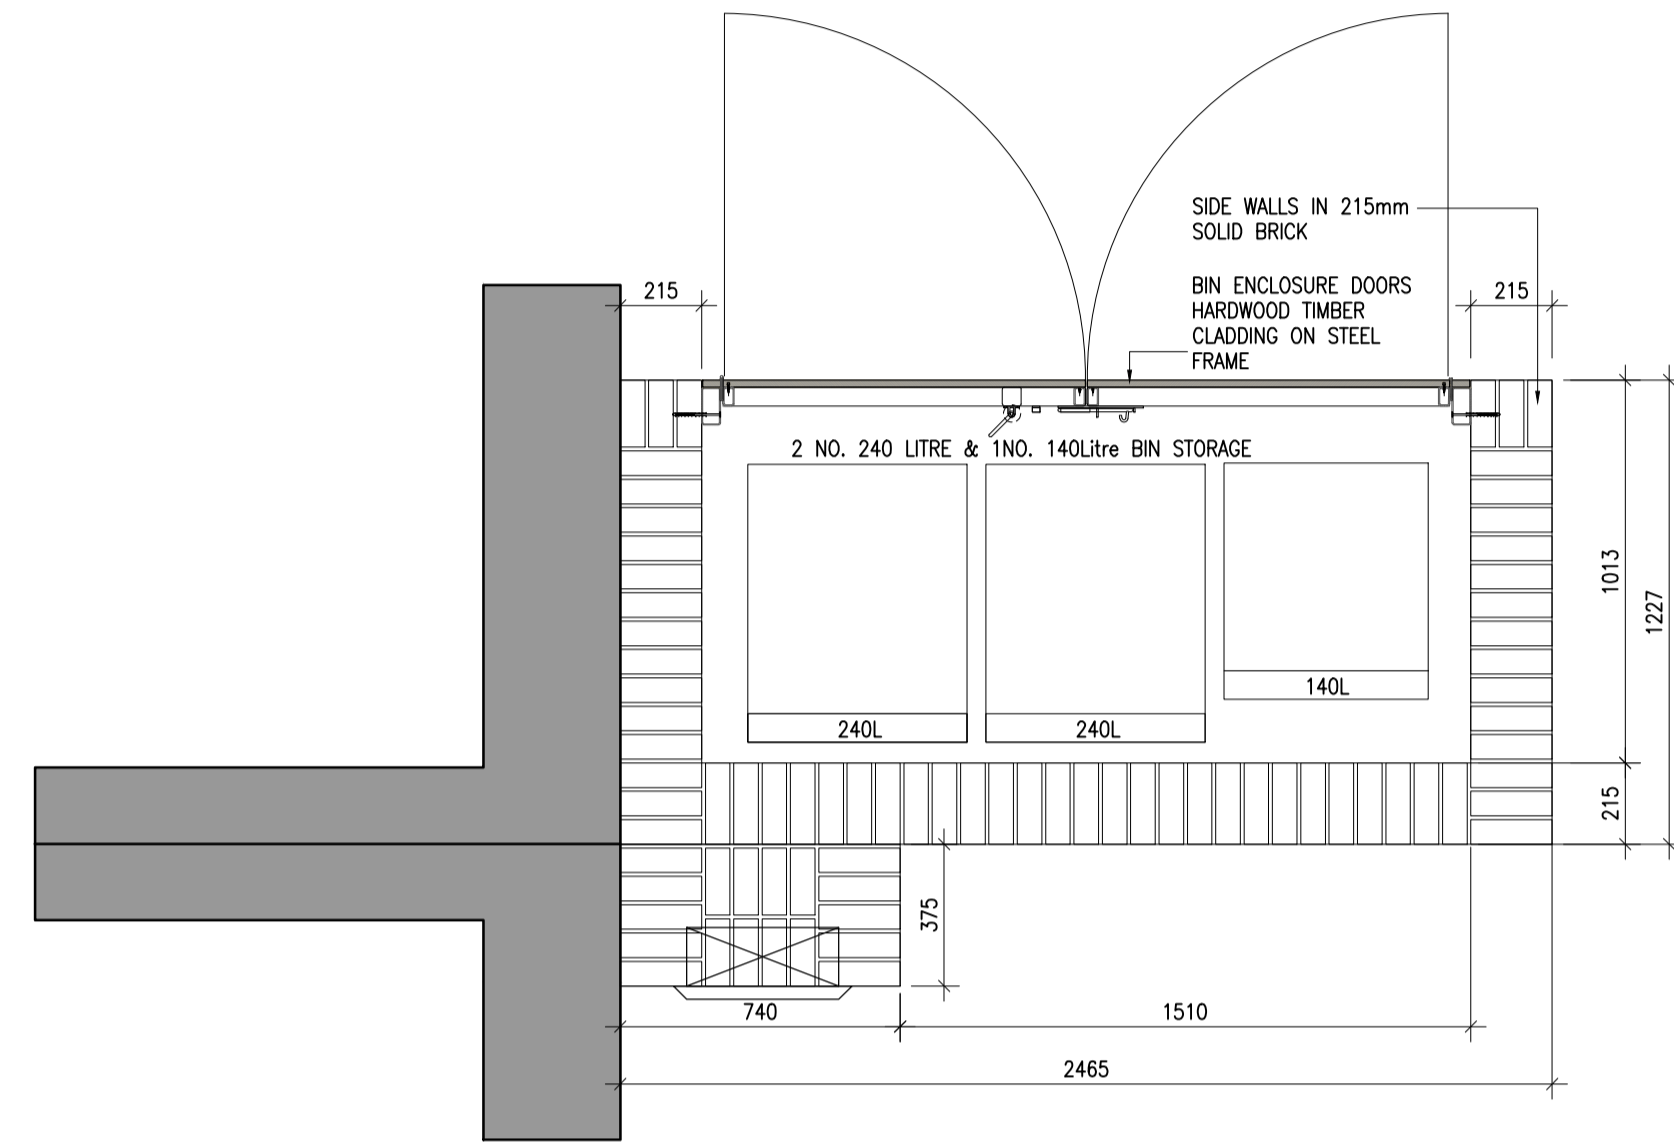


1 Bin store Type 7 Plan
P205 Scale 1:20

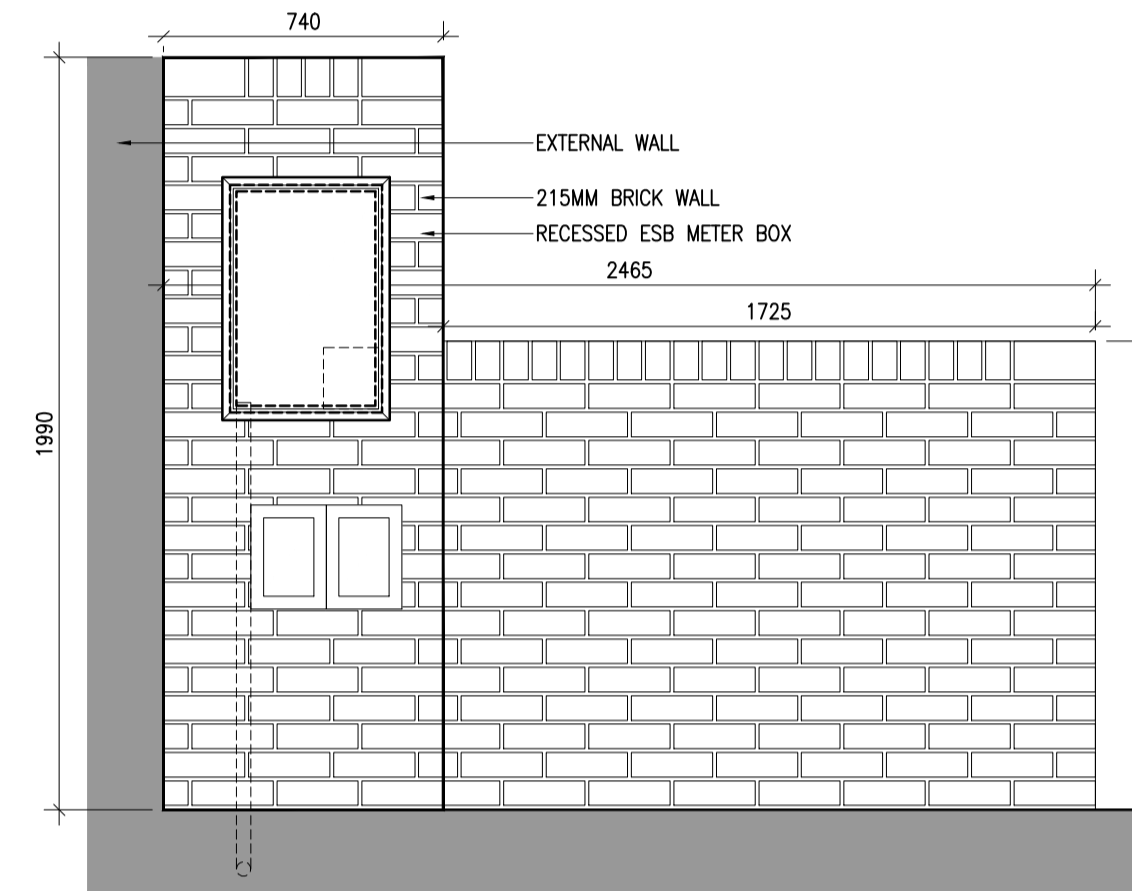

2 Bin store Type 7 Front Elevation
P205 Scale 1:20

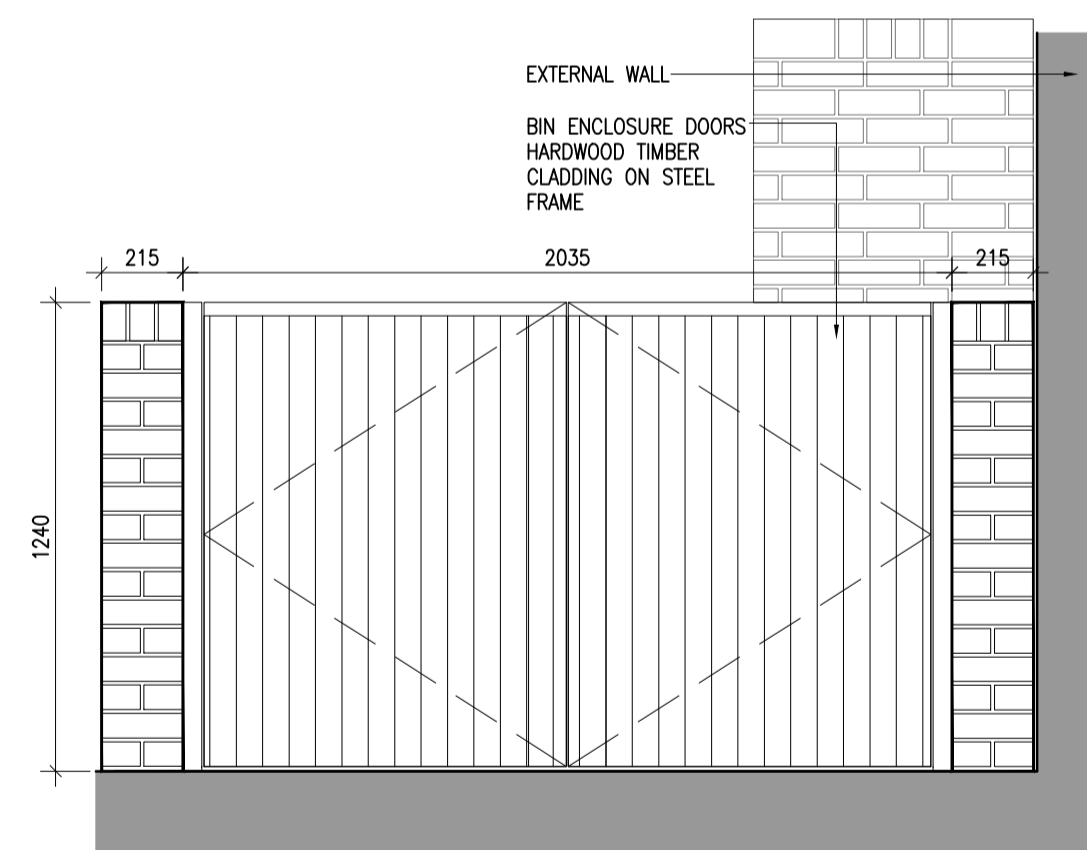

3 Bin store Type 7 Rear Elevation
P205 Scale 1:20

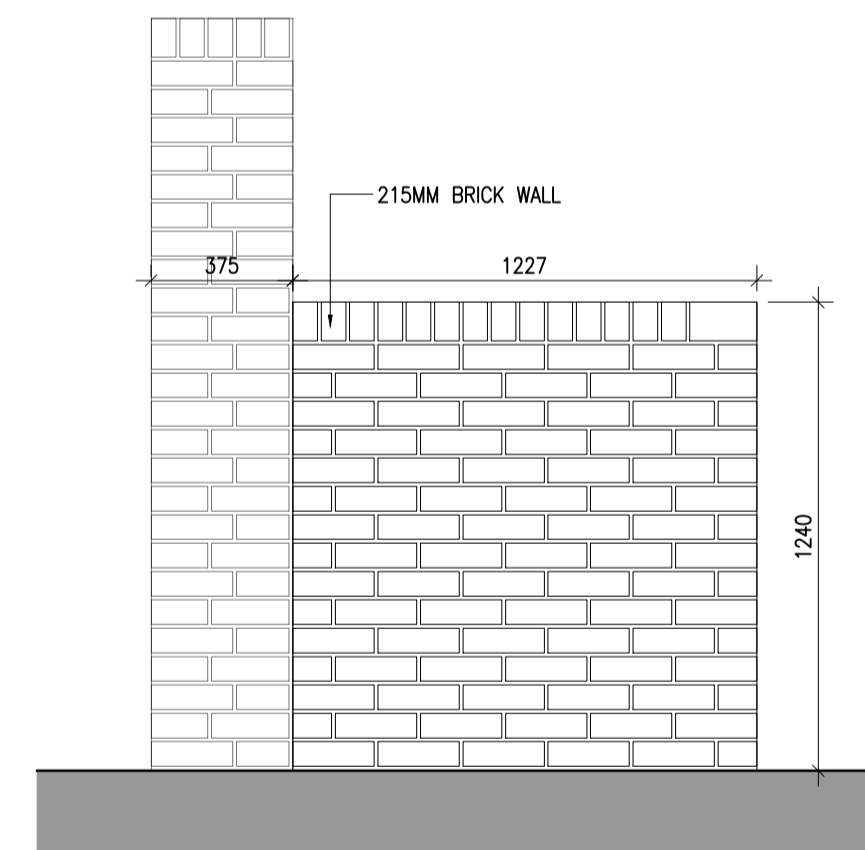

4 Bin store Type 7 Side Elevation
P205 Scale 1:20

Notes	Issue Status
1. Copyright Reserved	
2. Work to licensed dimensions only. Do not scale drawing	
3. The contractor is responsible for checking all levels and dimensions on site and shall refer all discrepancies to the Architect	
4. Where appropriate, for details of r.c. structure, or mechanical and electrical details, see Engineers drawings	
5. Proprietary items shall be fixed in strict accordance with manufacturers instructions.	
6. Sizes of proprietary items shall be checked with manufacturer.	
7. The contractor shall be responsible for the coordination of structure, finishes and services.	

Progress	Planning Application	Fire Cert	Disability Cert	Tender	Construction	As Built	Information Only

No.	Date	Revision	Initials
01	26.11.2021	SHD PLANNING APPLICATION TO ABP	AM

Project	Drawing Title	Drawing No	Scale	Rev	Drawn	Date
Portmarnock South - Phase 1D Quintain Developments Ireland Limited	Bin store Details Type 7	61588-P-205	1:20@A1	01	AM	26.11.2021

Project	Drawing Title	Drawing No	Scale	Rev	Drawn	Date
Portmarnock South - Phase 1D Quintain Developments Ireland Limited	Bin store Details Type 7	61588-P-205	1:20@A1	01	AM	26.11.2021

6-7 HARDCOURT TERRACE, DUBLIN 2, IRELAND
t +353-1-6182400 f +353-1-6767396
www.bkd.ie

bkdarchitects
BURKE-KENNEDY DOYLE