




2 ESB Substation Typical Front Elevation
P206 Scale 1:20

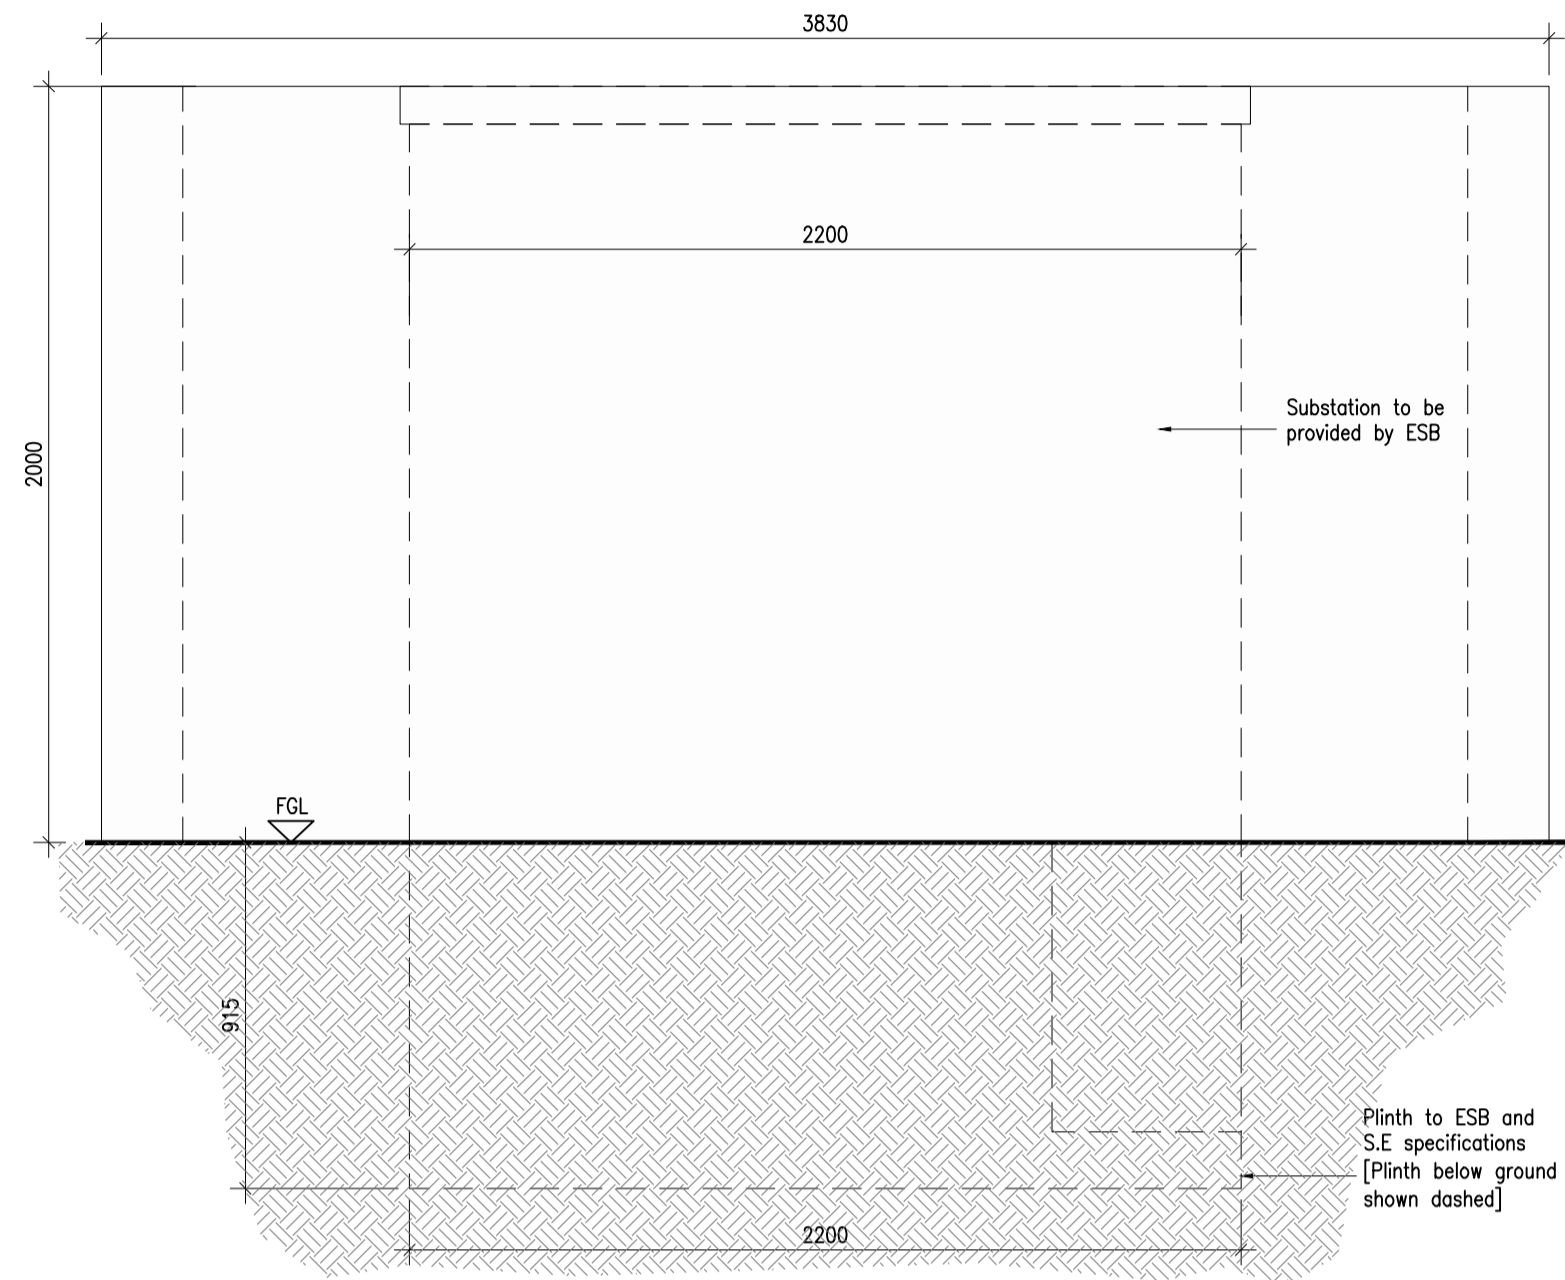

3 ESB Substation Typical Rear Elevation
P206 Scale 1:20

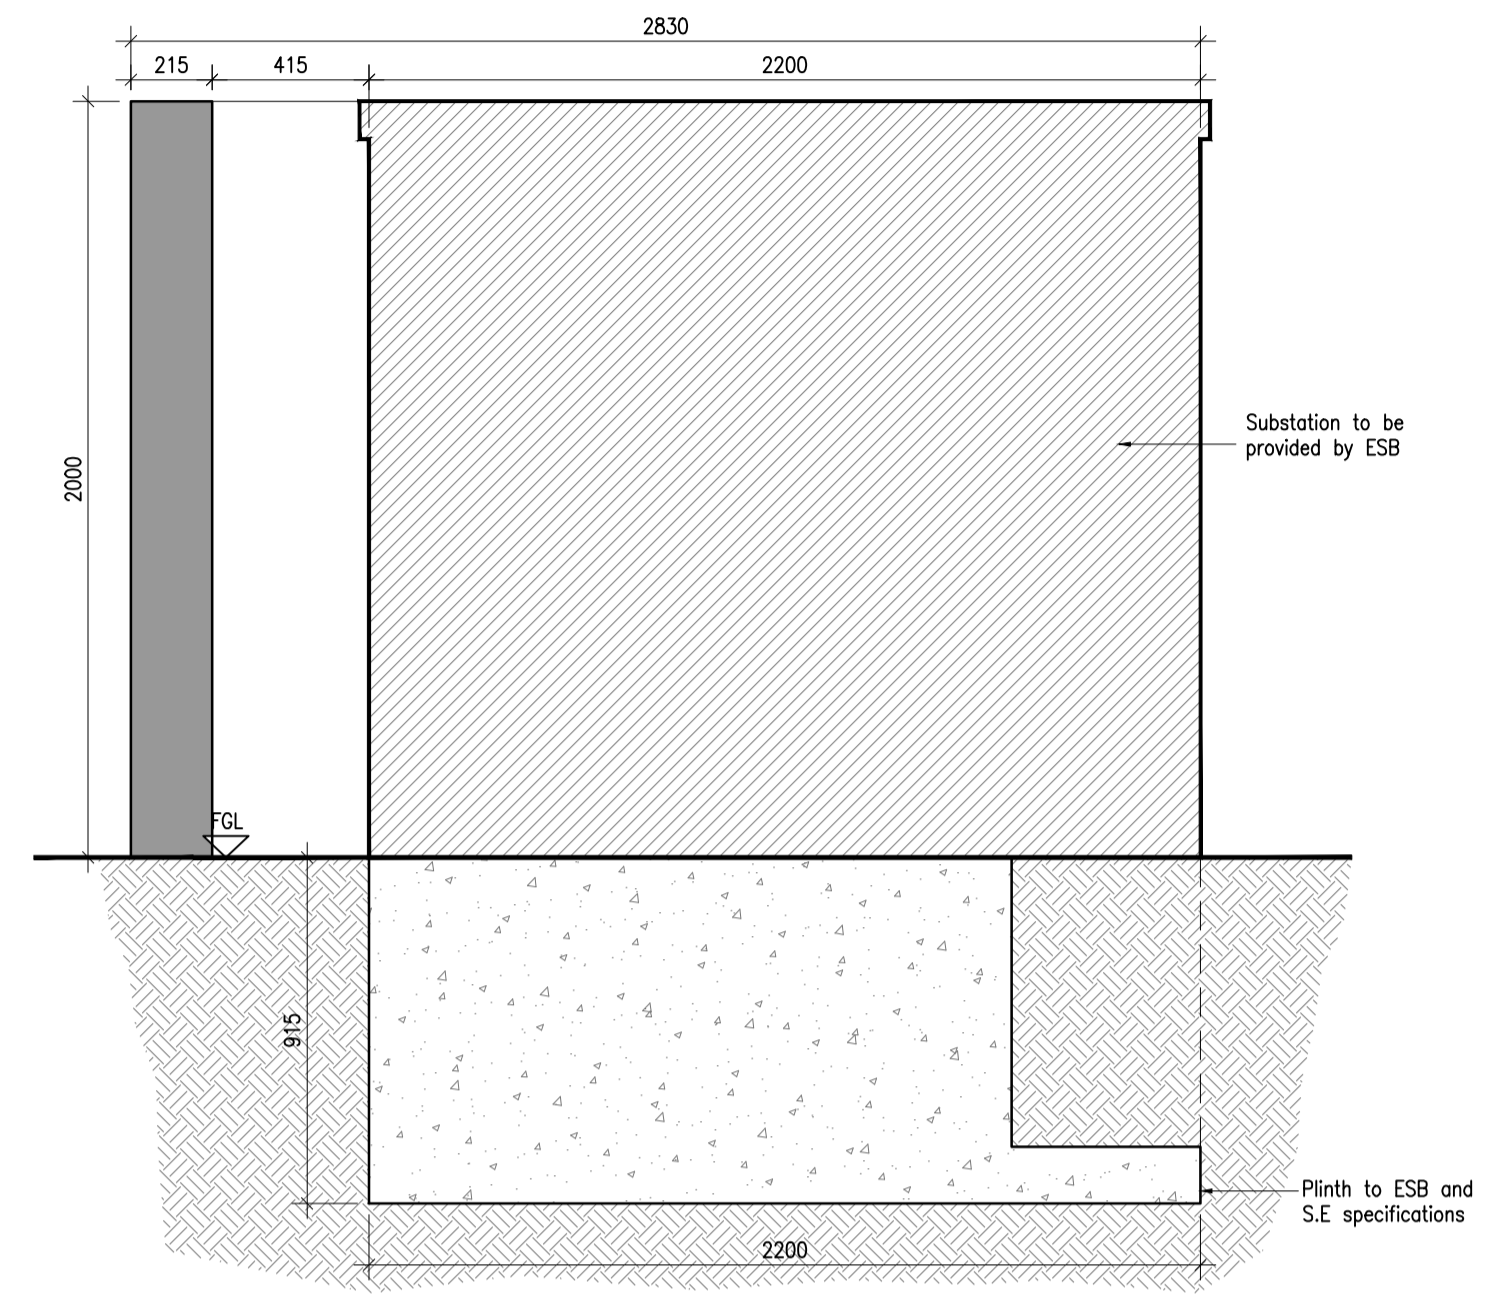

4 ESB Substation Typical Section
P206 Scale 1:20

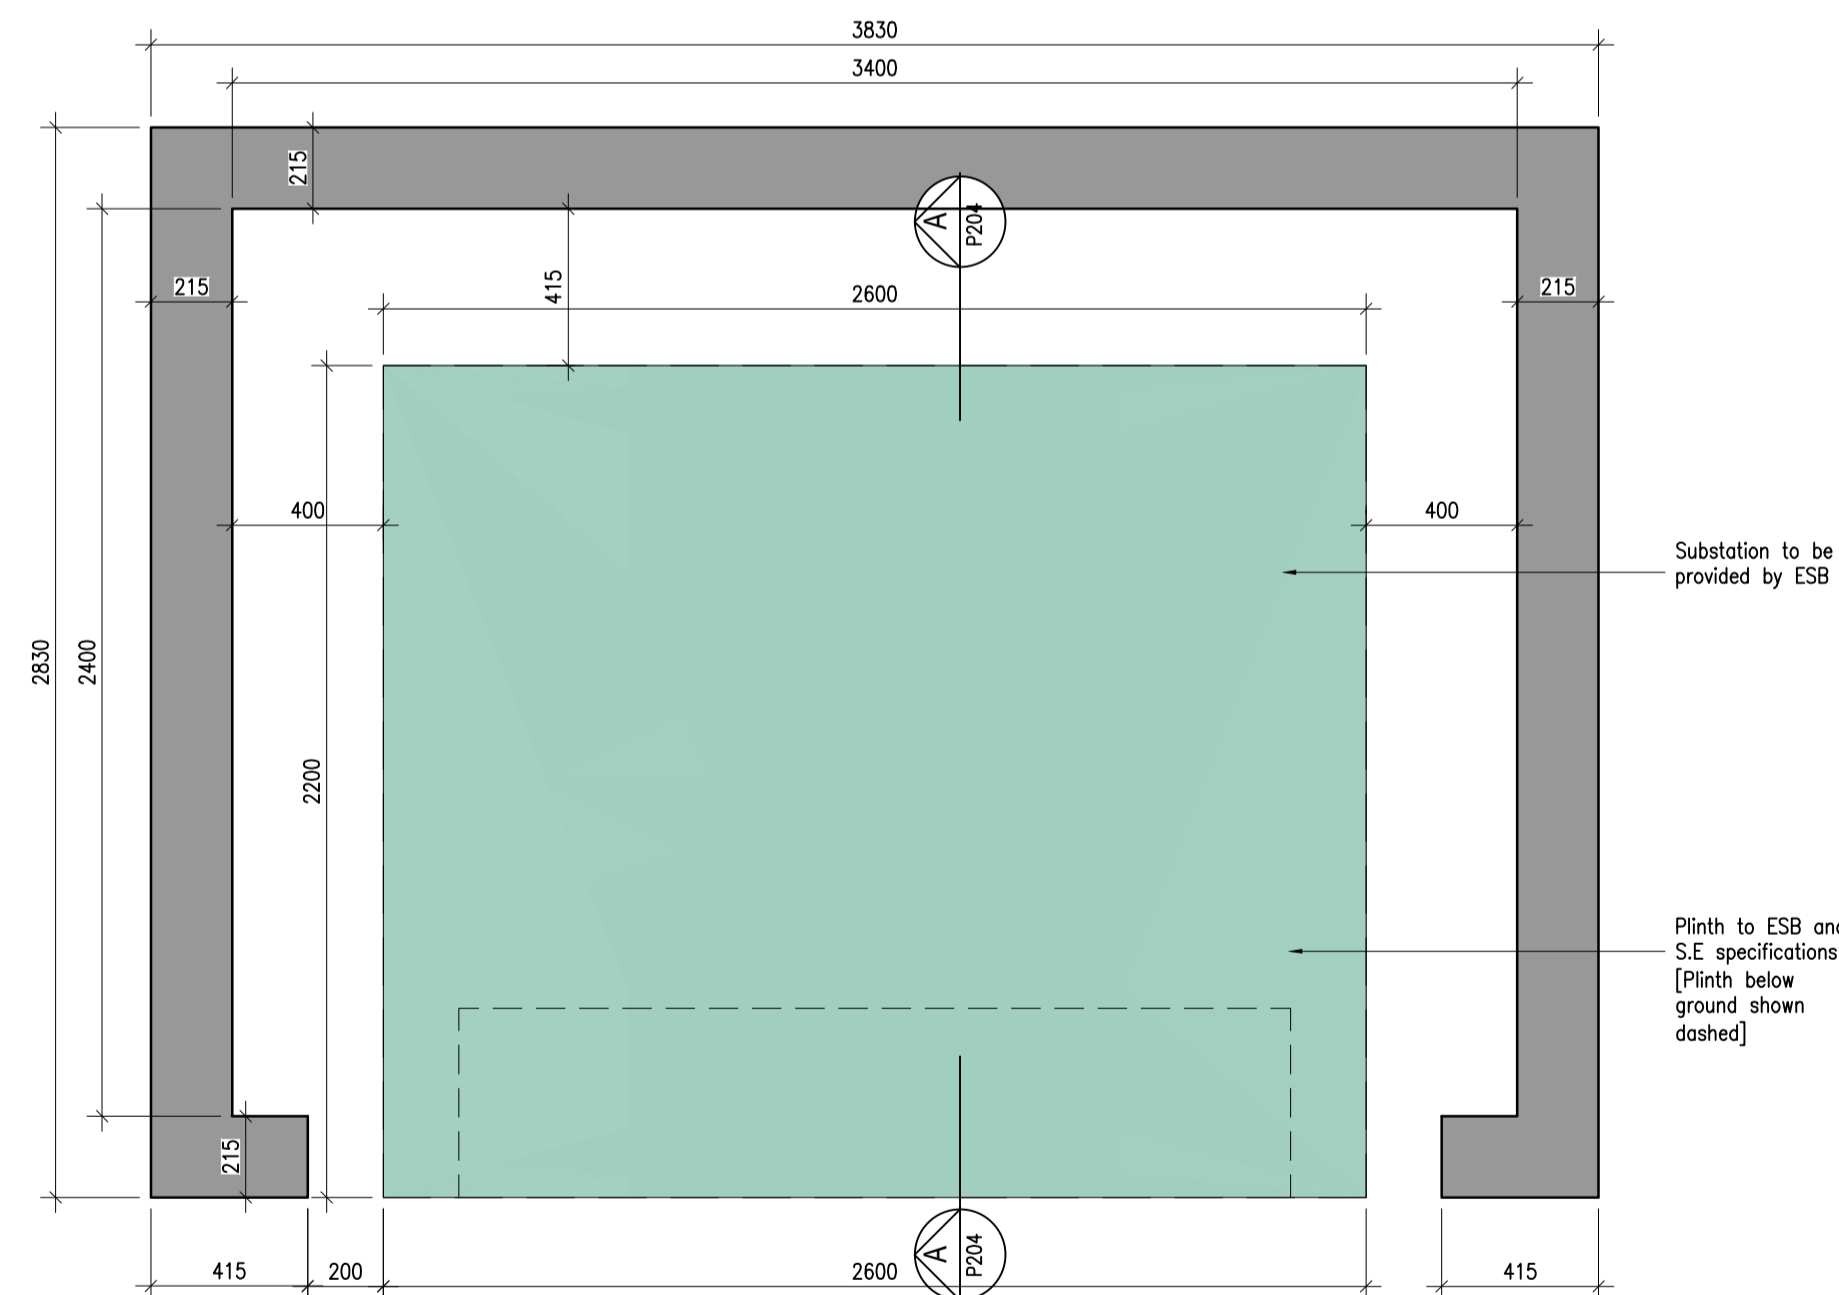

1 ESB Substation Typical Plan
P206 Scale 1:20



05 KEY PLAN - SUBSTATIONS
P206 NTS0A1

| Notes | Issue Status |
|--|----------------------|
| 1. Copyright Reserved | Progress |
| 2. Work to ignore dimensions only. Do not scale drawing | Planning Application |
| 3. The contractor is responsible for checking all levels and dimensions on site and shall refer all discrepancies to the Architect | Fire Cert |
| 4. Where appropriate, for details of r.c. structure, or mechanical and electrical details, see Engineers drawings | Disability Cert |
| 5. Proprietary items shall be fixed in strict accordance with manufacturers instructions. | Tender |
| 6. Sizes of proprietary items shall be checked with manufacturer. | Construction |
| 7. The contractor shall be responsible for the coordination of structure, finishes and services. | As Built |
| | Information Only |

| No. | Date | Revision | Initials |
|-----|------------|---------------------------------|----------|
| 01 | 26.11.2021 | SHD PLANNING APPLICATION TO ABP | AM |

| | |
|---|--------------------|
| Project Portmarnock South - Phase 1D Quintain Developments Ireland Limited | |
| Drawing Title ESB Substation Details | |
| Drawing No 61588-P-206 | |
| Scale 1:20@A1 | Rev 01 |
| Drawn AM | Date 26.11.2021 |

6-7 HARICOURT TERRACE, DUBLIN 2, IRELAND
t +353-1-618 2400 f +353-1-676 7396
www.bkd.ie

bkdarchitects
BURKE-KENNEDY DOYLE