


**KEY FRAME PLAN**  
SCALE 1:5000

LEGEND:	
PLANNING BOUNDARY	
2.65m PALISADE FENCE OR AS NOTED	
POST AND RAIL STOCK FENCE OR AS NOTED	
NEW ROAD HOT ROLLED ASPHALT TO DOE SPECIFICATION FOR ROAD WORKS	
NEW ROAD	
PROPOSED BUILDING	
220kV DUCT ROUTE	
FINISHED LEVELS SHOWN TYPICAL	

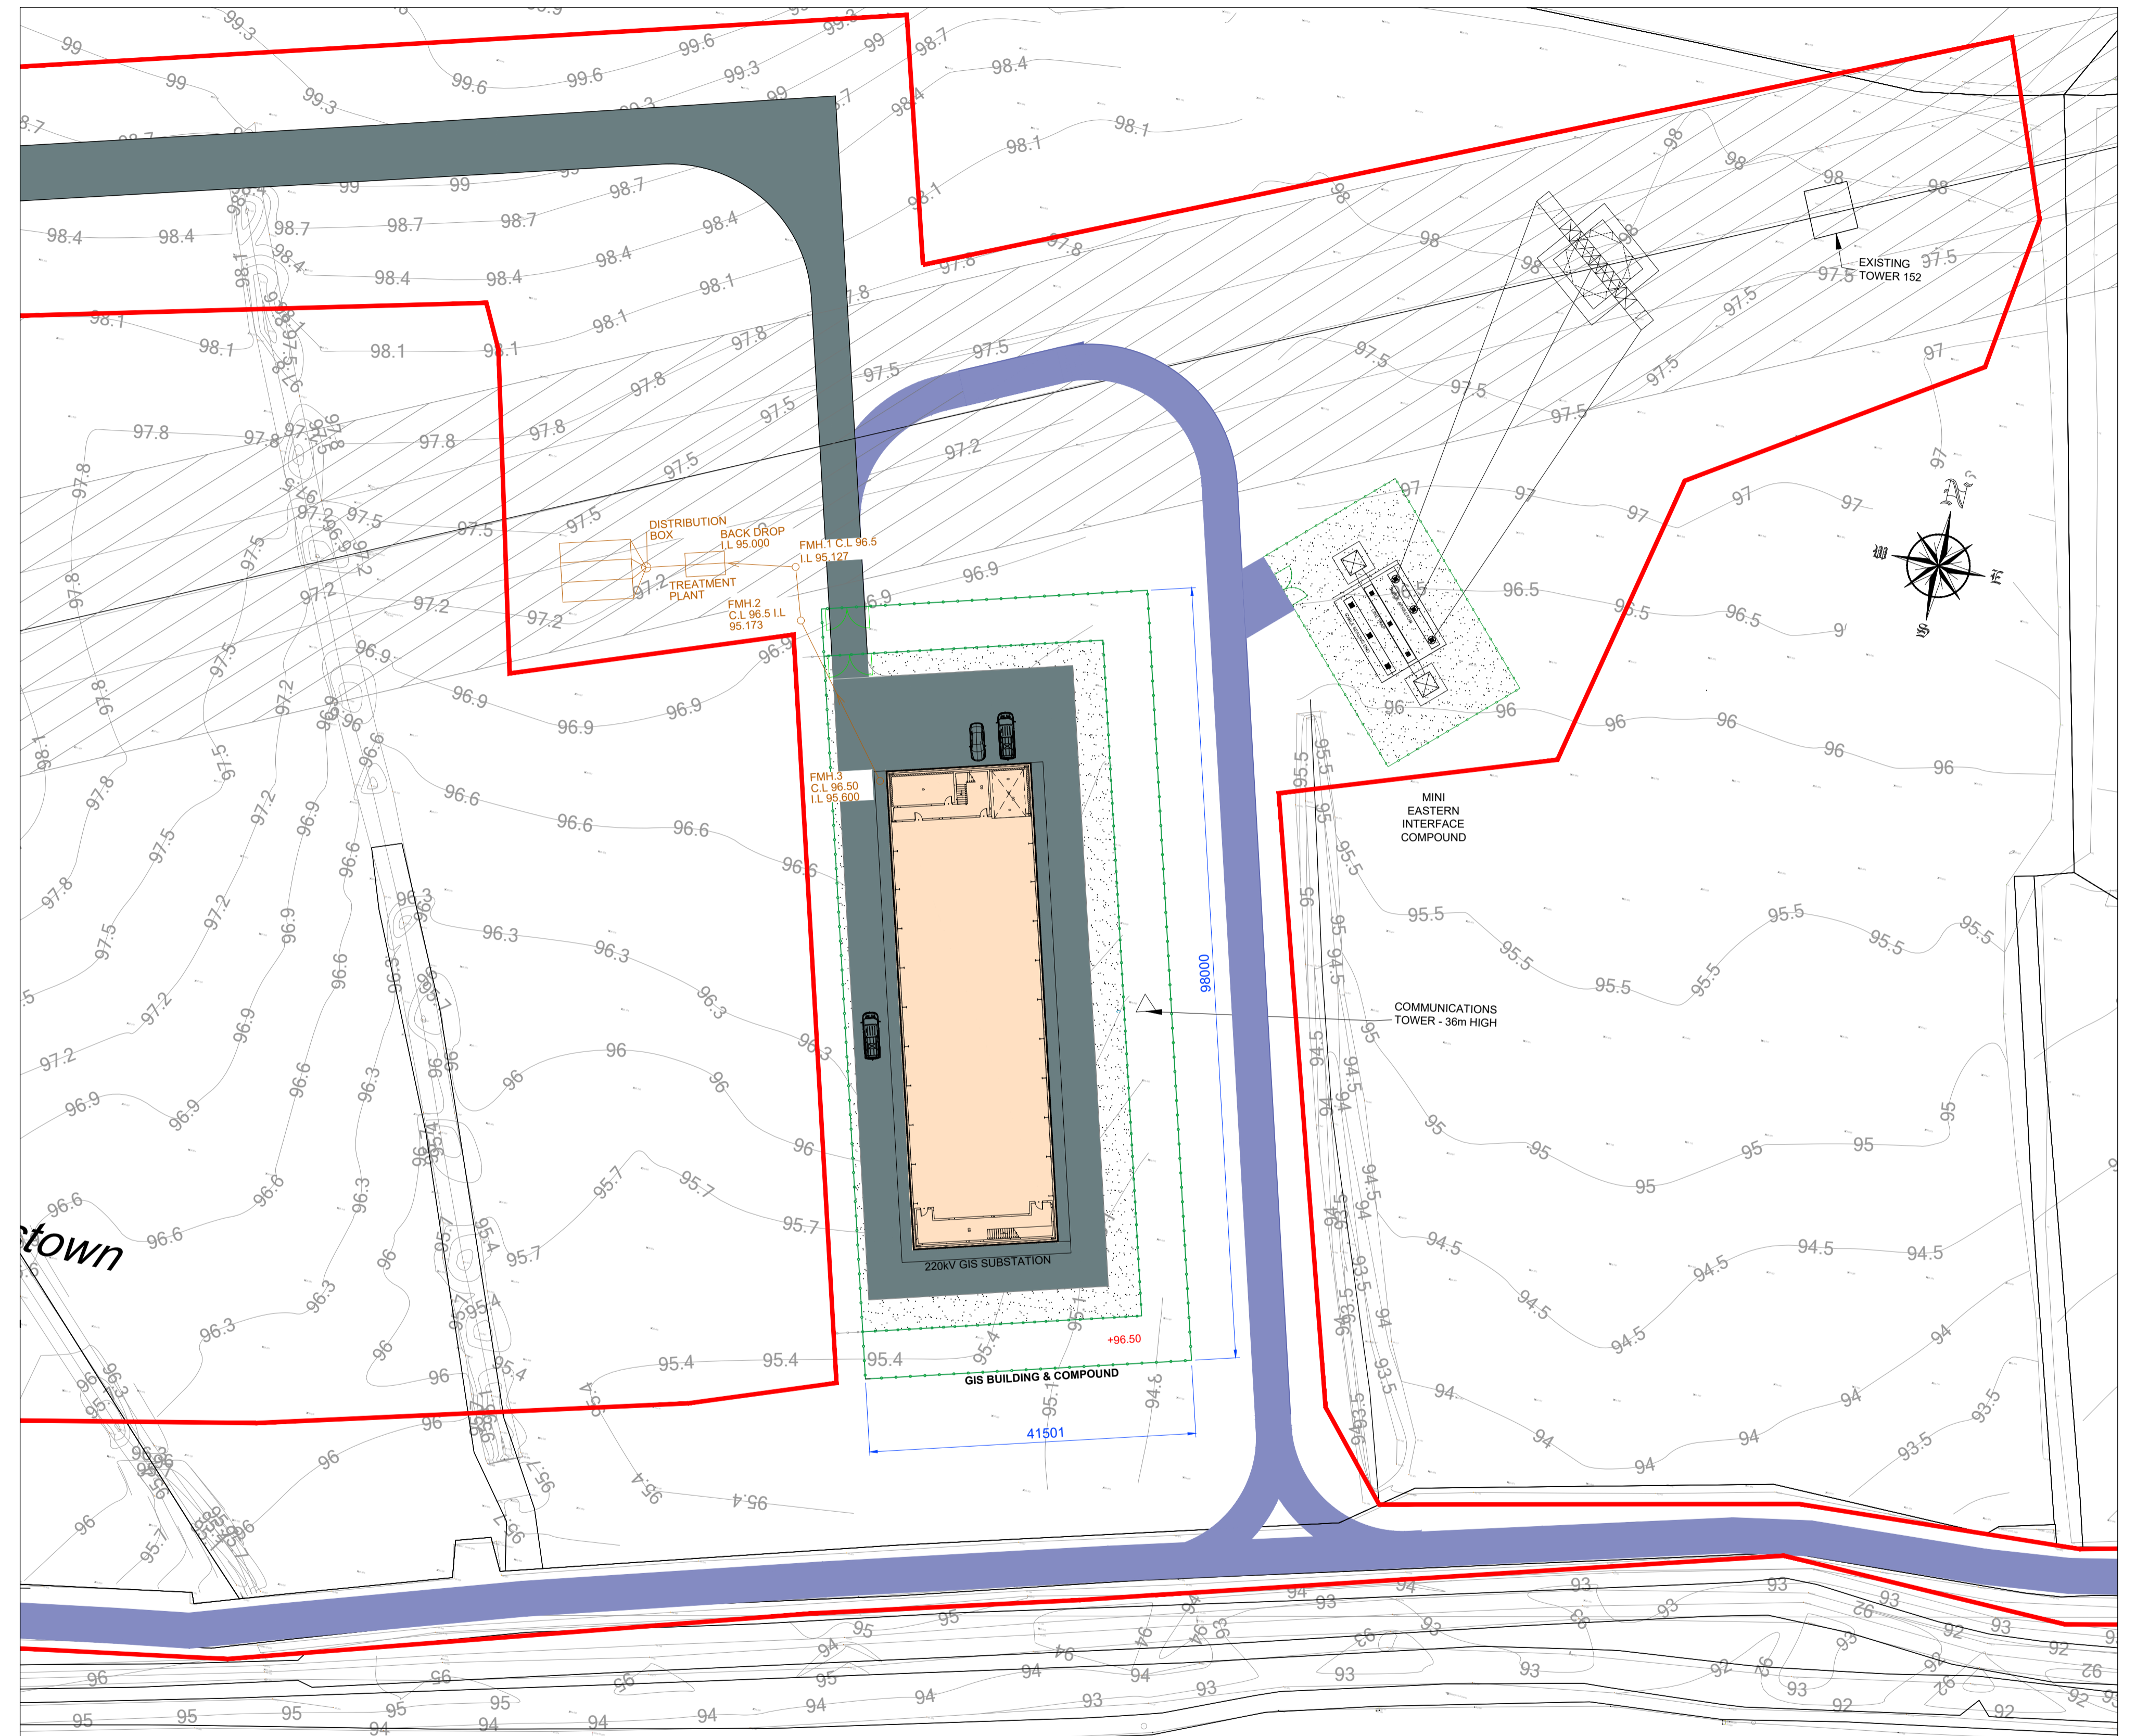

**KEY FRAME 1**  
SCALE 1:500

Rev.	Modifications	By	Date
P1	PLANNING ISSUE	BB	11.02.22

**NOTES:**  
1 FIGURED DIMENSIONS ONLY TO BE TAKEN FROM THIS DRAWING.  
2 THIS DRAWING TO BE READ IN CONJUNCTION WITH ALL OTHER RELEVANT DRAWINGS AND SPECIFICATIONS.

© COPYRIGHT OF



Email: info@halston.ie  
Tel: 094 9010111

**IHUB BUILDING**  
WESTPORT ROAD  
CASTLEBAR  
CO. MAYO.  
F23 K162

Client	LUMCLOON ENERGY	Drawn	BB	Checked	WD	Approved	CS
Project	LEL GIS, CASTLELOST CO. WESTMEATH	Date	Dec 2021	Scales	AS SHOWN (A1)	Sheet	1 of 1
Title	PROPOSED FOUL WATER DRAINAGE LAYOUT	Sheet Size	A1	Job No.	SEP-0347	Rev	P1
Stage	PLANNING	Dwg. No.	0347-PL-2006				