
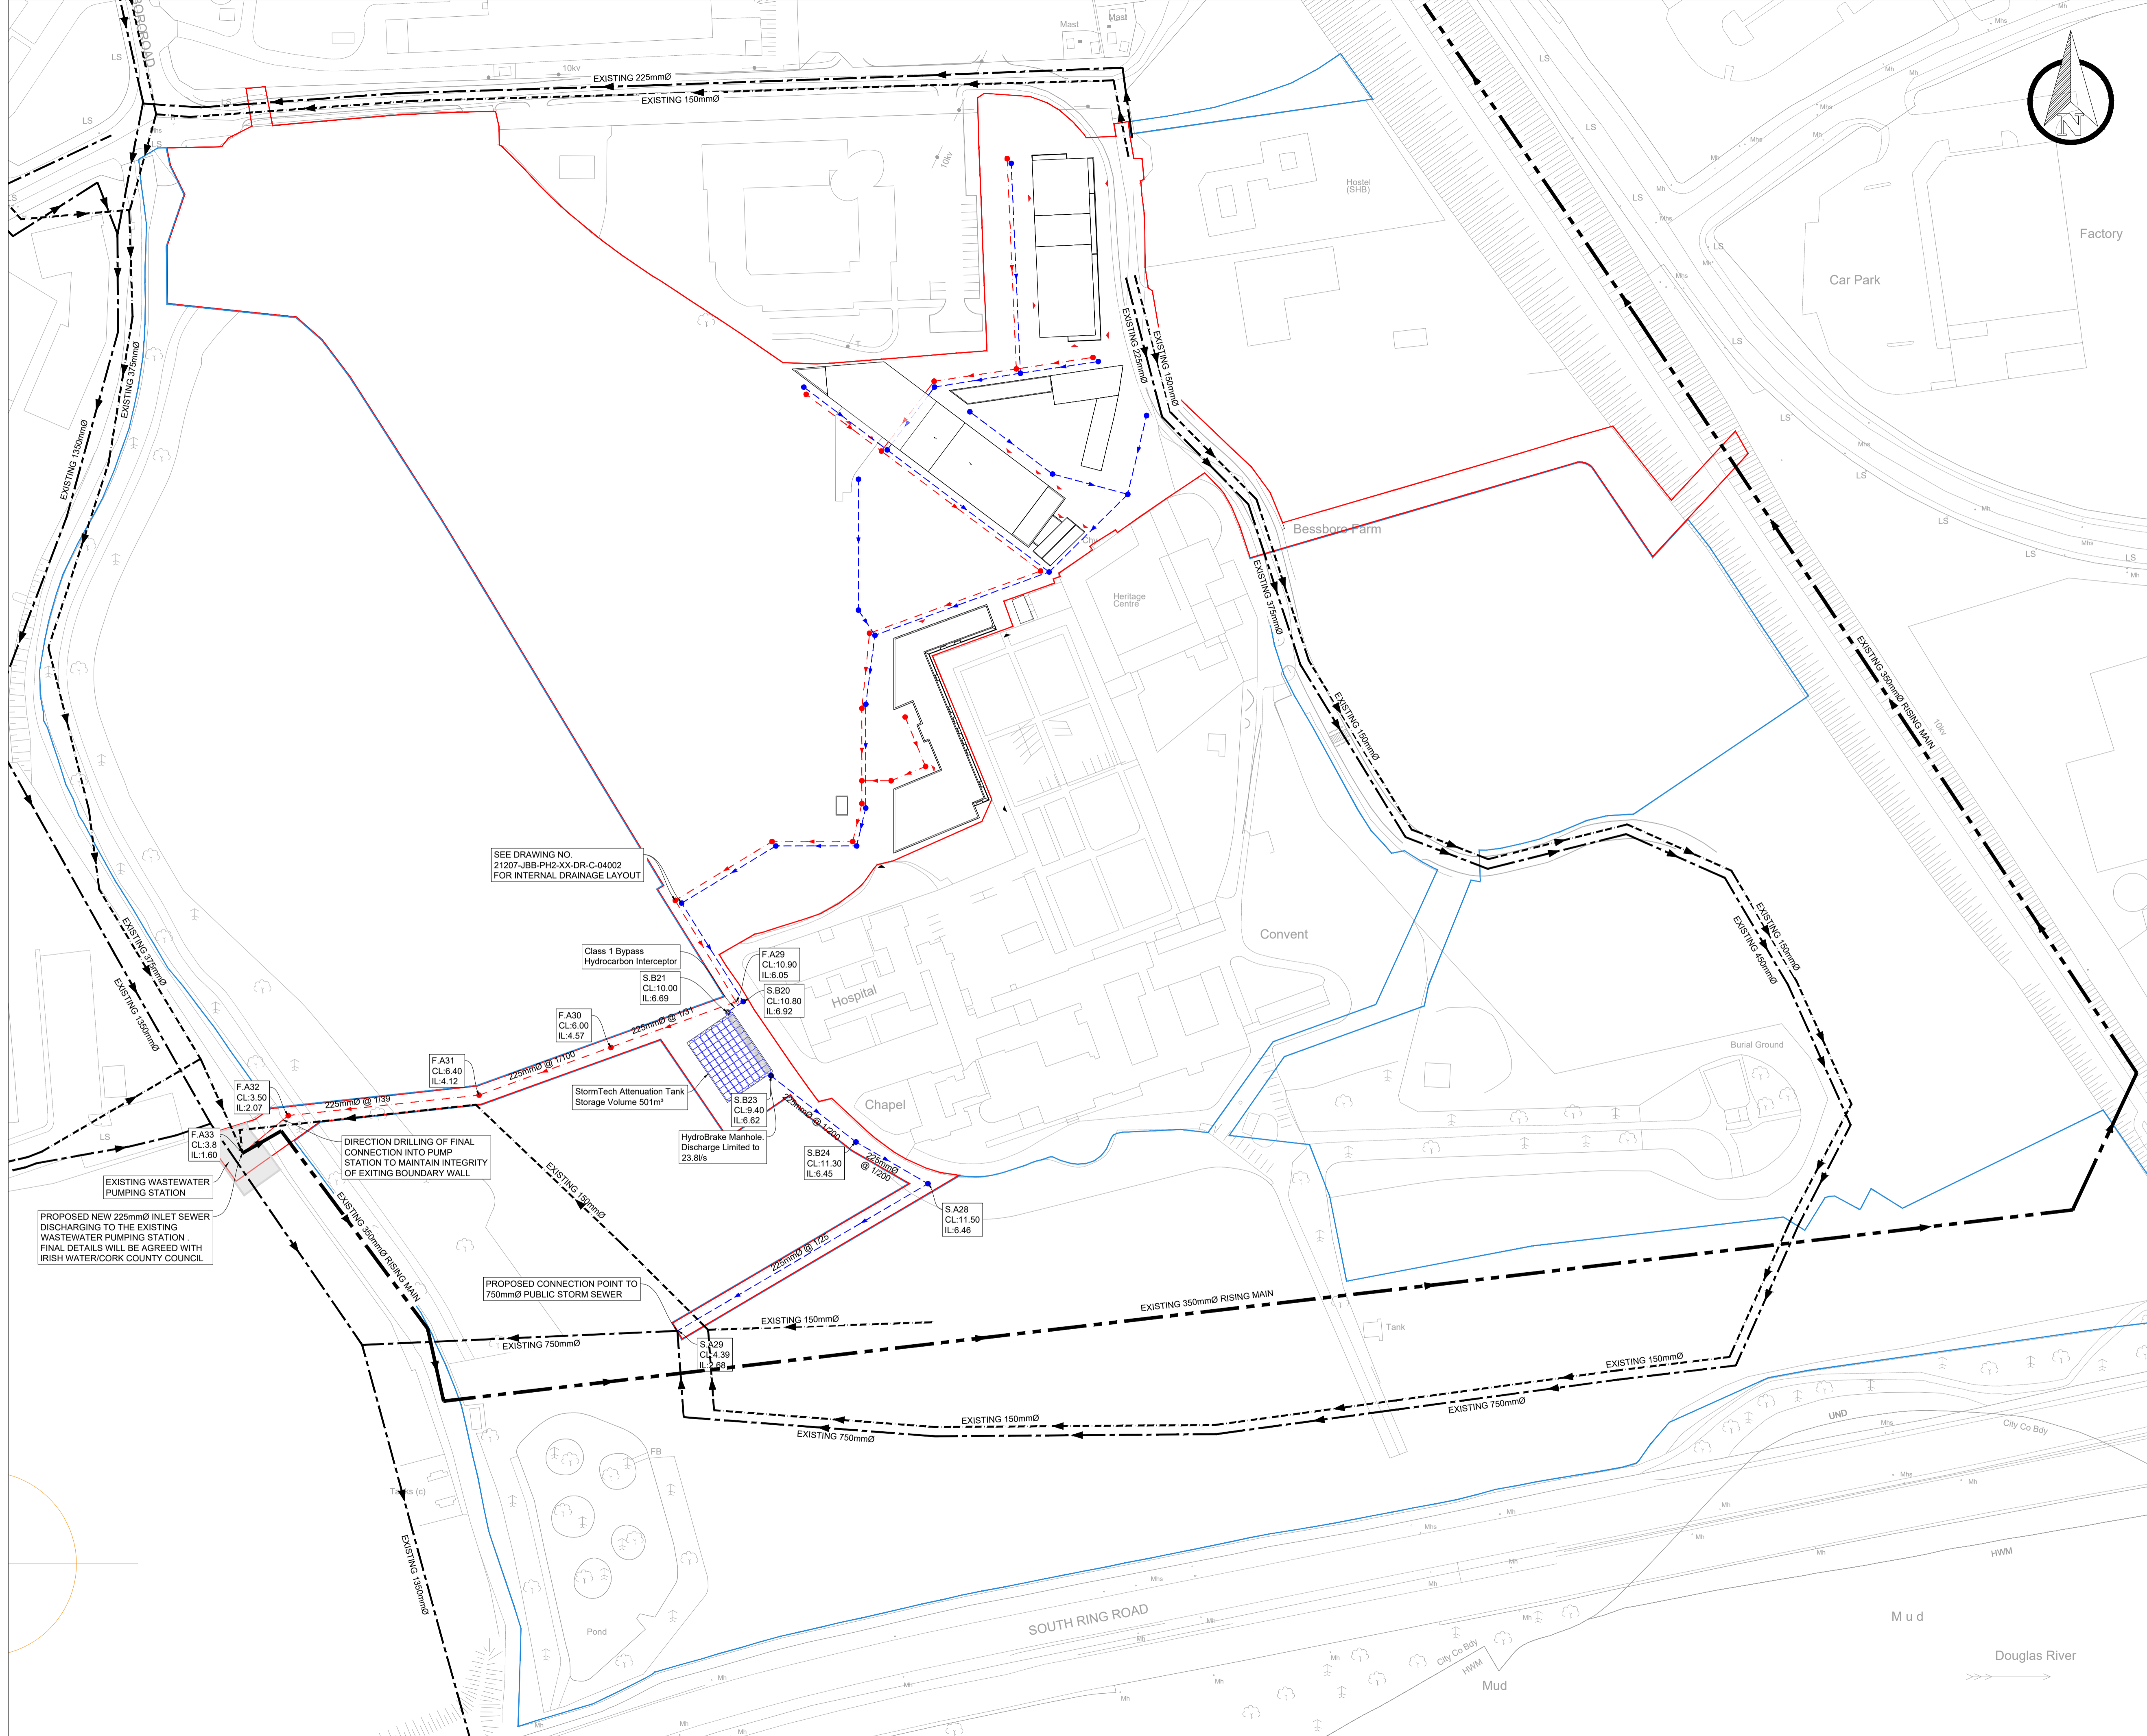


© Copyright
 This drawing and any design hereon is the copyright of the
 Consultants and must not be reproduced without their written
 consent.

All drawings remain the property of the Consultants.

LEGEND:

- Proposed Wastewater Sewer and Manhole ---
- Existing Wastewater Sewers ---
- Existing 350mmØ Rising Wastewater Sewer ---
- Proposed Stormwater Sewer and Manhole ---
- Existing Stormwater Sewers ---

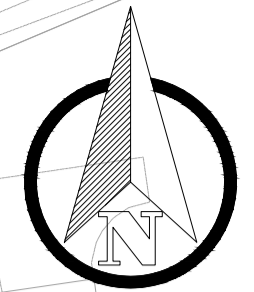

SEE DRAWING NO.
 21207-JBB-PH2-XX-DR-C-04002
 FOR INTERNAL DRAINAGE LAYOUT

F.A32
 CL.3.50
 IL.2.07

F.A31
 CL.6.40
 IL.4.12

F.A30
 CL.6.00
 IL.4.57

S.B21
 CL.10.00
 IL.6.69

S.B20
 CL.10.80
 IL.6.92

S.B23
 CL.9.40
 IL.6.62

S.B24
 CL.11.30
 IL.6.45

S.A28
 CL.11.50
 IL.6.46

S.A29
 CL.4.39
 IL.2.88

F.A33
 CL.3.39
 IL.1.60

F.A32
 CL.3.50
 IL.2.07

F.A33
 CL.3.39
 IL.1.60

PROPOSED NEW 225mmØ INLET SEWER
 DISCHARGING TO THE EXISTING
 WASTEWATER PUMPING STATION.
 FINAL DETAILS WILL BE AGREED WITH
 IRISH WATER/CORK COUNTY COUNCIL

DIRECTION DRILLING OF FINAL
 CONNECTION INTO PUMP
 STATION TO MAINTAIN INTEGRITY
 OF EXISTING BOUNDARY WALL

PROPOSED CONNECTION POINT TO
 750mmØ PUBLIC STORM SEWER

StormTech Attenuation Tank
 Storage Volume 501m³

HydroBrake Manhole,
 Discharge Limited to
 23.6l/s

Class 1 Bypass
 Hydrocarbon Interceptor

P03	S3	Issued for Planning	DOB	TF	21.02.22
P02	S3	Issued to IW for Design Approval	DOB	TF	03.02.22
P01	S3	Issued for Tripartite Meeting	DOB	TF	30.07.21
Rev.	Suit.	Description	Drawn	Chkd	Date

Client
 Estuary View Enterprises 2020 Ltd.

Client's Representative:

BARRY & PARTNERS
 consulting engineers

3 Eastgate Road, Eastgate tel +353 21 475 7800
 Business Park, Little Island, web www.jbbarry.ie
 Co. Cork, Ireland email cork@jbbarry.ie

Project
 BESSBOROUGH SHD DEVELOPMENT

Drawing Title
 PROPOSED DRAINAGE
 CONNECTION LOCATIONS

Drawn by:	DOB	Date:	29.07.21
Checked by:	RS	Date:	29.07.21
Approved by:	TF	Date:	29.07.21
Internal Project REF:	JBB: 21207		
Scales:	1:1000 @ A1		
Stage:	PLANNING		
Drawing No.:	21207-JBB-PH2-XX-DR-C-04006	Revision	P03
		Suitability Code	S3