
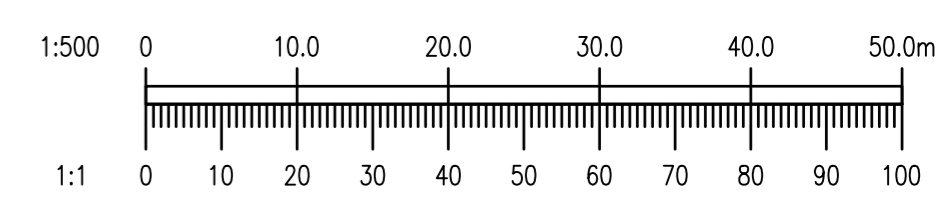


- NOTES:
- DO NOT SCALE. USE FIGURED DIMENSIONS ONLY.
 - THIS DRAWING IS TO BE READ IN CONJUNCTION WITH ALL OTHER RELEVANT ARCHITECTURAL AND ENGINEERING DRAWINGS.

LEGEND:

- EXF CL X IL X: EXISTING FOUL WATER SEWER WITH PIPE SIZE, GRADE, MANHOLE REF. AND INVERT LEVEL
- EXS CL X IL X: EXISTING SURFACE WATER SEWER WITH PIPE SIZE, GRADE, MANHOLE REF. AND INVERT LEVEL
- FX CL X IL X: PROPOSED FOUL WATER SEWER WITH PIPE SIZE, GRADE, MANHOLE REF. AND INVERT LEVEL
- SX CL X IL X: PROPOSED SURFACE WATER SEWER WITH PIPE SIZE, GRADE, MANHOLE REF. AND INVERT LEVEL
- Proposed Foul Inspection Chamber and Connection
- Proposed Surface Water Inspection Chamber and Connection
- Proposed Gully and Connection
- Proposed Underground Attenuation Storage
- Proposed Swale and Open Grated Manhole

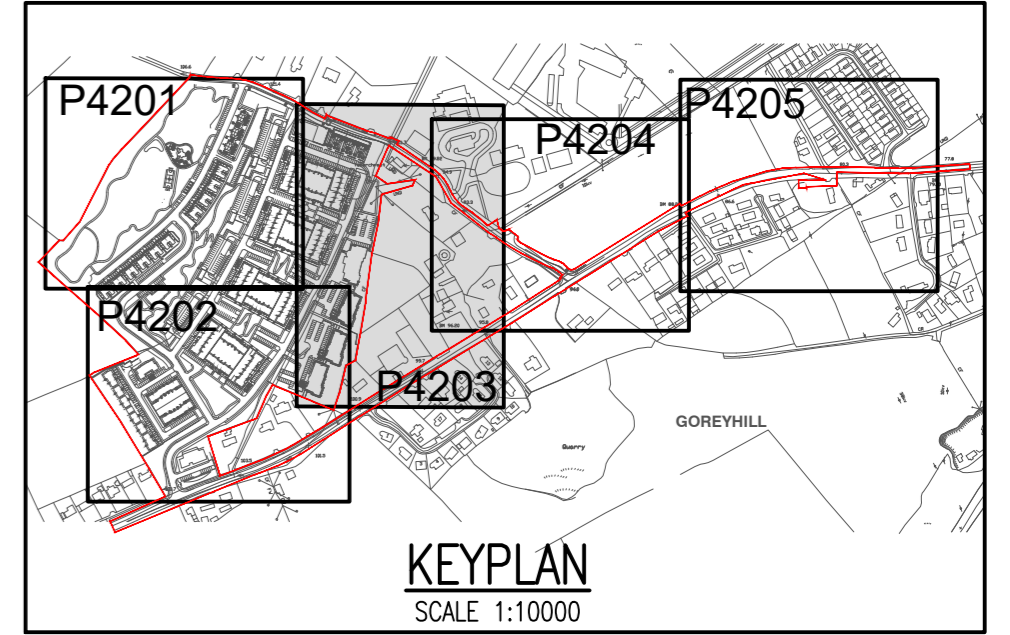

Ordnance Survey
Ordnance Survey Ireland Licence No. EN 0006022 © Ordnance Survey Ireland/Government of Ireland.

REV.	DATE	AMENDMENT	DRN	APPD

STATUS FOR PLANNING ONLY
NOT FOR CONSTRUCTION

Waterman Moylan
Engineering Consultants
BLOCK 5, EASTPOINT BUSINESS PARK, ALFIE BYRNE ROAD, DUBLIN D03 H3F4 IRELAND.
Tel: (01) 664 8900 Fax: (01) 661 3618
Email: info@waterman-moylan.ie www.waterman-moylan.ie

CLIENT GERARD GANNON PROPERTIES
ARCHITECT CONNOLLY ARCHITECTS
PROJECT LANDS AT KILNAHUE & GOREY HILL, GOREY
TITLE PROPOSED DRAINAGE LAYOUT SHEET 3 OF 5

DRAWN PJD	DESIGNED PJD	APPROVED MD	DATE MARCH 2022
SCALE 1:500 @ A1	JOB NO. 13-119	DRG. NO. P4203	REVISION

© 2018. This drawing is copyright. No part of this document may be reproduced or transmitted in any form or stored in any retrieval system of any nature without the written permission of the consulting engineer. No copyright notice is required for use on the project for which the document was originally issued.