



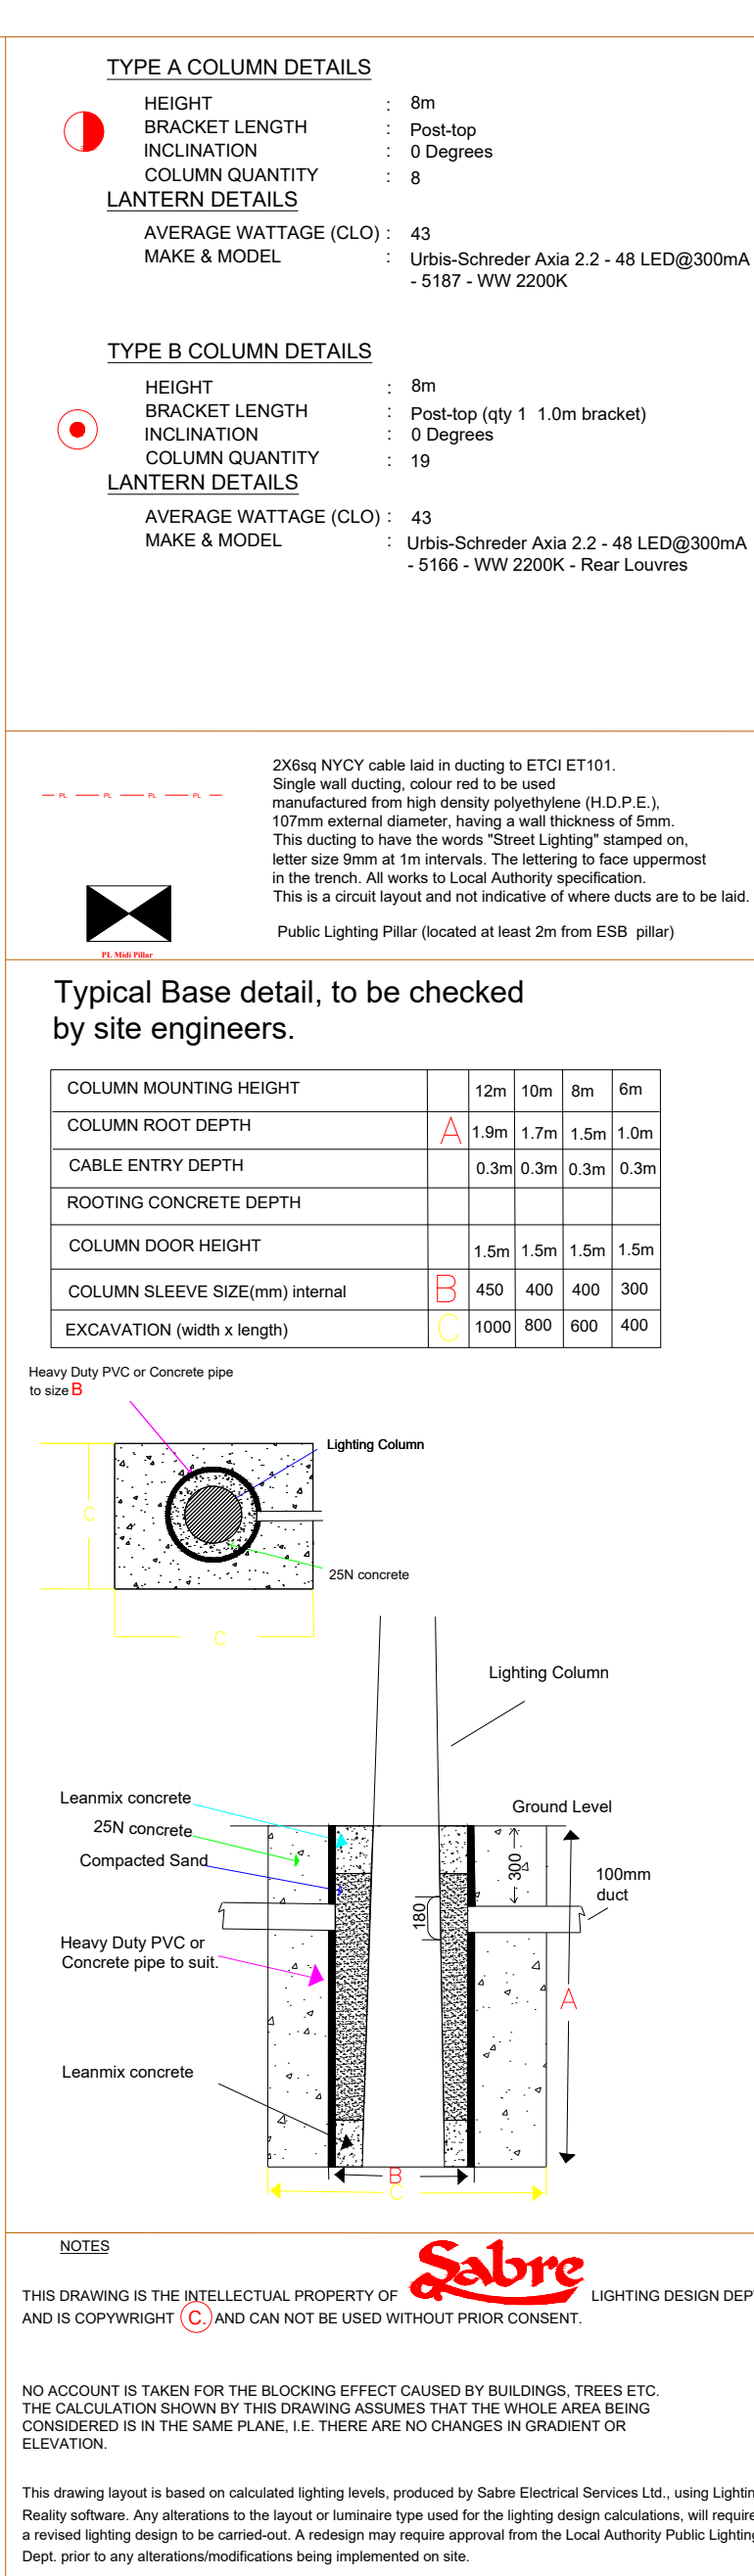

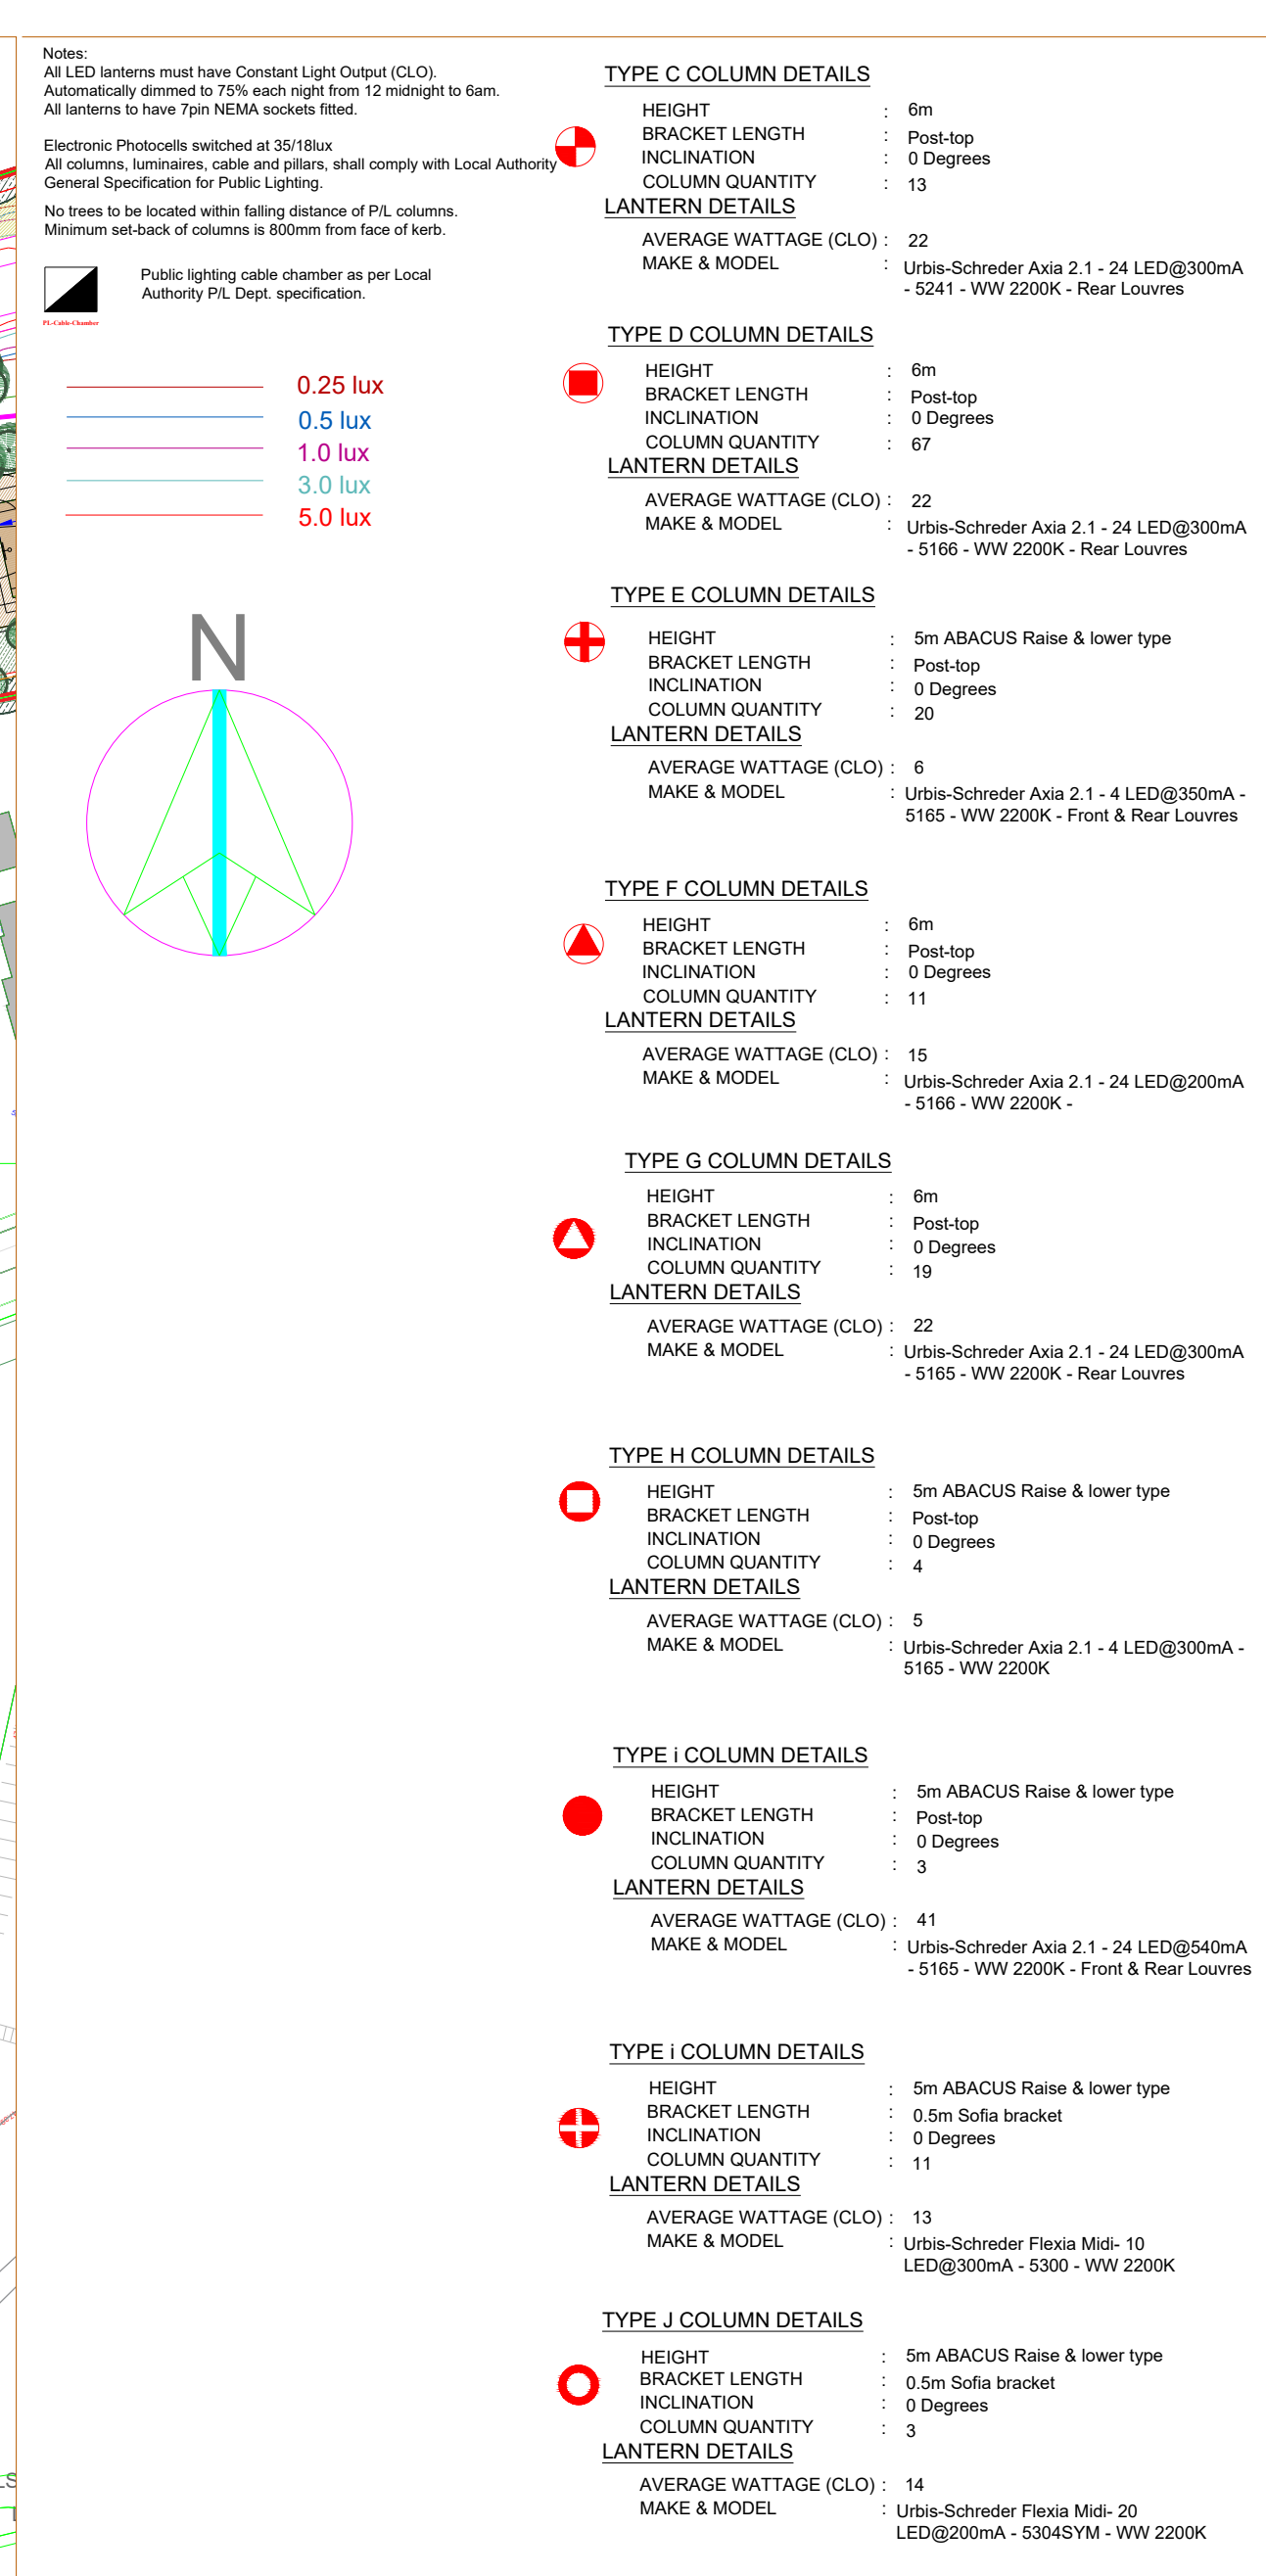

Sabre

ELECTRICAL SERVICES LTD.

Specialist Contractors

PUBLIC LIGHTING - FLOOD LIGHTING - SPORTS LIGHTING

UNIT 11,
BELLVUE INDUSTRIAL ESTATE,
FINGLAS,
DUBLIN 11.
E - MAIL: graham@sabrelighting.ie

PH: 01-811 0875

+	?	GS	CHK	-----
-	?	GS	CHK	-----
.	?	GS	CHK	-----
D	Updated as per comments	AN	CHK	15-03-22
C	Updated site layout	AN	CHK	23-02-22
B	Updated site layout	AN	CHK	-----
A	Updated Site layout	AN	CHK	09-02-22
REV	DESCRIPTION	INITS	CHKD	DATE

CLIENT/CUSTOMER

Cairn Homes Properties Ltd

PROJECT

Coolagad

TITLE

Public Lighting Layout

DRAWN A.N	SCALE 1:1000 @A1	DATE 26-01-22
DRAWING NUMBER SES 17121 Sheet 1	ISSUE 5	

BASE DRAWING NUMBER

20005 - PL03-PL08 Site Plan.dwg

DRAWING ORIGIN

DO NOT SCALE FROM THIS DRAWING