
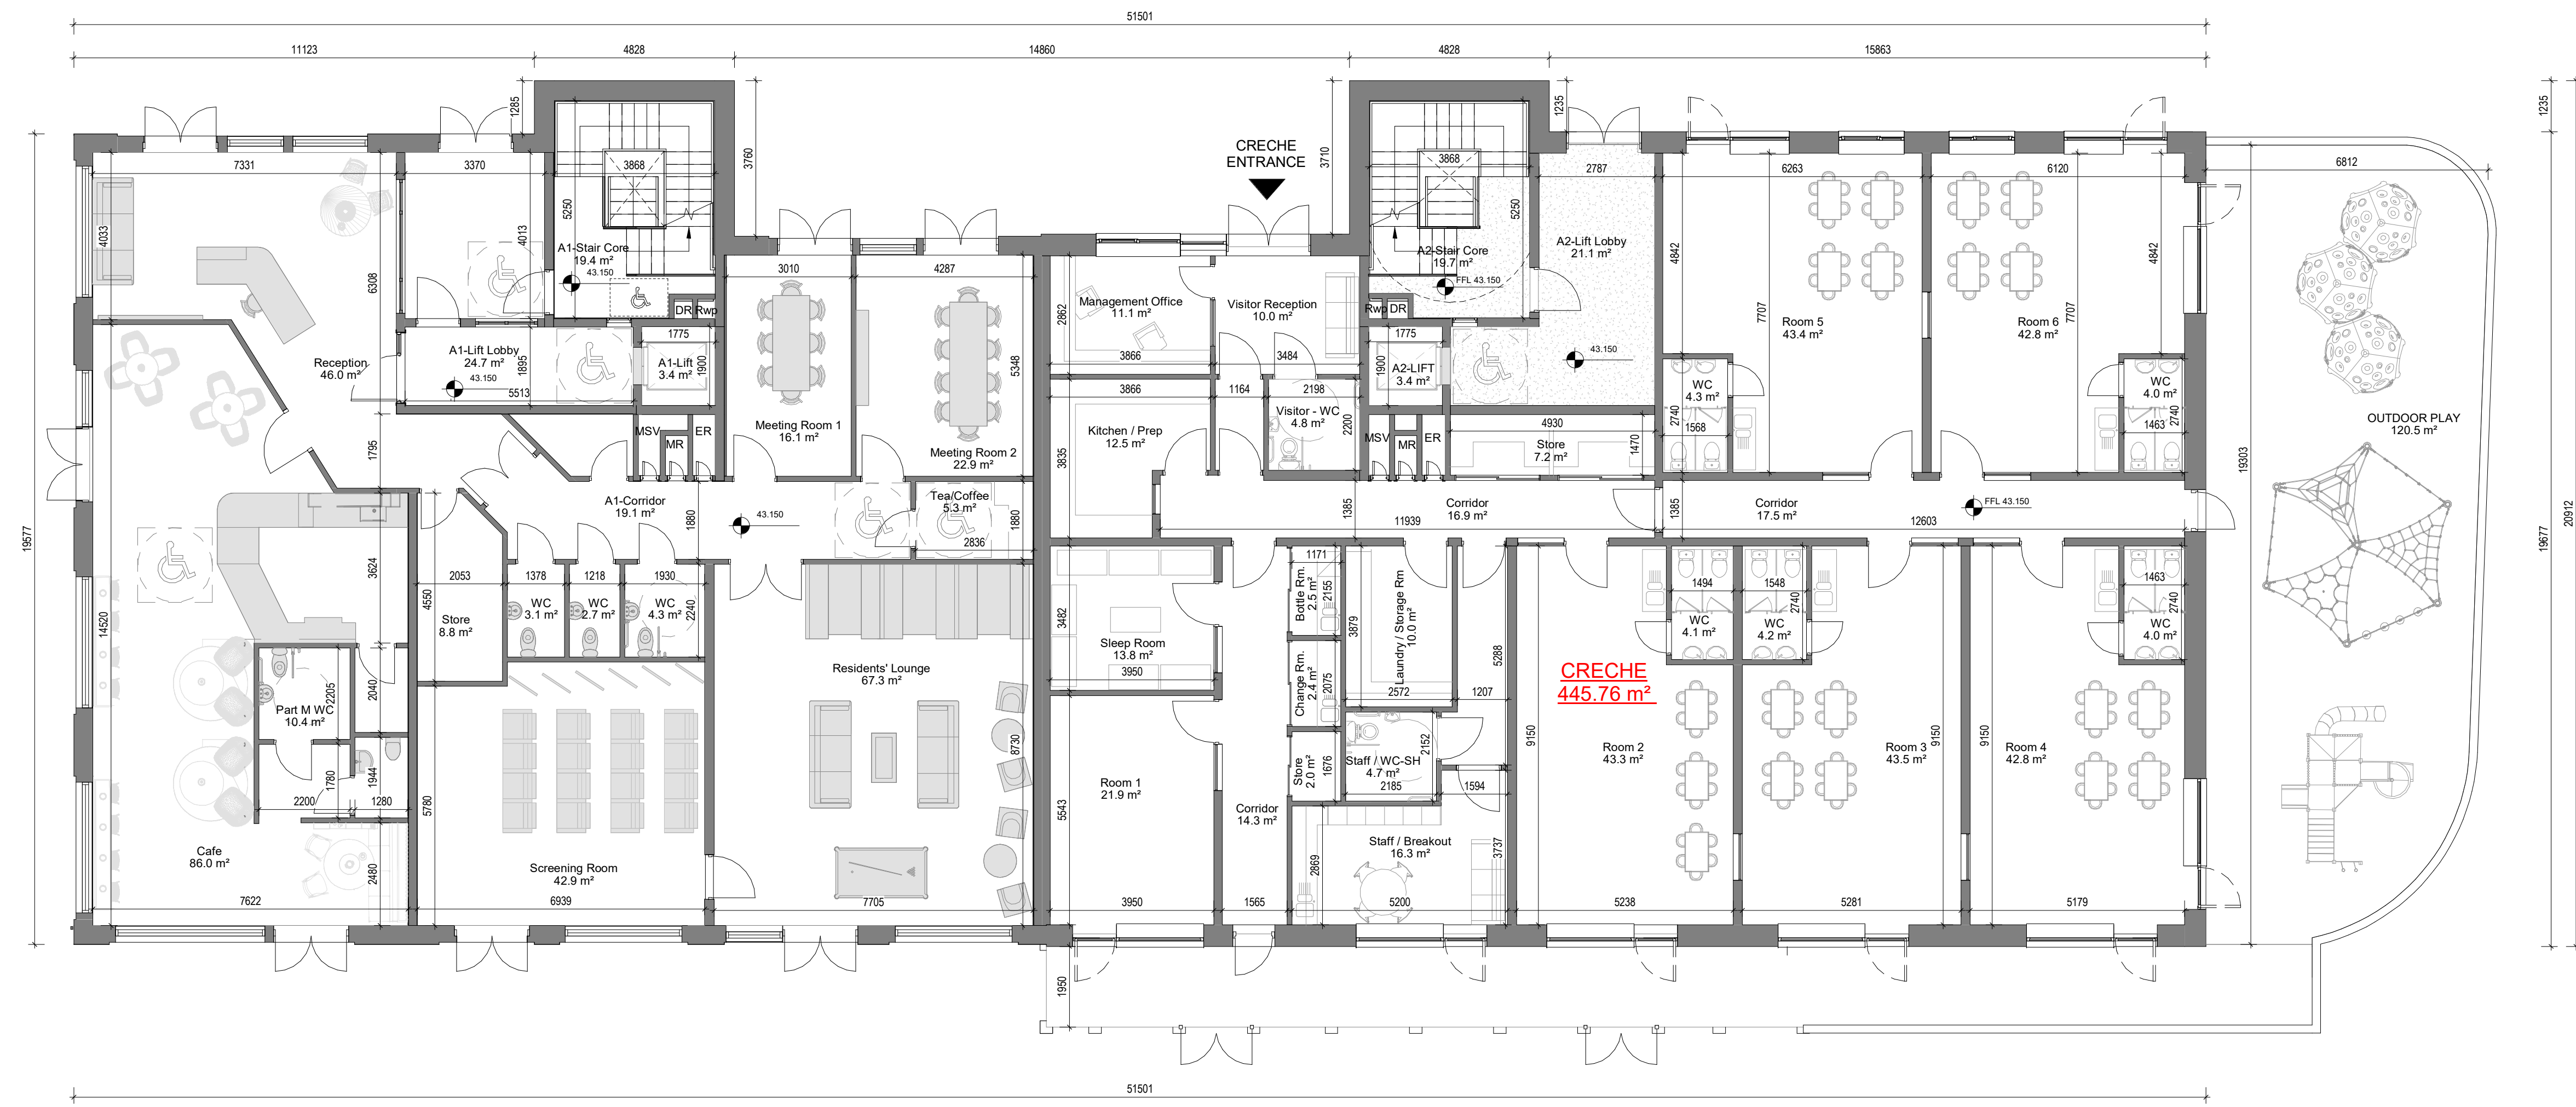


DESIGN INTENT DRAWING

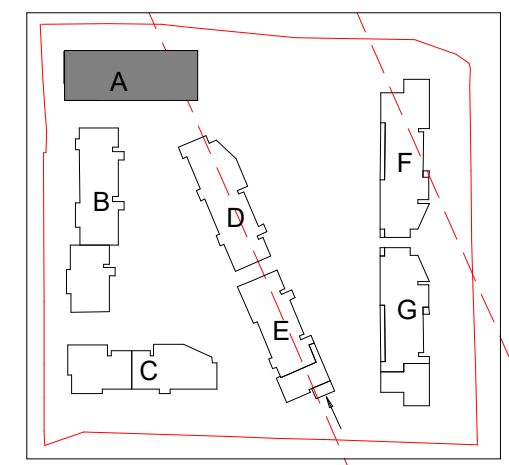

- Room Legend**
- EH/C Entrance Hall / Corridor
 - KLD Kitchen / Living / Dining Room
 - BD1 Bedroom 1
 - BD2 Bedroom 2
 - BD3 Bedroom 3
 - BR Bathroom
 - BR/ES Bathroom / En Suite
 - ES En Suite
 - ST Store
 - POS Private Open Space
 - ER Electrical Riser
 - MR Mechanical Riser
 - MSV Mechanical Smoke Vent

1 GA - Ground Floor Plan
1 : 100

Rev	Description	Date	Dr by	App by
Project Stage				

PLANNING

Client:
Eastwise Construction Swords Limited

Project:
Hartfield Place
Swords Road, Whitehall, Dublin 9
D09 C7F8

Drawing Title:
BLOCK A - Ground Floor GA - 472 Units

Drawn	Checked	Paper Size	Scale	Date
DP	CM	A1	1 : 100 @A1	Mar. 2022
Project No.	Drawing No.	Classification	Revision	
HARTPL	012500			

File Name:
HARTPL-CWO-BA-00-DR-A-012500

Status:
S2-Suitable For Information



No.1 Sarsfield Quay, Dublin 7, D07 R9FH
t: 01 518 0170 e: admin@cwoarchitects.ie
Dublin | Cork | Galway | London | UK & Europe +
www.cwoarchitects.ie

Please consider the environment before printing this sheet