
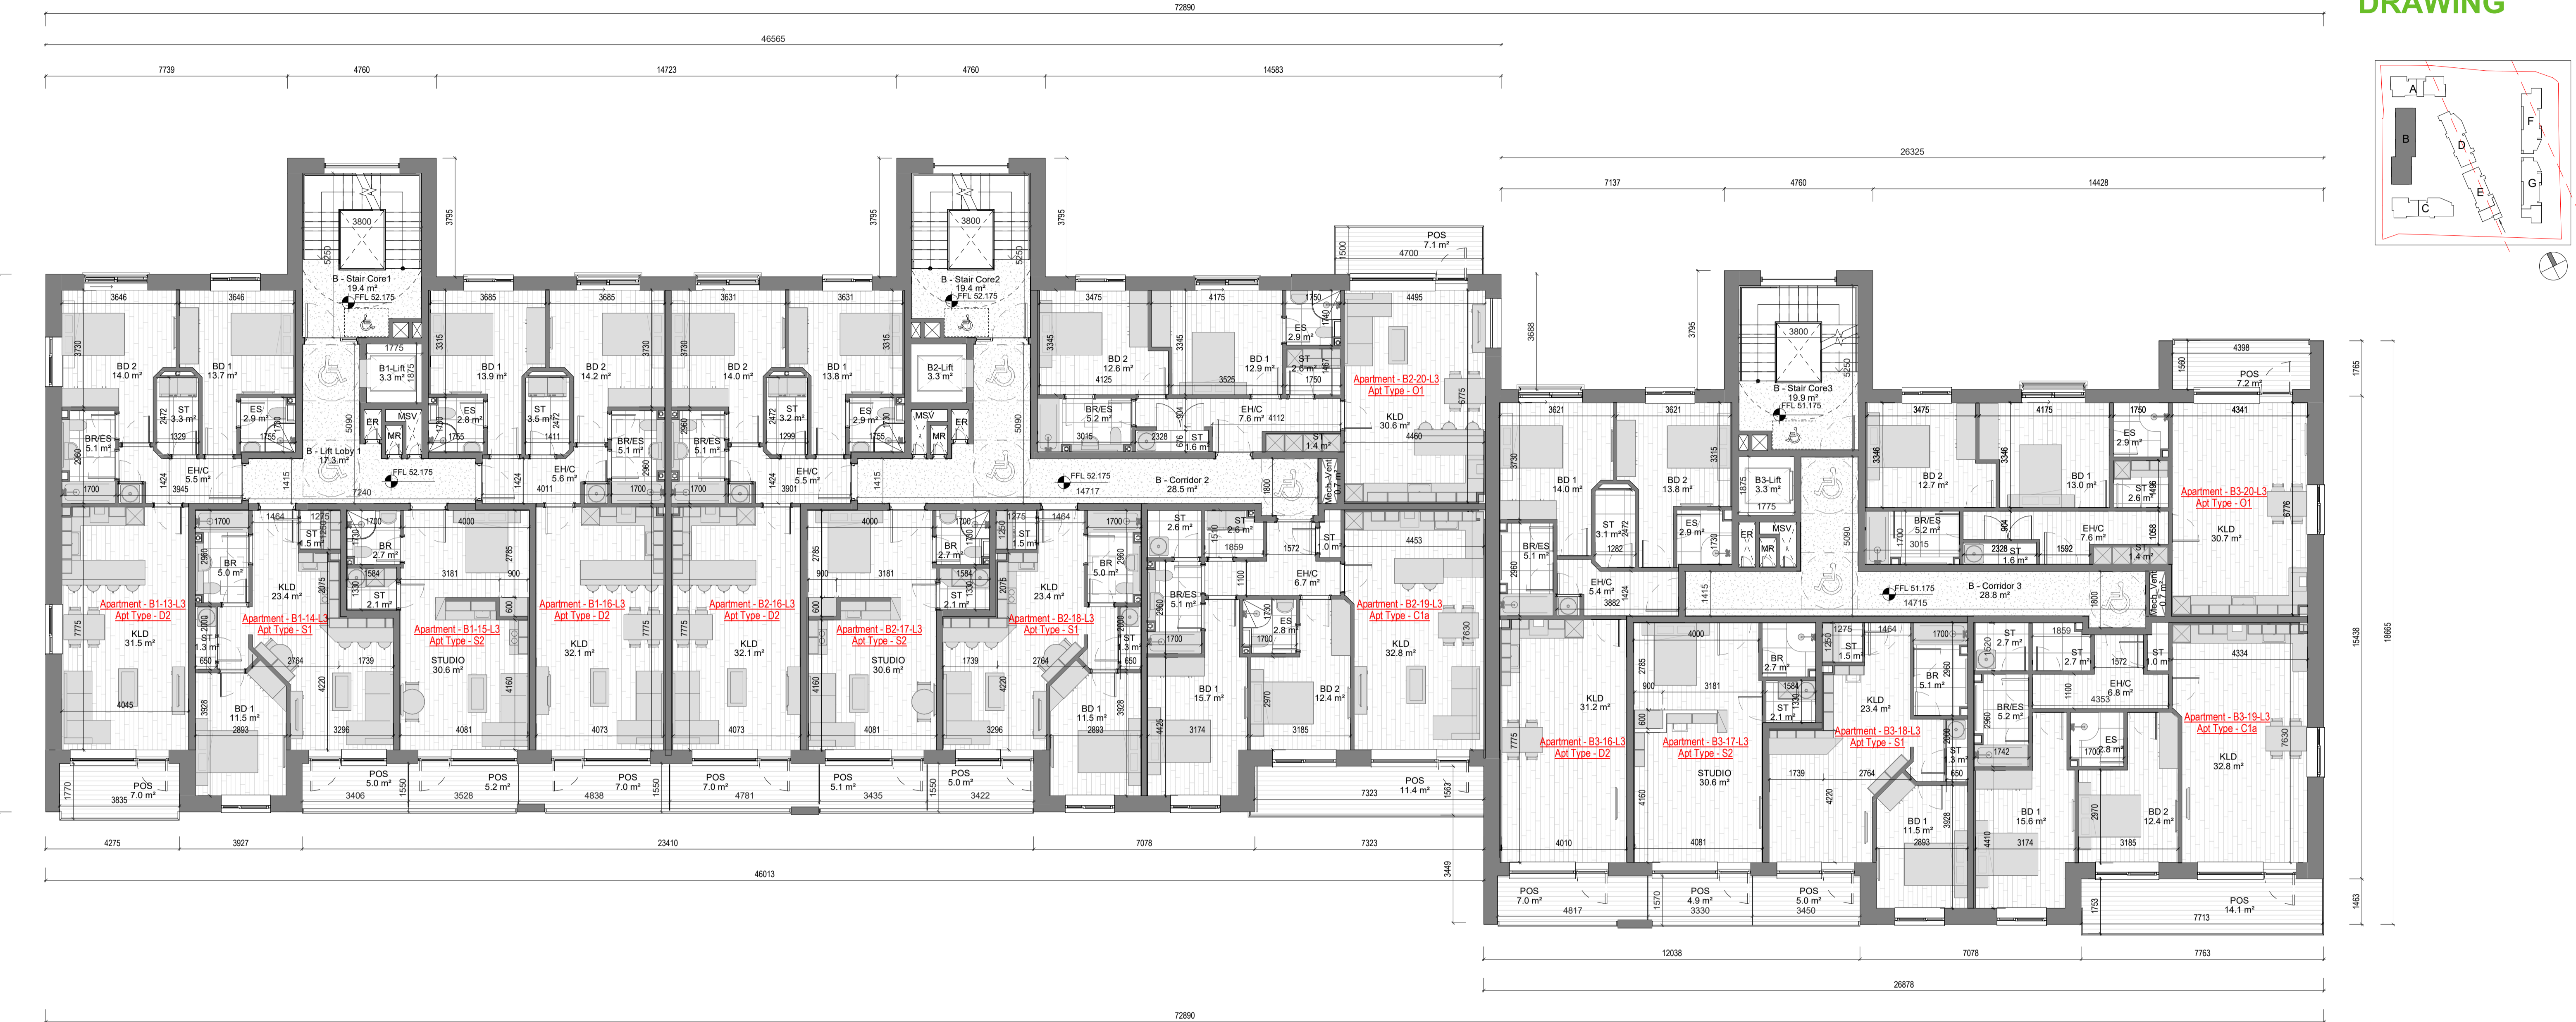


# DESIGN INTENT DRAWING

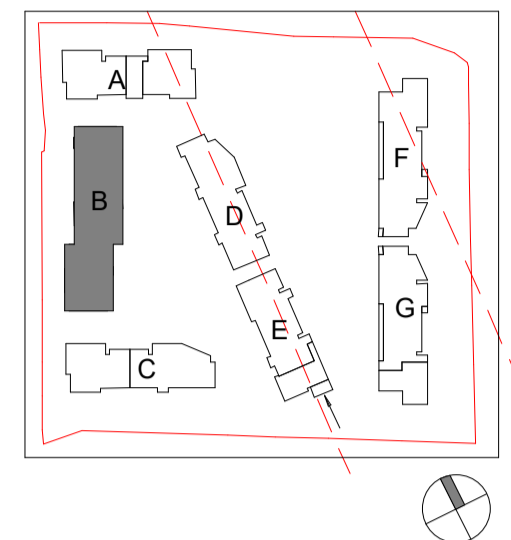

1 GA - Third Floor Plan  
1 : 100

**Room Legend**

EH/C	Entrance Hall / Corridor
KLD	Kitchen / Living / Dining Room
BD1	Bedroom 1
BD2	Bedroom 2
BD3	Bedroom 3
BR	Bathroom
BR/ES	Bathroom / En Suite
ES	En Suite
ST	Store
POS	Private Open Space
ER	Electrical Riser
MR	Mechanical Riser
MSV	Mechanical Smoke Vent

Rev	Description	Date	Dr by	App by
	Project Stage			

## PLANNING

Client:  
Eastwise Construction Swords Limited

Project:  
Hartfield Place  
Swords Road, Whitehall, Dublin 9  
D09 C7F8

Drawing Title:  
BLOCK B - Third Floor GA - 472 Units

Drawn	Checked	Paper Size	Scale	Date
DP	CM	A1	1 : 100 @A1	Mar. 2022

Project No. HARTPL  
Drawing No. 022503  
Classification  
Revision

File Name  
HARTPL-CWO-BB-03-DR-A-022503

Status:  
S2-Suitable For Information

