
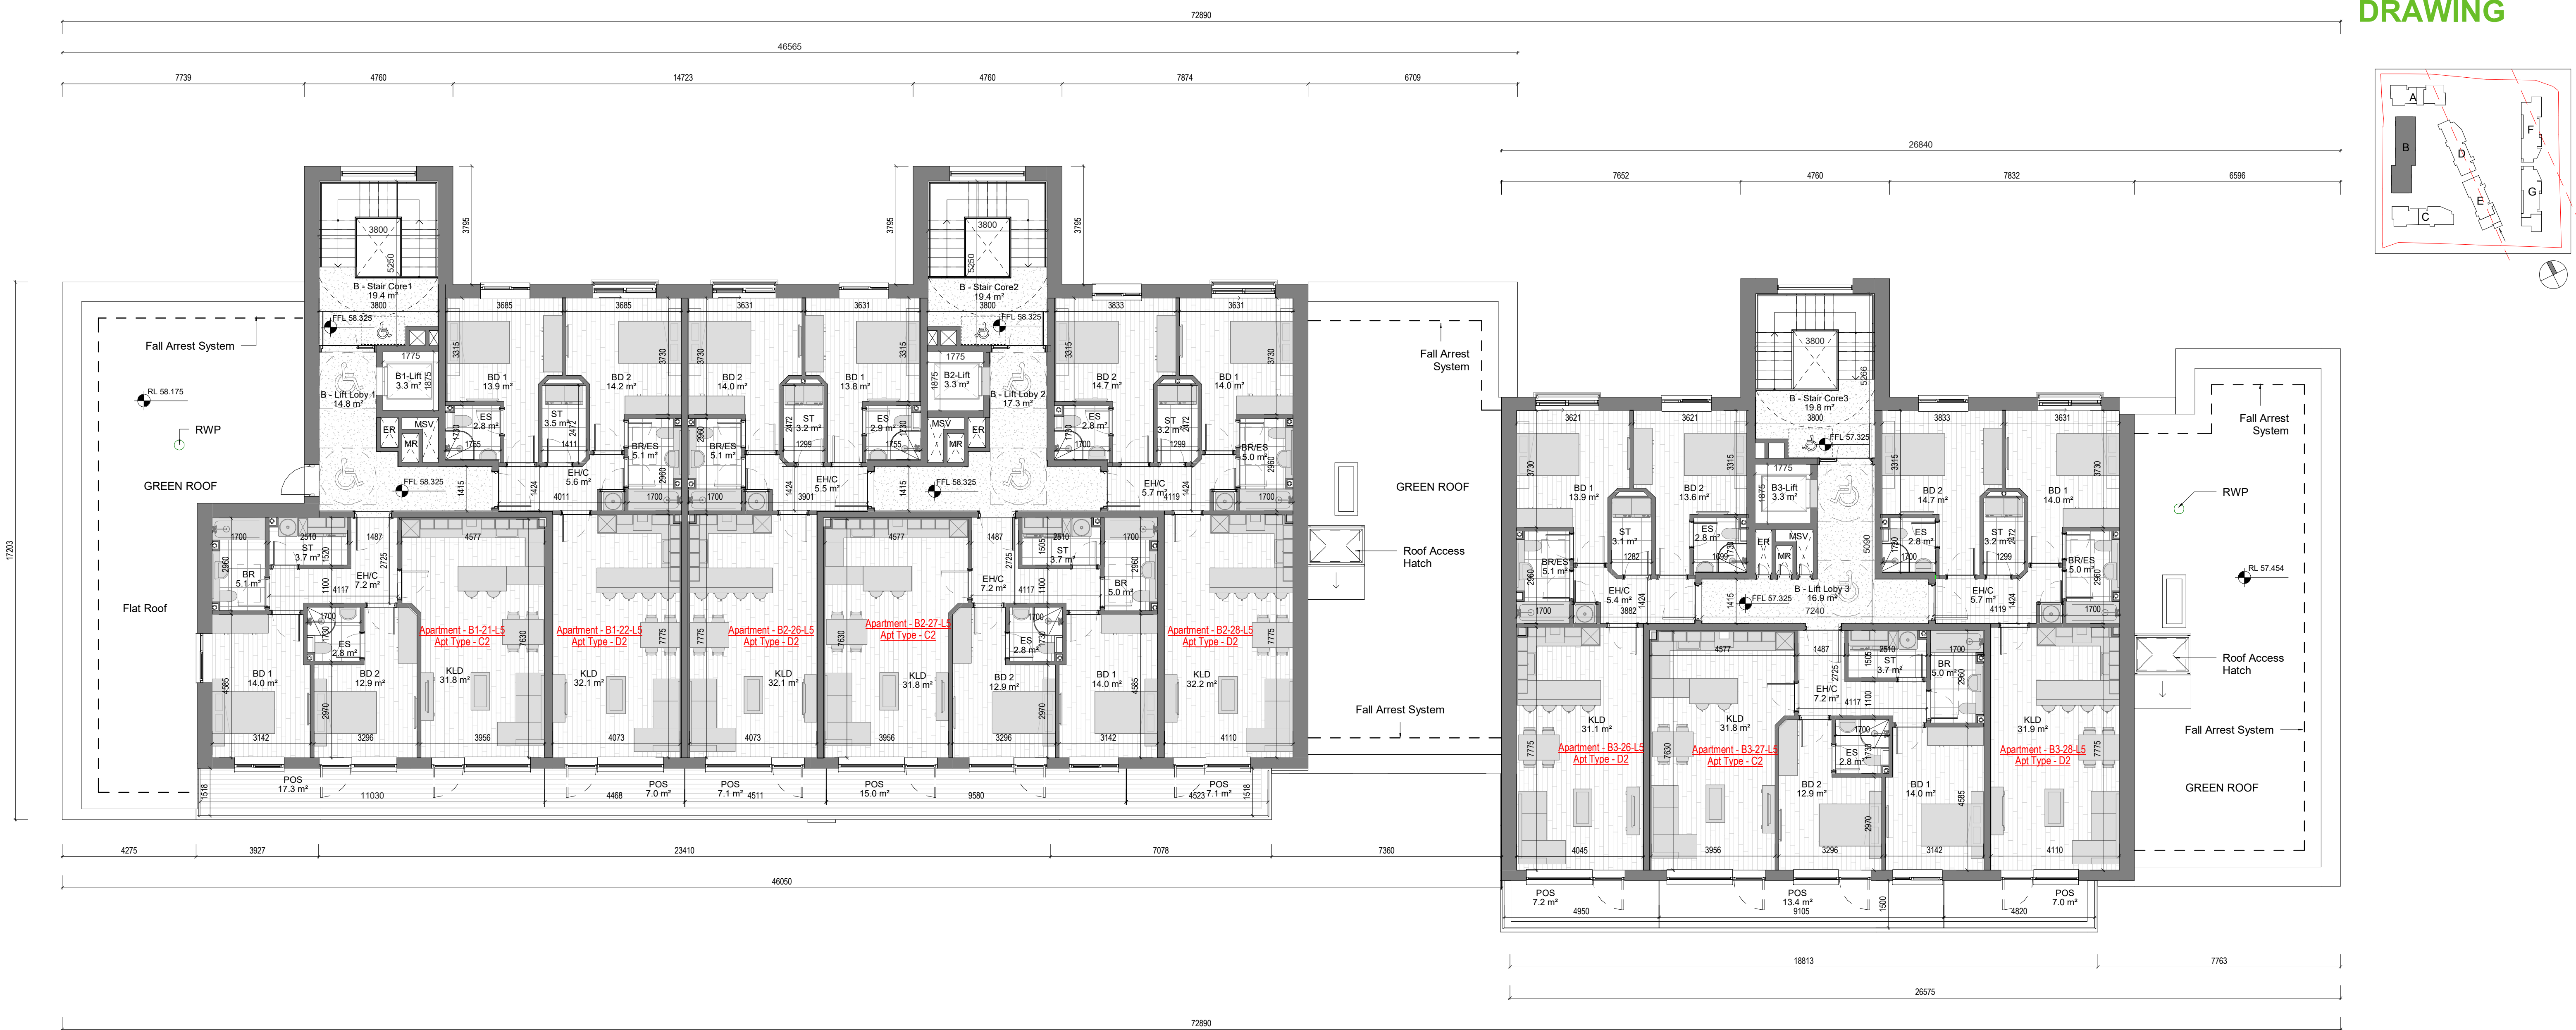


DESIGN INTENT DRAWING

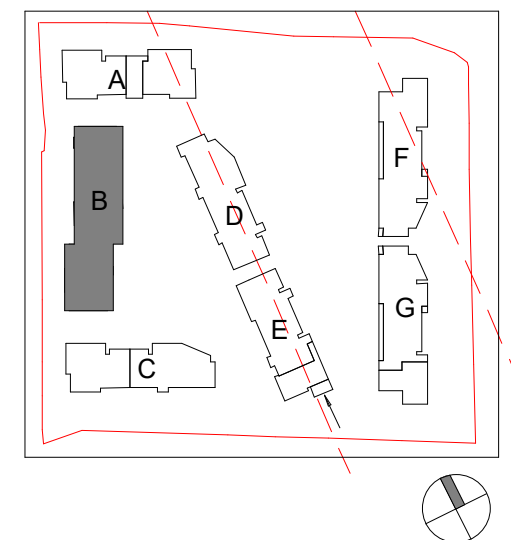

1 GA - Fifth Floor Plan
1 : 100

Room Legend

| | |
|-------|--------------------------------|
| EH/C | Entrance Hall / Corridor |
| KLD | Kitchen / Living / Dining Room |
| BD1 | Bedroom 1 |
| BD2 | Bedroom 2 |
| BD3 | Bedroom 3 |
| BR | Bathroom |
| BR/ES | Bathroom / En Suite |
| ES | En Suite |
| ST | Store |
| POS | Private Open Space |
| ER | Electrical Riser |
| MR | Mechanical Riser |
| MSV | Mechanical Smoke Vent |

| Rev | Description | Date | Dr by | App by |
|-----|-------------|------|-------|--------|
| | | | | |

PLANNING

Client:
Eastwise Construction Swords Limited

Project:
Hartfield Place
Swords Road, Whitehall, Dublin 9
D09 C7F8

Drawing Title:
BLOCK B - Fifth Floor GA - 472 Units

| Drawn | Checked | Paper Size | Scale | Date |
|-------|---------|------------|-------------|-----------|
| DP | CM | A1 | 1 : 100 @A1 | Mar. 2022 |

Project No. HARTPL
Drawing No. 022505
Classification
Revision

File Name:
HARTPL-CWO-BB-05-DR-A-022505

Status:
S2-Suitable For Information

