



DESIGN INTENT DRAWING

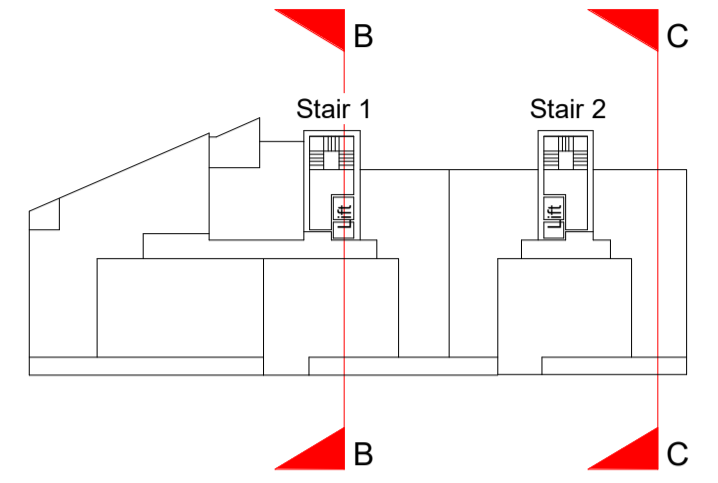


Key Plan (NTS)

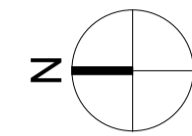


Room Legend

- EH/C Entrance Hall / Corridor
- KLD Kitchen / Living / Dining Room
- BD1 Bedroom 1
- BD2 Bedroom 2
- BD3 Bedroom 3
- BR Bathroom
- BR/ES Bathroom / En Suite
- ES En Suite
- ST Store
- POS Private Open Space

- ER Electrical Riser
- MR Mechanical Riser
- MSV Mechanical Smoke Vent

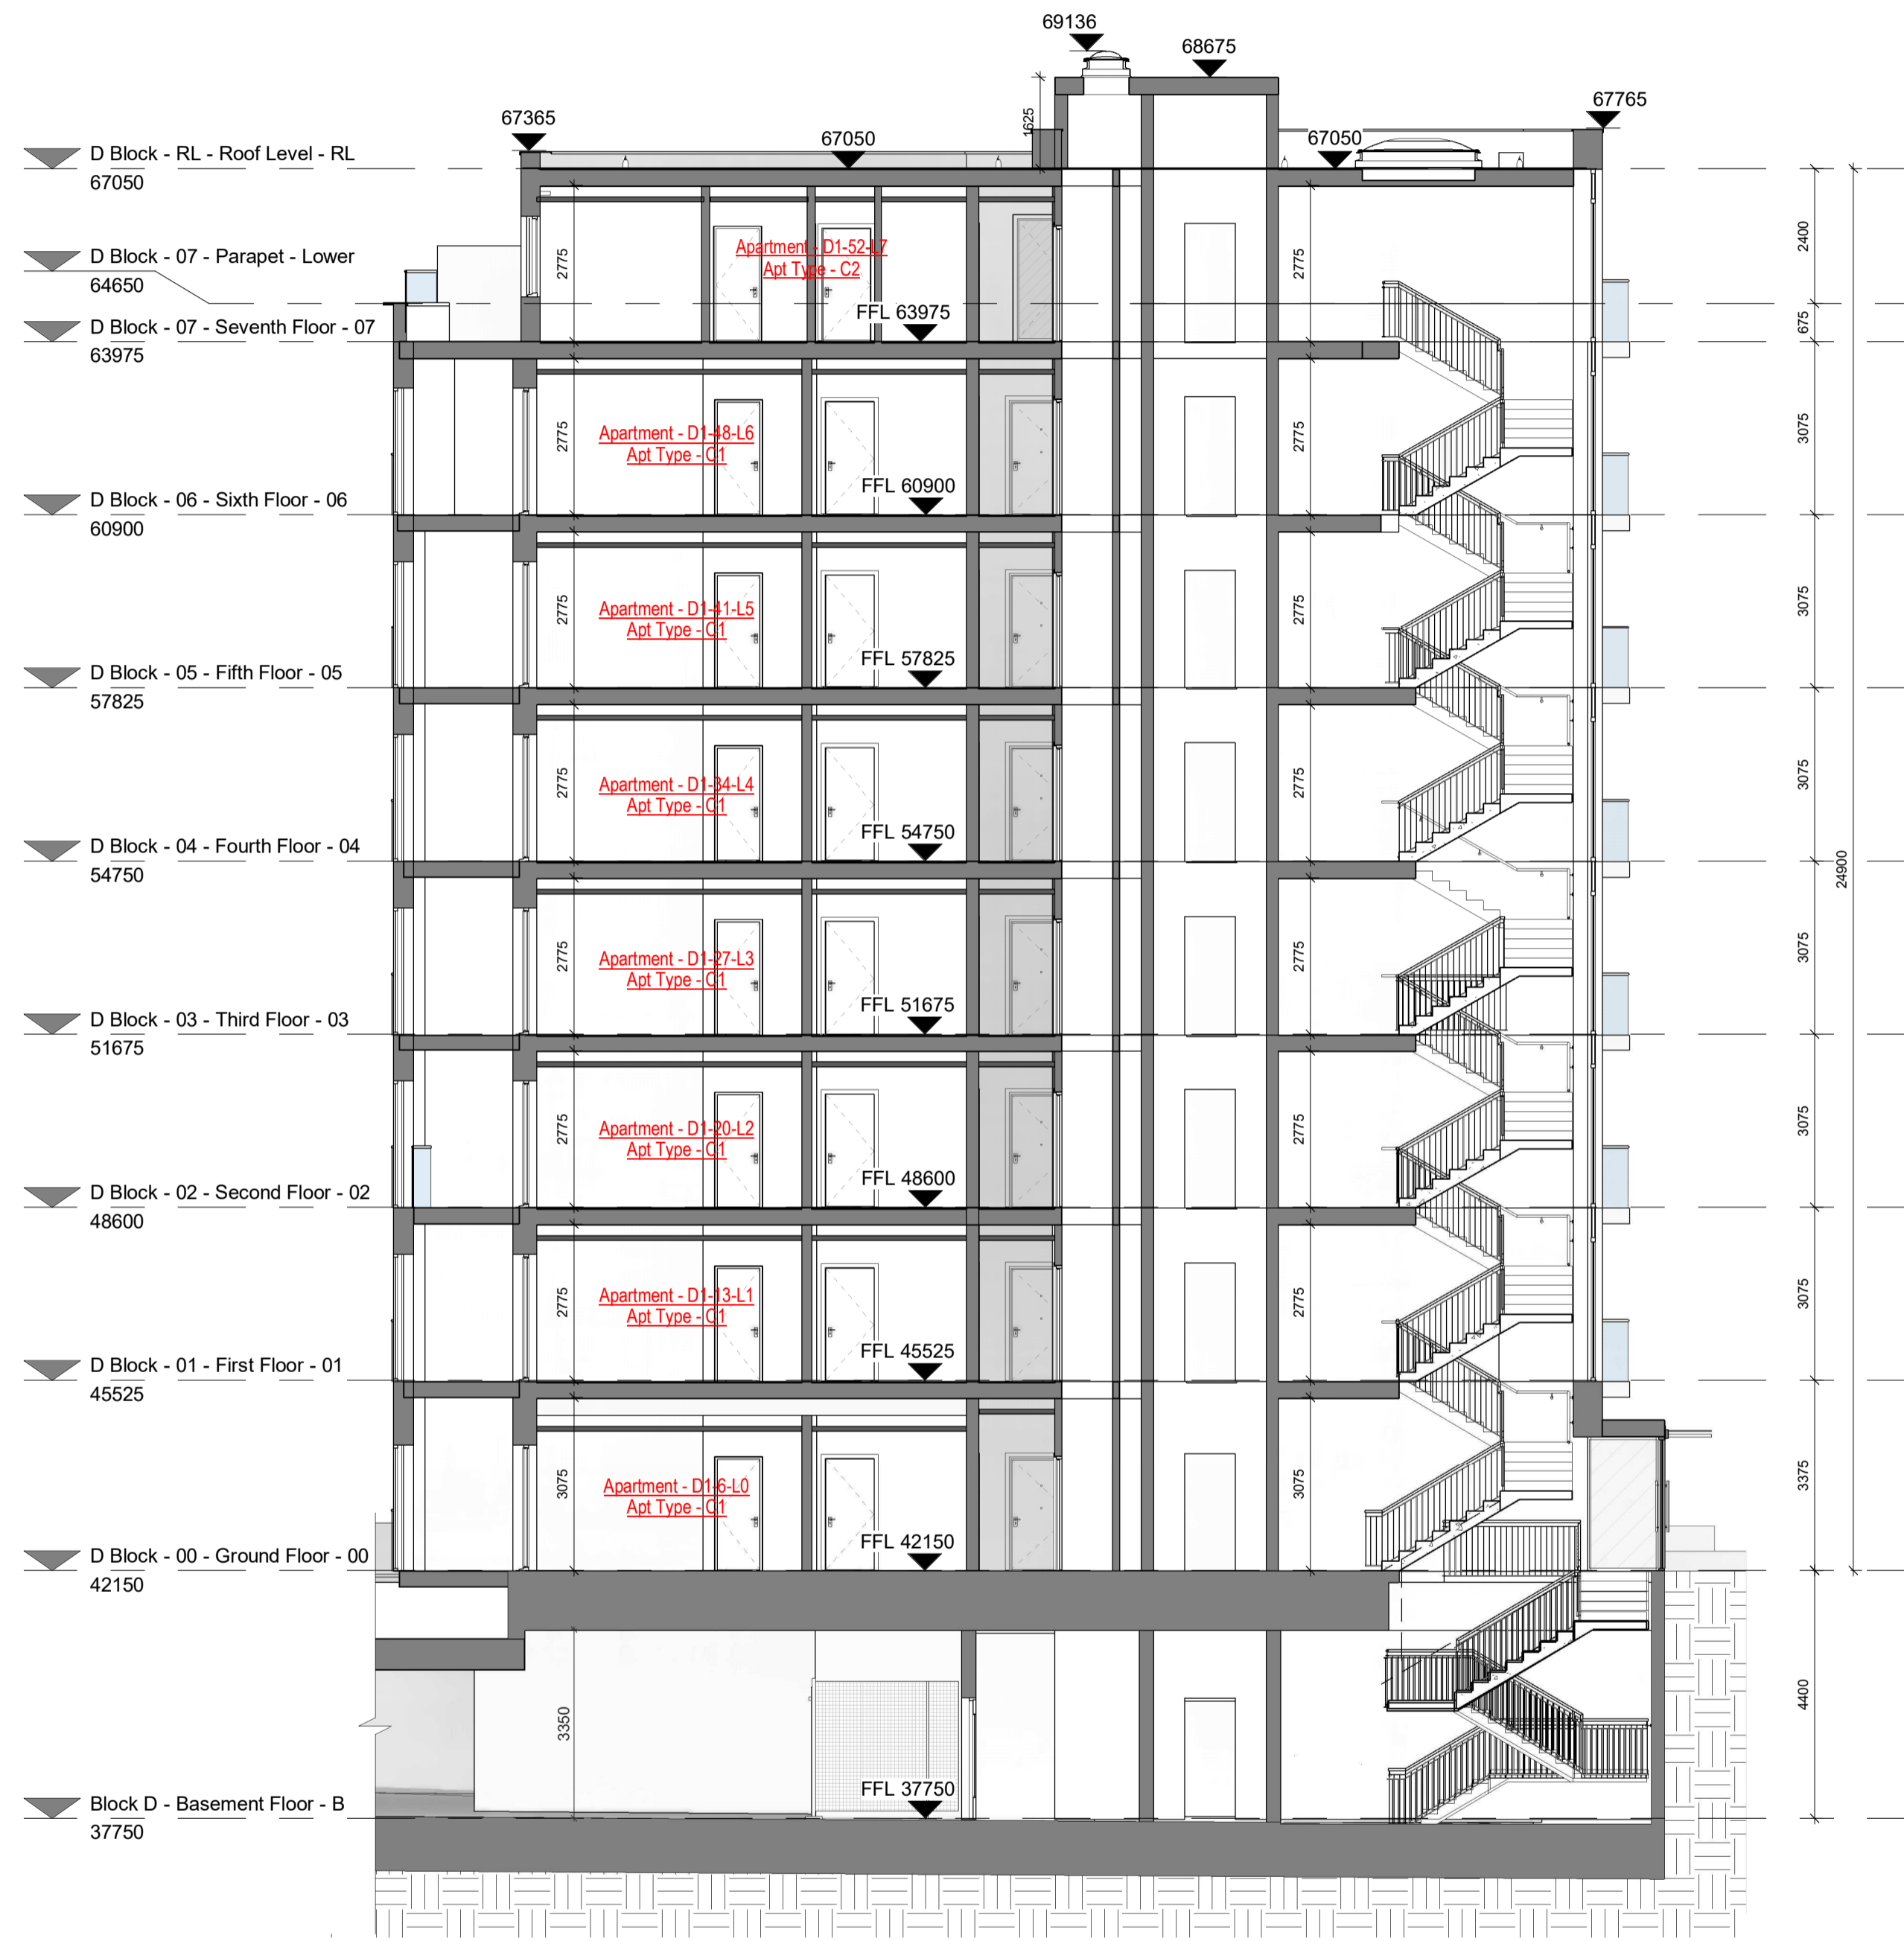

1 GA - Section BB
1 : 100

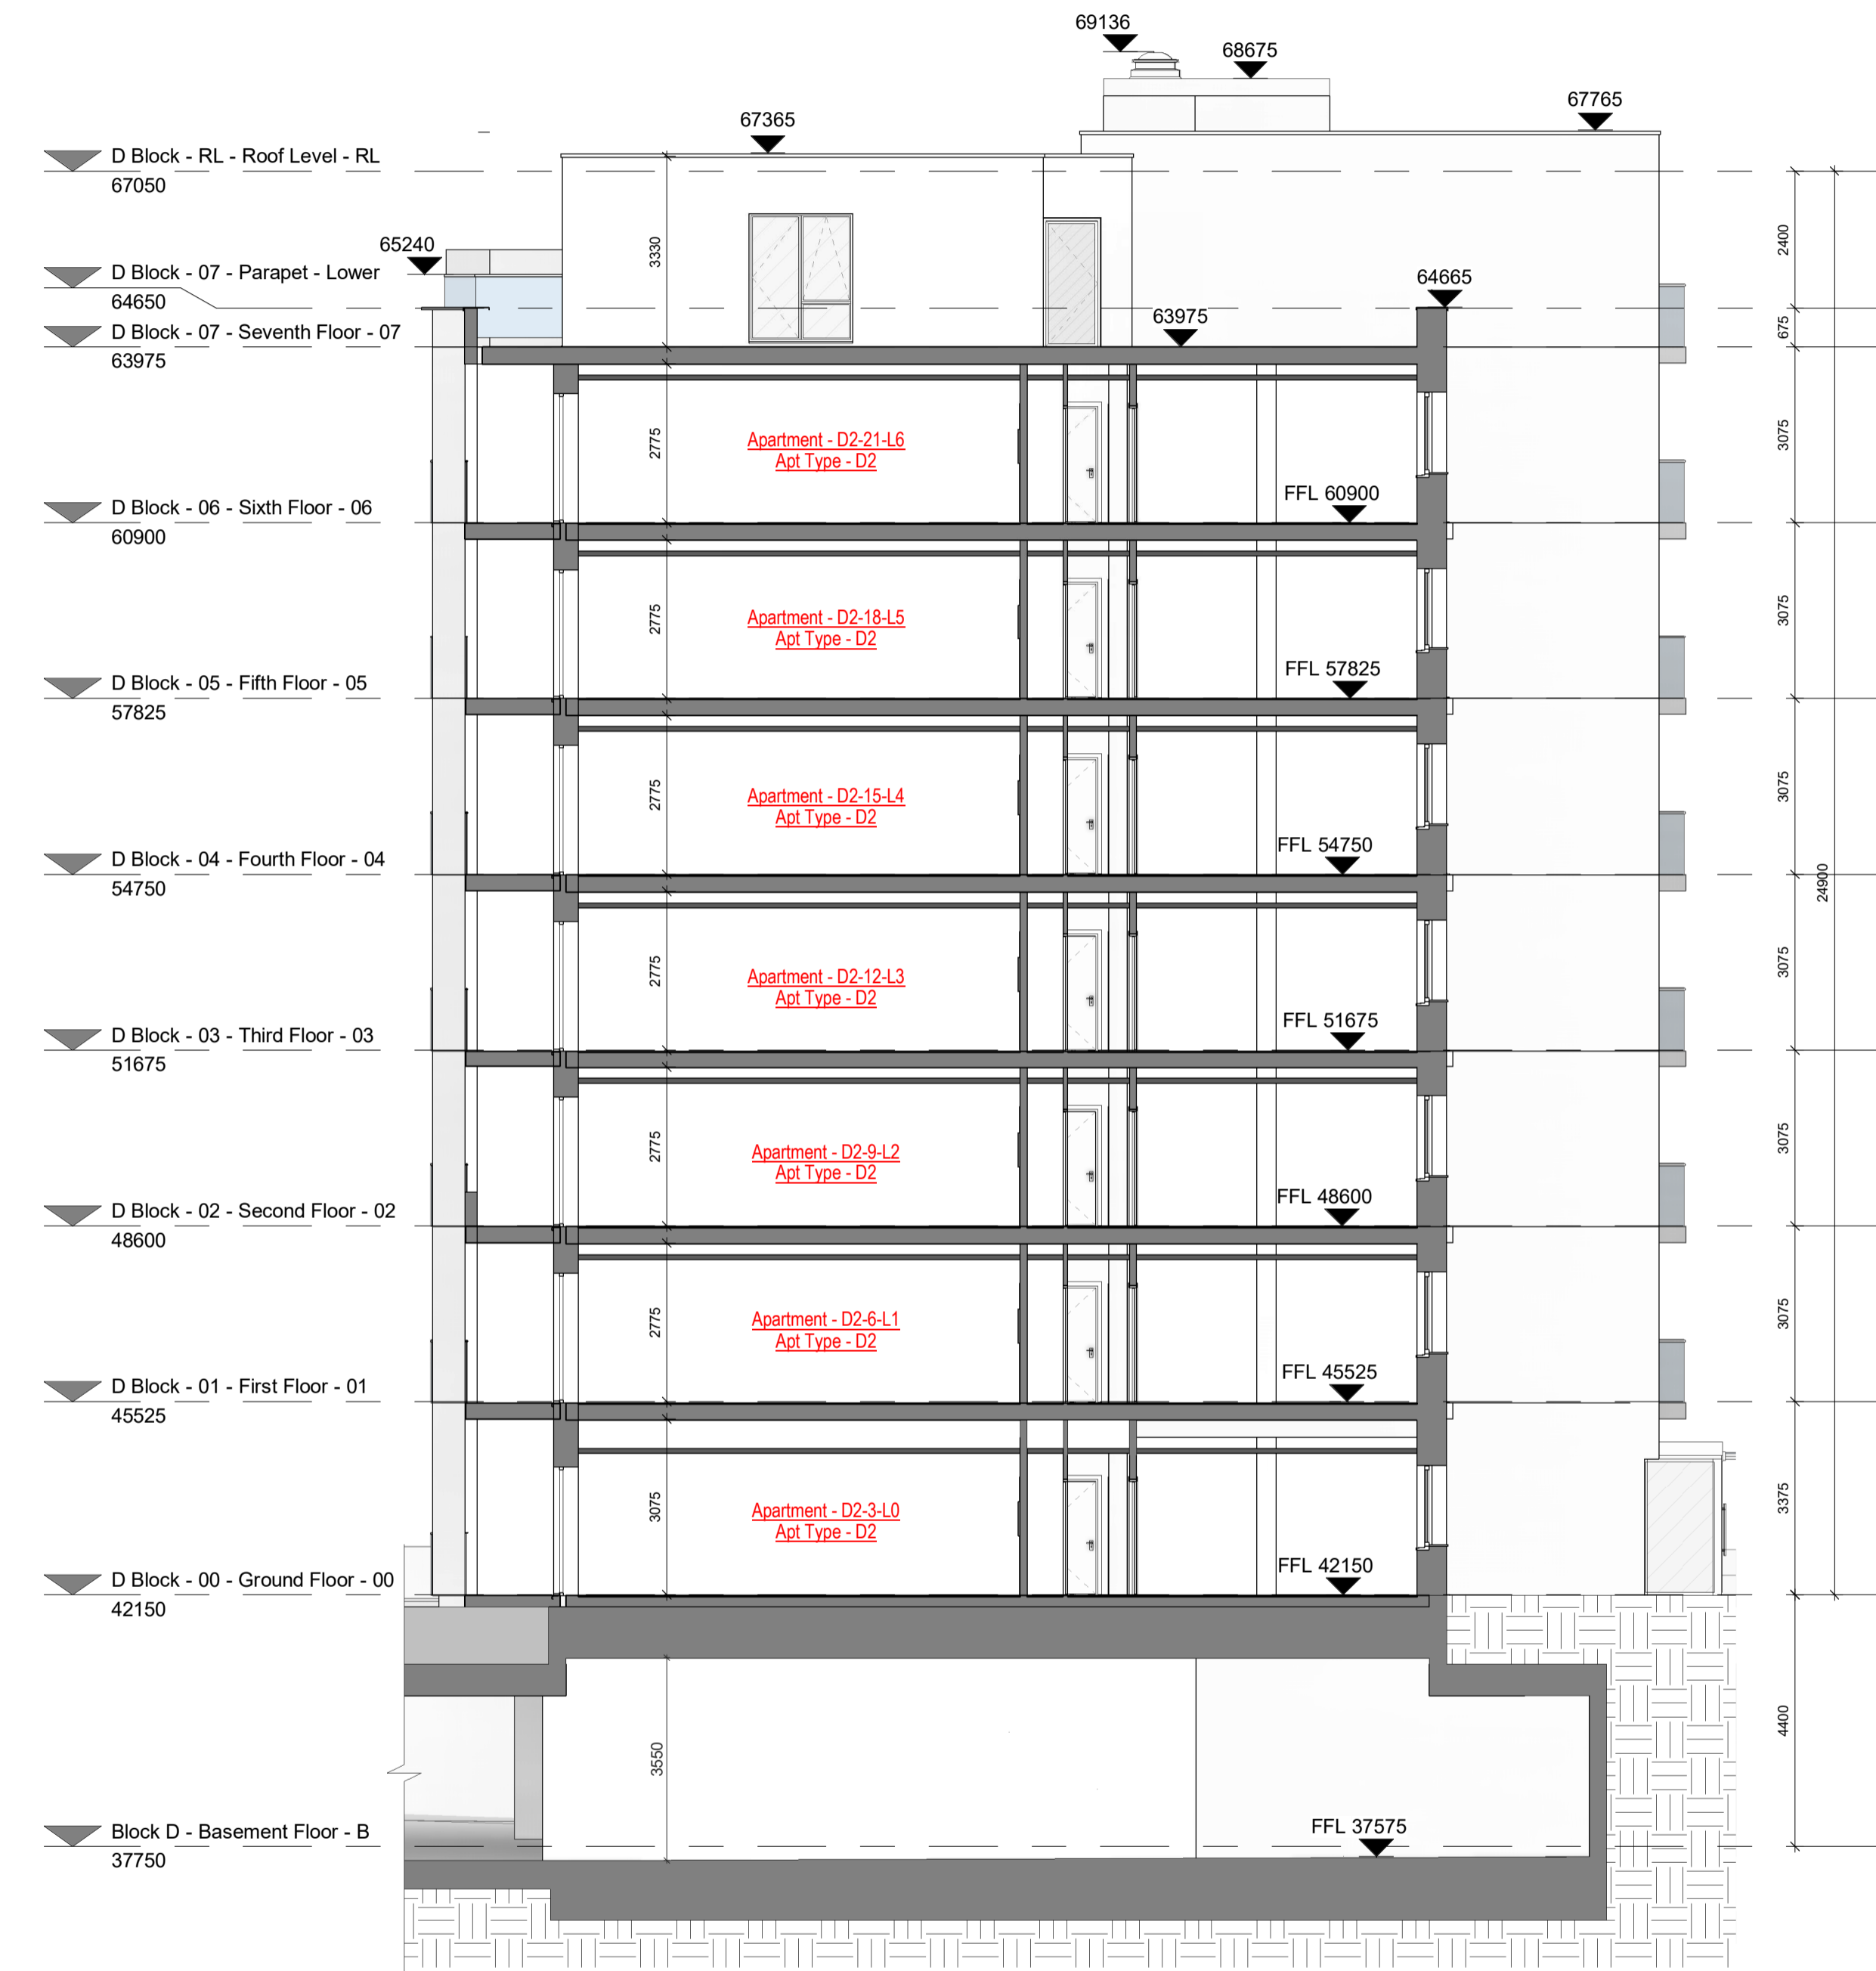

2 GA - Section CC
1 : 100

Rev	Date	Description	Issued By
Project Stage			
PLANNING			
Client:			
Eastwise Construction Swords Limited			
Project:			
Hartfield Place Swords Road, Whitehall, Dublin 9 D09 C7F8			
Drawing Title:			
BLOCK D - Section BB and CC GA - 472 Units			
Drawn	Checked	Paper Size	Scale
DP	CM	A1	1 : 100@A1
Project No.		Date	
HARTPL		Mar. 2022	
Drawing No.	Classification	Revision	
042531			
File Name			
HARTPL-CWO-BD-ZZ-DR-A-042531			
Status:			
S2-Suitable For Information			