



DESIGN INTENT DRAWING

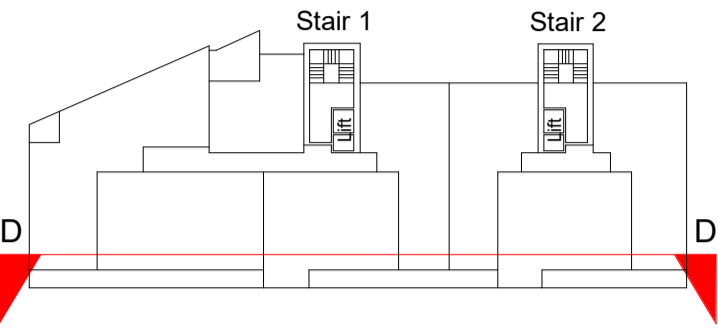


Key Plan (NTS)

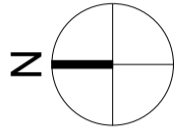

Room Legend

- EH/C Entrance Hall / Corridor
- KLD Kitchen / Living / Dining Room
- BD1 Bedroom 1
- BD2 Bedroom 2
- BD3 Bedroom 3
- BR Bathroom
- BR/ES Bathroom / En Suite
- ES En Suite
- ST Store
- POS Private Open Space

- ER Electrical Riser
- MR Mechanical Riser
- MSV Mechanical Smoke Vent

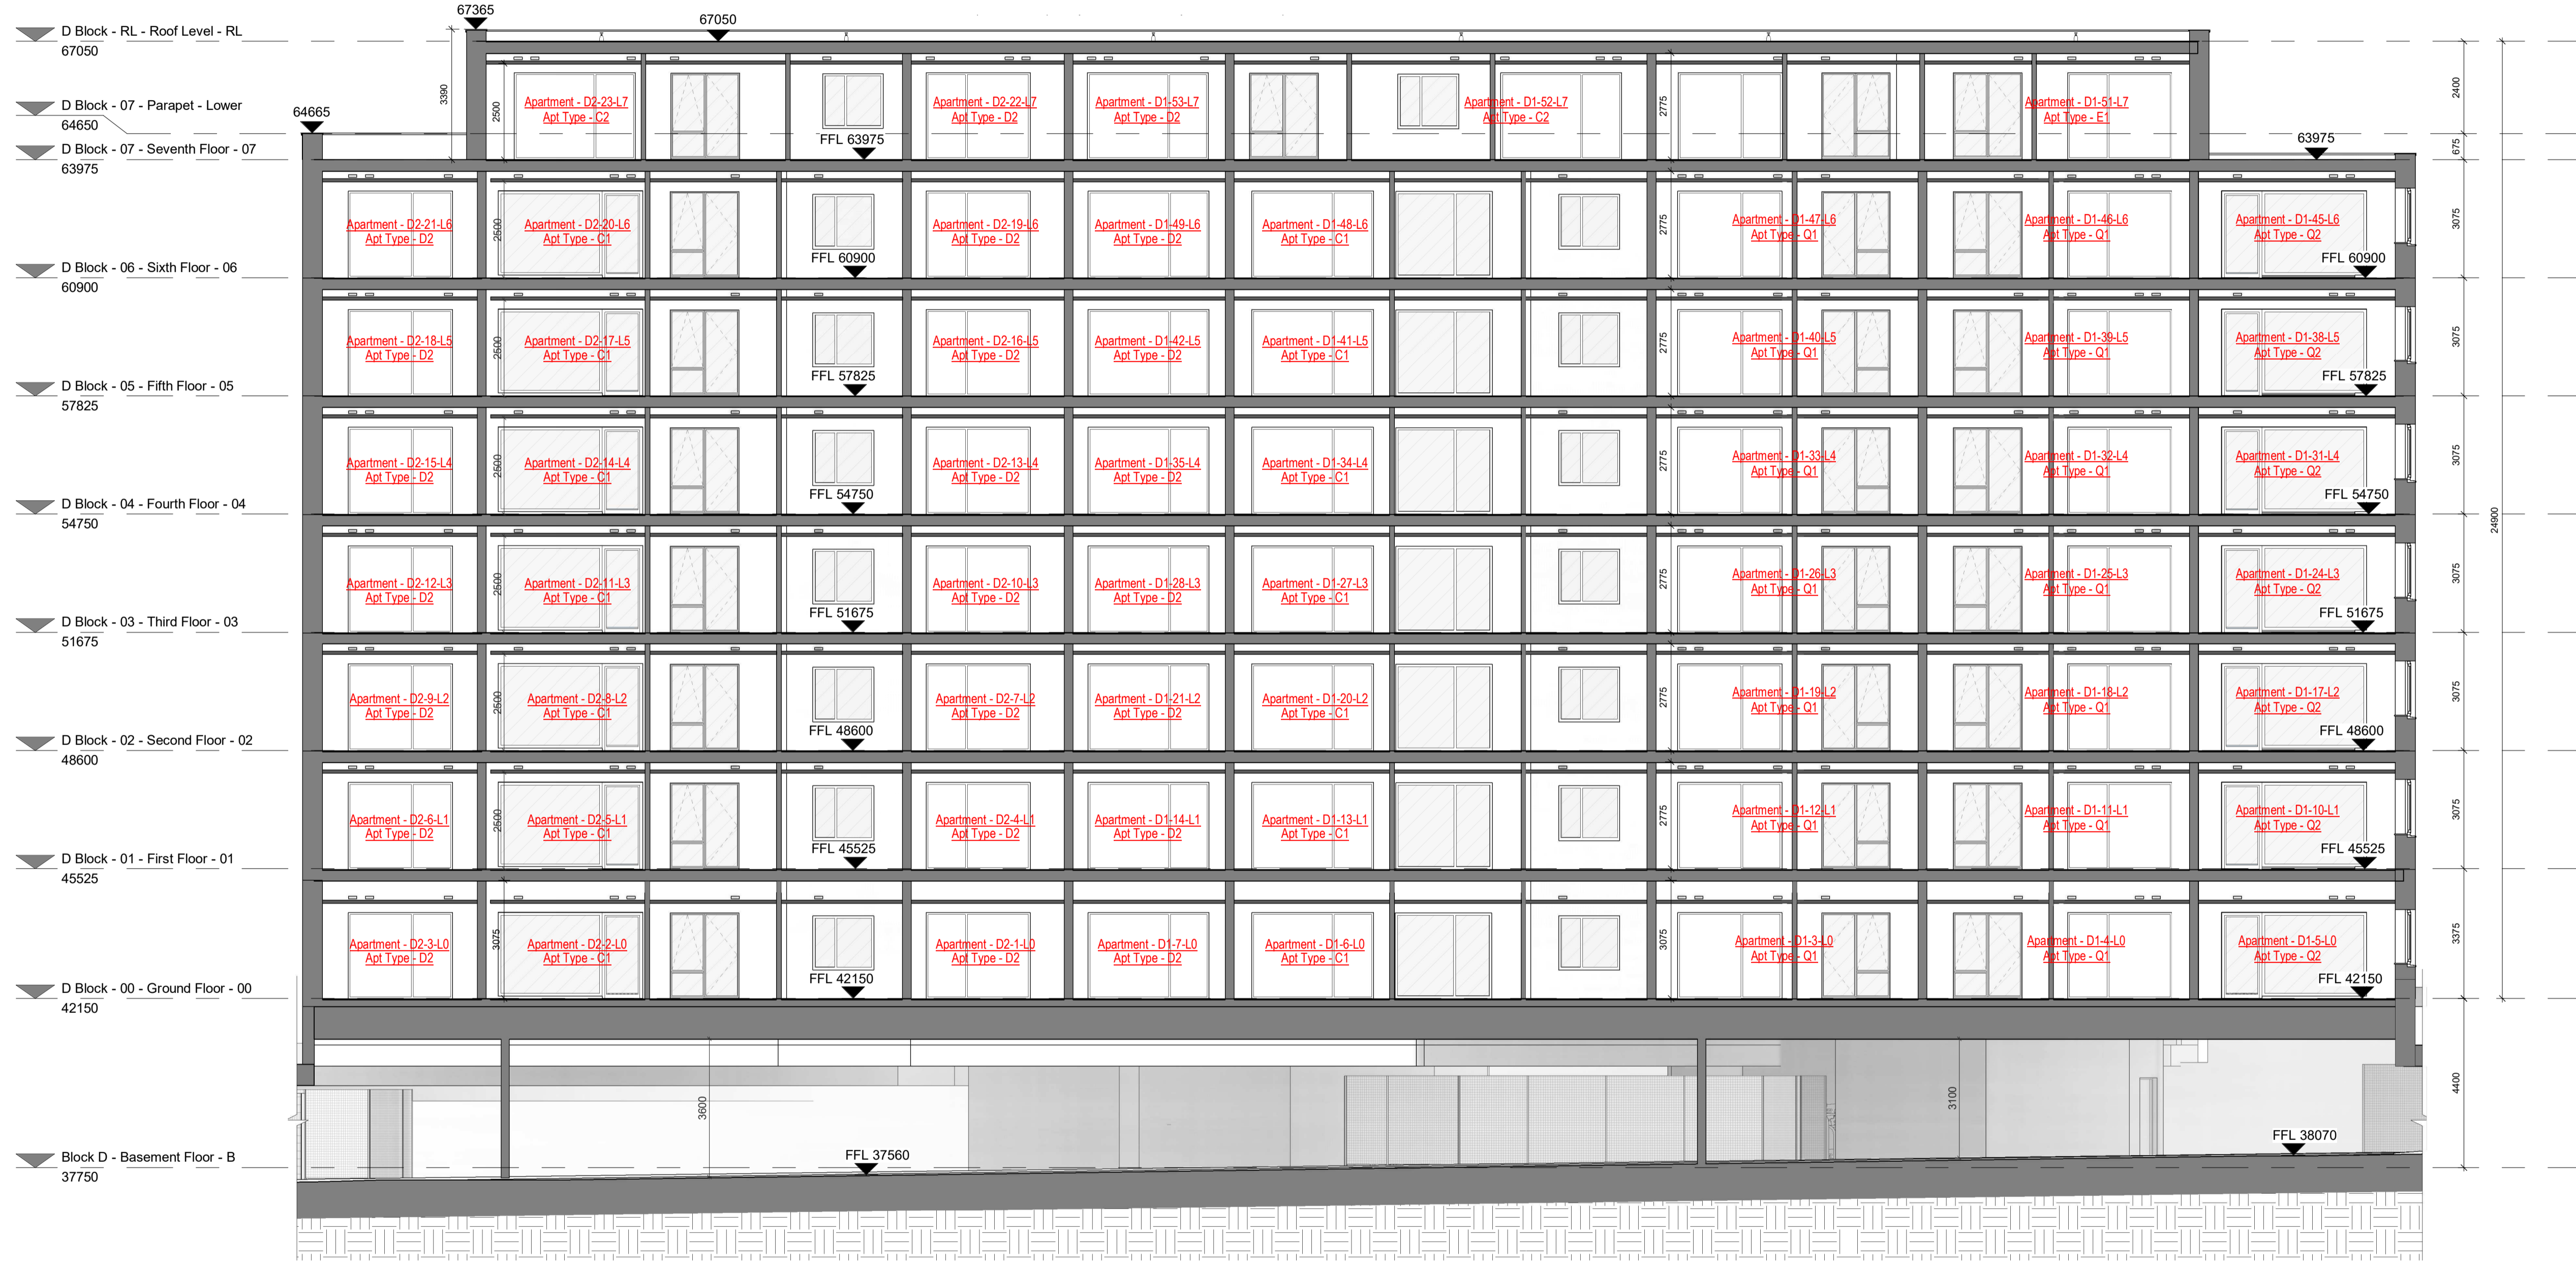

1 GA - Section DD
1 : 100

| Rev | Date | Description | Issued By |
|---|-------------|----------------|------------|
| Project Stage | | | |
| PLANNING | | | |
| Client: | | | |
| Eastwise Construction Swords Limited | | | |
| Project: | | | |
| Hartfield Place Swords Road, Whitehall, Dublin 9 D09 C7F8 | | | |
| Drawing Title: | | | |
| BLOCK D - Section DD GA - 472 Units | | | |
| Drawn | Checked | Paper Size | Scale |
| DP | CM | A1 | 1 : 100@A1 |
| Date | | Mar. 2022 | |
| Project No. | Drawing No. | Classification | Revision |
| HARTPL | 042532 | | |
| File Name | | | |
| HARTPL-CWO-BD-ZZ-DR-A-042532 | | | |
| Status: | | | |
| S2-Suitable For Information | | | |