
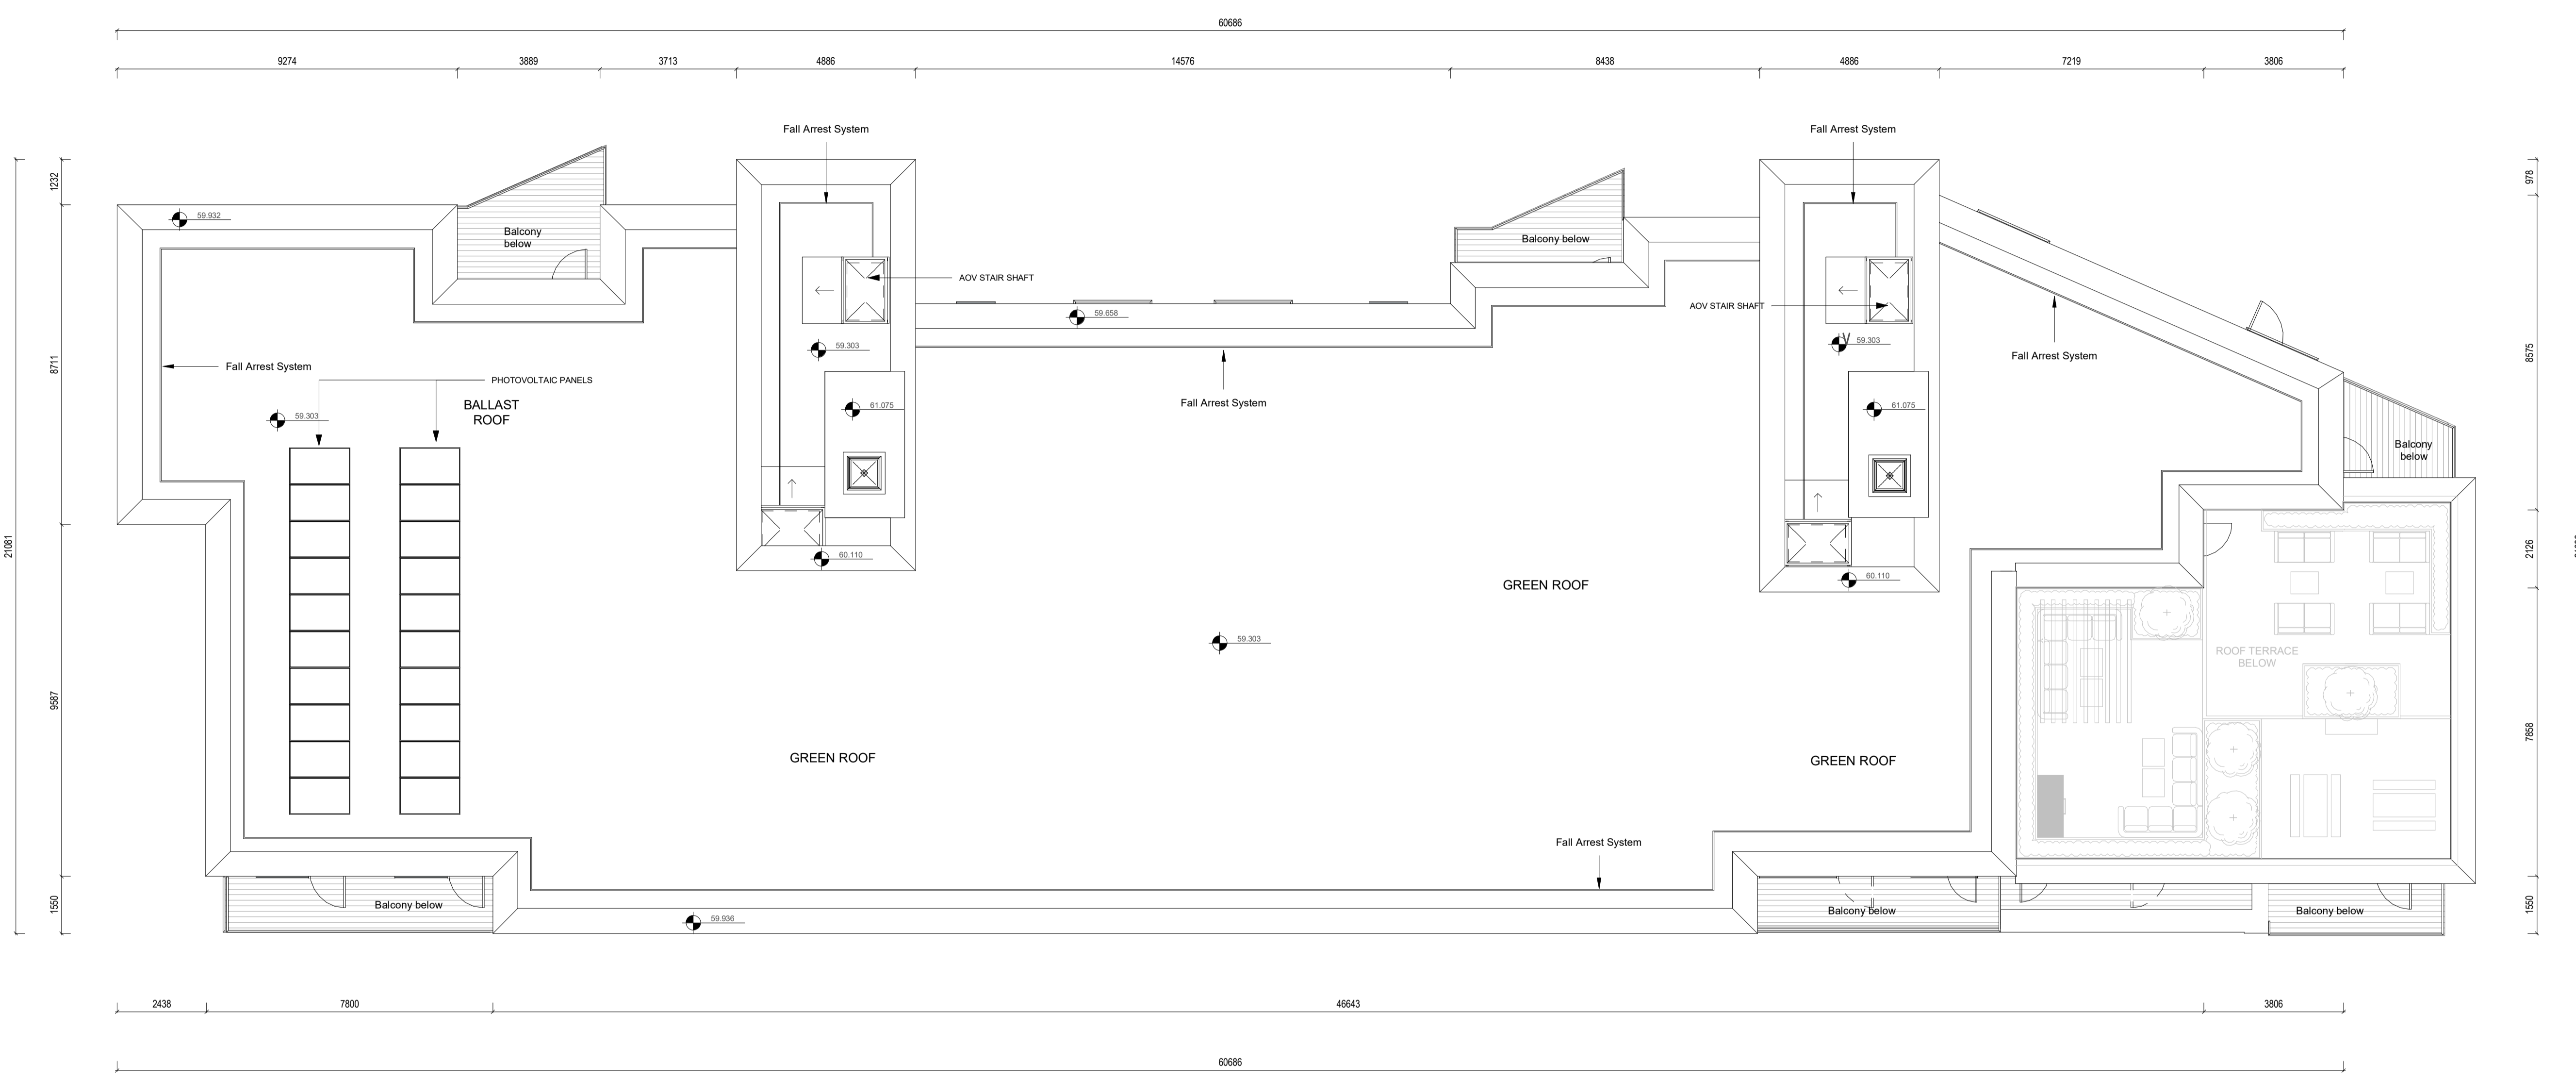


# DESIGN INTENT DRAWING

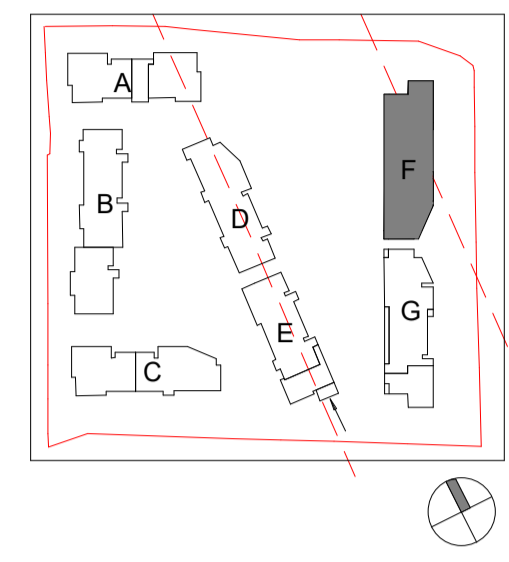

**Room Legend**

EH/C	Entrance Hall / Corridor
KLD	Kitchen / Living / Dining Room
BD1	Bedroom 1
BD2	Bedroom 2
BD3	Bedroom 3
BR	Bathroom
BR/ES	Bathroom / En Suite
ES	En Suite
ST	Store
POS	Private Open Space
ER	Electrical Riser
MR	Mechanical Riser
MSV	Mechanical Smoke Vent

**1** GA - Roof Plan  
 1 : 100

Rev	Description	Date	Dr by	App by
Project Stage				

## PLANNING

Client:  
 Eastwise Construction Swords Limited

Project:  
 Hartfield Place  
 Swords Road, Whitehall, Dublin 9  
 D09 C7F8

Drawing Title:  
 BLOCK F - Roof Plan GA - 472 Units

Drawn	Checked	Paper Size	Scale	Date
DP	CM	A1	1 : 100 @A1	Mar. 2022

Project No.	Drawing No.	Classification	Revision
HARTPL	062506		

File Name:  
 HARTPL-CWO-BF-RL-DR-A-062506

Status:  
 S2-Suitable For Information



No.1 Sarsfield Quay, Dublin 7, D07 R9FH  
 t: 01 518 0170 e: admin@cwoarchitects.ie  
 Dublin | Cork | Galway | London | UK & Europe +  
 www.cwoarchitects.ie