
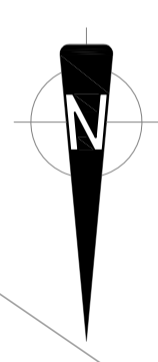


- NOTES:
1. LAYOUT IS NON-TYPE ONLY. FINAL POSITION
 2. ALL WASTEWATER WORKS TO BE IN ACCORDANCE WITH IRISH WATER WASTEWATER CODE OF PRACTICE AND IRISH WATERS WASTEWATER INFRASTRUCTURE STANDARD DETAILS.
 3. ALL SURFACE WATER WORKS TO BE IN ACCORDANCE WITH DRAINAGE WORKS PROFESSIONAL CODE OF PRACTICE FOR
 4. Foul pipe materials to be uPVC wavin pipe as per OF PROPOSED WASTEWATER INFRASTRUCTURE STANDARD DETAILS.
 5. ALL PUMP CHAMBERS AND RISING MAINS TO BE DESIGNED BY SPECIALIST CONTRACTOR.
 6. ALL PUMP CHAMBERS AND RISING MAINS TO BE DESIGNED BY SPECIALIST CONTRACTOR.

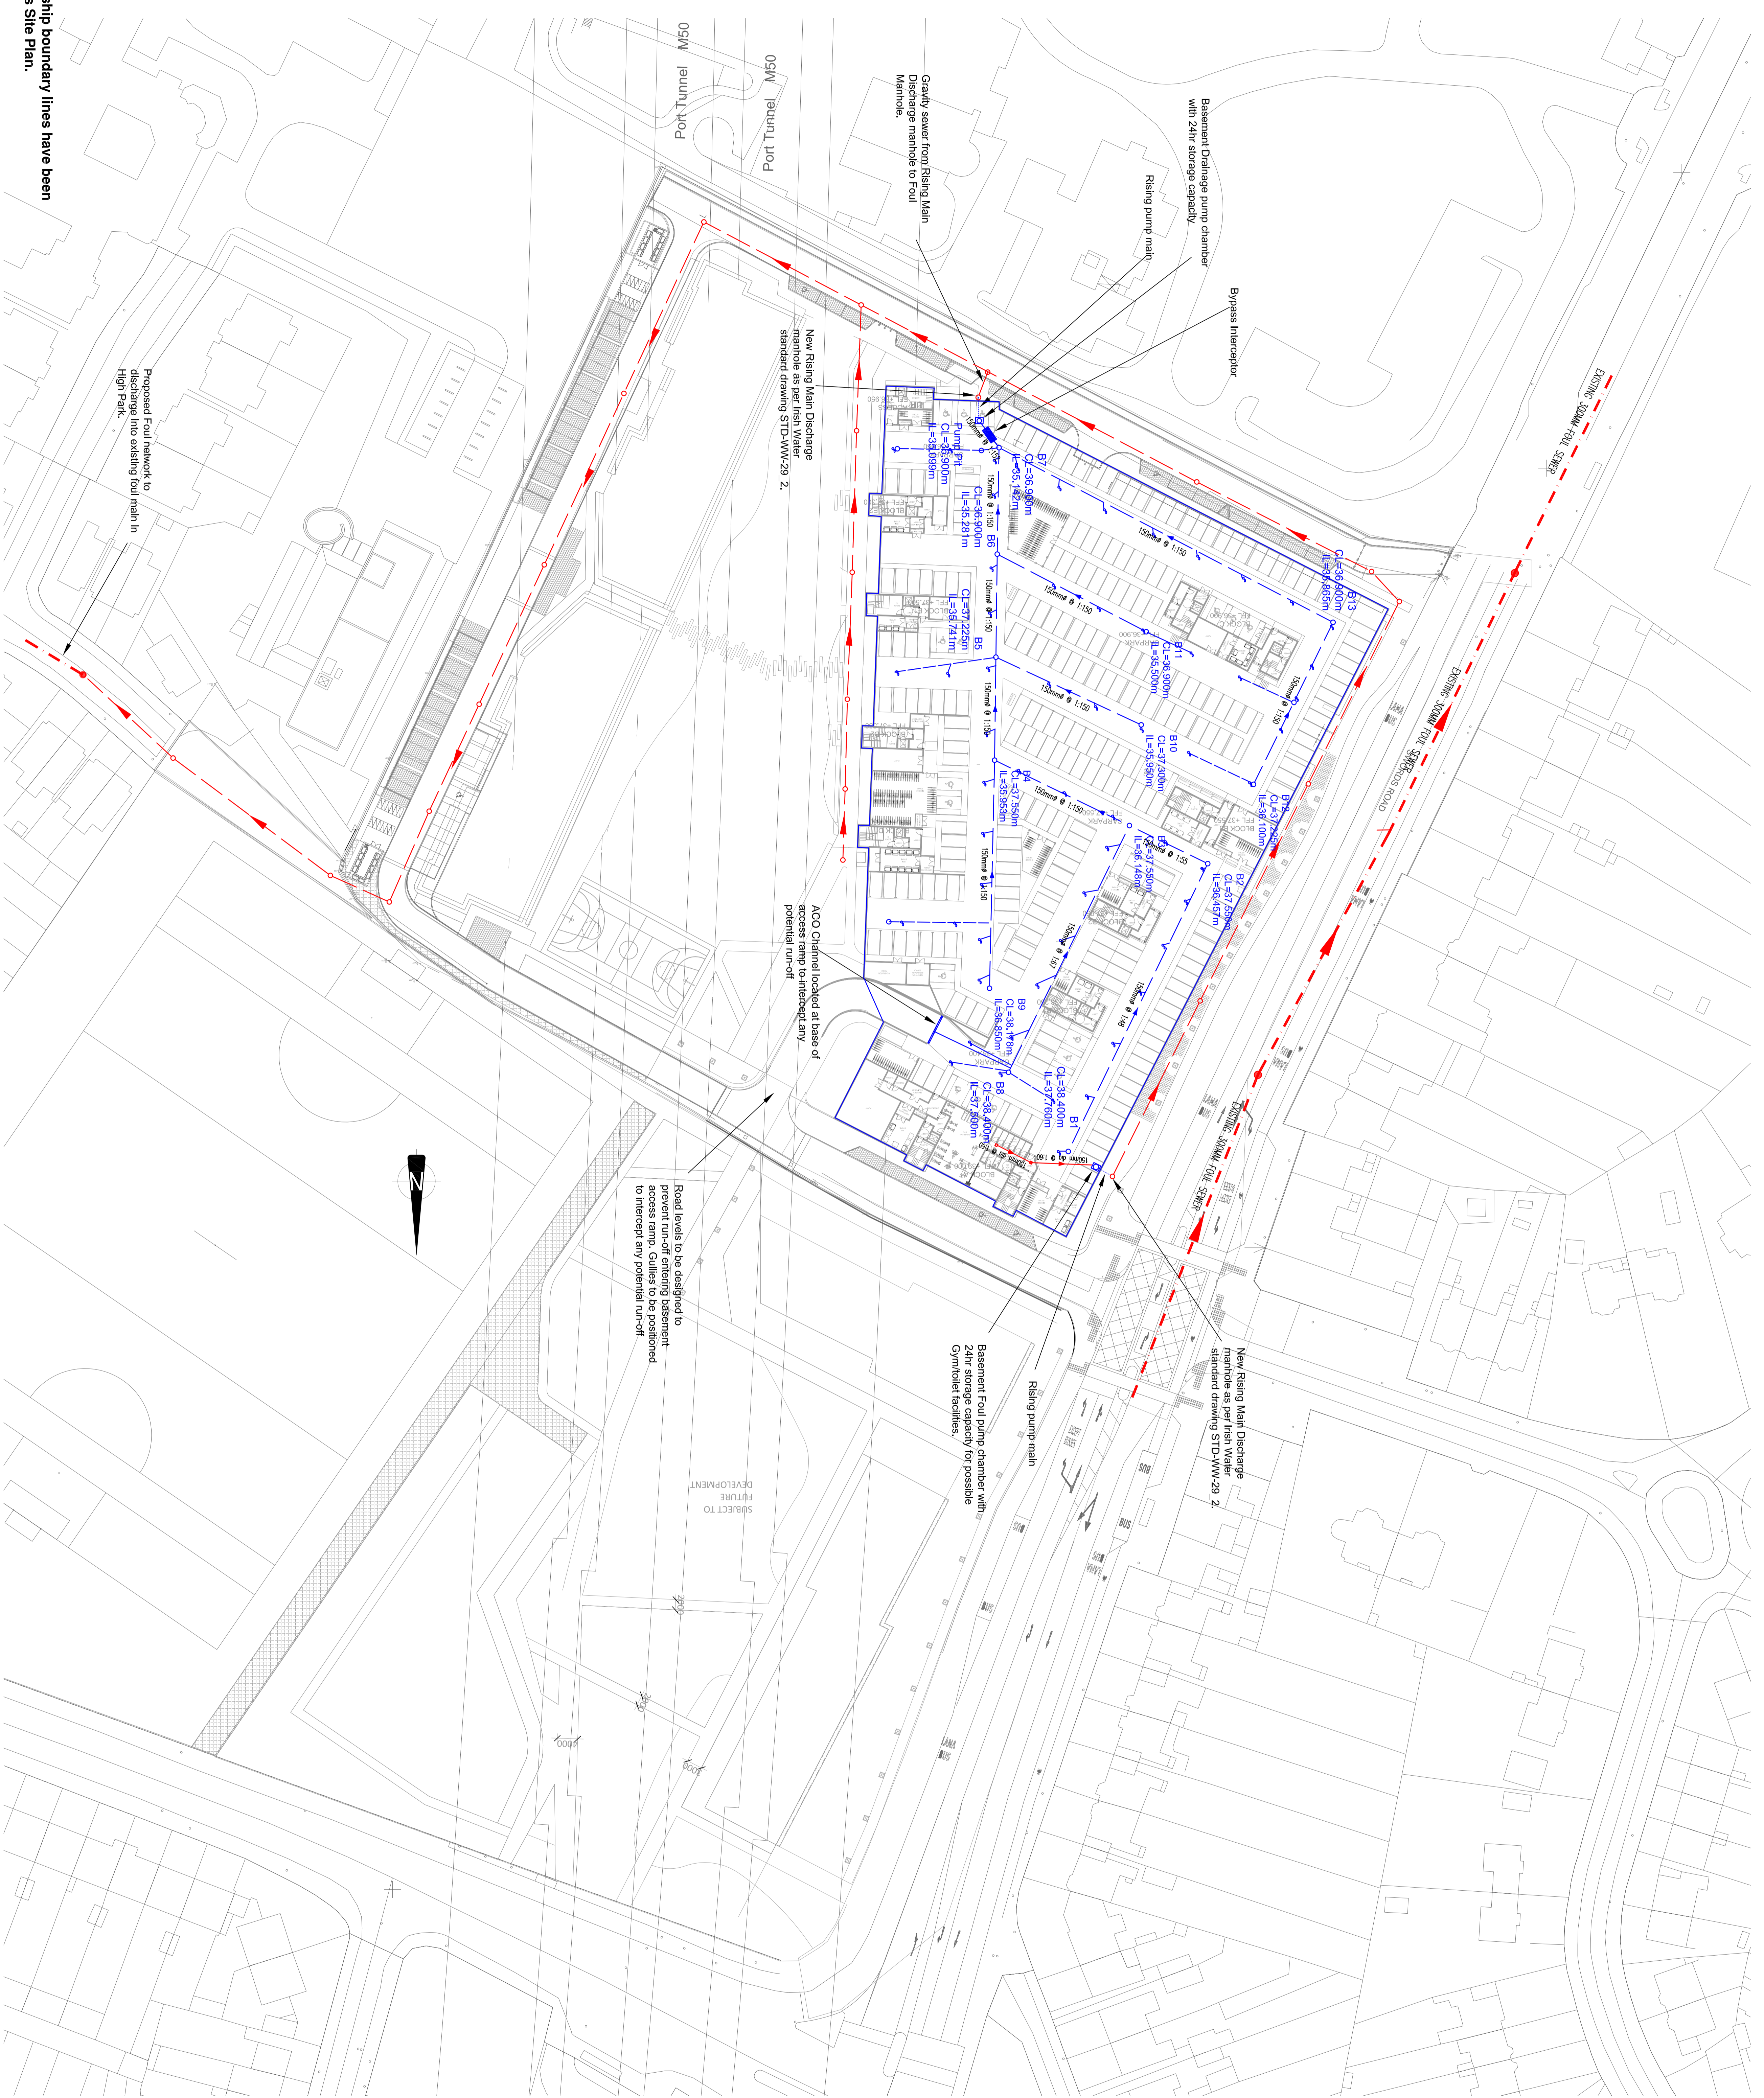

Site Boundaries:
The red site boundary and blue land ownership boundary lines have been omitted for clarity. Please refer to Architects Site Plan.

- NOTES
- Existing Foul Main
 - Existing Foul Manhole
 - Proposed Foul Drainage
 - Proposed Foul Manhole
 - Proposed Basement Drainage
 - Proposed Basement Gully
 - Proposed Basement Inspection Chamber
 - Proposed Pump station chamber
 - Proposed Bypass Interceptor
 - Proposed Rising Pump Main

REV	DATE	DETAILS
C03	04/12/22	Issued for stamp application

CLIENT	Eastwise Construction Swords Ltd
TITLE	Site Services: Basement Drainage Layout
PROJECT	Hartfield Place, Swords Road, Whitehall, Dublin 9, D09 C7R8
SCALE	1:500 (A3)
DATE	Nov. 2023
DRAWING NO.	HARTPL-JOB-BT-DR-C-0001
DATE	Nov. 2023
DESIGNED BY	NS
CHECKED BY	NS
REV	C03

ISSUED FOR PLANNING