


- NOTES:
1. THIS IS NOT A FINAL POSITION.
  2. ALL SERVICES TO BE CONFIRMED ON SITE.
  3. ALL WASTEWATER WORKS TO BE IN ACCORDANCE WITH IRISH WATER WASTEWATER CODE OF PRACTICE AND IRISH WATERS WASTEWATER INFRASTRUCTURE STANDARD DETAILS. GREATER DUE DILIGENCE SHALL BE EXERCISED IN ACCORDANCE WITH THE IRISH WATER WASTEWATER CODE OF PRACTICE FOR DRAINAGE WORKS.
  4. FOLI PIPE MATERIALS TO BE UPVC MAIN PIPE AS PER OF SECTION 3.13 IN THE IRISH WATER WASTEWATER CODE OF PRACTICE.
  5. WHERE THE PIPE SHALL HAVE A CONCRETE SURROUND AS PER IRISH WATER WASTEWATER CODE OF PRACTICE MINIMUM COVER OF 750MM.
  6. TRAFFICABLE AREAS THE PIPE SHALL HAVE A CONCRETE SURROUND AS PER IRISH WATER WASTEWATER CODE OF PRACTICE MINIMUM COVER OF 750MM.
  7. ALL PUMP CHAMBERS AND RISING MAINS TO BE DESIGNED BY LOCAL FOUUL DRAINAGE FROM CARPARK ROOF SLAB TO BE CONFIRMED BY M&E CONTRACTOR.
  8. SLEUNG FOUUL DRAINAGE TO BE CONFIRMED BY M&E CONTRACTOR.
  9. LOCAL FOUUL DRAINAGE LAYOUT WHICH WILL CONNECT THE ABOVE INTERNAL BUILDING DRAINAGE TO BE CONFIRMED.

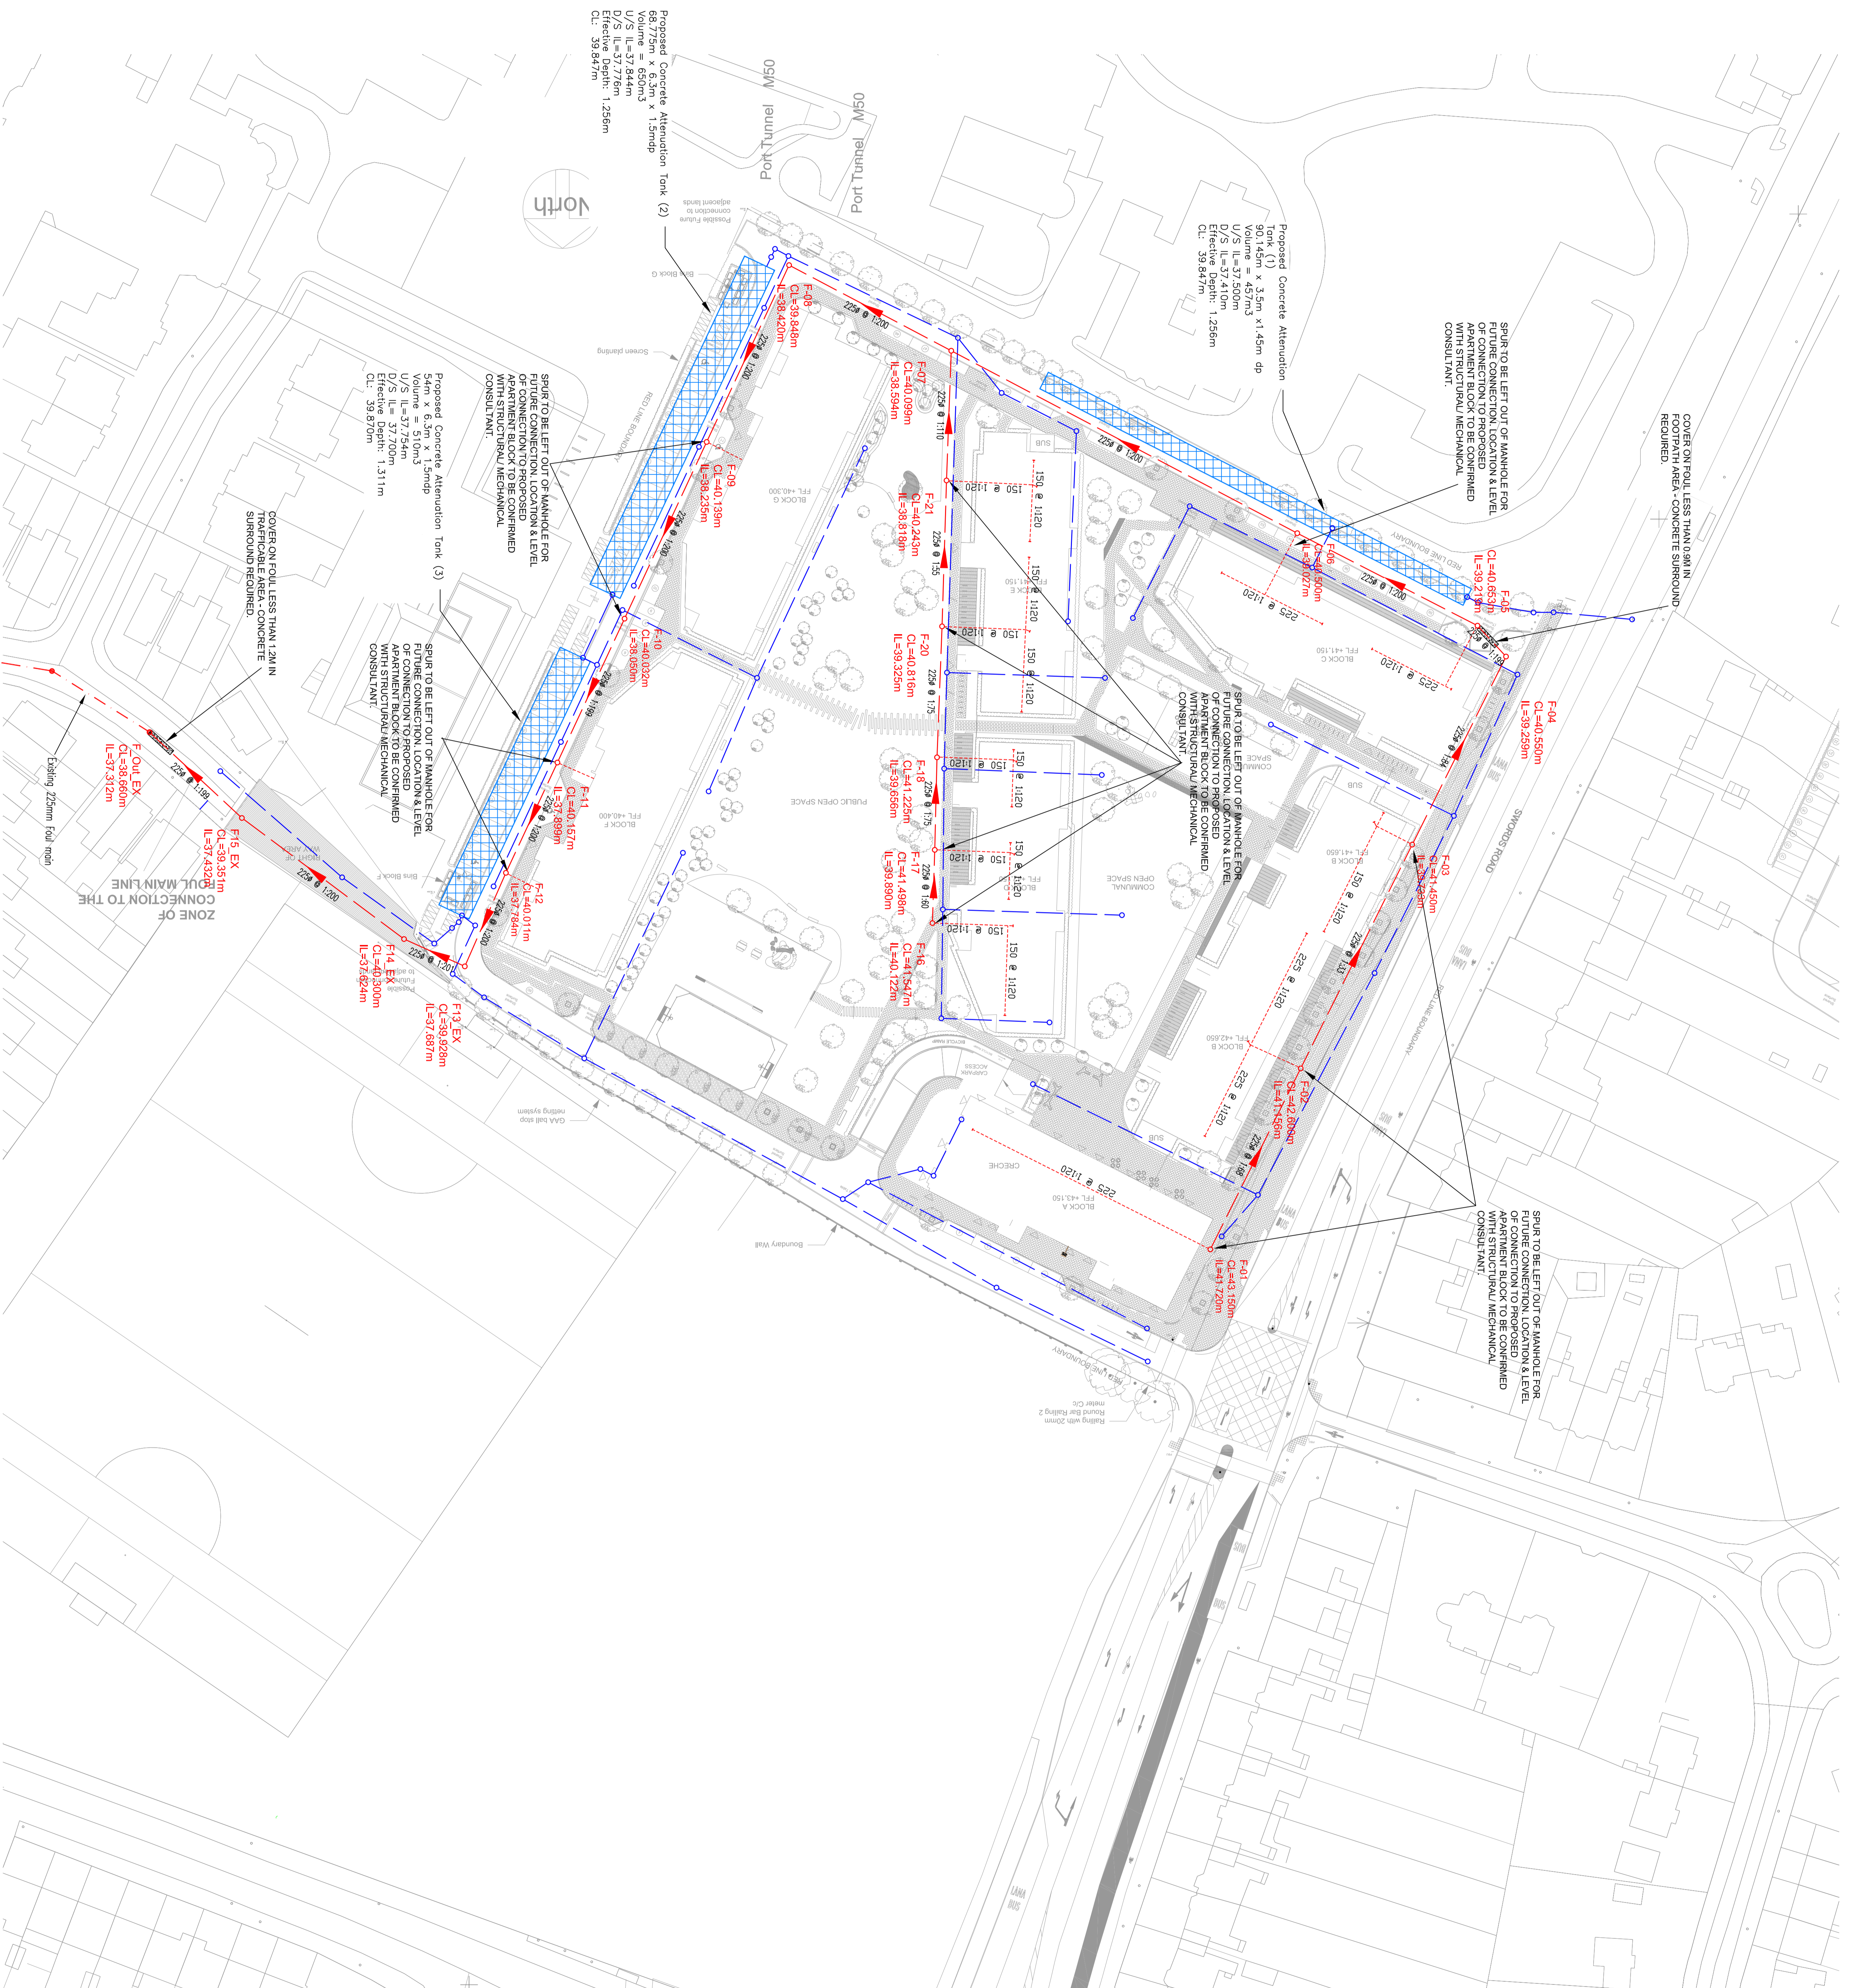

Site Boundaries:  
The red site boundary and blue land ownership boundary lines have been omitted for clarity. Please refer to Architects Site Plan.

- NOTES
- Existing Foul Main
  - Existing Foul Manhole
  - Proposed Foul Drainage
  - Proposed Foul Manhole
  - Proposed Slung Foul Drainage
  - Proposed Surface Water Manhole
  - Proposed Surface Water Drainage
  - Proposed Attenuation tanks
  - Concrete surround required

REV	DATE	DETAILS
C05	01/04/22	Issued as part of the contract for S&D
C04	24/02/22	Revised as per the contract for S&D
C03	11/03/21	Issued for S&D Application

**JOE**  
Joseph O'Reilly  
Consulting Civil & Structural Engineers  
Tel: 046 9077032 Fax: 046 9077932  
Email: info@joe.ie Web: www.joe.ie  
Unit 7, St. Theresa's Place, Fowhill, Navan, Co. Meath

CLIENT	Eastwise Construction Swords Ltd
TITLE	Foul Drainage Layout
PROJECT	Hartfield Place, Swords Road, Whitehall, Dublin 9, D09 C7R8
SCALE	1:500 (A3)
DATE	Oct. 2021
DATE	028
DRAWING NO.	HARTFLD-OR-SW-ZZ-DR-C-001
CHECKED BY	MS
REV	C05

ISSUED FOR PLANNING