




- NOTES:**
1. SITE INVESTIGATION DATA BASED ON ICSL LIMITED FACTUAL GROUND INVESTIGATION REPORT, REPORT NO. 23110 DATED APRIL 2021
 2. REFER TO DRAWING NO. 192229-PUNCH-XX-XX-DR-C-0101 TO 0104 FOR FULL DRAINAGE LAYOUT.
 3. REFER TO DRAWING NO. 192229-PUNCH-XX-XX-DR-C-0110 FOR TYPICAL SUDS SCHEMATIC DETAIL PLAN.

- LEGEND:**
- PROPOSED SURFACE WATER SEWER
 - PROPOSED OVERFLOW PIPE
 - PROPOSED SURFACE WATER MANHOLE
 - PROPOSED SURFACE WATER INSPECTION CHAMBER
 - PROPOSED ATTENUATION TANK
 - PROPOSED SOAK PIT
 - PROPOSED WATERBUTT
 - PROPOSED LAND DRAIN
 - PROPOSED SWALE
 - PROPOSED NSORR SWALE
 - PROPOSED PERMEABLE PAVING
 - PROPOSED GREEN ROOF
 - EXTENT OF PROPOSED DEVELOPMENT

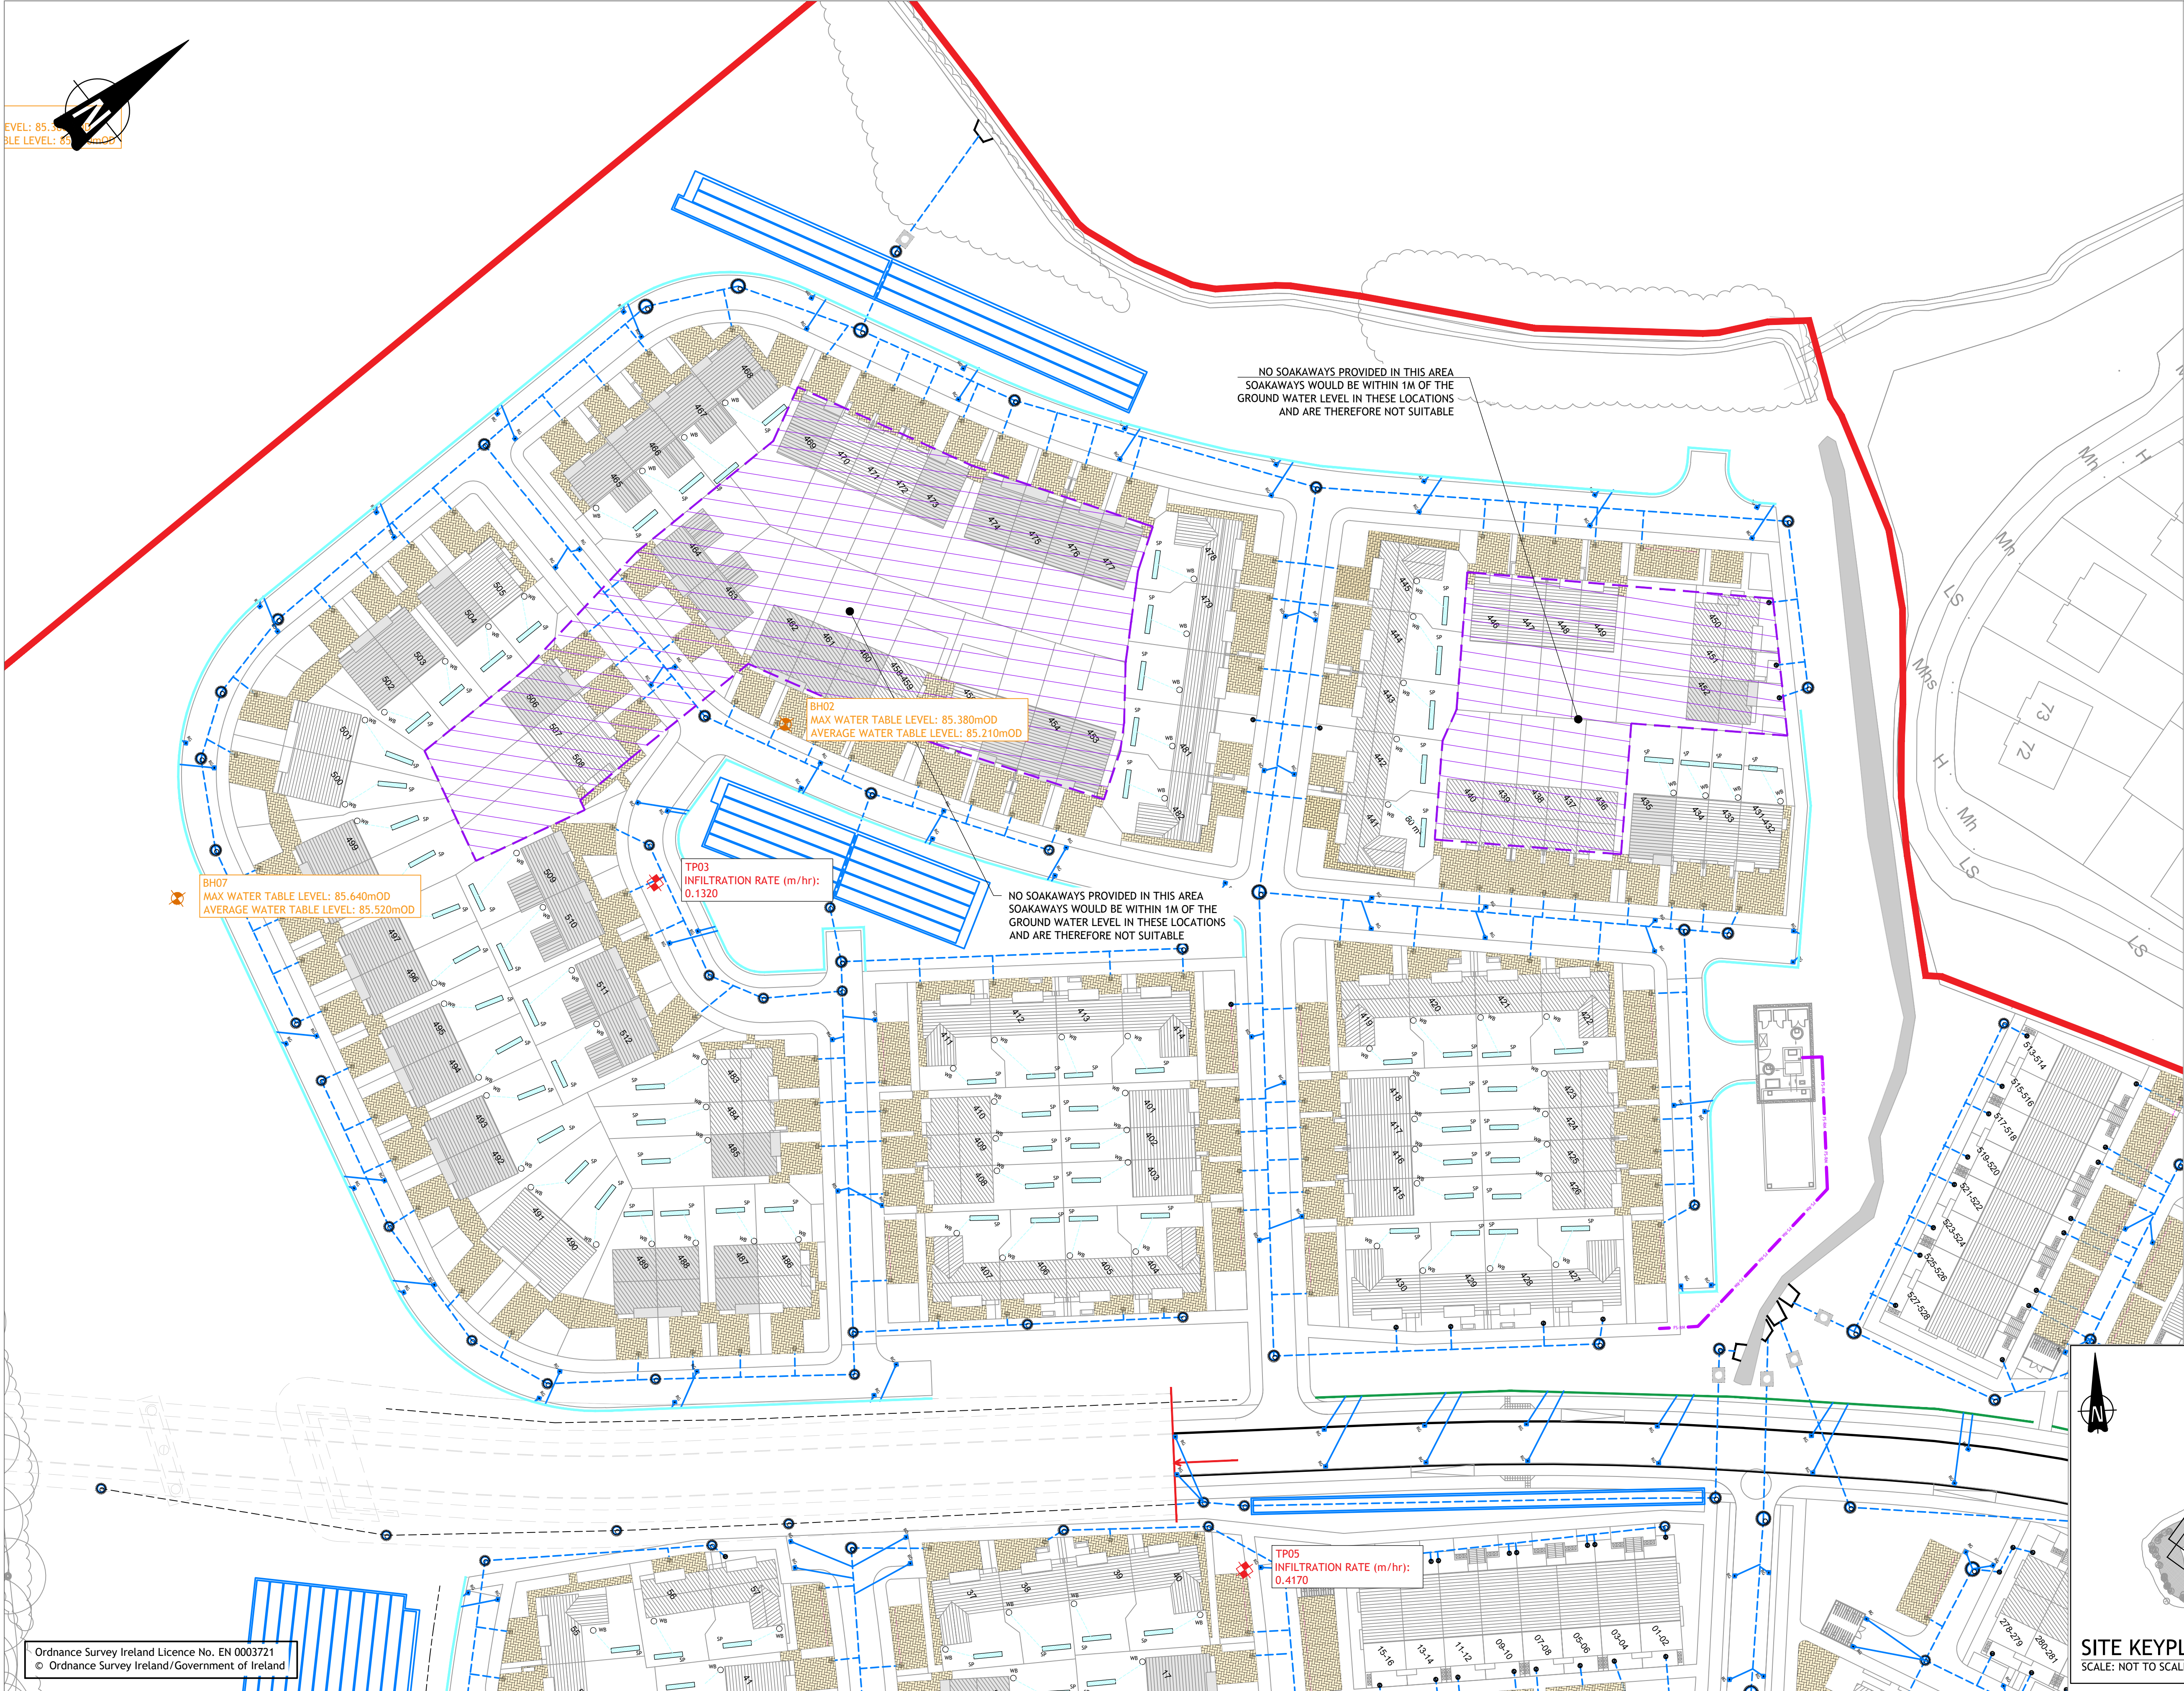

SITE KEYPLAN
SCALE: NOT TO SCALE

© PUNCH Consulting Engineers
This drawing and any design hereon is the copyright of the Consultants and must not be reproduced without their written consent.
All drawings remain the property of the Consultants.
Figured dimension only to be taken from this drawing.
Consultants to be informed immediately of any discrepancies before work proceeds.



Rev	Amendment	By	Date	Rev	Amendment	By	Date
C01	ISSUED FOR PLANNING	IBS	2022-03-22				
C02	ISSUED FOR PLANNING	IBS	2022-03-31				

Client:



Project:	GREAT CONNELL SHD, NEWBRIDGE
Title:	PROPOSED SUDS MEASURES LAYOUT - SHEET 2
Drawn:	IBS
Date drawn:	MARCH 2022
Model Ref:	192229-PUNCH-XX-XX-M2-C-0151
Document Ref:	192229-PUNCH-XX-XX-DR-C-0151
Scale @ A1:	1:500
Engineer's Check:	SWC
Approved:	LB
Drawing Status:	A0 PLANNING
Revision No:	C02