



PLAN VIEW – DRAINAGE LAYOUT
SCALE 1:1000 @A1

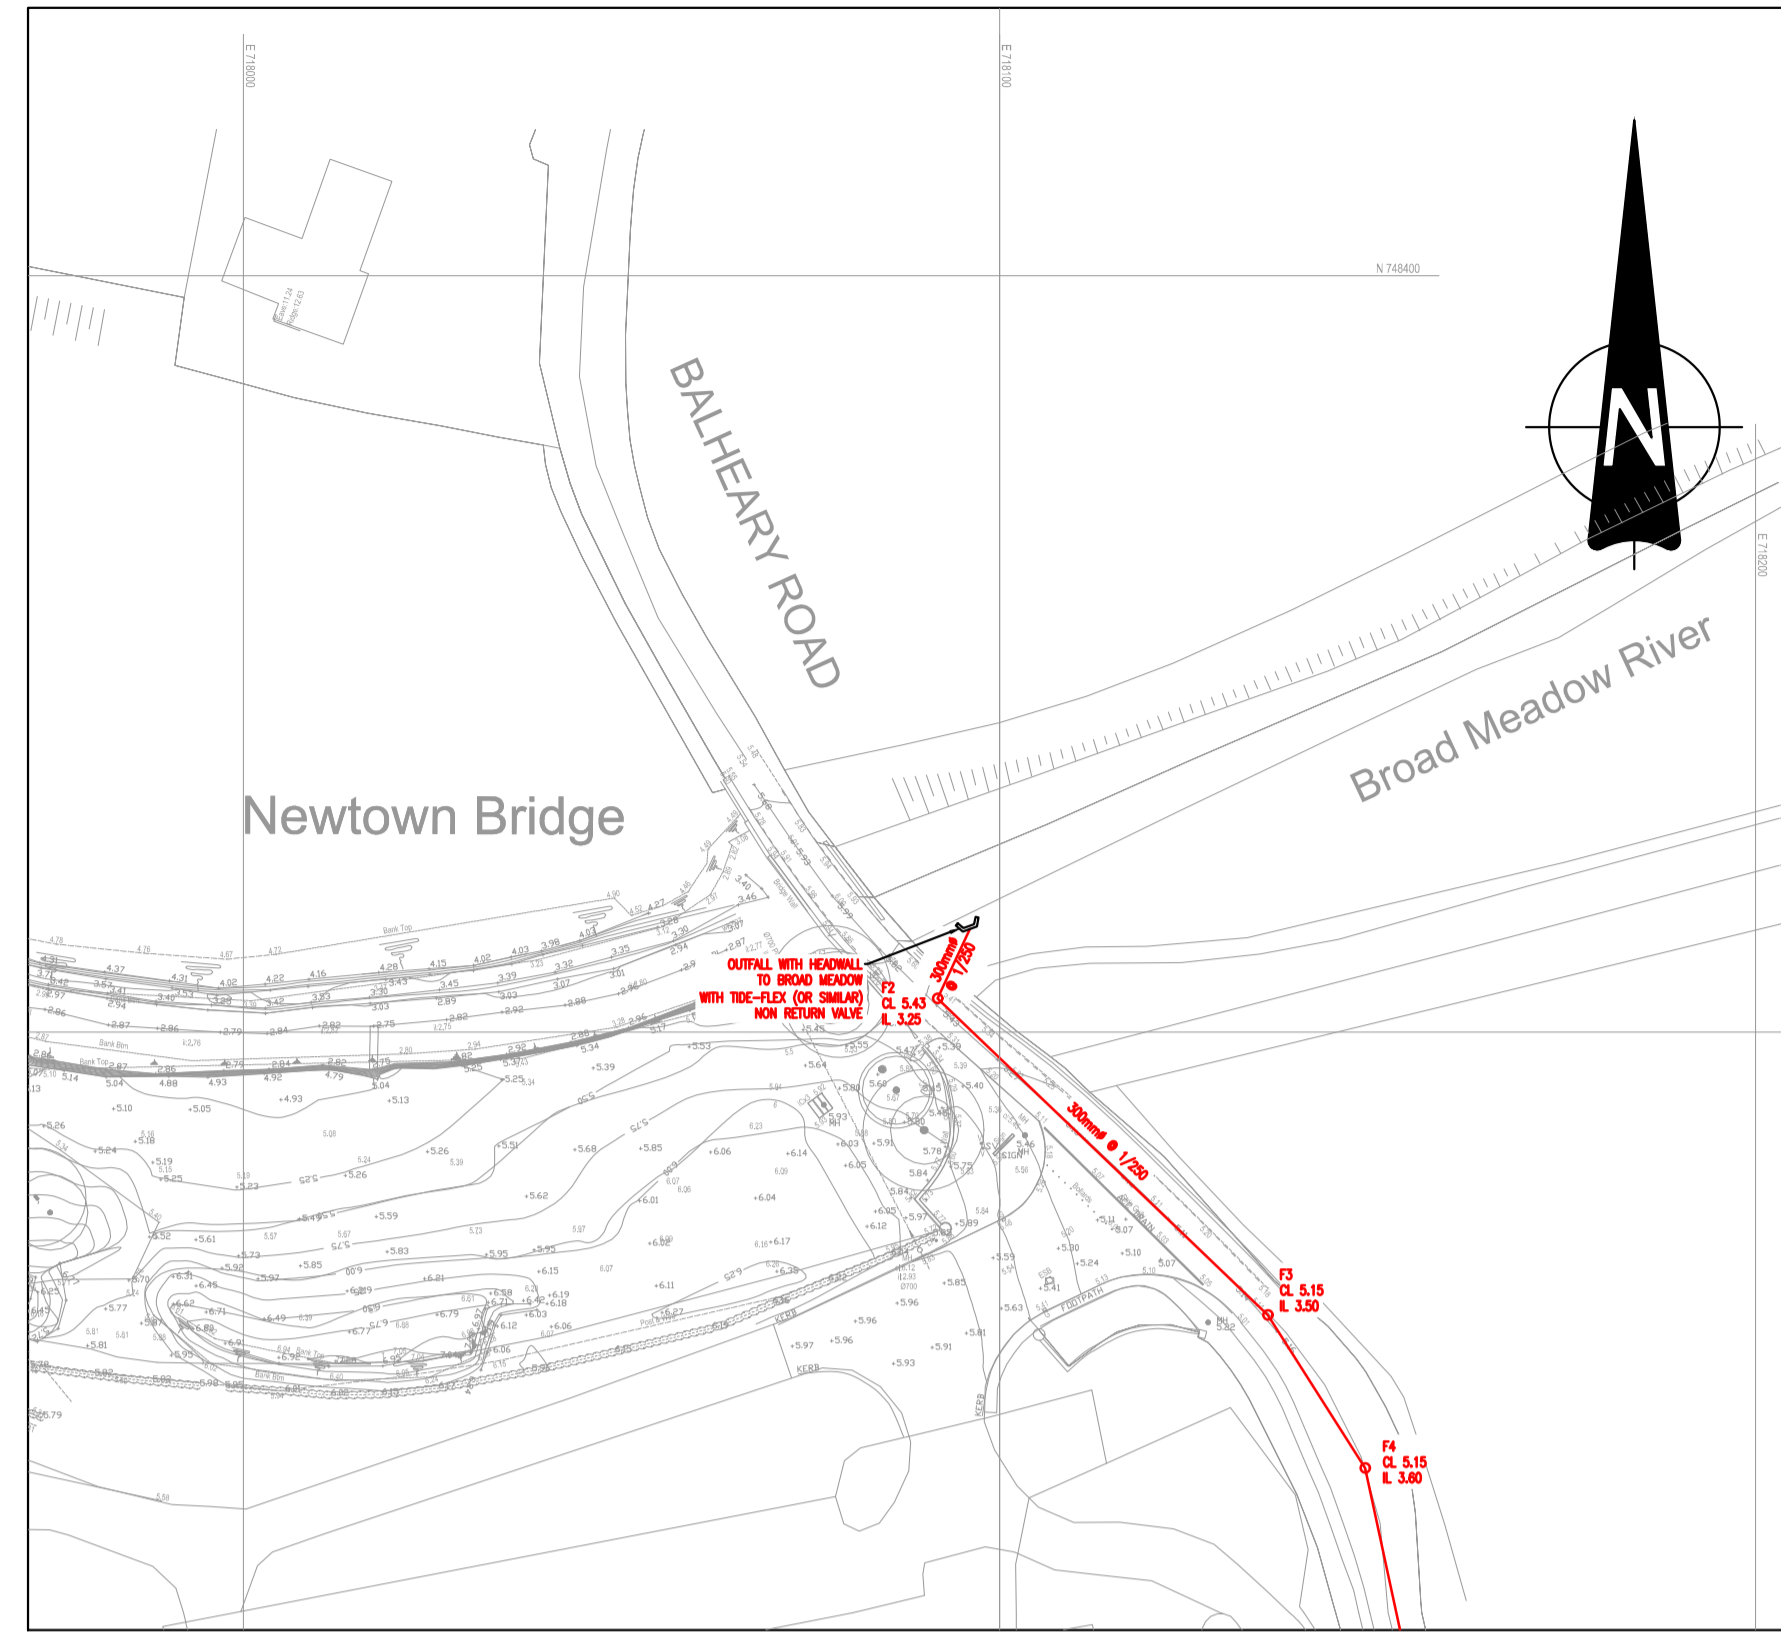


PLAN VIEW – HEADWALL LOCATION
SCALE 1:1000 @A1

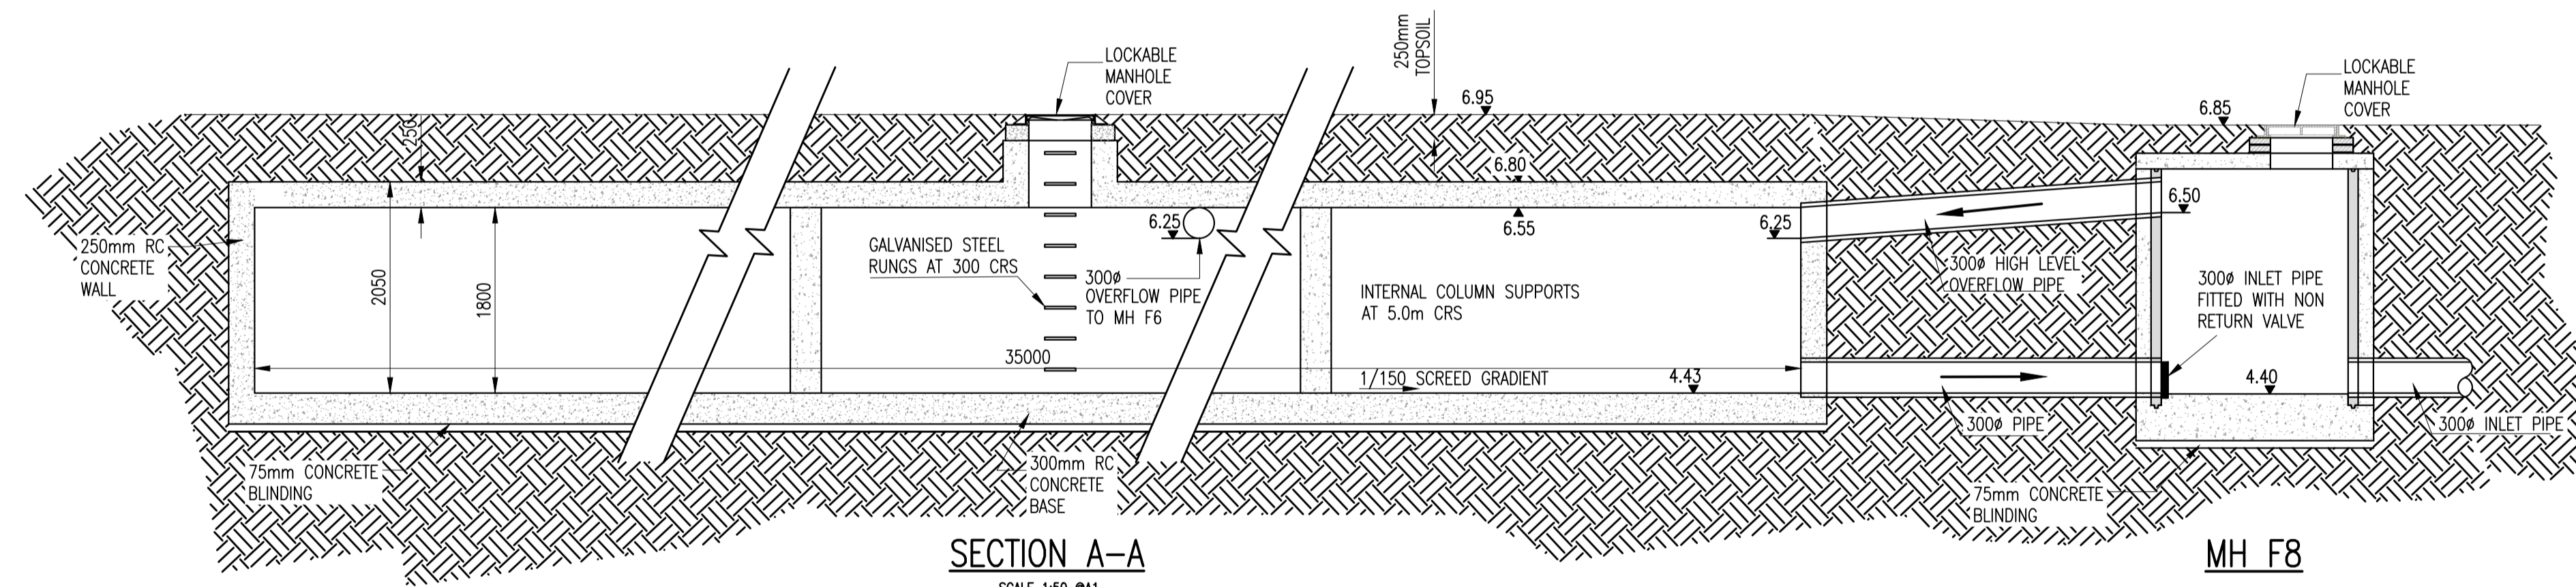


SECTION A-A
SCALE 1:50 @A1

MH F8

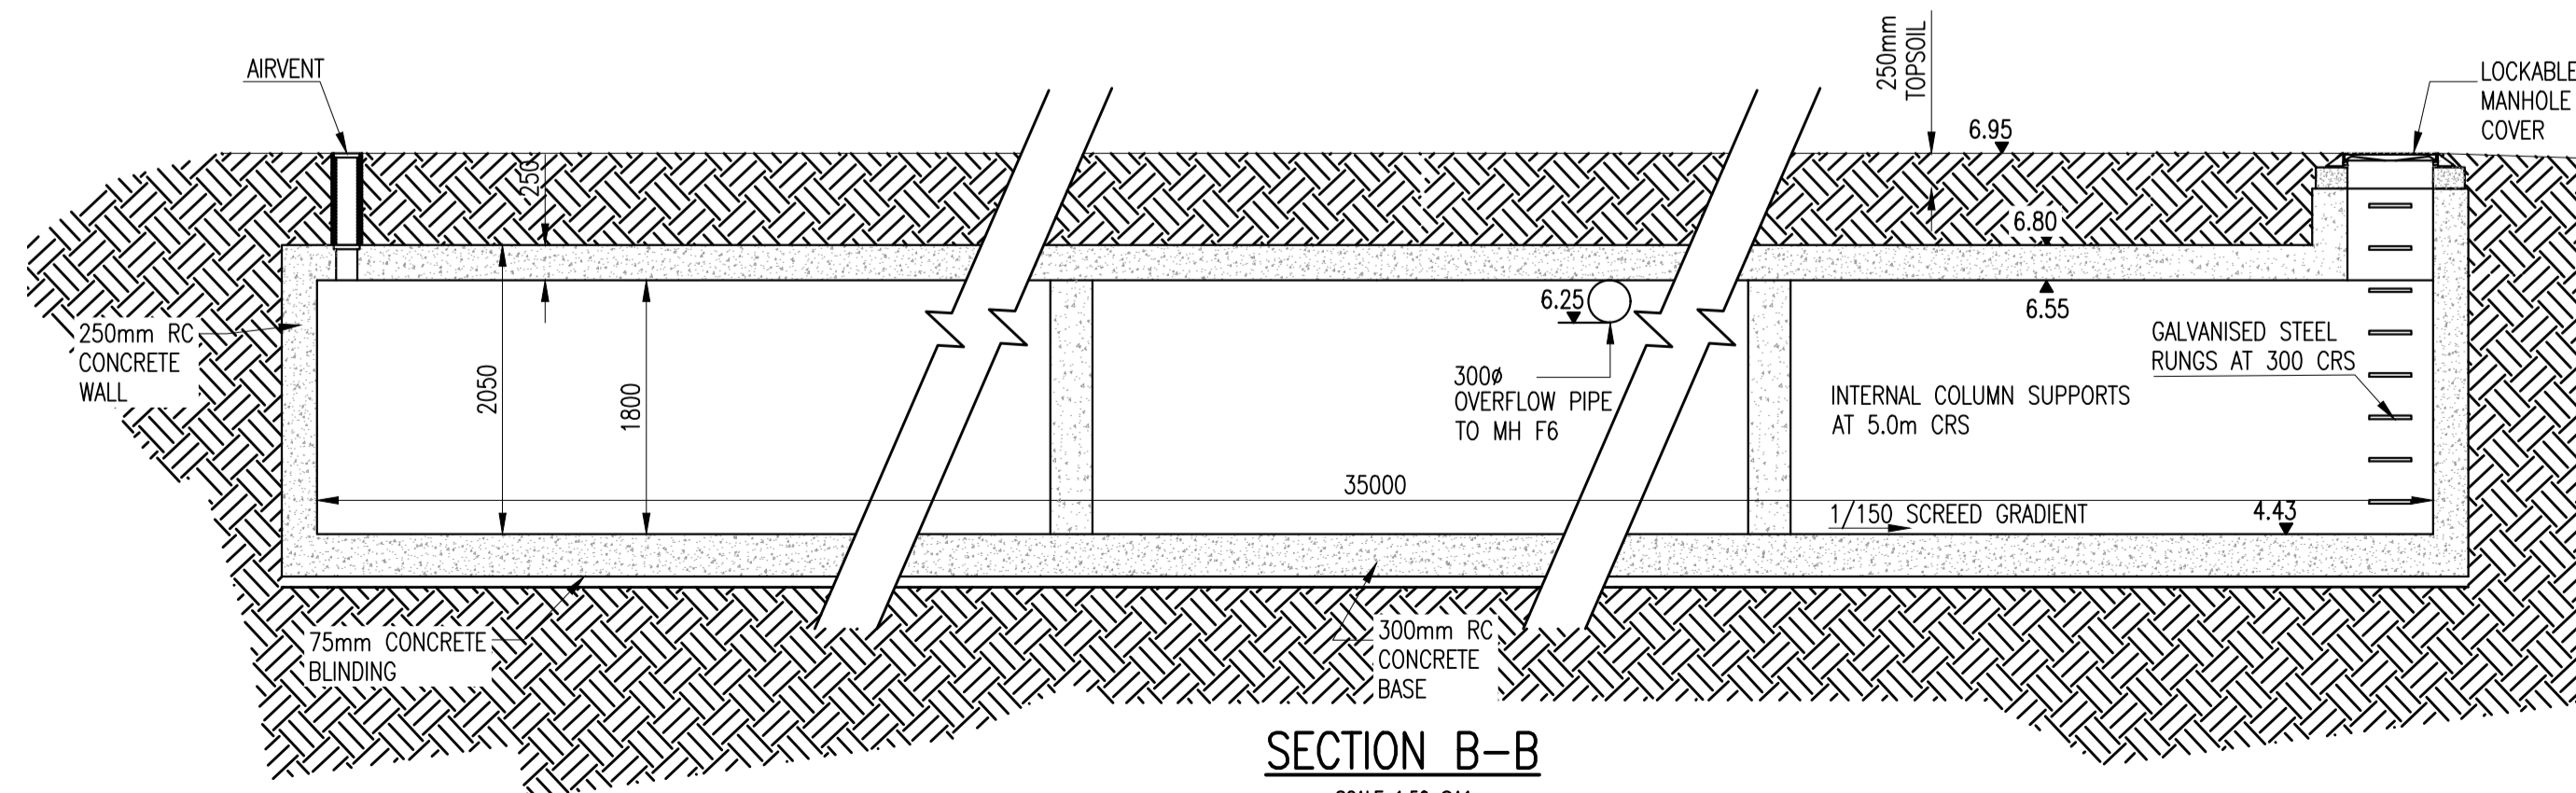

SECTION B-B
SCALE 1:50 @A1

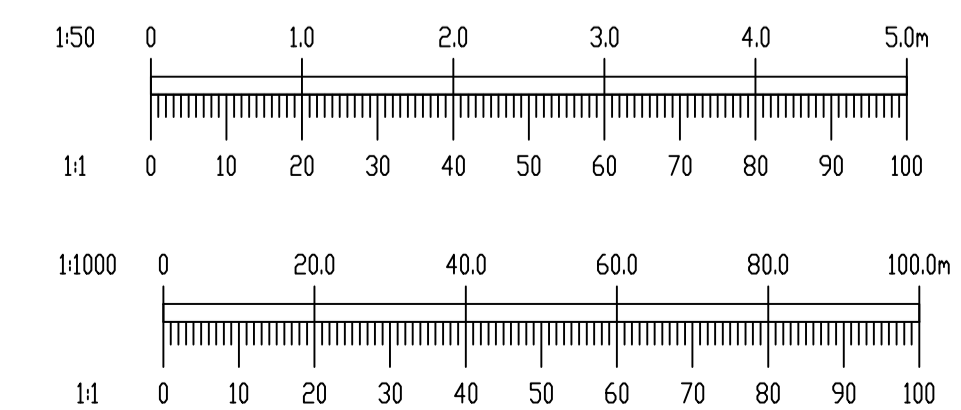

- NOTES:
- DO NOT SCALE. USE FIGURED DIMENSIONS ONLY.
 - THIS DRAWING IS TO BE READ IN CONJUNCTION WITH ALL OTHER RELEVANT ARCHITECTURAL AND ENGINEERING DRAWINGS.

16/03/22	AN BORD PLEANALA SUBMISSION	PW	EC
REV.	DATE	AMENDMENT	DRN APPD

STATUS **FOR PLANNING ONLY
NOT FOR CONSTRUCTION**

Waterman Moylan
Engineering Consultants
BLOCK 5, EASTPOINT BUSINESS PARK, ALFIE BYRNE ROAD,
DUBLIN D03 K7W7 IRELAND.
Tel: (01) 664 8900 Fax: (01) 661 3618
Email: info@waterman-moylan.ie www.waterman-moylan.ie

CLIENT **CAIRN HOMES PROPERTIES LTD.**

ARCHITECT **MCORM ARCHITECTS**

PROJECT **SHD AT HOLYBANKS,
SWORDS**

TITLE **STORMWATER STORAGE TANK DETAIL**

DRAWN MS	DESIGNED MD	APPROVED MD	DATE MARCH 2022
SCALE AS SHOWN	JOB NO. 17-088	DRG. NO. P210	REVISION -

© 2018. This drawing is copyright. No part of this document may be reproduced or transmitted in any form or stored in any retrieval system of any kind without the written permission of the consulting engineer or copyright holder except as agreed for use on the project for which the document was originally issued.