


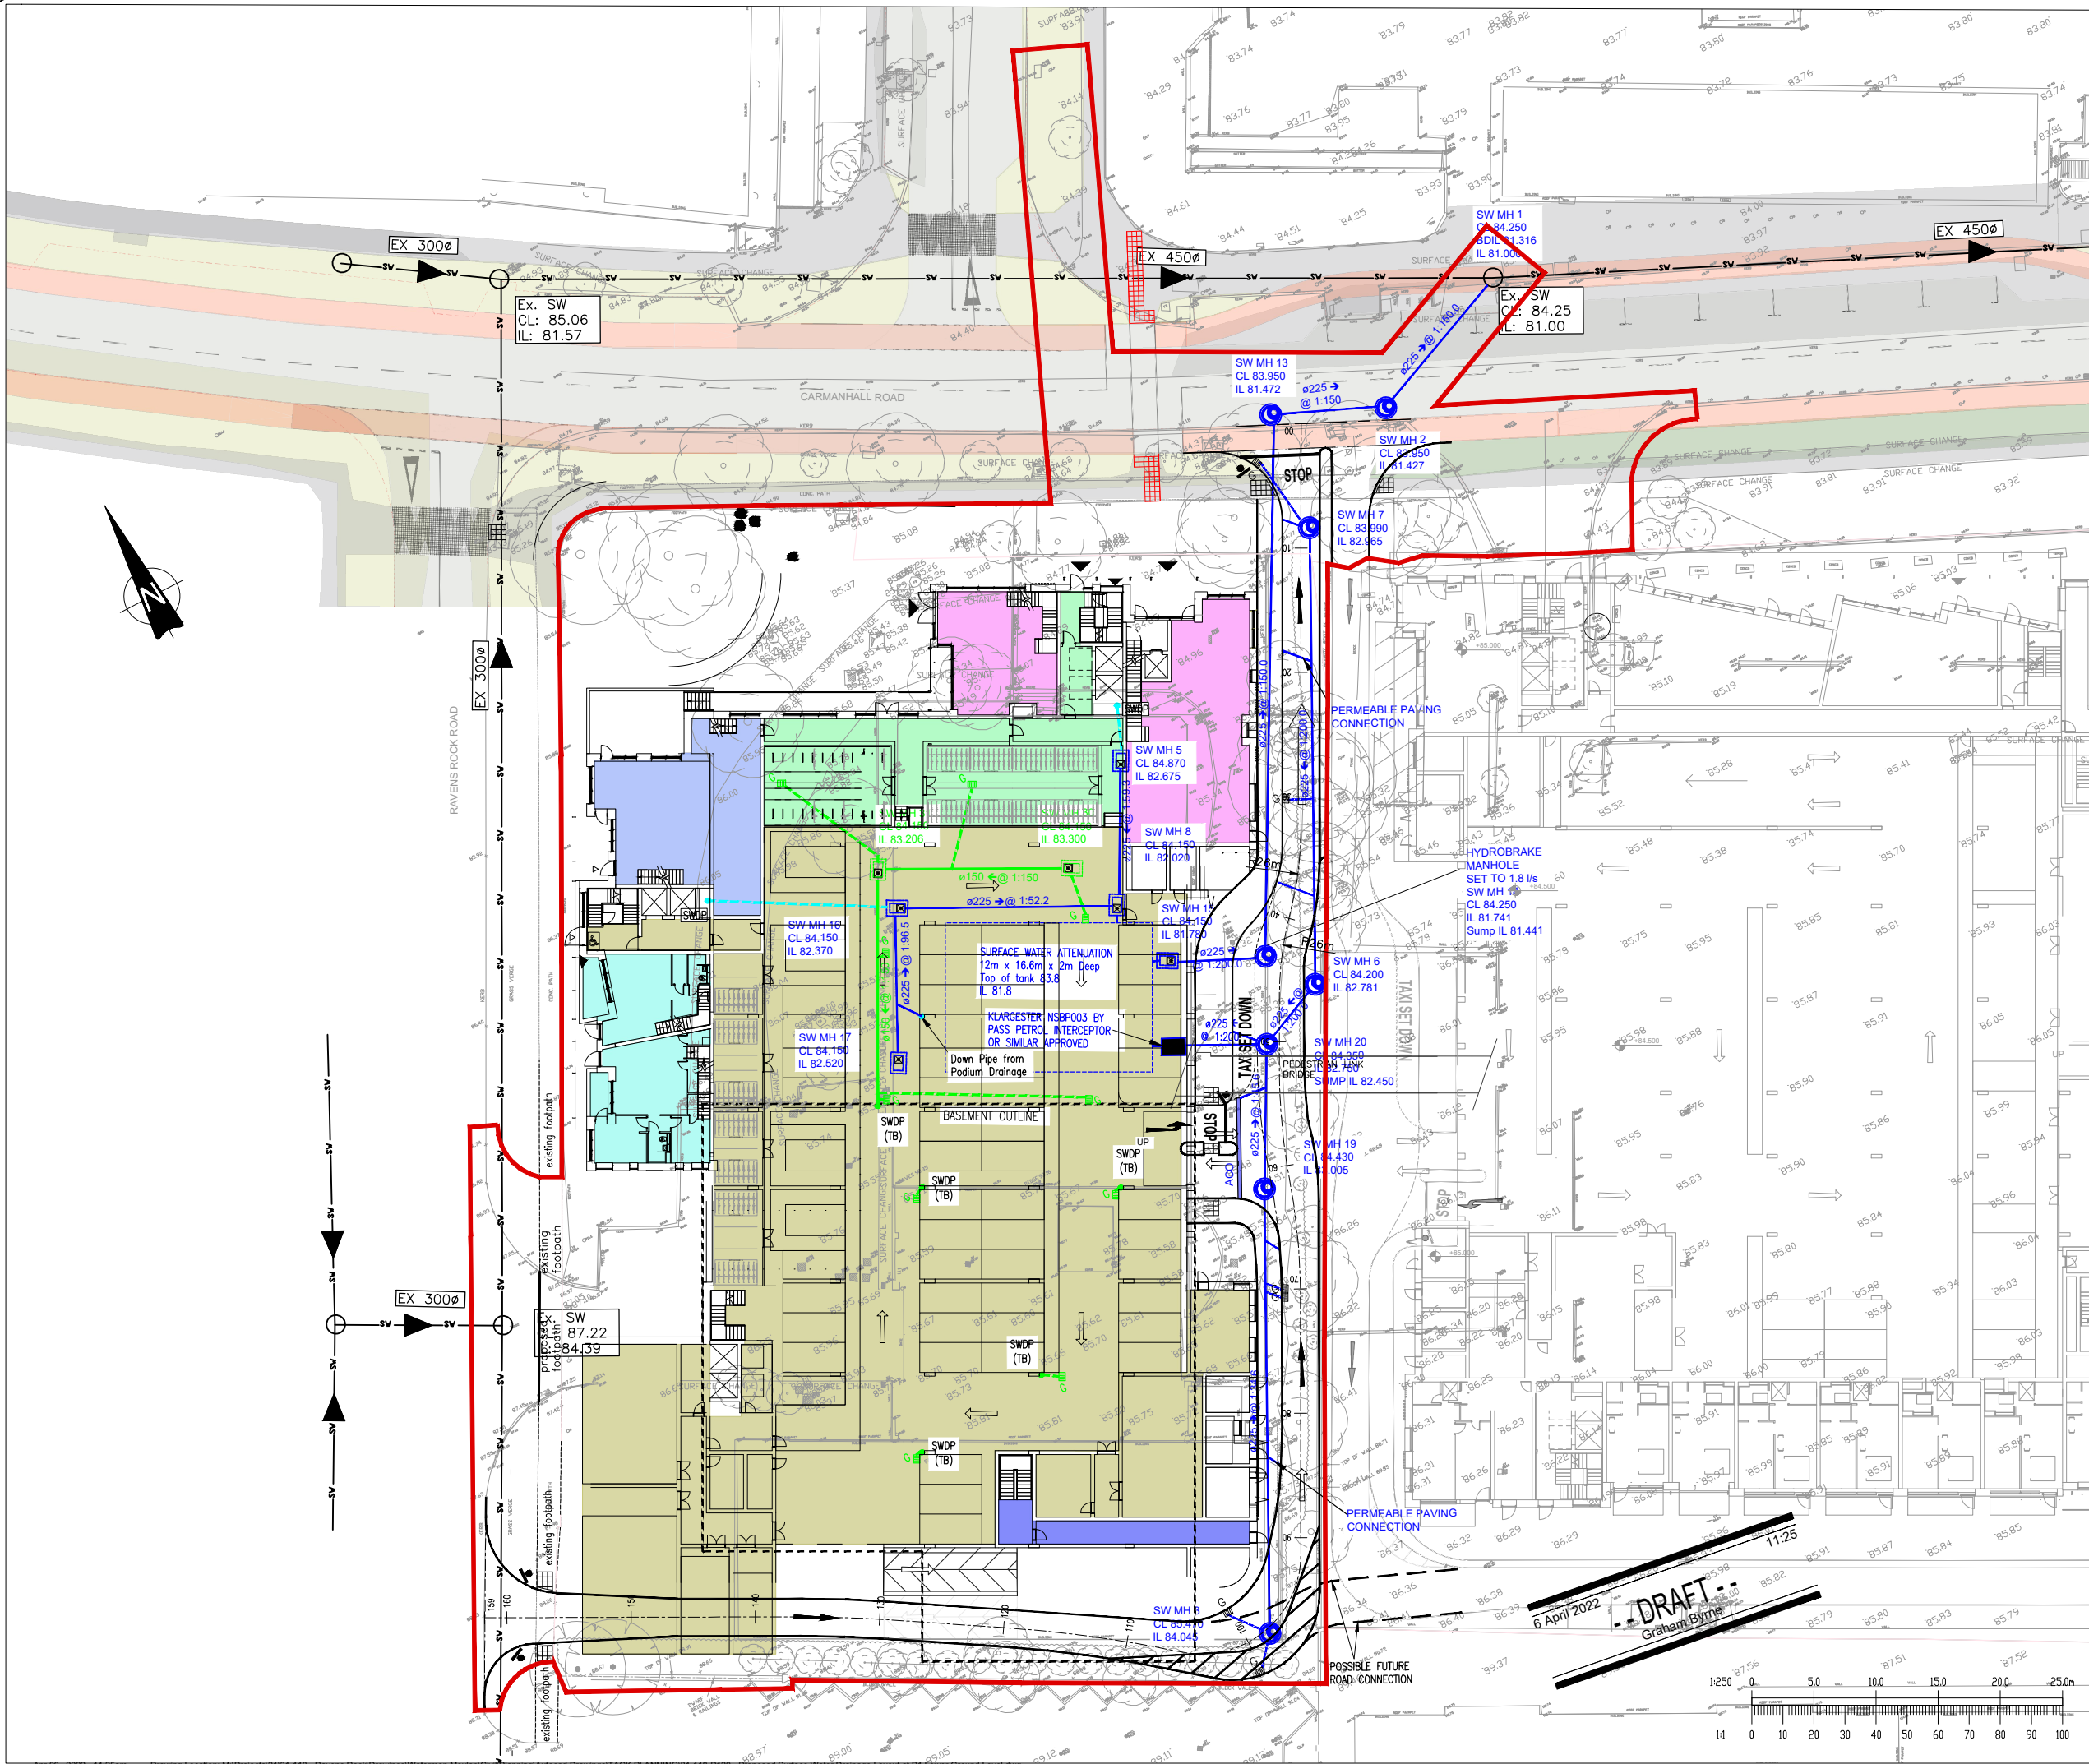

- NOTES:
- DO NOT SCALE. USE FIGURED DIMENSIONS ONLY.
 - THIS DRAWING IS TO BE READ IN CONJUNCTION WITH ALL OTHER RELEVANT ARCHITECTURAL AND ENGINEERING DRAWINGS.

LEGEND SURFACE WATER

- SW MH3
CL 84.250
IL 81.128
- 225mm @ 1:200.0
- INDICATES PROPOSED SURFACE WATER SEWER, PIPE SIZE AND GRADIENT WITH MANHOLE REFERENCE, COVER AND INVERT LEVELS
- G
- INDICATES PROPOSED ROAD GULLY AND 150mm CONNECTION
- SWDP
- PROPOSED 150mm SURFACE WATER DOWN PIPE (BY OTHERS)
- SW MH30
CL 84.100
IL 83.500
- 225mm @ 1:200.0
- INDICATES PROPOSED SURFACE WATER BASEMENT SEWER, PIPE SIZE AND GRADIENT WITH MANHOLE REFERENCE, COVER AND INVERT LEVELS
- G
- INDICATES PROPOSED ROAD GULLY (PARKING AREAS ONLY), AND 150mm CONNECTION
- SW MH30
CL 84.100
IL 83.500
- 225mm @ 1:200.0
- INDICATES PROPOSED CAR PARK BASEMENT DRAINAGE SEWER, PIPE SIZE AND GRADIENT WITH MANHOLE REFERENCE, COVER AND INVERT LEVELS
- SWDP (TB)
- INDICATES PROPOSED SURFACE WATER DOWN PIPE (TO BASEMENT)
- EX. SW
CL: 84.25
IL: 81.00
- EX 450
- INDICATES EXISTING SURFACE WATER PUBLIC SEWER, PIPE SIZE WITH MANHOLE REFERENCE, COVER AND INVERT LEVELS

- INDICATES FUTURE FOOTPATH
- INDICATES FUTURE CYCLETRACK
- INDICATES FUTURE ROAD
- INDICATES FUTURE GRASS VERGE

LEGEND: LOWER GROUND

- INDICATES LEVEL 84.15m
- INDICATES LEVEL 84.45m
- INDICATES LEVEL 84.82m
- INDICATES LEVEL 84.87m
- INDICATES LEVEL 86.125m
- INDICATES LEVEL 86.615m

REV.	DATE	AMENDMENT	DRN	APPD

STATUS **FOR PLANNING ONLY**
NOT FOR CONSTRUCTION

Waterman Moylan
Engineering Consultants

BLOCK 5, EASTPOINT BUSINESS PARK, ALFIE BYRNE ROAD,
DUBLIN D03 H3F4 IRELAND. Tel: (01) 664 8900
Email: info@waterman-moylan.ie www.waterman-moylan.ie

CLIENT **SANDYFORD ENVIRONMENTAL CONSTRUCTION LTD**

ARCHITECT **MC CAULEY DAYE O'CONNELL**

PROJECT **TACK SANDYFORD SHD**

TITLE **PROPOSED SURFACE WATER DRAINAGE LAYOUT AT B1 LOWER GROUND LEVEL**

DRAWN G.Byrne	DESIGNED BMC	APPROVED JG	DATE MAR. '22
SCALE 1:250 @A1	JOB NO. 21-118	DRG. NO. P120	REVISION

© 2017. This drawing is copyright. No part of this document may be reproduced or transmitted in any form or stored in any retrieval system of any nature without the written permission of the consulting engineer in copyright. Where noted as agreed for use on the project for which the document was originally issued.