
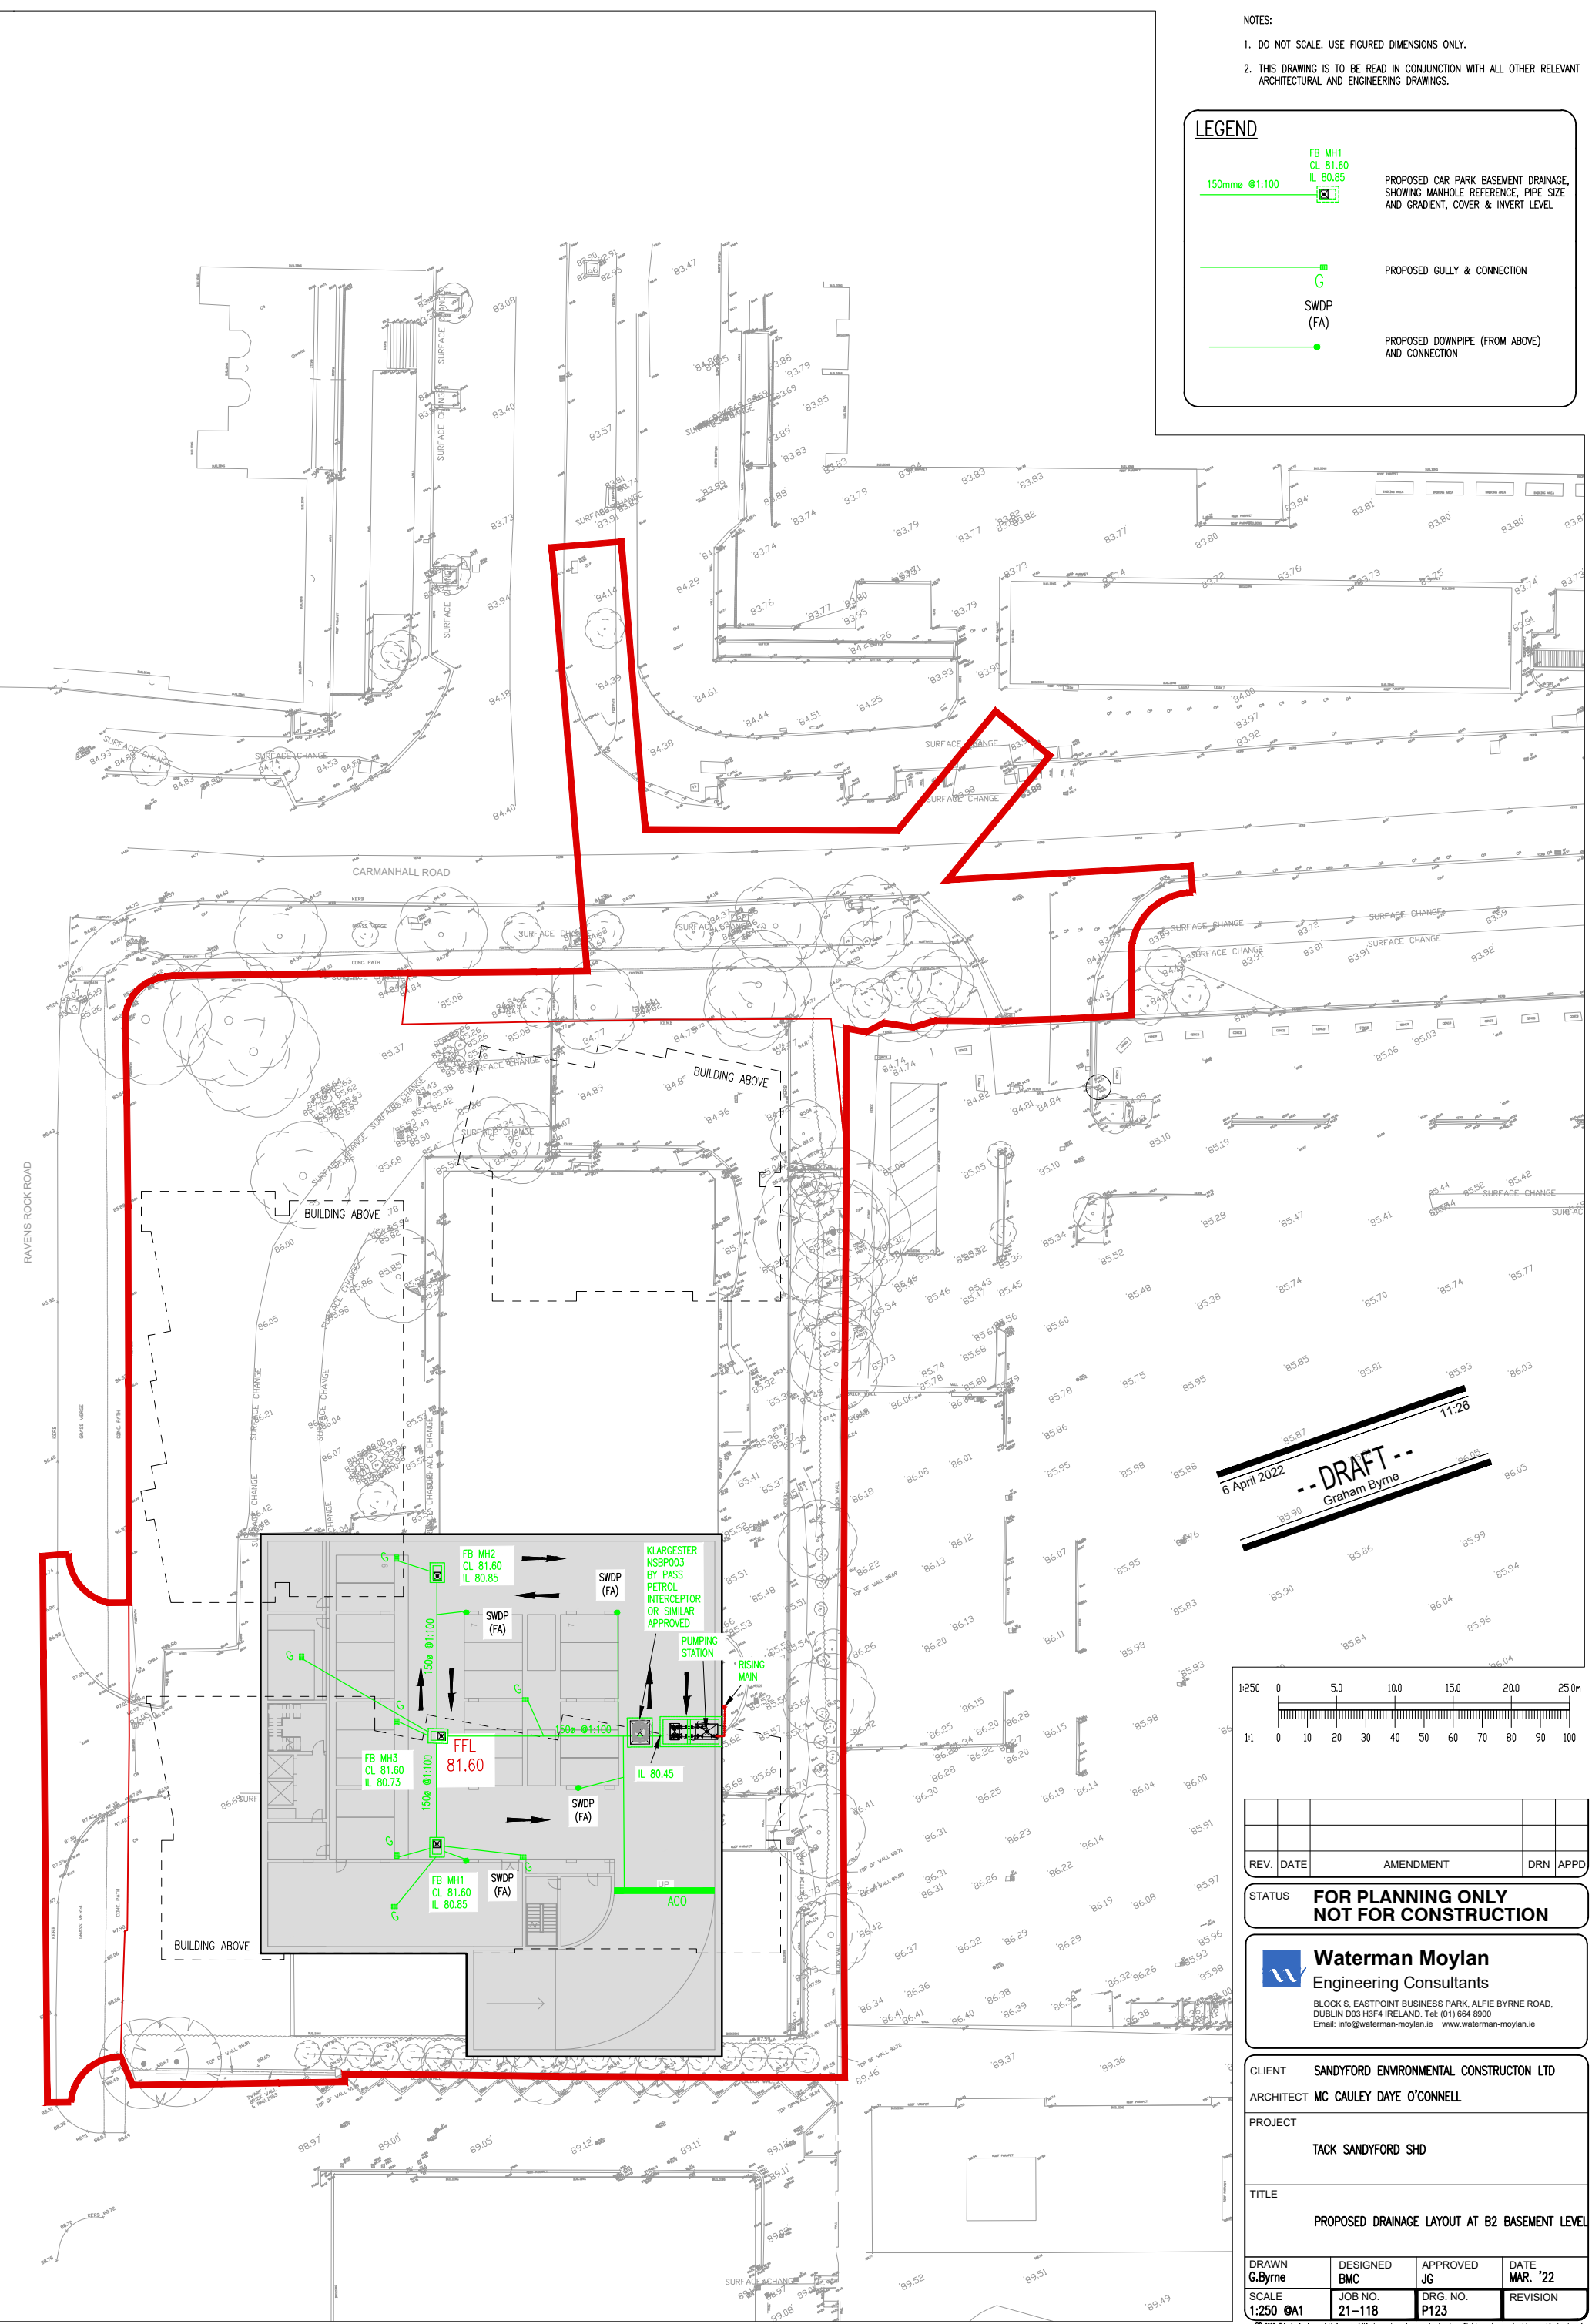



NOTES:

- DO NOT SCALE. USE FIGURED DIMENSIONS ONLY.
- THIS DRAWING IS TO BE READ IN CONJUNCTION WITH ALL OTHER RELEVANT ARCHITECTURAL AND ENGINEERING DRAWINGS.

LEGEND

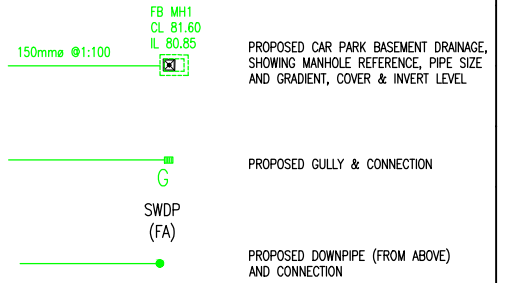

 6 April 2022
DRAFT
 Graham Byrne 11:26



REV.	DATE	AMENDMENT	DRN	APPD

STATUS **FOR PLANNING ONLY
NOT FOR CONSTRUCTION**

Waterman Moylan
 Engineering Consultants
 BLOCK 5, EASTPOINT BUSINESS PARK, ALFIE BYRNE ROAD,
 DUBLIN D03 H3F4 IRELAND. Tel: (01) 664 8900
 Email: info@waterman-moylan.ie www.waterman-moylan.ie

CLIENT	SANDYFORD ENVIRONMENTAL CONSTRUCTION LTD
ARCHITECT	MC CAULEY DAYE O'CONNELL
PROJECT	TACK SANDYFORD SHD
TITLE	PROPOSED DRAINAGE LAYOUT AT B2 BASEMENT LEVEL

DRAWN	DESIGNED	APPROVED	DATE
G.Byrne	BMC	JC	MAR. '22
SCALE	JOB NO.	DRG. NO.	REVISION
1:250 ØA1	21-118	P123	